


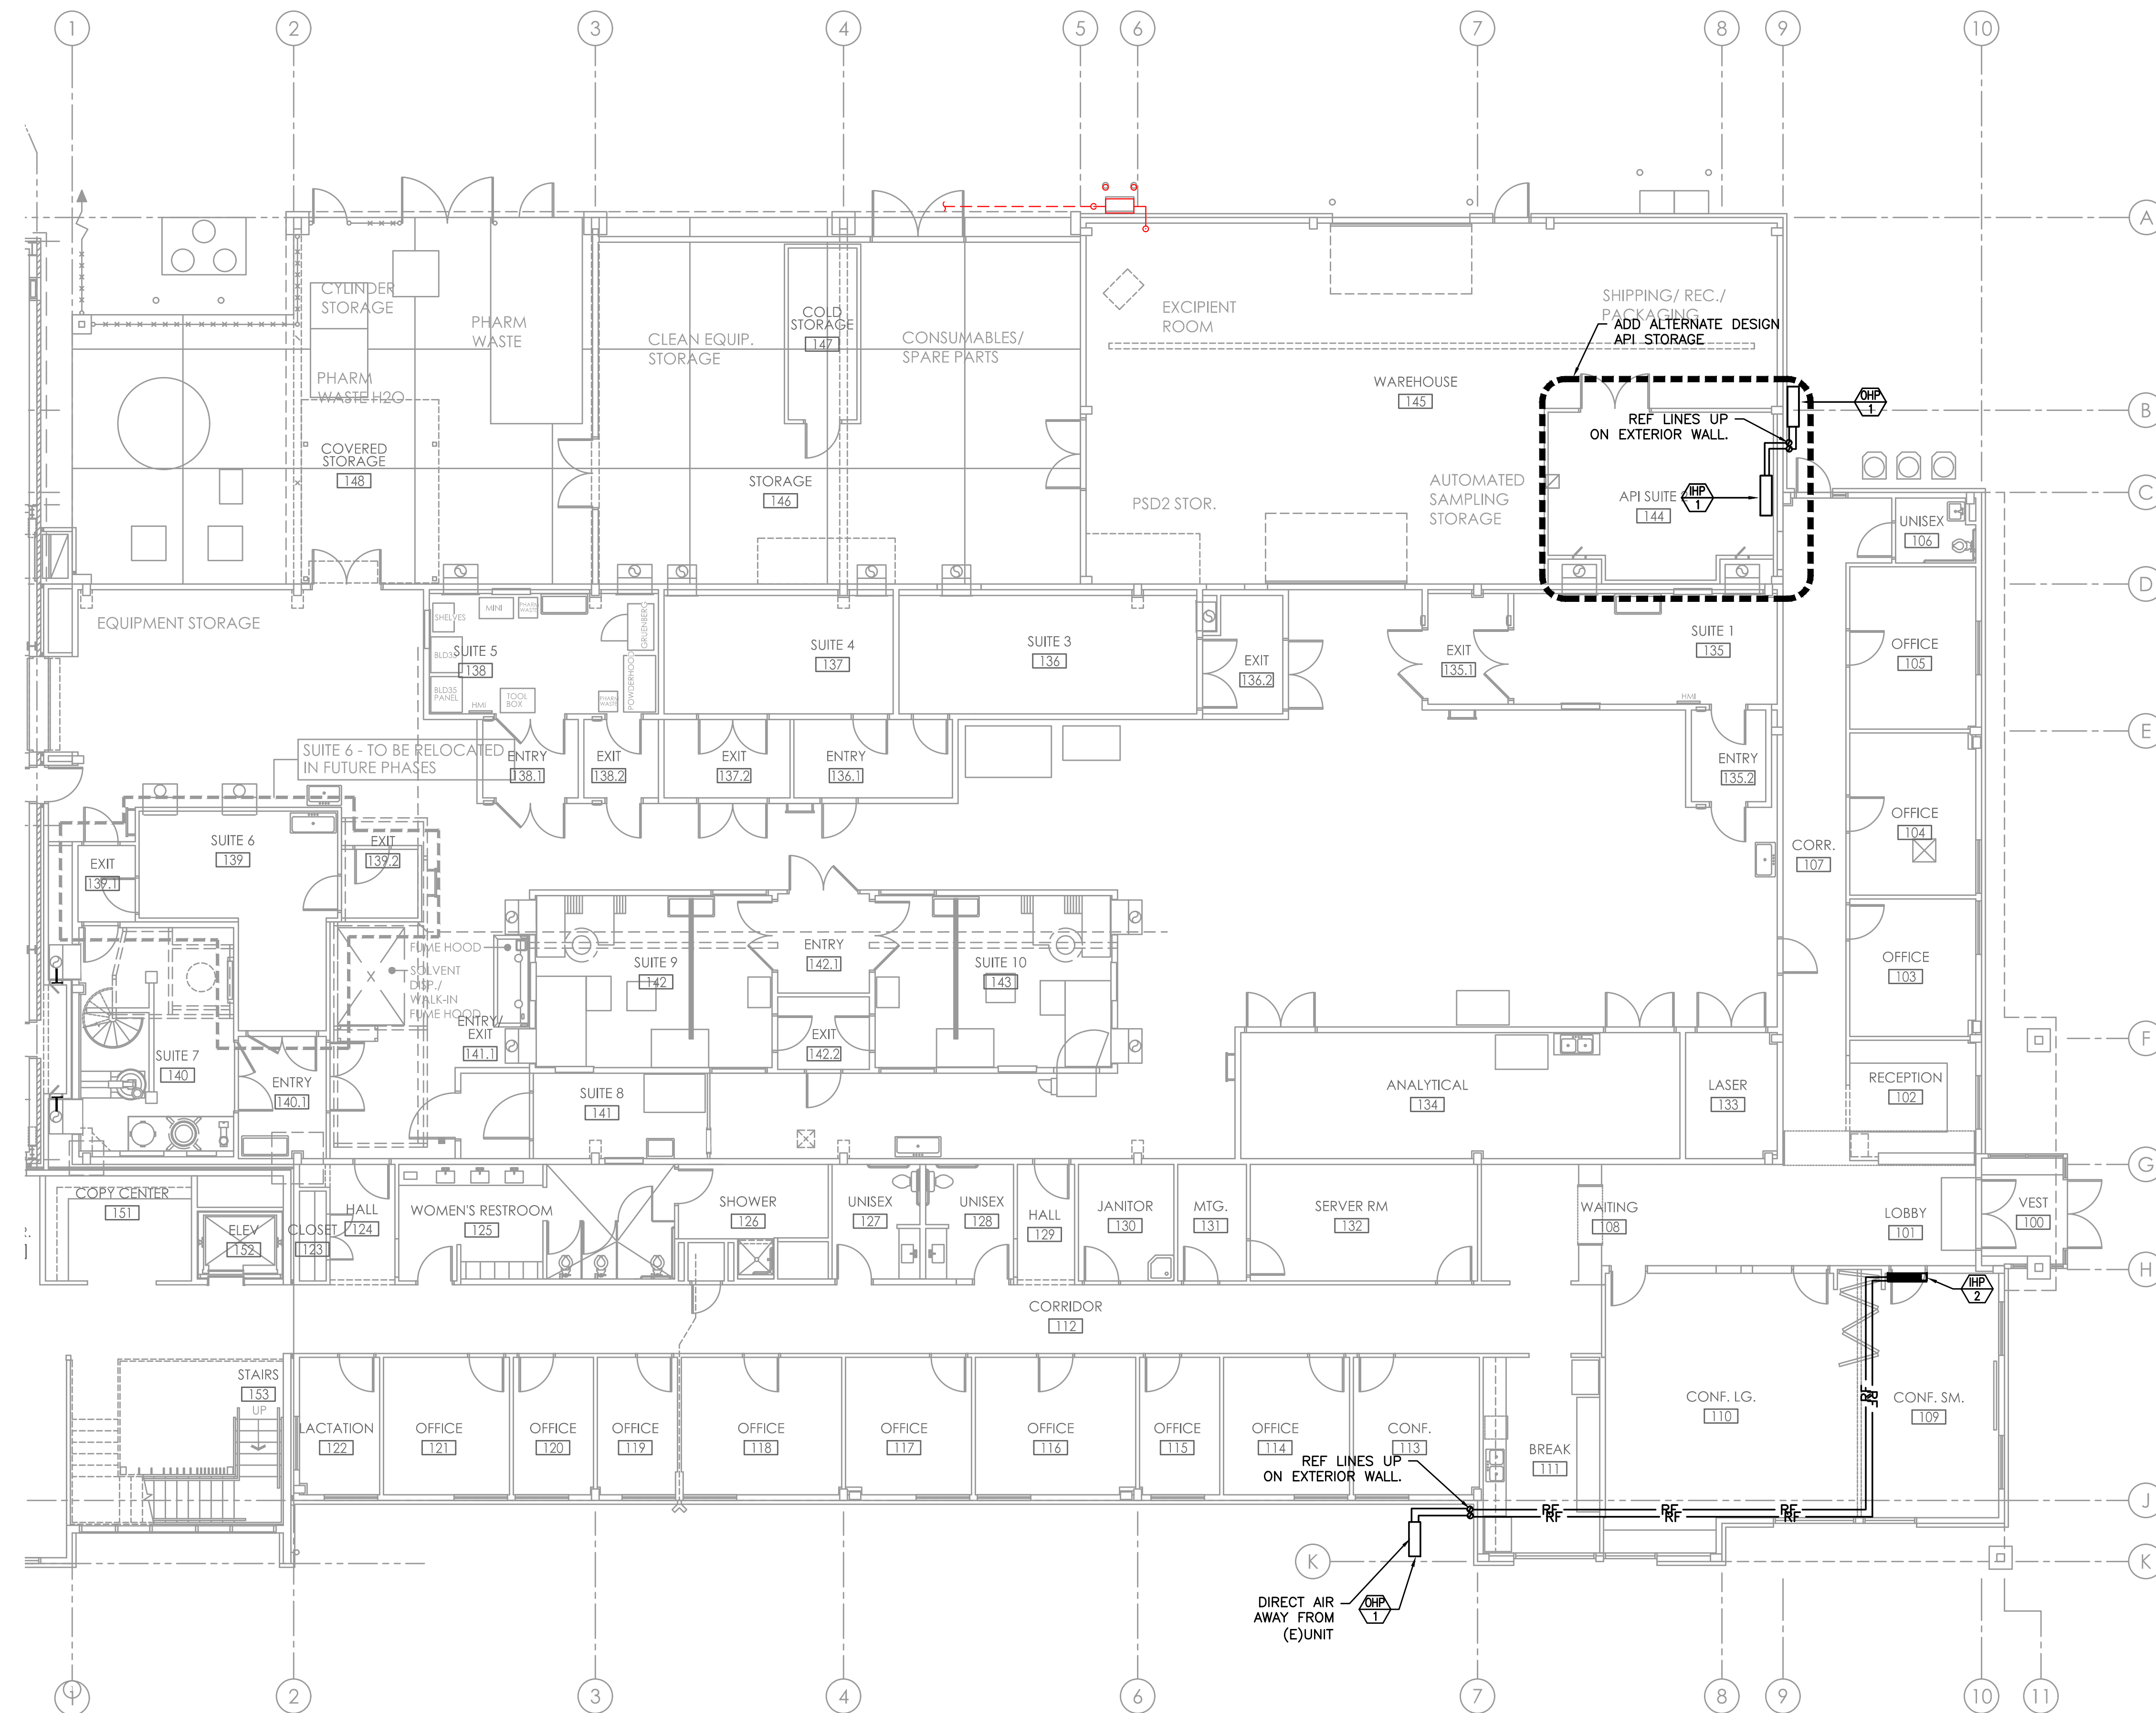

GENERAL NOTES:

1. CONTRACTOR TO COORDINATE PIPE ROUTING WITH OTHER DISCIPLINES.

KEYED NOTES:

1. FUTURE VAV BOX.
2. 3/4" HWS/HWR CAPPED WITH SHUT-OFF VALVE FOR FUTURE.
3. 1-1/4" HWS/HWR CAPPED WITH SHUT-OFF VALVE FOR FUTURE.
4. CONNECT (N)3/4" HWS/HWR TO (E) MAINS.
5. 7/8" SERIES BALANCE VALVE. SEE PIPING SCHEMATIC ON SHEET MP3.0 FOR GPM SETTING.
6. 7/8" SERIES 794 DIFFERENTIAL PRESSURE CONTROLLER.

KEYED NOTES:

1. FUTURE VAB BOX.
2. 3/4" HWS/HWR CAPPED WITH SHUT-OFF VALVE FOR FUTURE.
3. 1-1/4" HWS/HWR CAPPED WITH SHUT-OFF VALVE FOR FUTURE.
4. CONNECT (N)3/4" HWS/HWR TO (E) MAINS.
5. T/A SERIES BALANCE VALVE. SEE PIPING SCHEMATIC ON SHEET MP3.0 FOR GPM SETTING.
6. T/A SERIES 794 DIFFERENTIAL PRESSURE CONTROLLER.

 1 MECHANICAL FIRST FLOOR PLAN – EXISTING BUILDING
M2.1B 1/8"=1'-0"

DRAWN/ CHECKED: TB

ISSUES / REVISIONS:

**MECH PIPING FIRST FLOOR
PLAN - EXISTING BUILDING**