
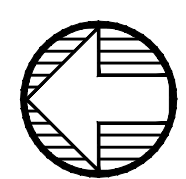


PLAN REVIEW APPROVAL STAMP

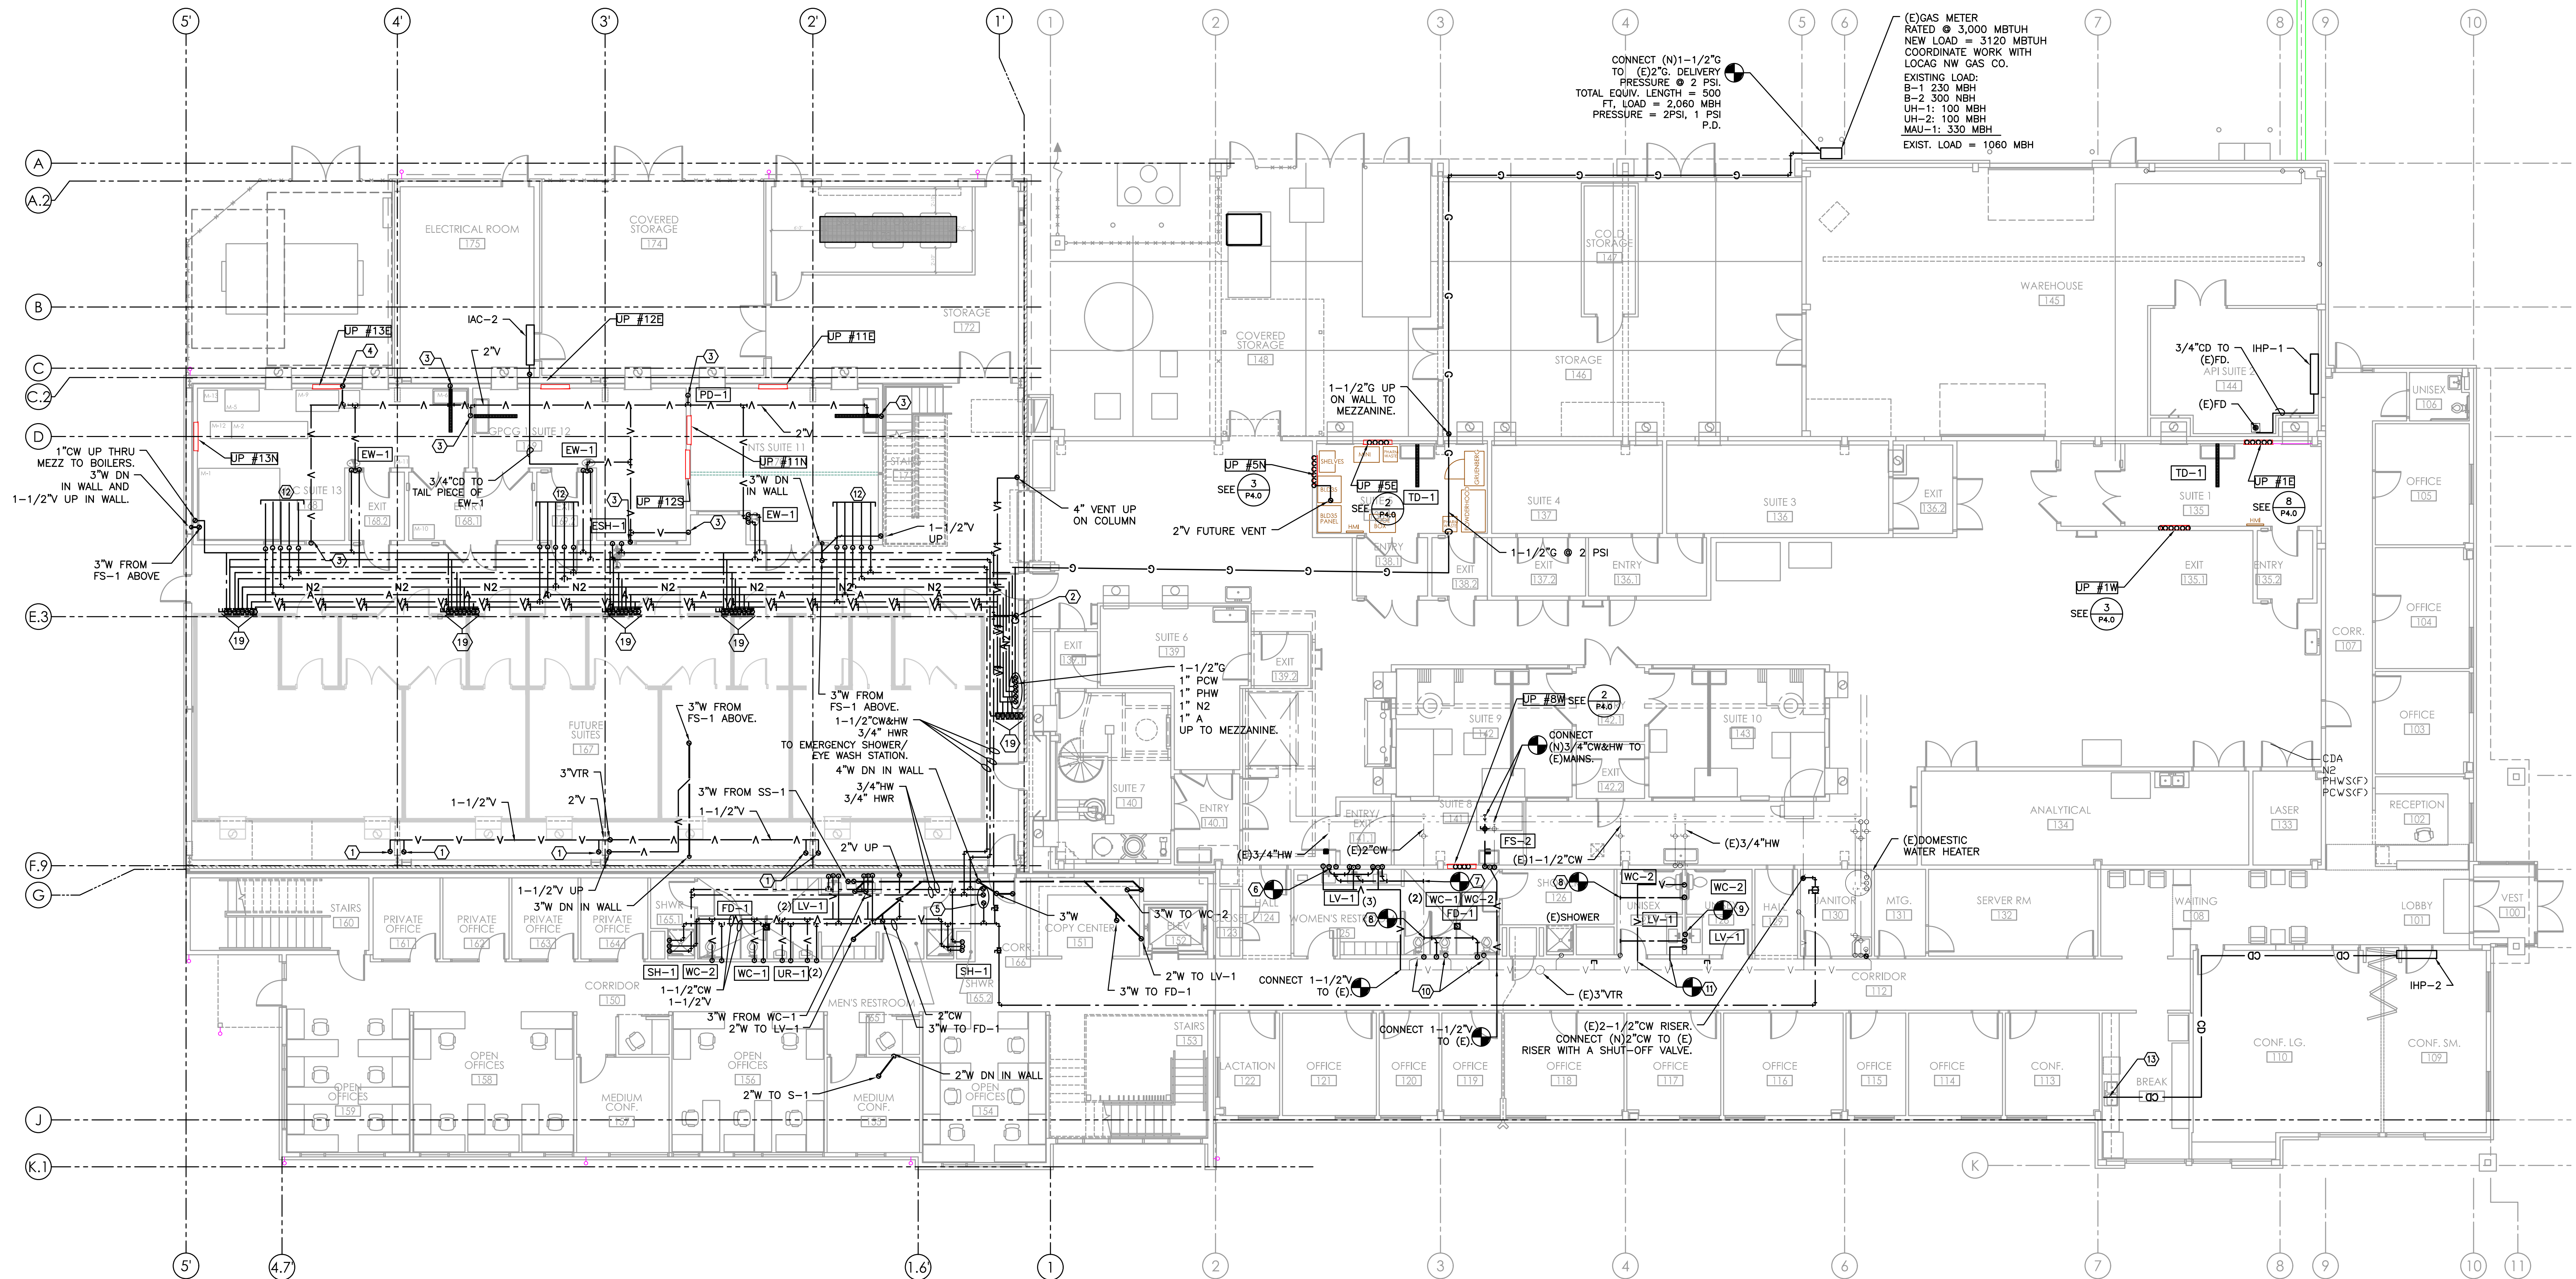

1 FIRST FLOOR PLUMBING PLAN
P2.0 1/8"=1'-0"

KEYED NOTES:

1. PROVIDE 1-1/2"V TO 3'-0" A.F.F. FOR FUTURE CONNECTION TO TRENCH DRAINS (TD-1) AND DETAILS.
2. CW ON ON WALL TRAP PRIMER MANIFOLD. MOUNT LOW ON WALL.
3. 1-1/2"V FROM BELOW.
4. 2"V UP.
5. 1-1/2"CW, 1-1/2"HW, AND 3/4"HW UP.
6. CONNECT (N)3/4"HW TO EXISTING AND FEED (3)JAV'S.
7. CONNECT (N)3/4"CW TO EXISTING AND FEED (3)JAV'S.
8. CONNECT (N)1-1/2"CW TO (E).
9. CONNECT (N)3/4"HW TO (E) AND CONNECT TO (2)JAV'S.
10. MODIFY (E)VENT PIPING AND CONNECT TO NEW FIXTURES.
11. EXTEND (E)VENT AND CONNECT TO NEW FIXTURES.
12. SEE SUITE DETAIL ON SHEET P4.0 FOR CONTINUATION.
13. CONNECT 3/4" CD TO TAIL PIECE OF (E) SINK.
14. MODIFY (E)PIPING TO SUITE 1 AND RE-ROUTE IN NEW WALL TO NEW UTILITY PANEL.
15. 3/4" POW&PHW, 1/2" N2, 1/2"A AND 2" SV DN THRU MEZZANINE FLOOR TO NEW UTILITY PANEL IN SUITE 1.
16. CONNECT (N)3/4"POW&PHW, 1/2"N2, 1/2"A AND 2"SV TO (E) BRANCHES.
17. 3/4" POW&PHW, 1/2" N2, 1/2" A DN IN WALL TO NEW UTILITY PANEL IN SUITE 5.
18. 2" FUTURE VENT FROM UTILITY PANEL BELOW. TERMINATE 3" ABOVE FINISHED FLOOR WITH SANITARY FITTING.
19. STUB-OUT FOR FUTURE SUITE. SEE SHEET P4.0 FOR DETAILS.

GENERAL NOTES:

1. SEE P4.0 FOR PROCESS PIPING SIZING, LAYOUT AND DETAILS.
2. SEE (1) P6.2 FOR SEISMIC PIPE SUPPORT.
3. SEE (6) P6.1 FOR NON-SEISMIC PIPE SUPPORT.
4. UP-#XX
E, W, N, OR S EXPOSURE
SUITE #
5. SEE (2) P6.2 CW & HW PIPING DIAGRAM FOR VALVE LOCATIONS AND BRANCH PIPE SIZES.

BEND RESEARCH, INC
CORPORATE PLACE FACILITY - BUILDING EXPANSION NORTH



BLAISE CACCIOLA
ARCHITECT
1465 SW Knoll Avenue, Suite 250
Bend, OR 97702
Phone: 541.728.0375
www.BCA-Architect.com

DRAWN / CHECKED: TB

ISSUES / REVISIONS:

FIRST FLOOR
PLUMBING PLAN

P2.0