

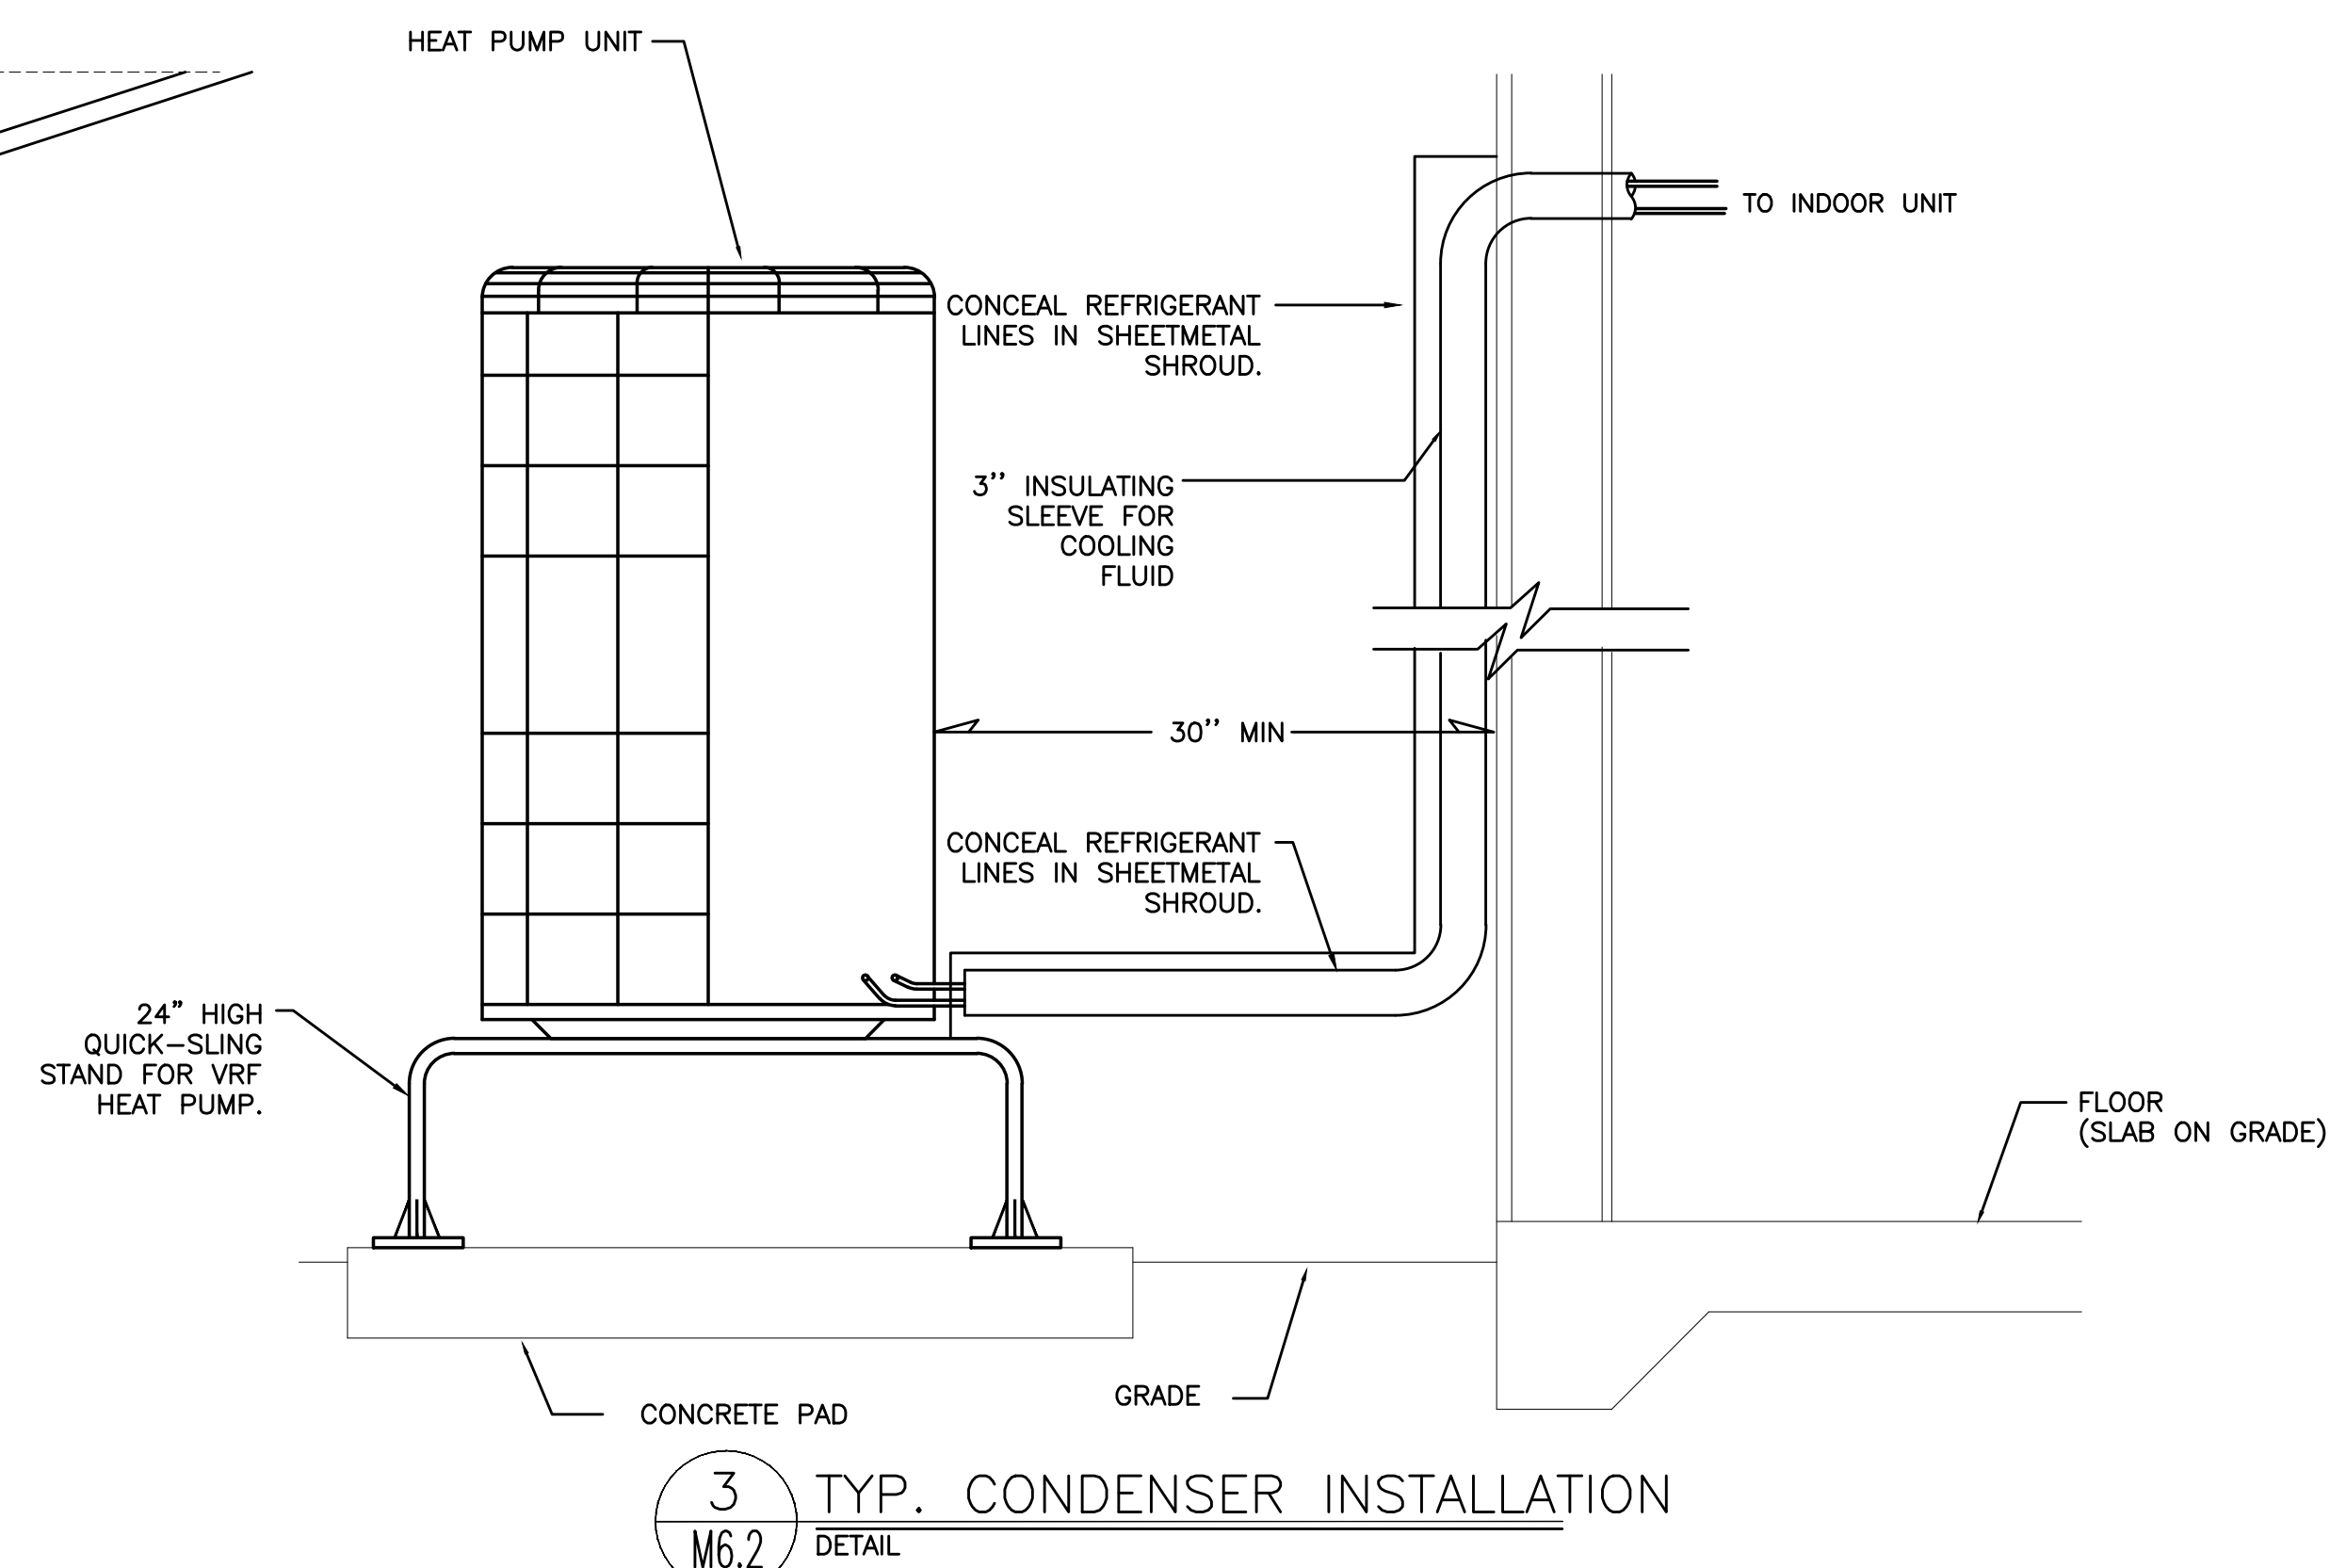
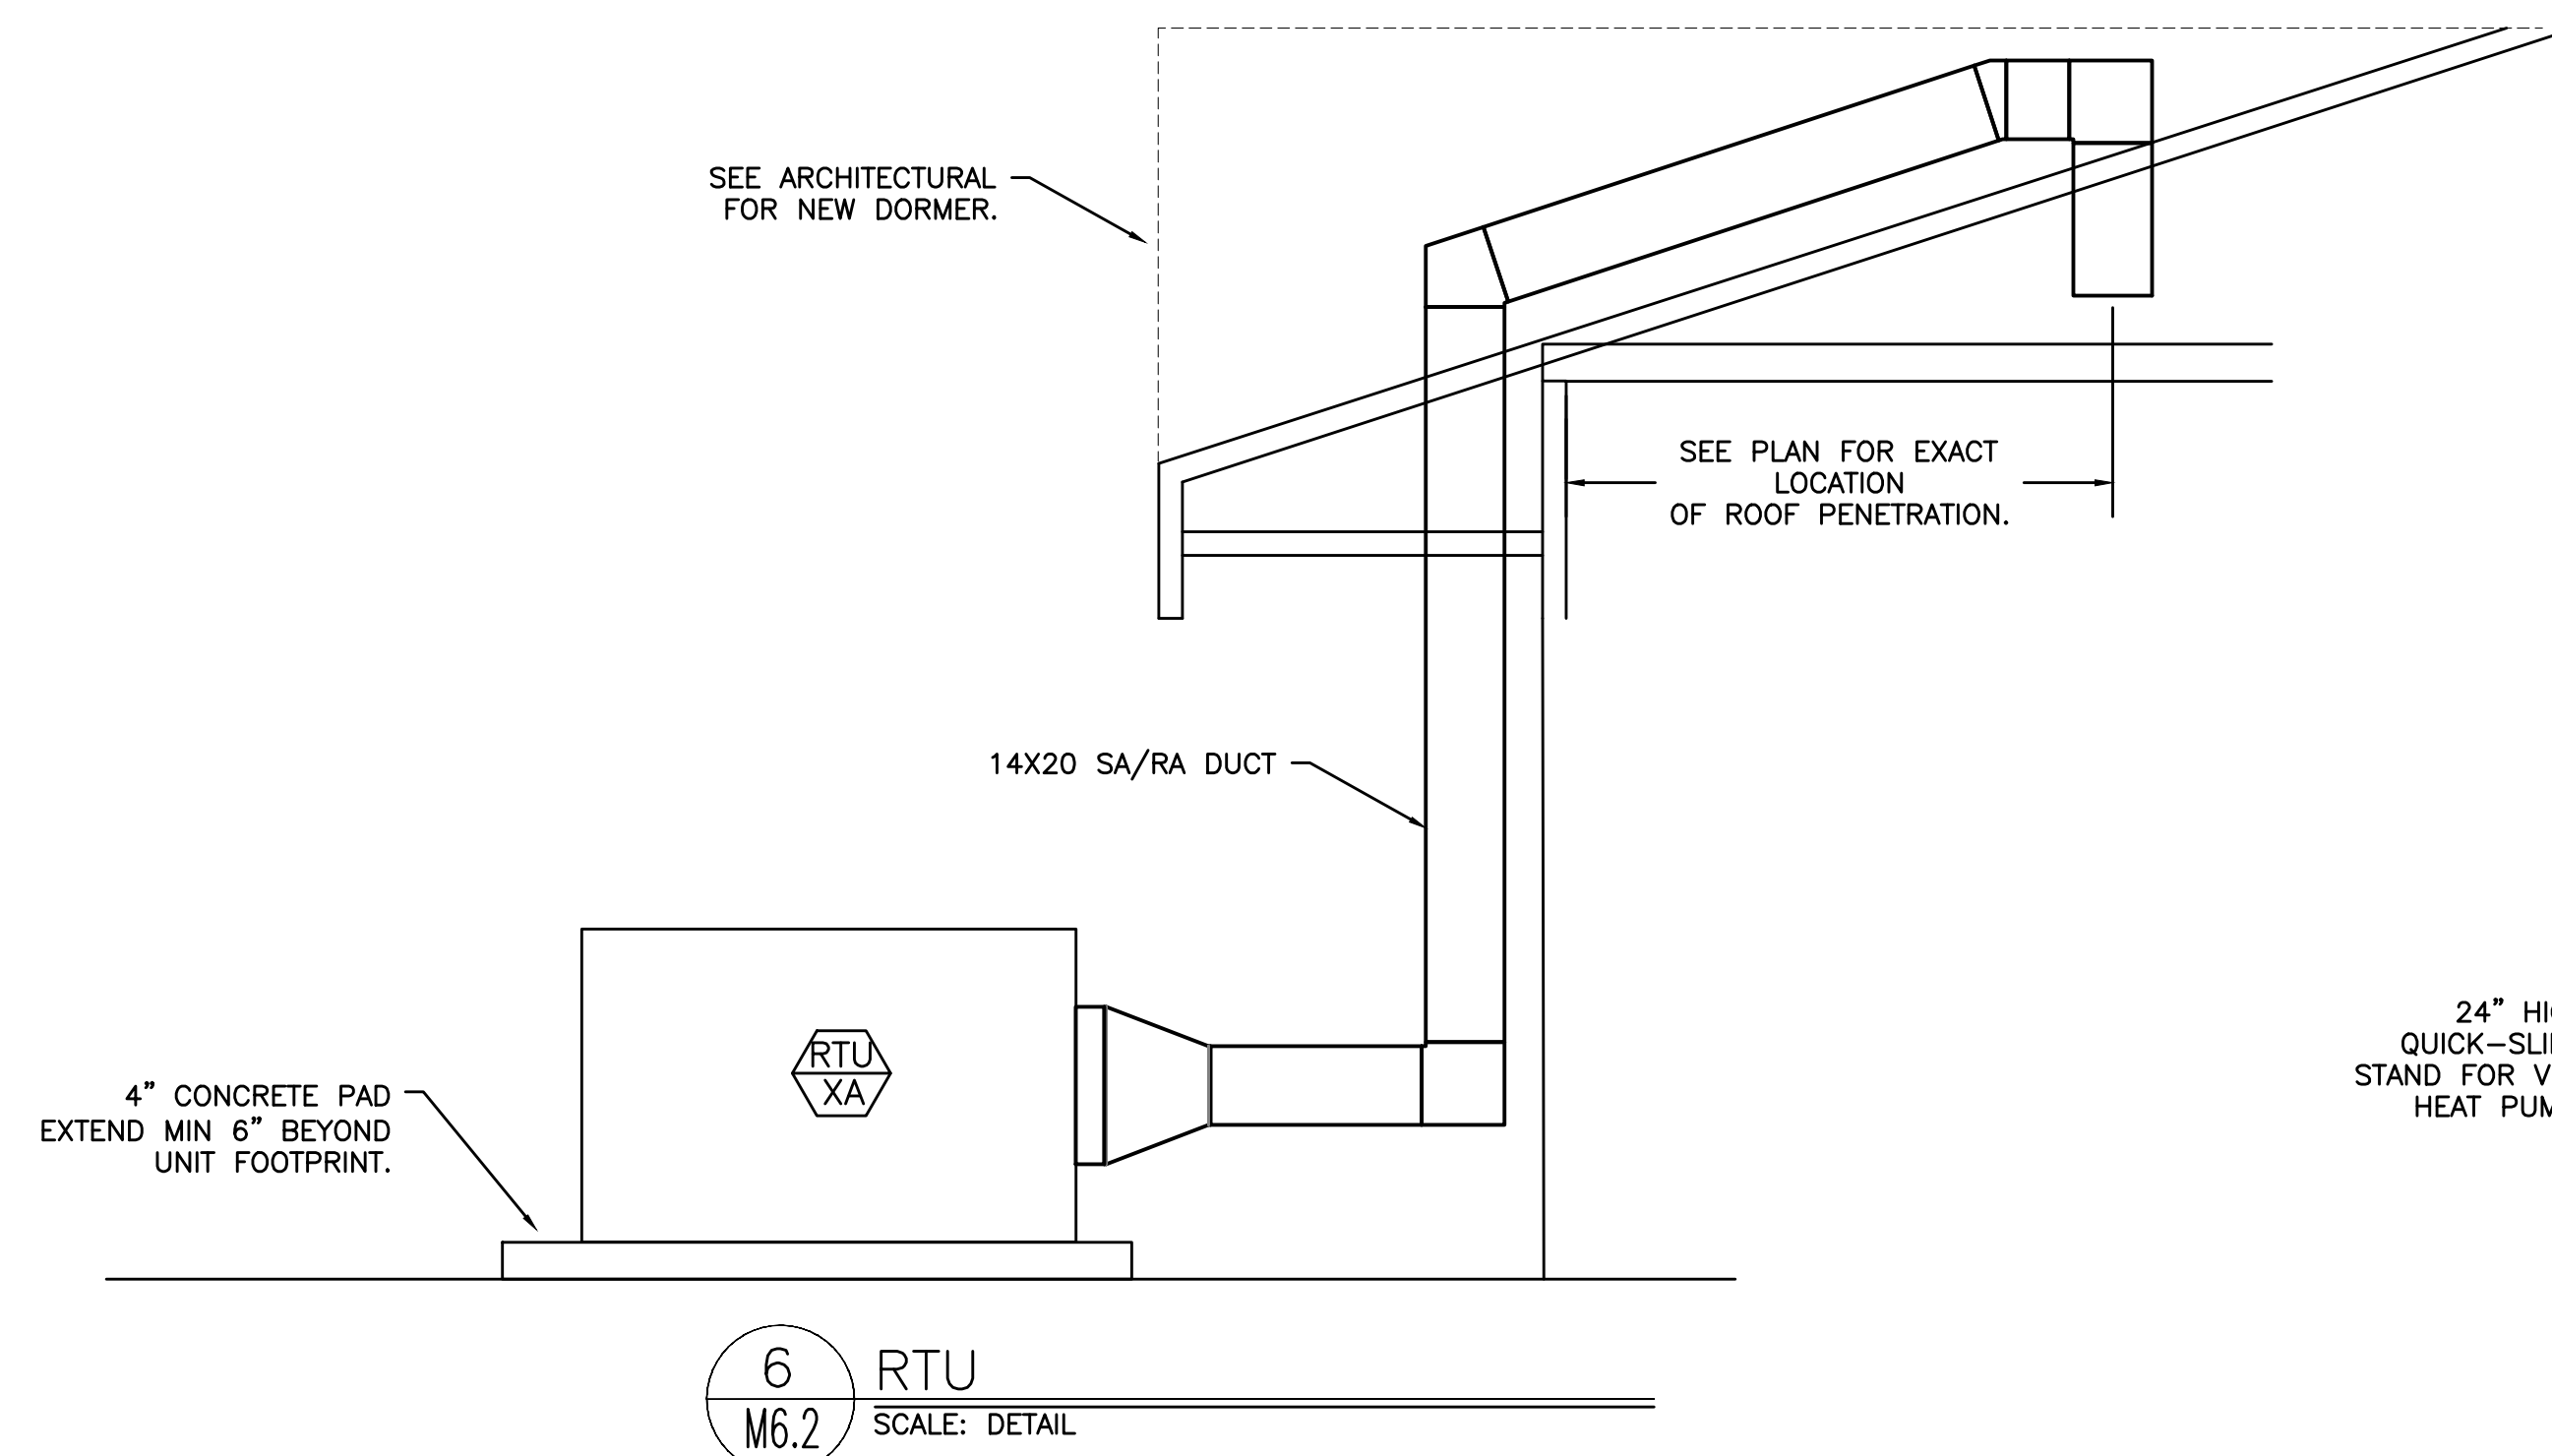
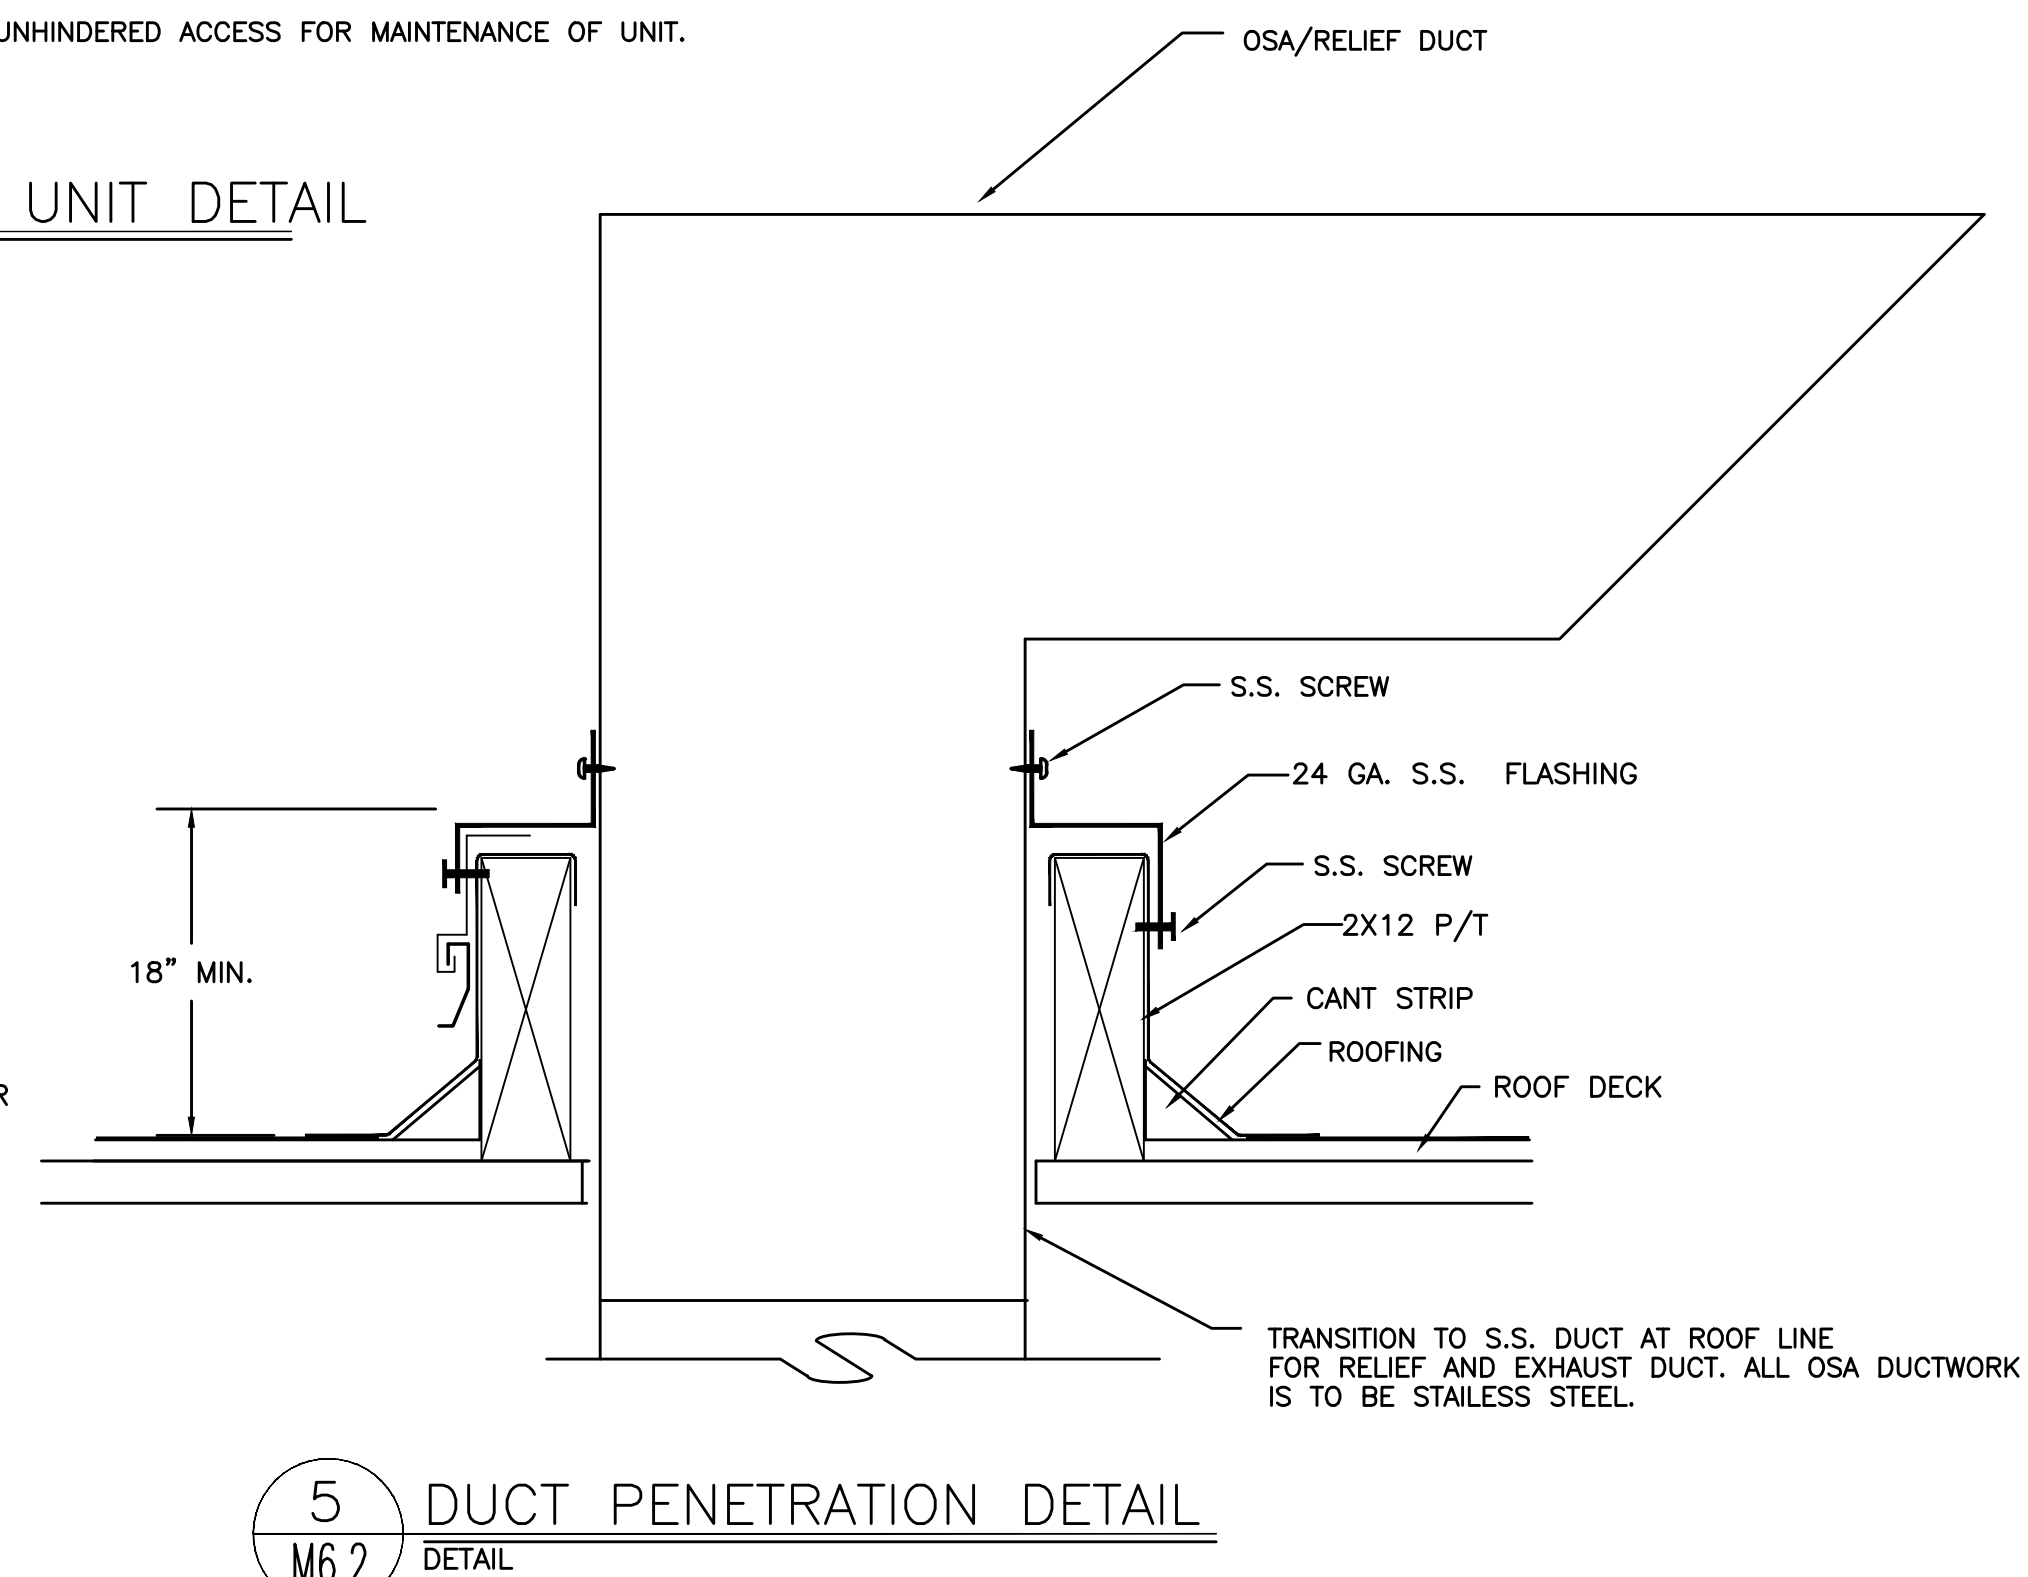
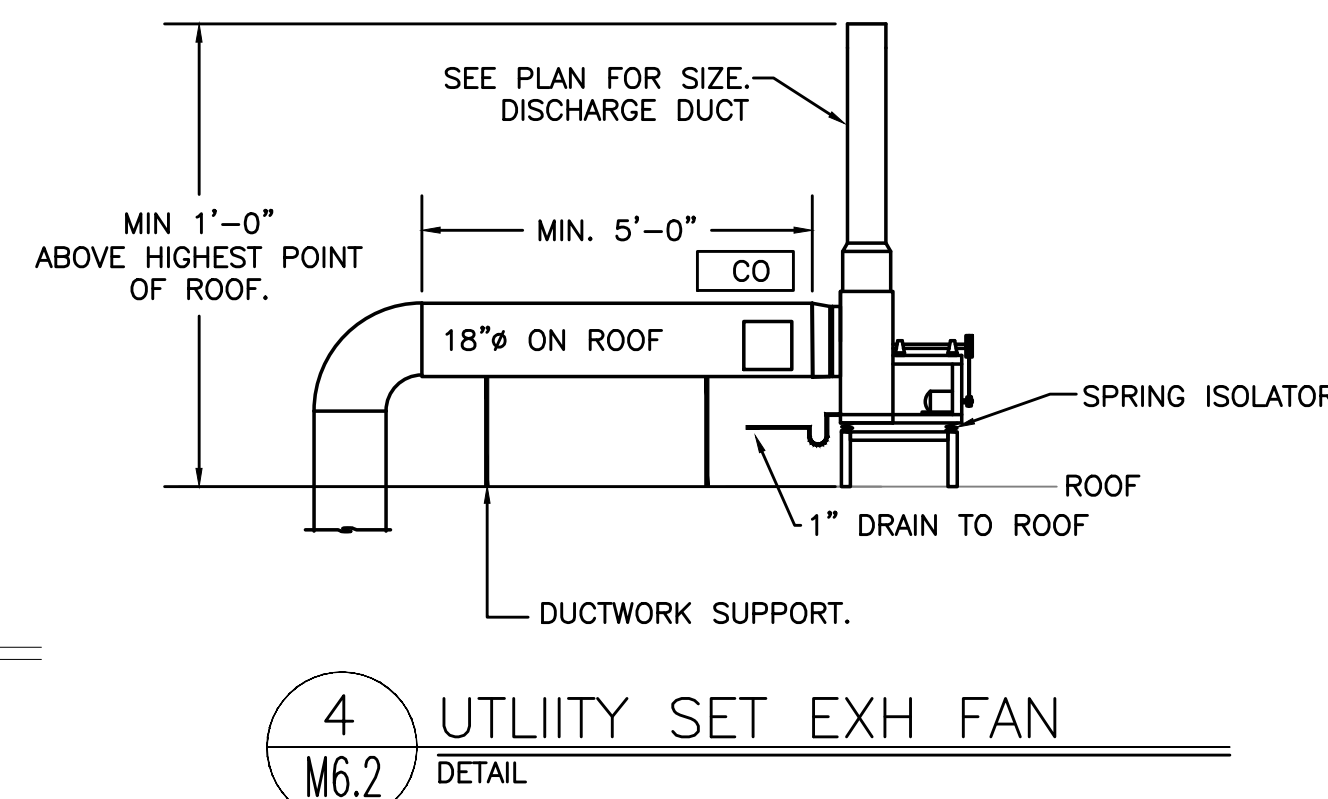
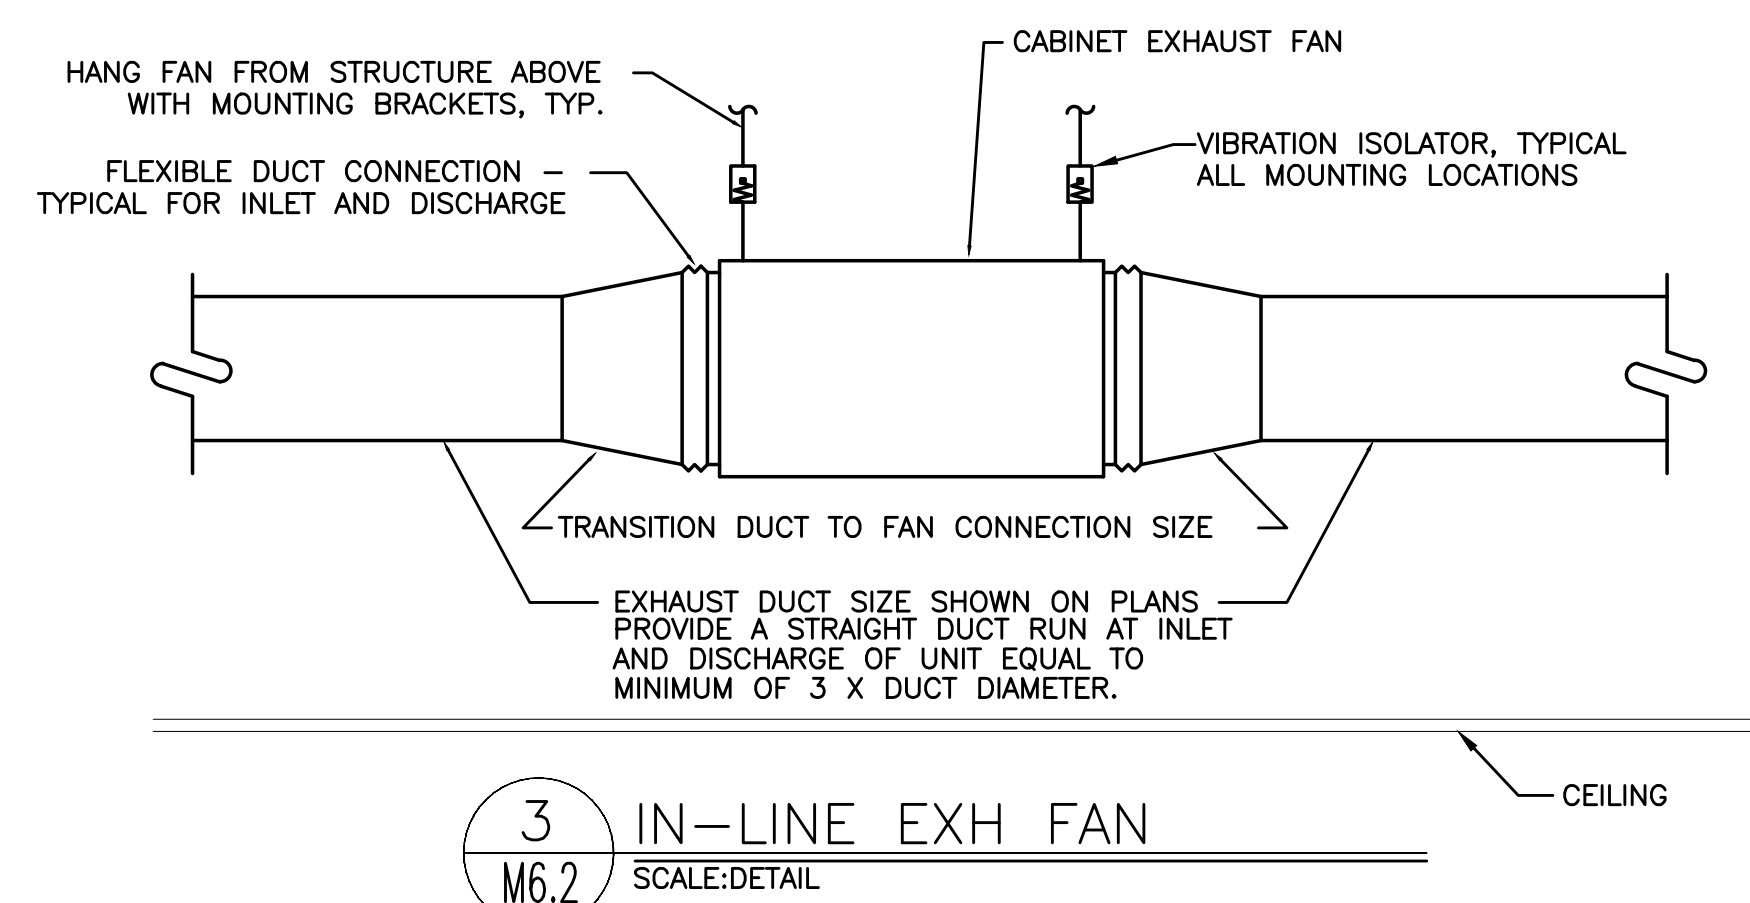


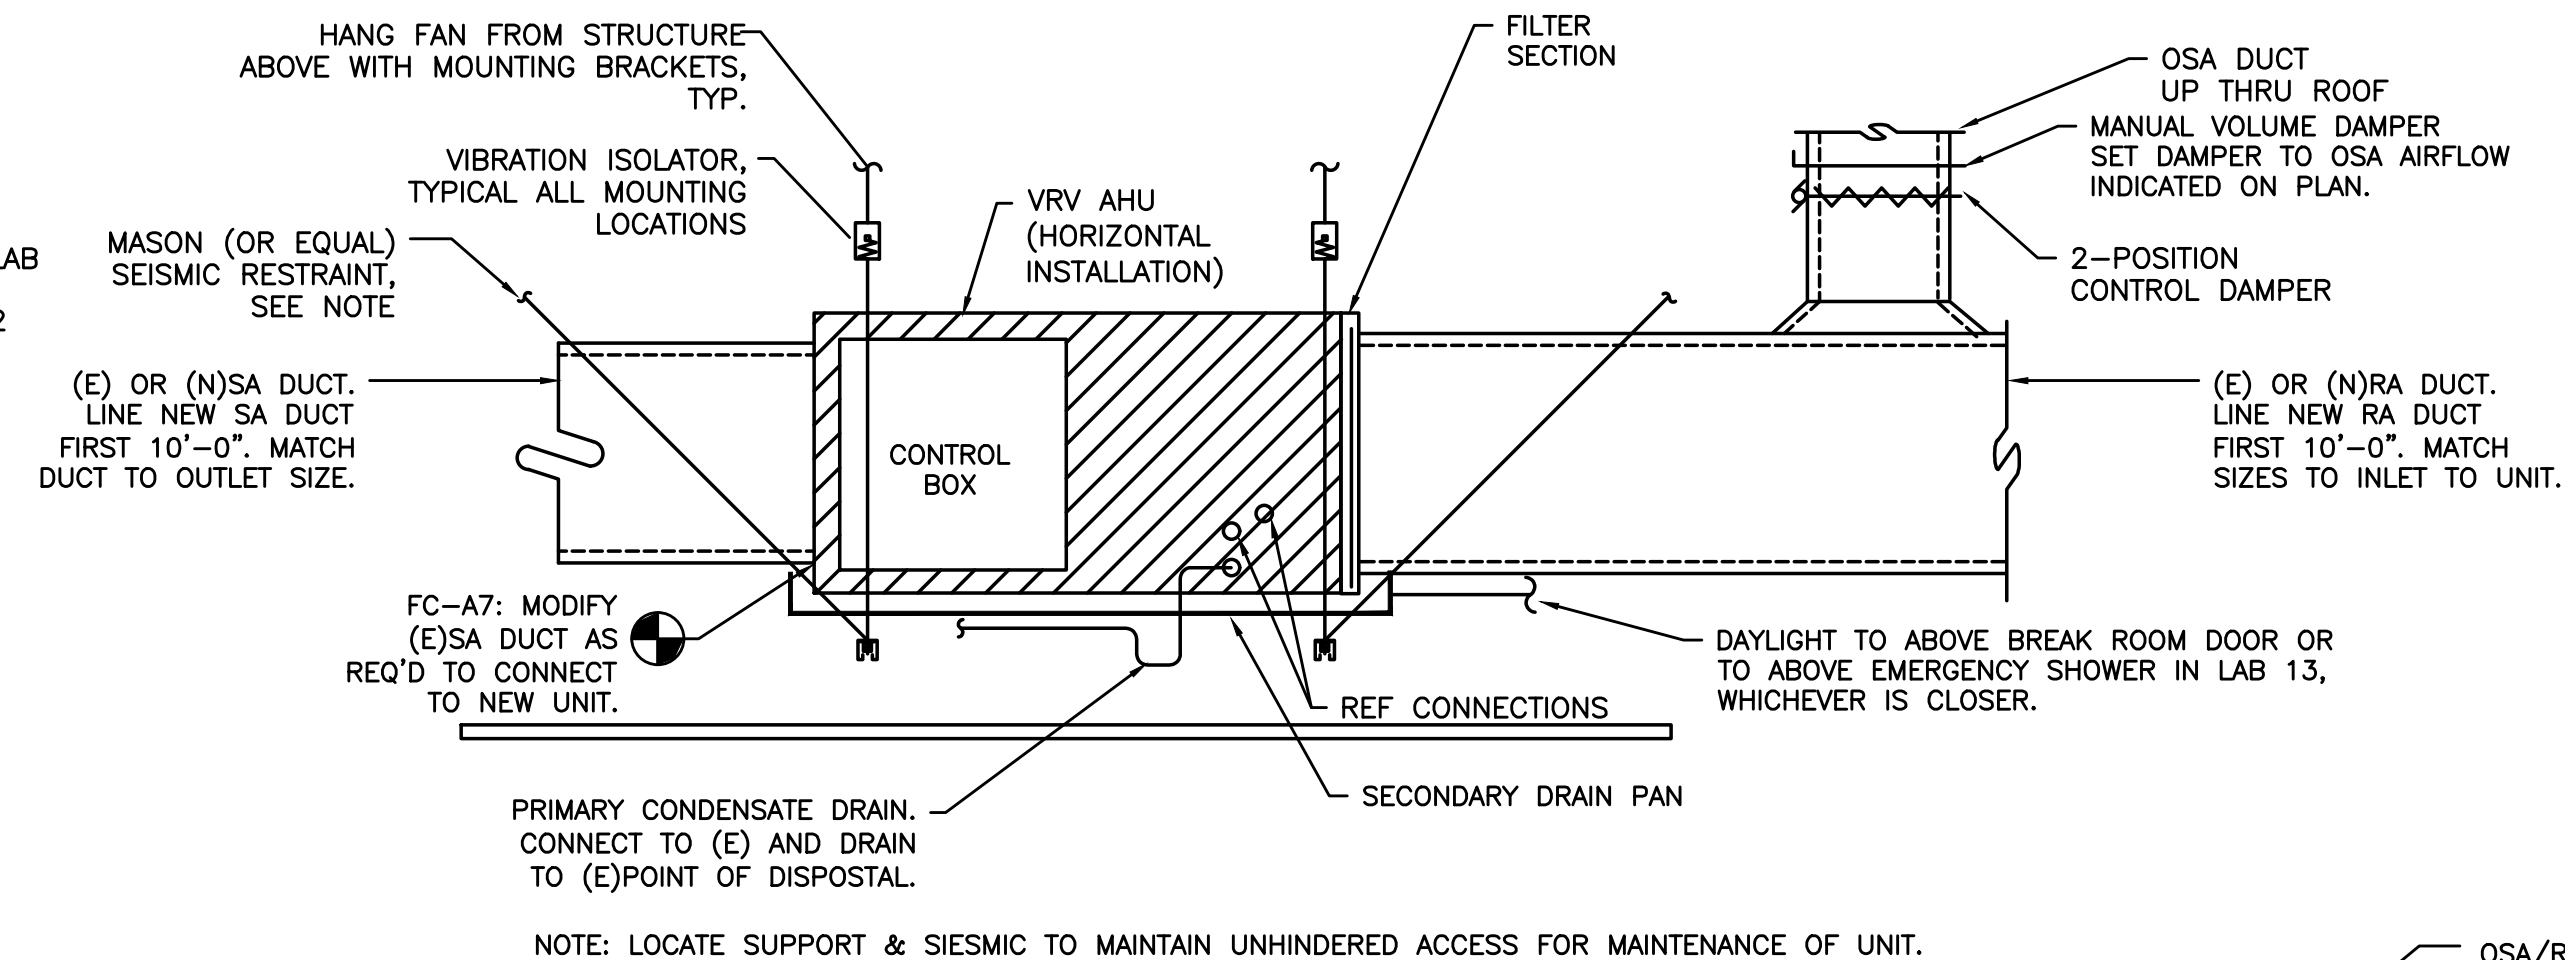

MEFA
INC. Consulting Engineers
2007 S.E. Ash St.
Portland, OR 97214
PHN: (503) 234-0548
FAX: (503) 234-0677
WWW.MFIA-ENG.COM
CONTACT: TAKAKO BAKER

PLAN REVIEW APPROVAL STAMP

BEND RESEARCH, INC.

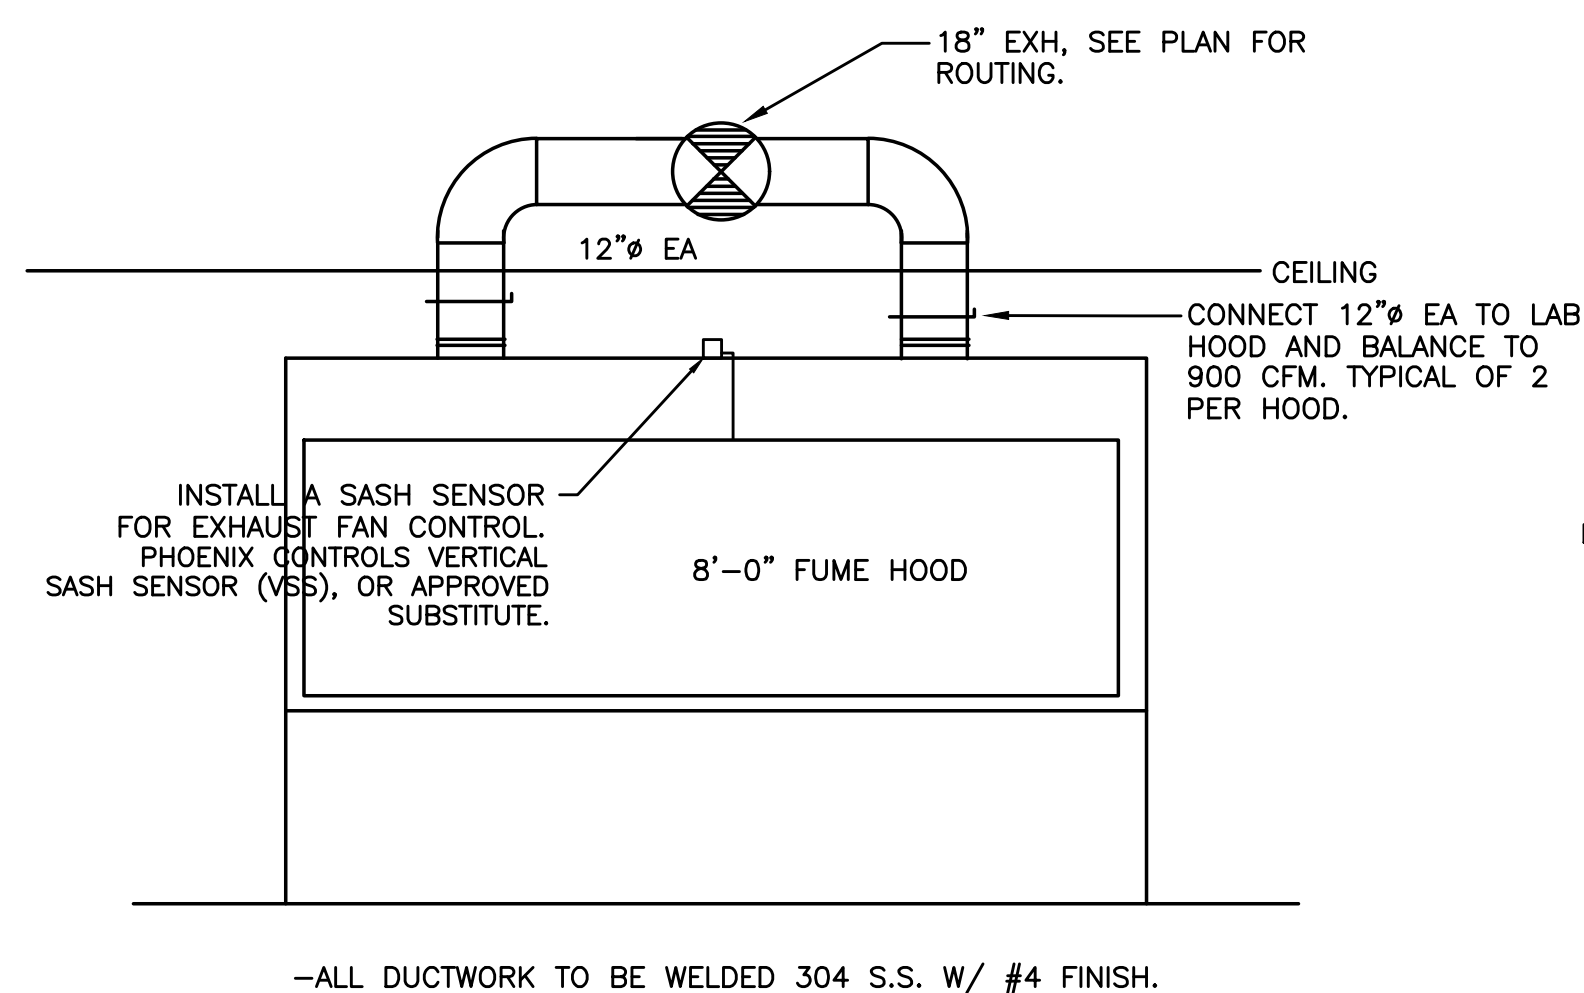

BLAISE CACCIOLA
ARCHITECT

**1465 SW Knoll Avenue, Suite 250
Bend, OR 97702
Phone: 541.728.0375
www.BCA-Architect.com**

BEND RESEARCH, INC
BURLINGAME, CA

64550 RESEARCH RD.
BEND, OREGON 97701

DRAWN/ CHECKED:

ISSUED:

MECHANICAL DETAILS

M6.2