





**KEYED NOTES:**  
 1. PROVIDE SELF-REGULATING ICE MELT CABLE IN THE GUTTER.  
 2. PROVIDE SELF-REGULATING ICE MELT CABLE IN THE DOWNSPOUT. APPROX. LENGTH = 20 FT.

City Of Bend Approval Stamp:

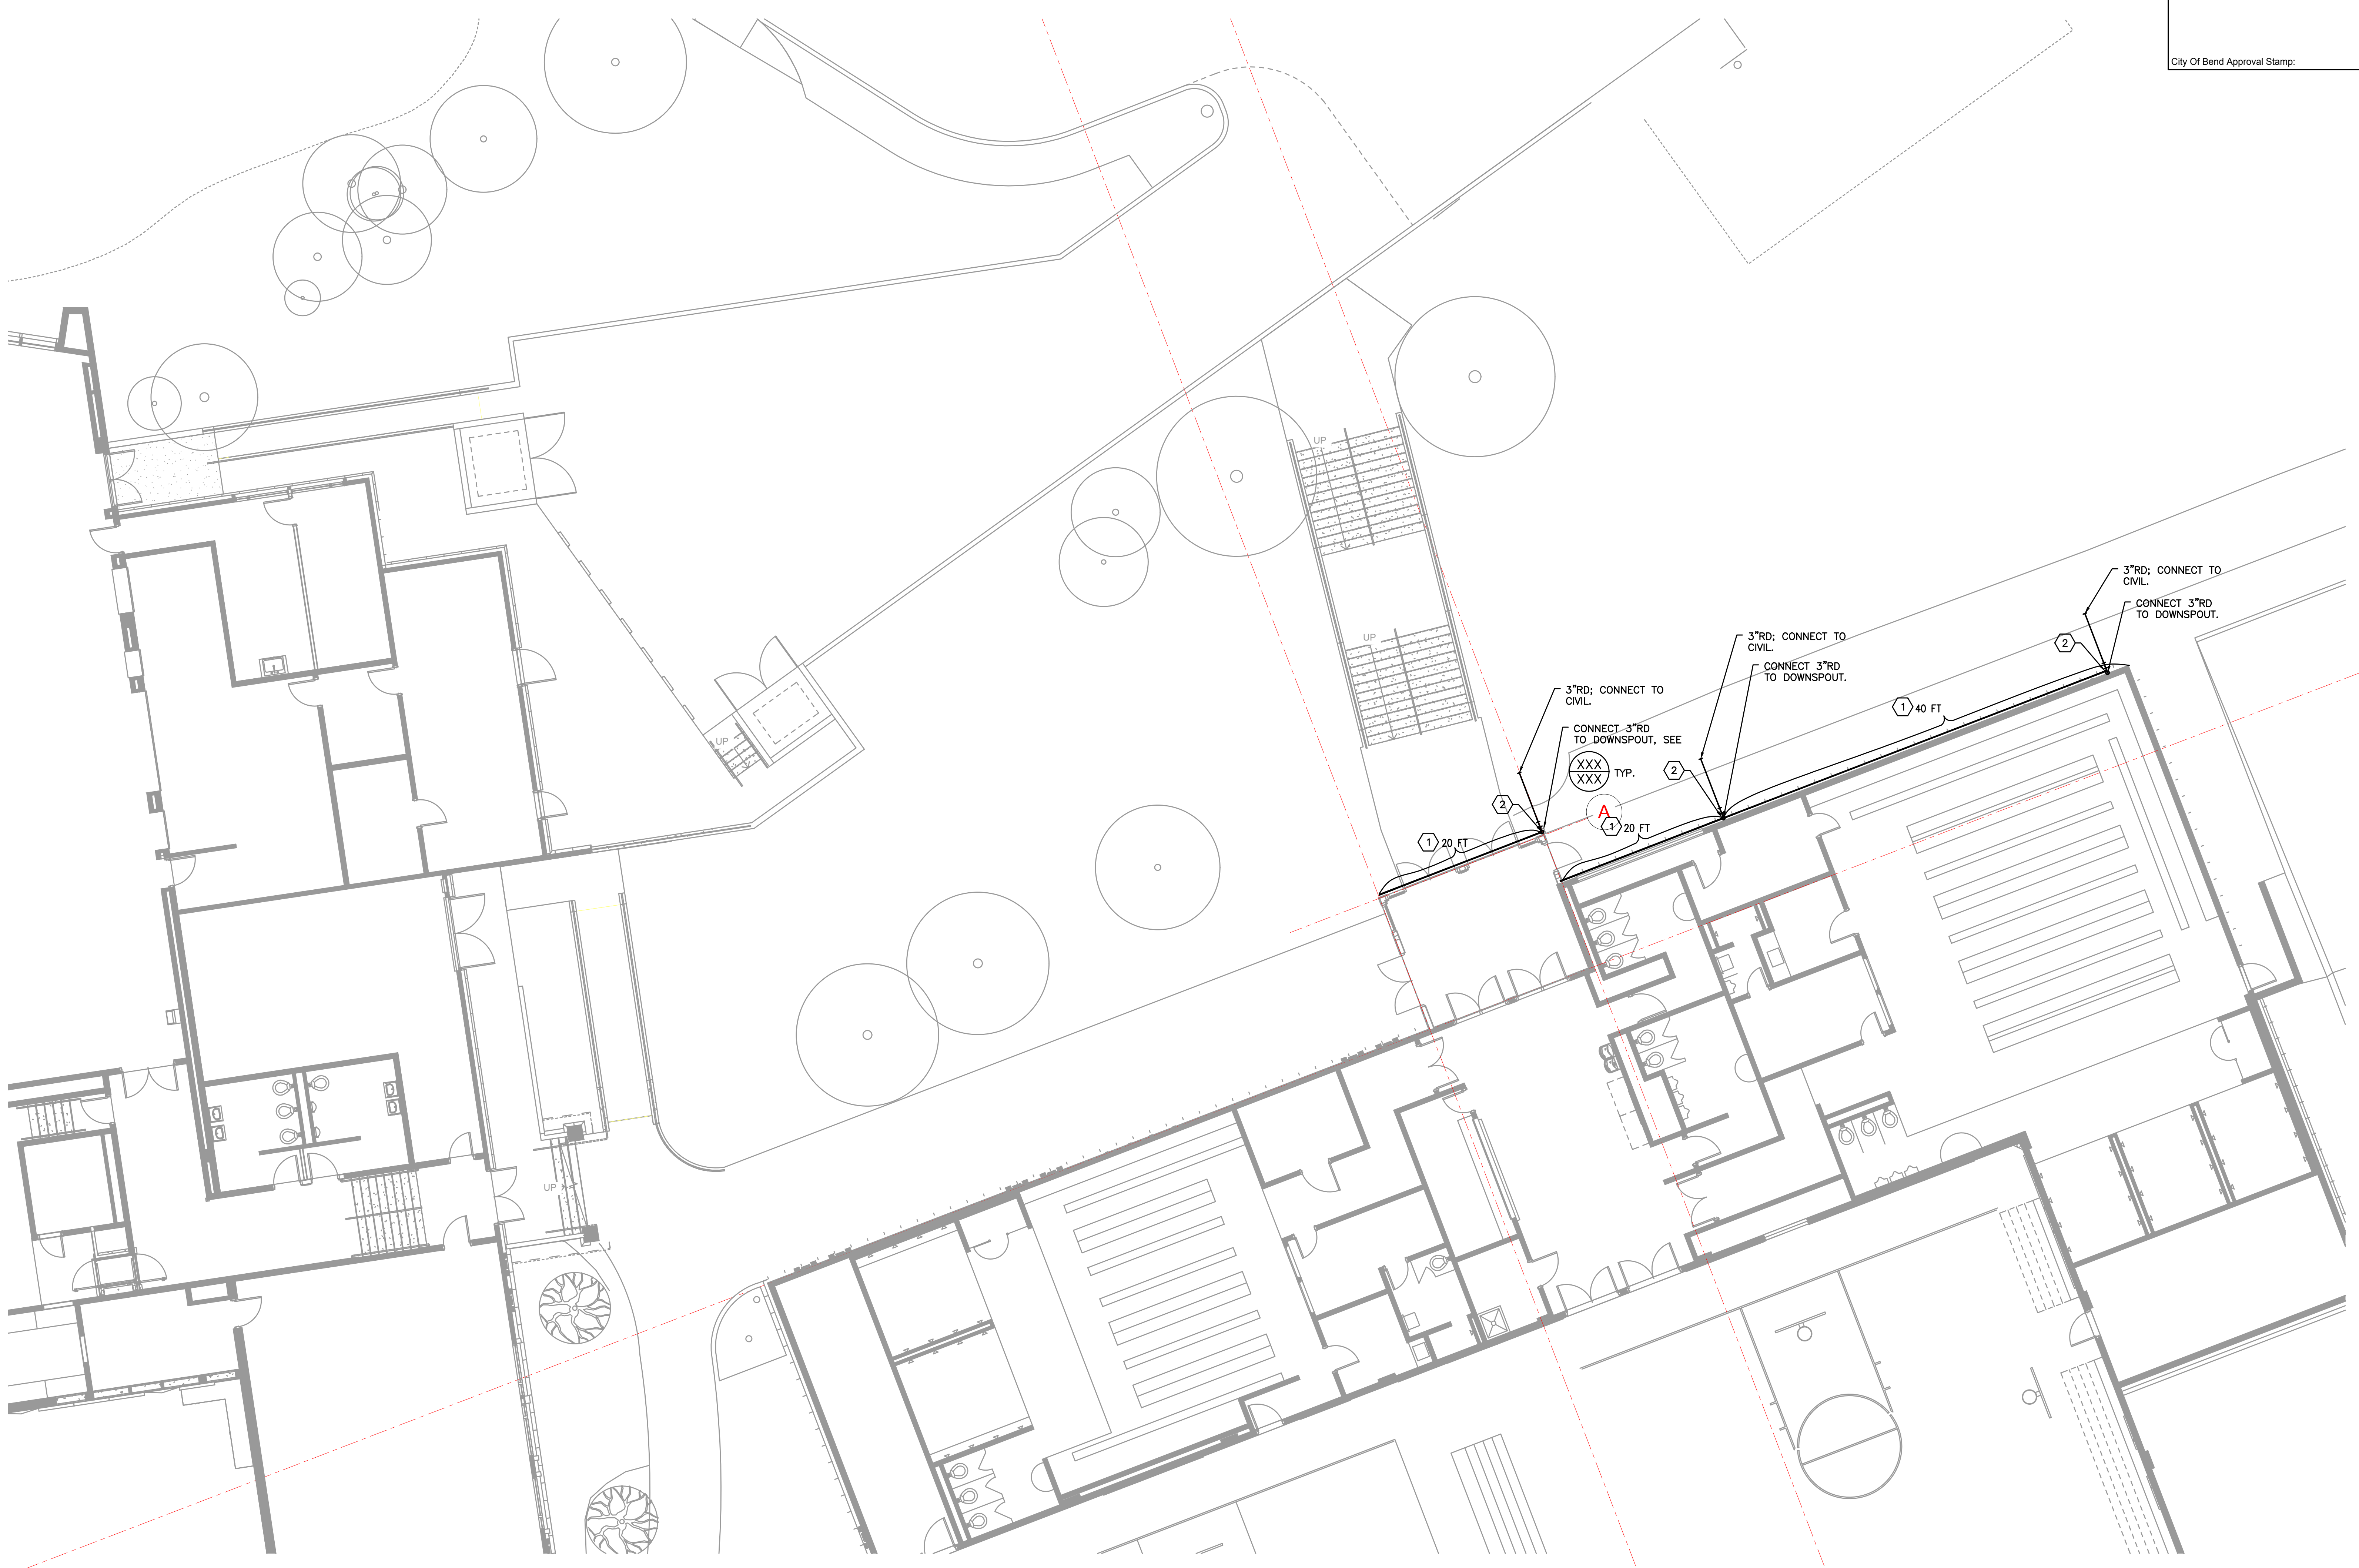

 1 PLUMBING PLAN — BUILDING A  
 2.01 SCALE: 1/8"=1'-0"

#	Date	Description
Revision Schedule		

**65% PROGRESS SET**

**PILOT BUTTE MIDDLE SCHOOL - BUILDING A**  
 1501 NE Neff Road  
 Bend OR 97701

**BLRB architects**

Drawing Title:

**PLUMBING PLAN - BUILDING A**

Date: 11.11.2017 Drawn By: INITIALS

Revised Date: Project No. 17.34B

Stamp Sheet No.

**META INC.**  
 Consulting Engineers  
 2007 S.E. Ash St.  
 Portland, OR 97214  
 PHN: (503) 234-0548  
 FAX: (503) 234-0677  
 WWW.META-ENG.COM  
 CONTACT: TAKAKO BAKER

**P2.01**

**PLUMBING LEGEND**


AFF	..... ABOVE FINISHED FLOOR	---	--- (CW) COLD WATER
ARCH	..... ARCHITECTURAL	---	--- (HW) HOT WATER
B.G.	..... BELOW GRADE	---	--- (HWR) HOT WATER RECIRC
BTU	..... BRITISH THERMAL UNIT	---HT---	--- (HT) HOT WATER HEAT TRACED
CAP.	..... CAPACITY	---	--- (W) BELOW GRADE WASTE
C.I.	..... CAST IRON	---	--- (W) ABOVE GRADE WASTE
COMP.	..... COMPARTMENT	---V---	--- (V) VENT
CONT.	..... CONTINUATION	---AV---	--- (AV) ACID VENT
CU.	..... CUBIC	---RD---	--- (RD) RAIN DRAIN
DF	..... DRINKING FOUNTAIN	---OD---	--- (OD) OVERFLOW RAIN DRAIN
DI	..... DEIONIZED (WATER)	---FDC---	--- (FDC) FIRE DEPARTMENT CONNECTION
DIA.	..... DIAMETER	---A---	--- (A) COMPRESSED AIR
ELEV.	..... ELEVATION	---PHW---	--- (PHW) PROCESS HOT WATER
EWC	..... ELECTRIC WATER COOLER	---PCW---	--- (PCW) PROCESS COLD WATER
FD	..... FLOOR DRAIN	---VAC---	--- (VAC) VACUUM
FDC	..... FIRE DEPARTMENT CONNECTION	---G---	--- (G) NATURAL GAS
F.F.	..... FINISH FLOOR	---F---	--- (F) FIRE WATER
FLG.	..... FLANGE	---GW---	--- (GW) GREASE WASTE
FT	..... FOOT / FEET	---AW---	--- (AW) ACID WASTE
G	..... GAS		
GALV.	..... GALVANIZED		
GPM	..... GALLONS PER MINUTE		
G.V.	..... GATE VALVE		
HP	..... HORSEPOWER		
HR.	..... HOUR		
I.E.	..... INVERT ELEVATION		
I.W.	..... INVERT		
LAV	..... LAVATORY		
LBS	..... POUNDS		
MAX.	..... MAXIMUM		
MBH	..... THOUSANDS OF BTUs PER HOUR		
MIN.	..... MINIMUM		
M.J.	..... MECHANICAL JOINT		
N.I.M.	..... NOT IN MECHANICAL		
OS&Y	..... OUTSIDE STEM & YOKE		
PROT.	..... PROTECTION		
PRV	..... PRESSURE REDUCING VALVE		
PSI, PSIG	..... POUNDS PER SQUARE INCH		
P/T	..... PRESSURE / TEMPERATURE		
REQ'D	..... REQUIRED		
RPBP	..... REDUCED PRESSURE BACKFLOW PREVENTER		
RPM	..... REVOLUTIONS PER MINUTE		
TYP.	..... TYPICAL		
UR	..... URINAL		
VTR	..... VENT THROUGH ROOF		
WC	..... WATER CLOSET		

	..... EQUIPMENT MARK NUMBER		..... PRESSURE/TEMP RELIEF VALVE
	..... FIXTURE MARK		..... BUTTERFLY VALVE
(E)	..... EXISTING		..... GAS PRESSURE REGULATING VALVE
	..... NOTE		..... TOP CONNECTION
	..... CONNECT TO EXISTING		..... BOTTOM CONNECTION
	..... CAP		..... PIPE TURNED UP, PIPE TURNED DOWN
	..... TEE		..... GATE VALVE
	..... ELBOW		..... BALL VALVE
	..... CLEANOUT		..... BALANCING VALVE
			..... CHECK VALVE
			..... UNION
			..... DOUBLE CHECK ASSEMBLY

**PLUMBING CONNECTION SCHEDULE**

MARK	FIXTURE	W	V	CW	HW	REMARKS
DS-1	DOWNSPOUT					SEE XX/P6.01

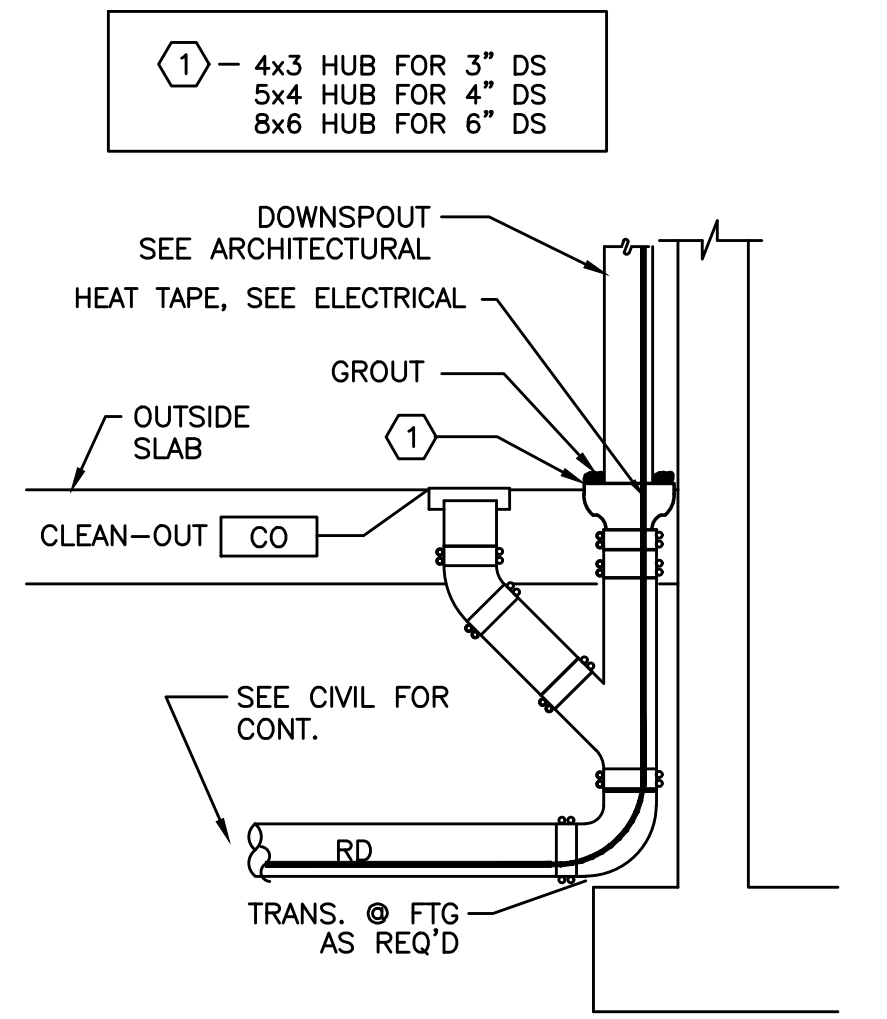

**1 DOWN SPOUT DETAIL**  
SCALE: DETAIL

City Of Bend Approval Stamp:

#	Date	Description
Revision Schedule		

**65% PROGRESS SET**

**PILOT BUTTE MIDDLE SCHOOL - BUILDING A**

1501 NE Neff Road  
Bend OR 97701

**BLRB architects**

Drawing Title:

**PLUMBING LEGEND AND SCHEDULES**

Date: 11.11.2017 Drawn By: INITIALS

Revised Date: Project No. 17.34B

Stamp: Sheet No.

**P6.01**