


1 2 3 4 5 6

A  
B  
C  
D  
E  
F  
G  
H  
J  
K

City Of Bend Approval Stamp:

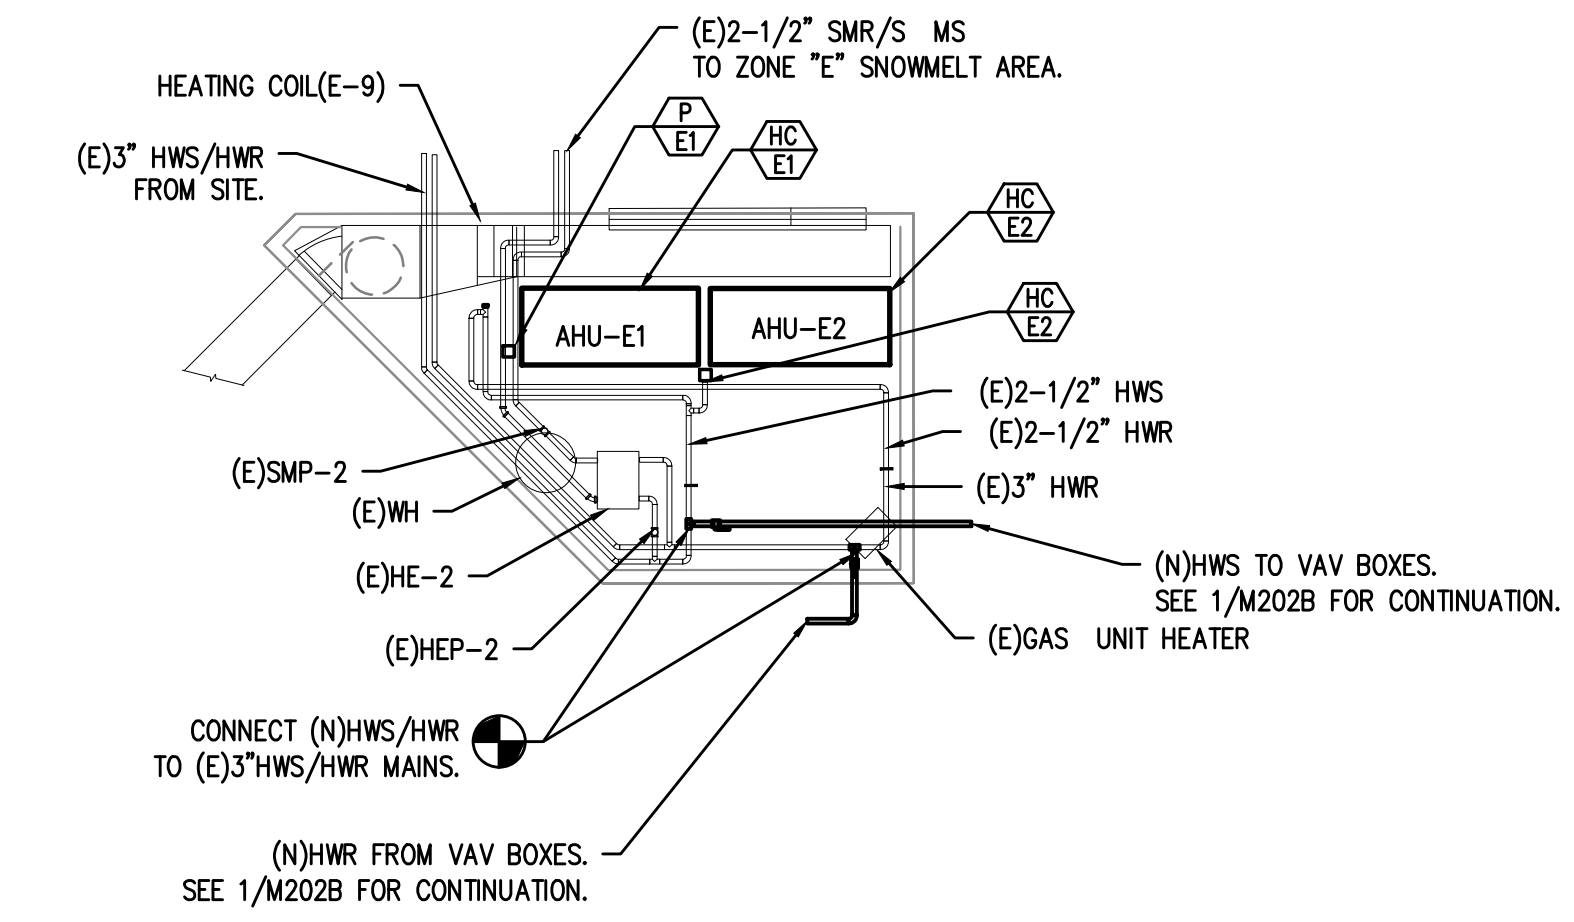

**3** MECHANICAL ROOM PIPING DETAIL  
M2.02B SCALE: 1/8"=1'-0"

**1** MECHANICAL PIPING FLOOR PLAN - BUILDING E  
M2.02B SCALE: 1/8"=1'-0"

#	Date	Description
Revision Schedule		

**PILOT BUTTE MIDDLE SCHOOL - BLDGS E&F**  
Project Address

**BLRB architects**

Drawing Title:  
**MECHANICAL PIPING PLAN - BUILDING E**

Date : 11.11.2017 Drawn By : INITIALS

Revised Date : Project No. 17.34B

Stamp Sheet No.

**META INC.**  
Consulting Engineers  
2007 S.E. Ash St.  
Portland, OR 97214  
PH: (503) 234-0548  
FAX: (503) 234-0677  
WWW.META-ENG.COM  
CONTACT: TAKAKO BAKER

**M2.02B**