


City Of Bend Approval Stamp:

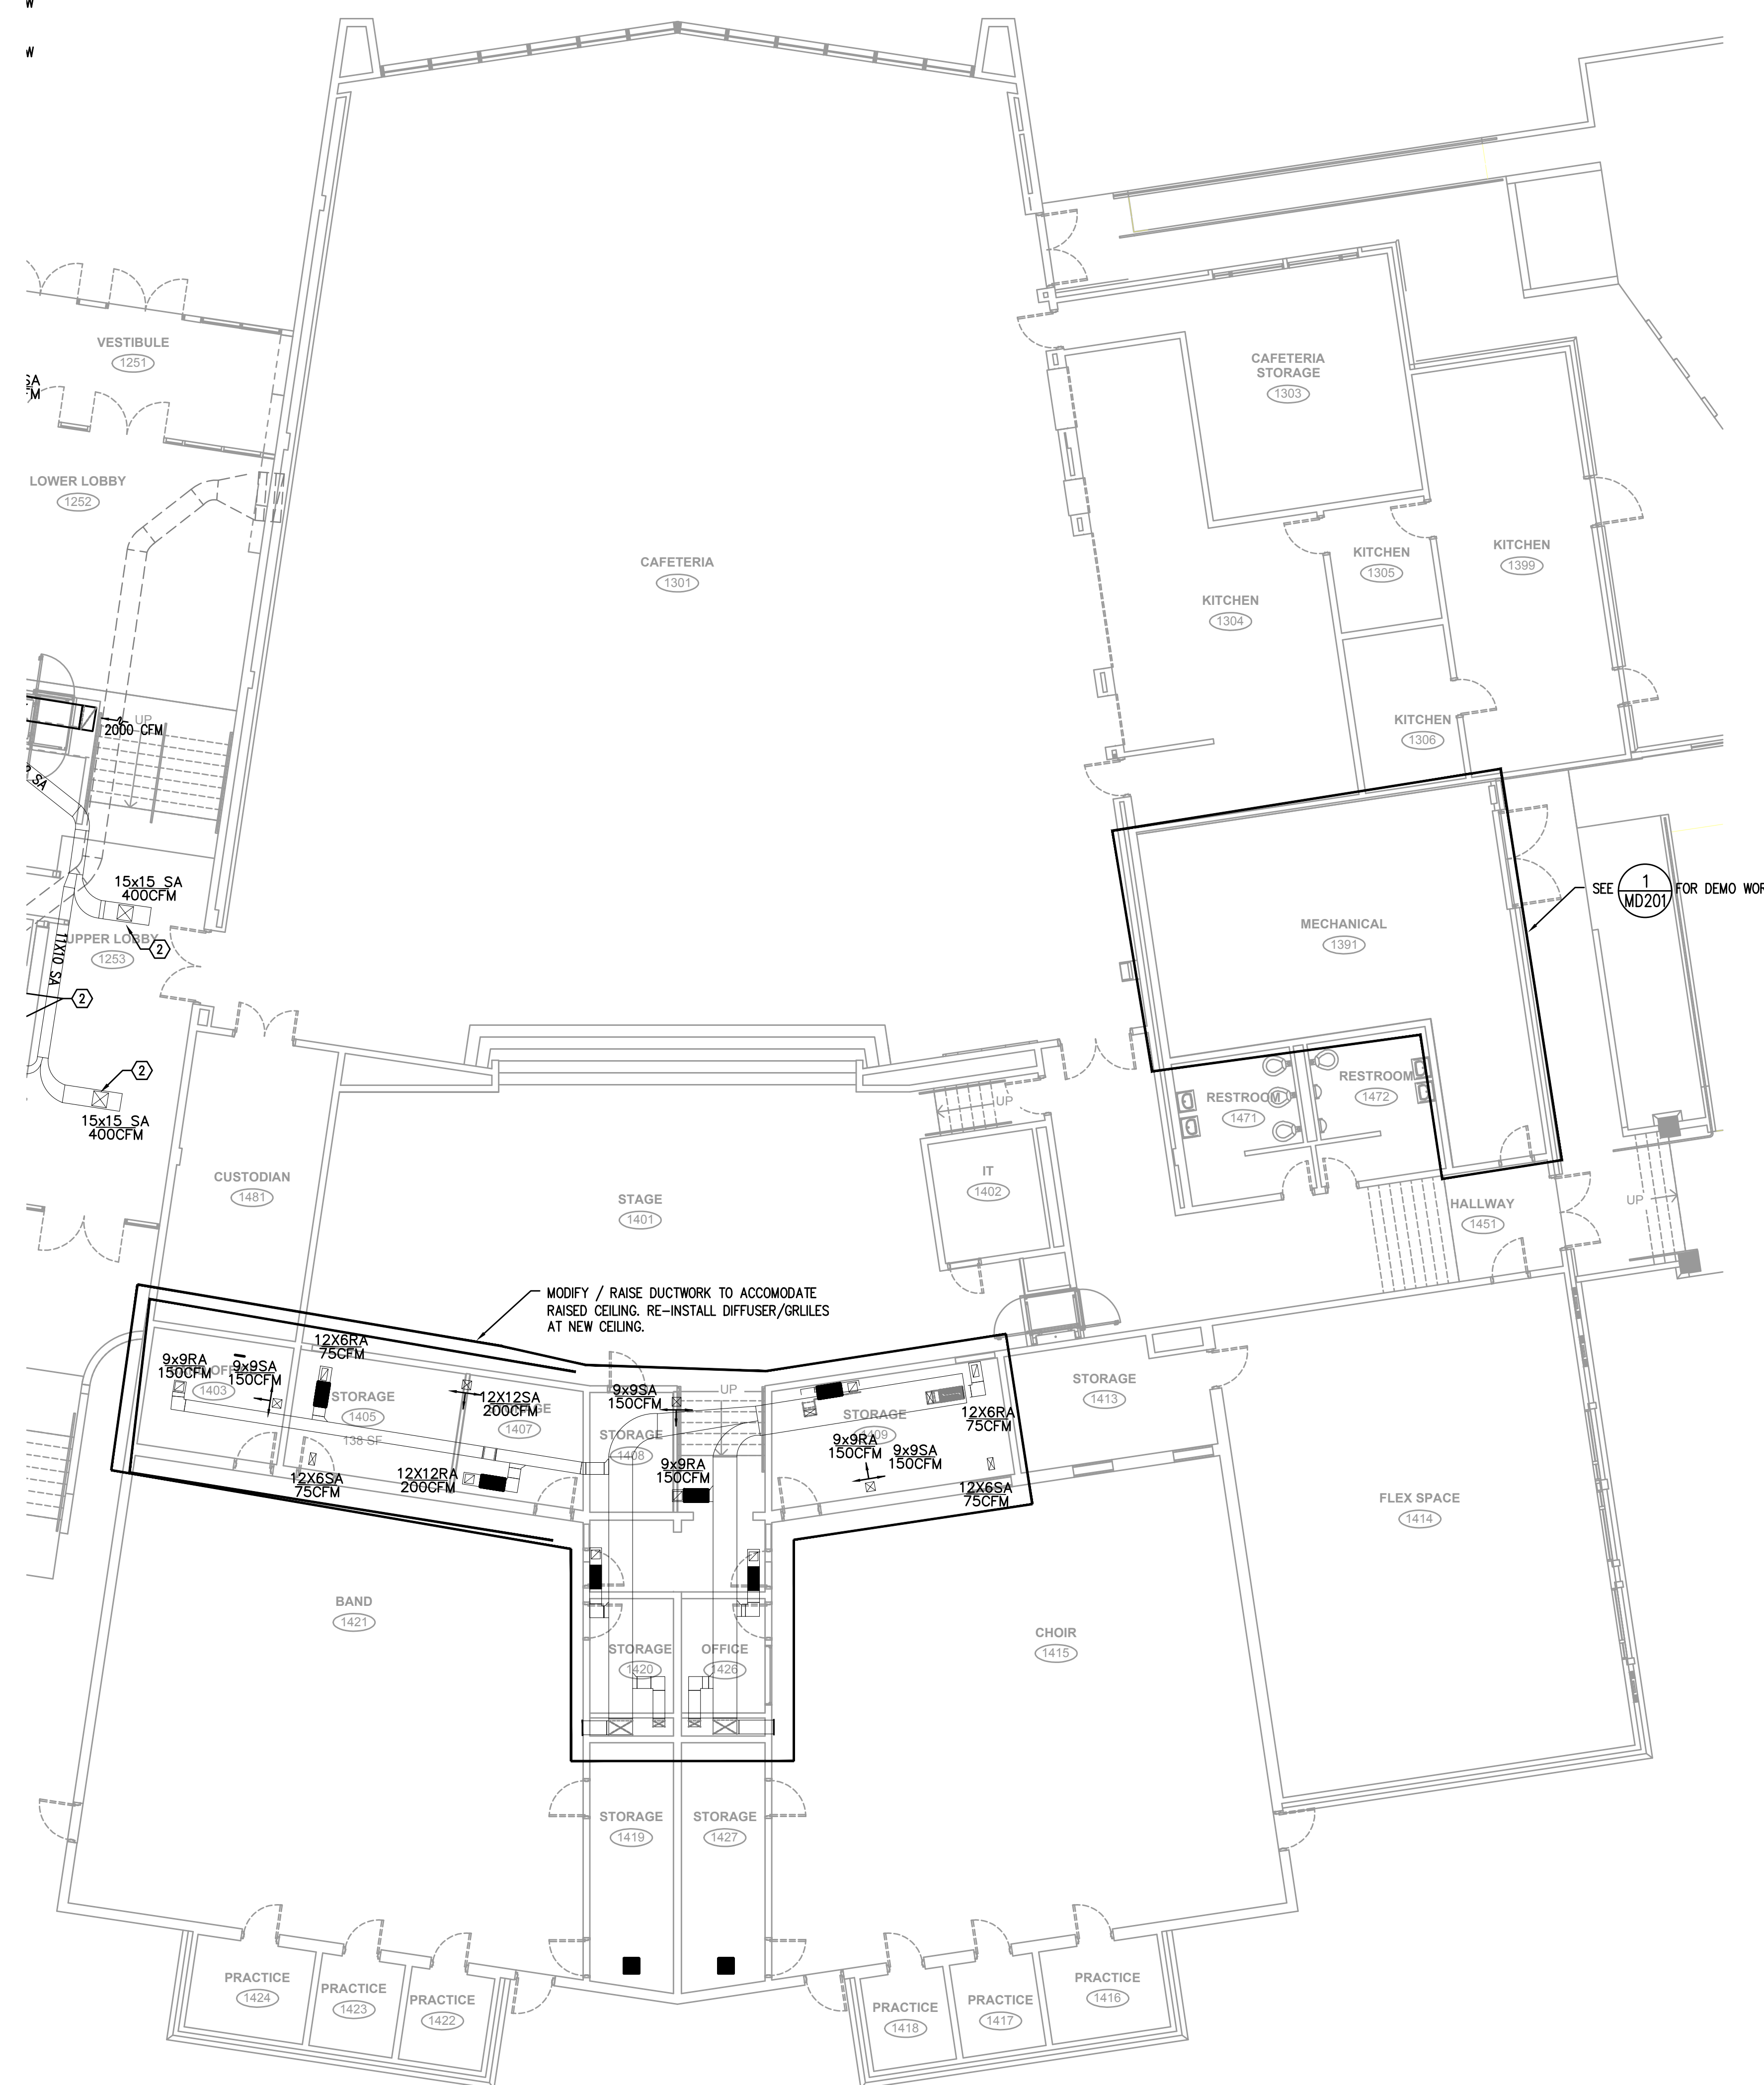

1 MECHANICAL FLOOR PLAN - BUILDINGS F
M2.03 SCALE: 1/8"=1'-0"

#	Date	Description

#	Date	Description

PILOT BUTTE MIDDLE SCHOOL - BLDGS E&F
Project Address



Drawing Title:

MECHANICAL FLOOR PLAN - BUILDG F

Date: 11.11.2017 Drawn By: INITIALS

Revised Date: Project No. 17.34B

Stamp Sheet No.

META INC.
Consulting Engineers
2007 S.E. Ash St.
Portland, OR 97214
PH: (503) 234-0548
FAX: (503) 234-0877
WWW.META-ENG.COM
CONTACT: TAKAKO BAKER

M2.03