

1

2

3

4

5

6

A

B

C

D

E

F


G

H

J

K

City Of Bend Approval Stamp:

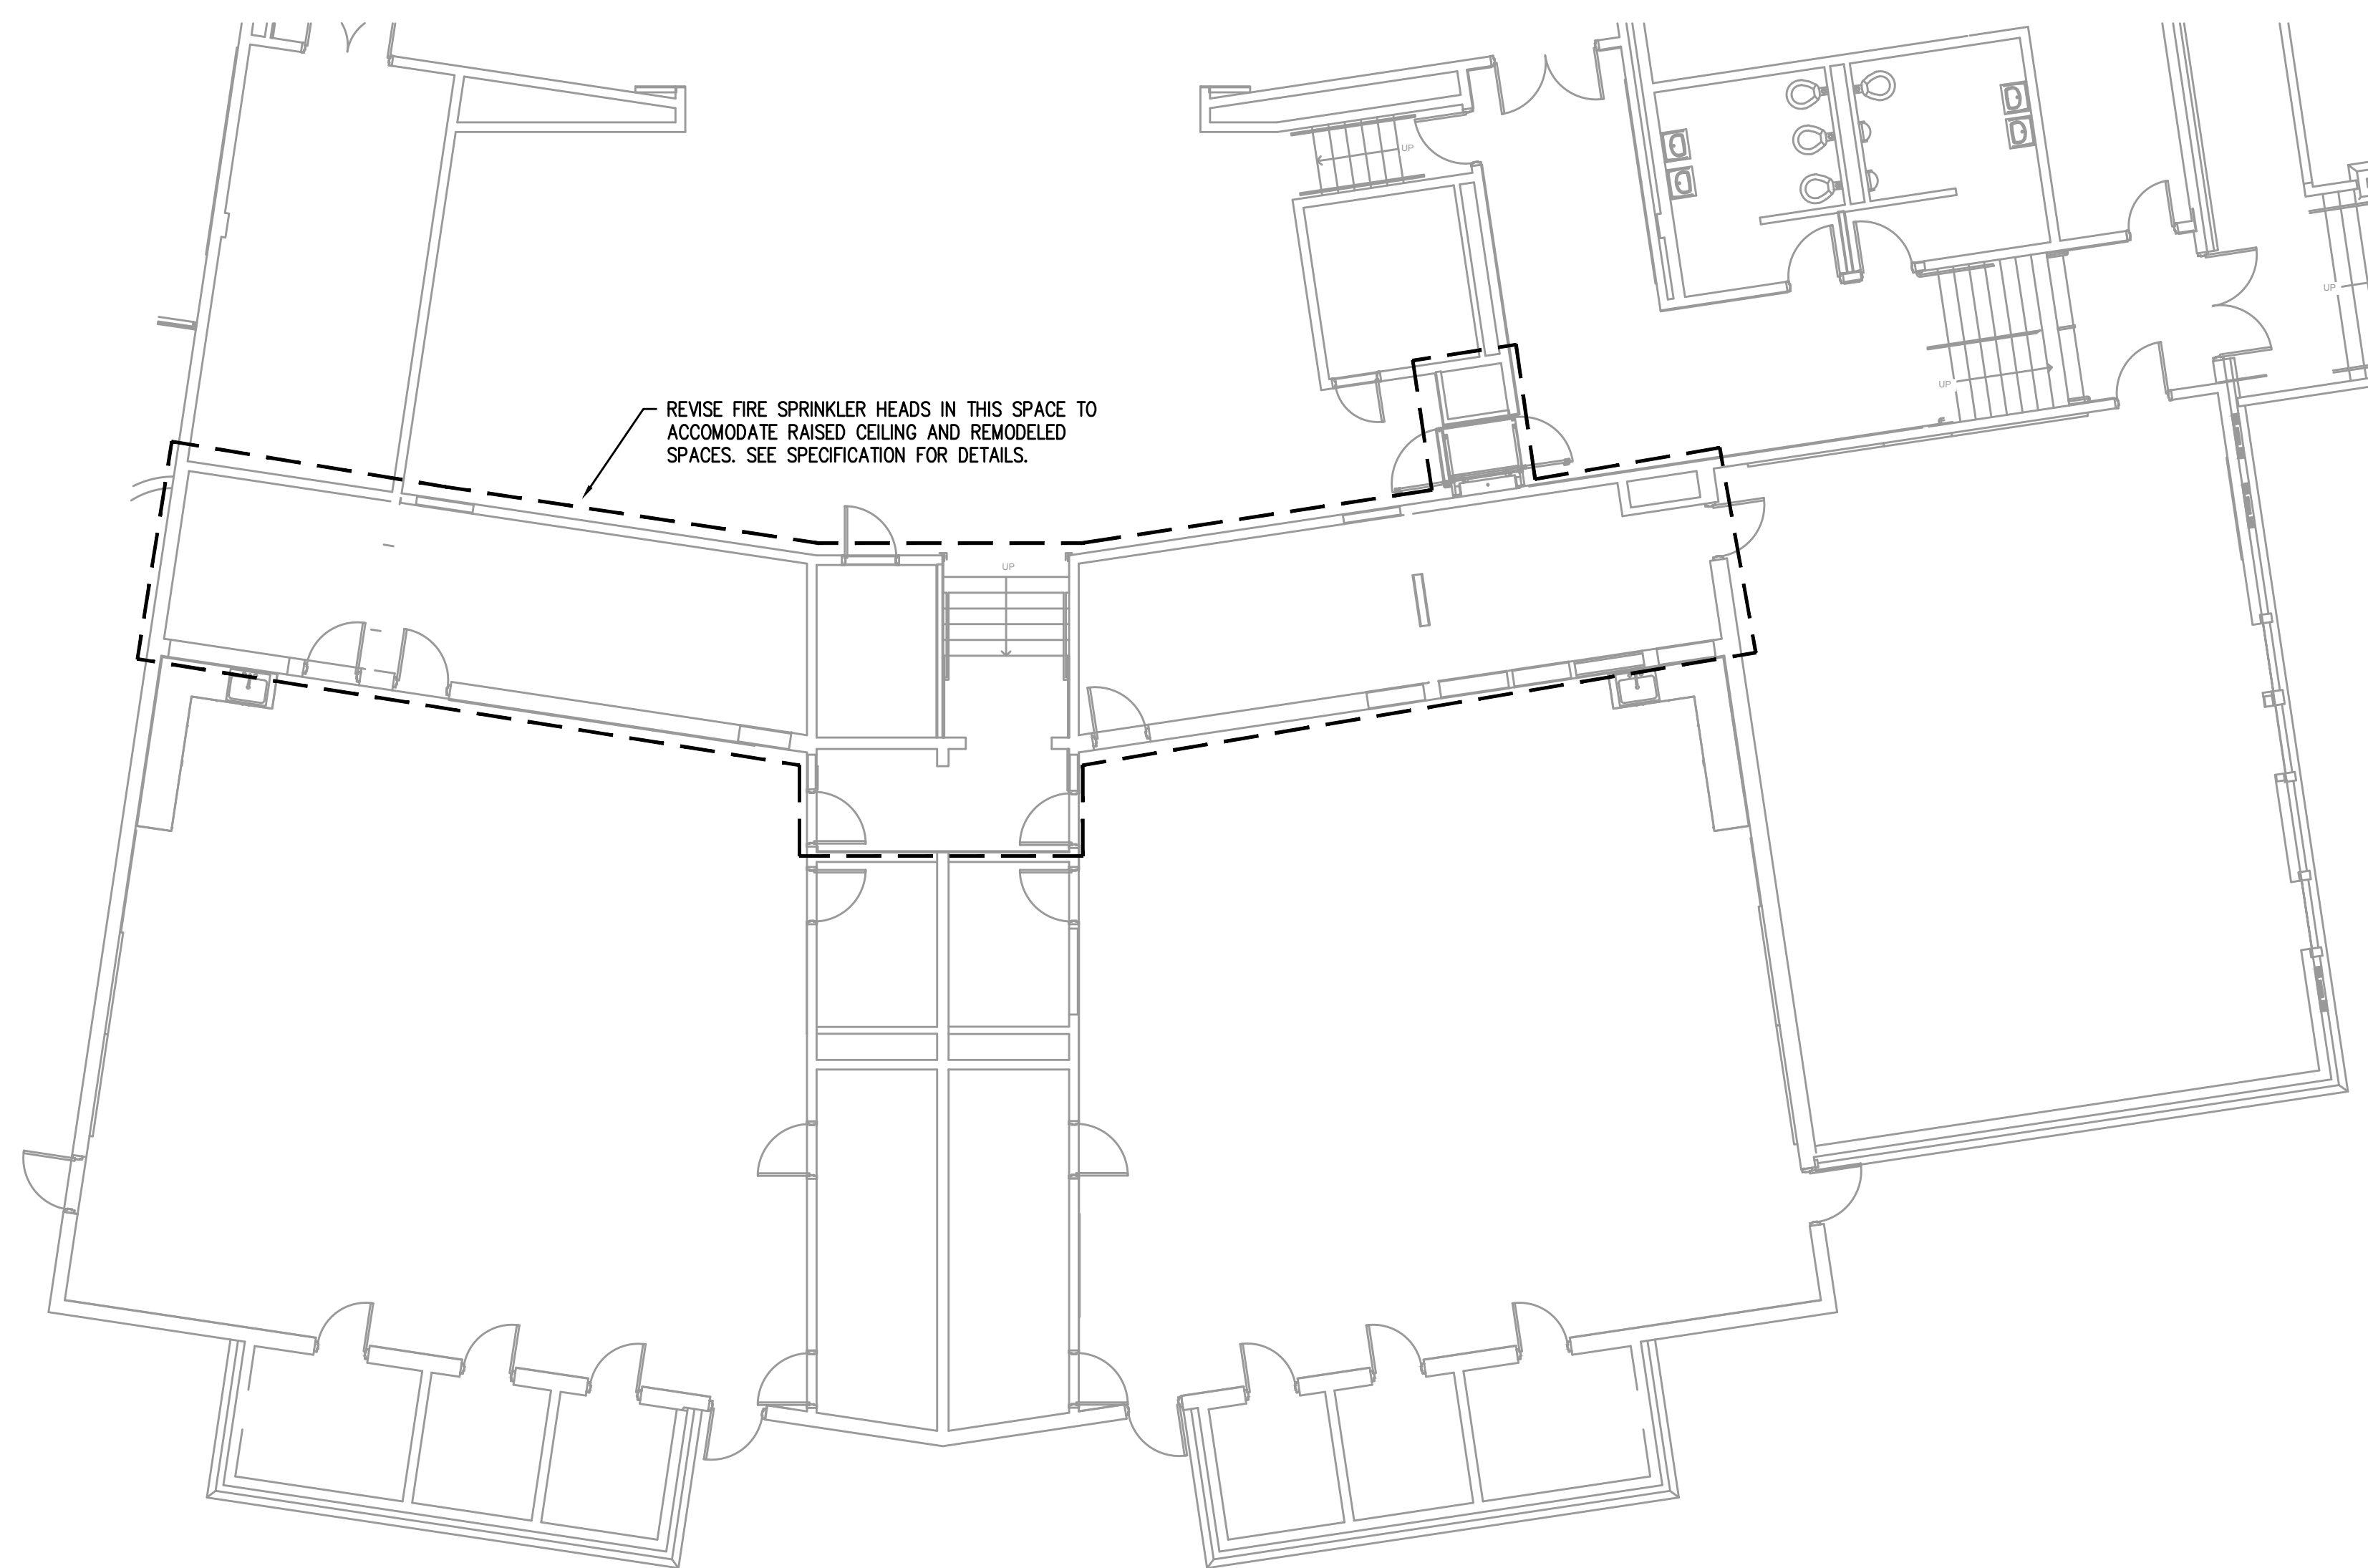

1 FIRE SPRINKLER PLAN
 FS1.00 SCALE: 1/8"=1'-0"

#	Date	Description
1	2/19/18	DISTRICT REVIEW COMMENTS

BID SET

PILOT BUTTE MIDDLE SCHOOL - BLDGS E&F
 1501 NE Neff Road,
 Bend OR 97701

BLRB architects


Drawing Title:
FIRE SPRINKLER FLOOR PLAN - BUILDING F

Date : 02.19.2018 Drawn By : TB

Revised Date : Project No. 17.34B

Stamp Sheet No.

MPIA
 Consulting Engineers
 2007 S.E. Ash St.
 Portland, OR 97214
 PHN: (503) 234-0549
 FAX: (503) 234-0877
 INC. WWW.MPIA-ENG.COM
 CONTACT: TAKAKO BAKER

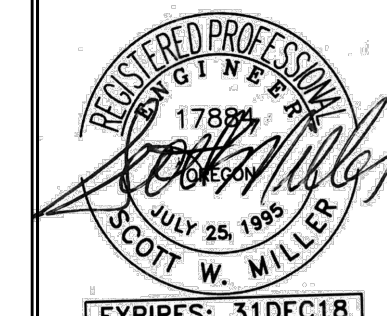

FS1.00