

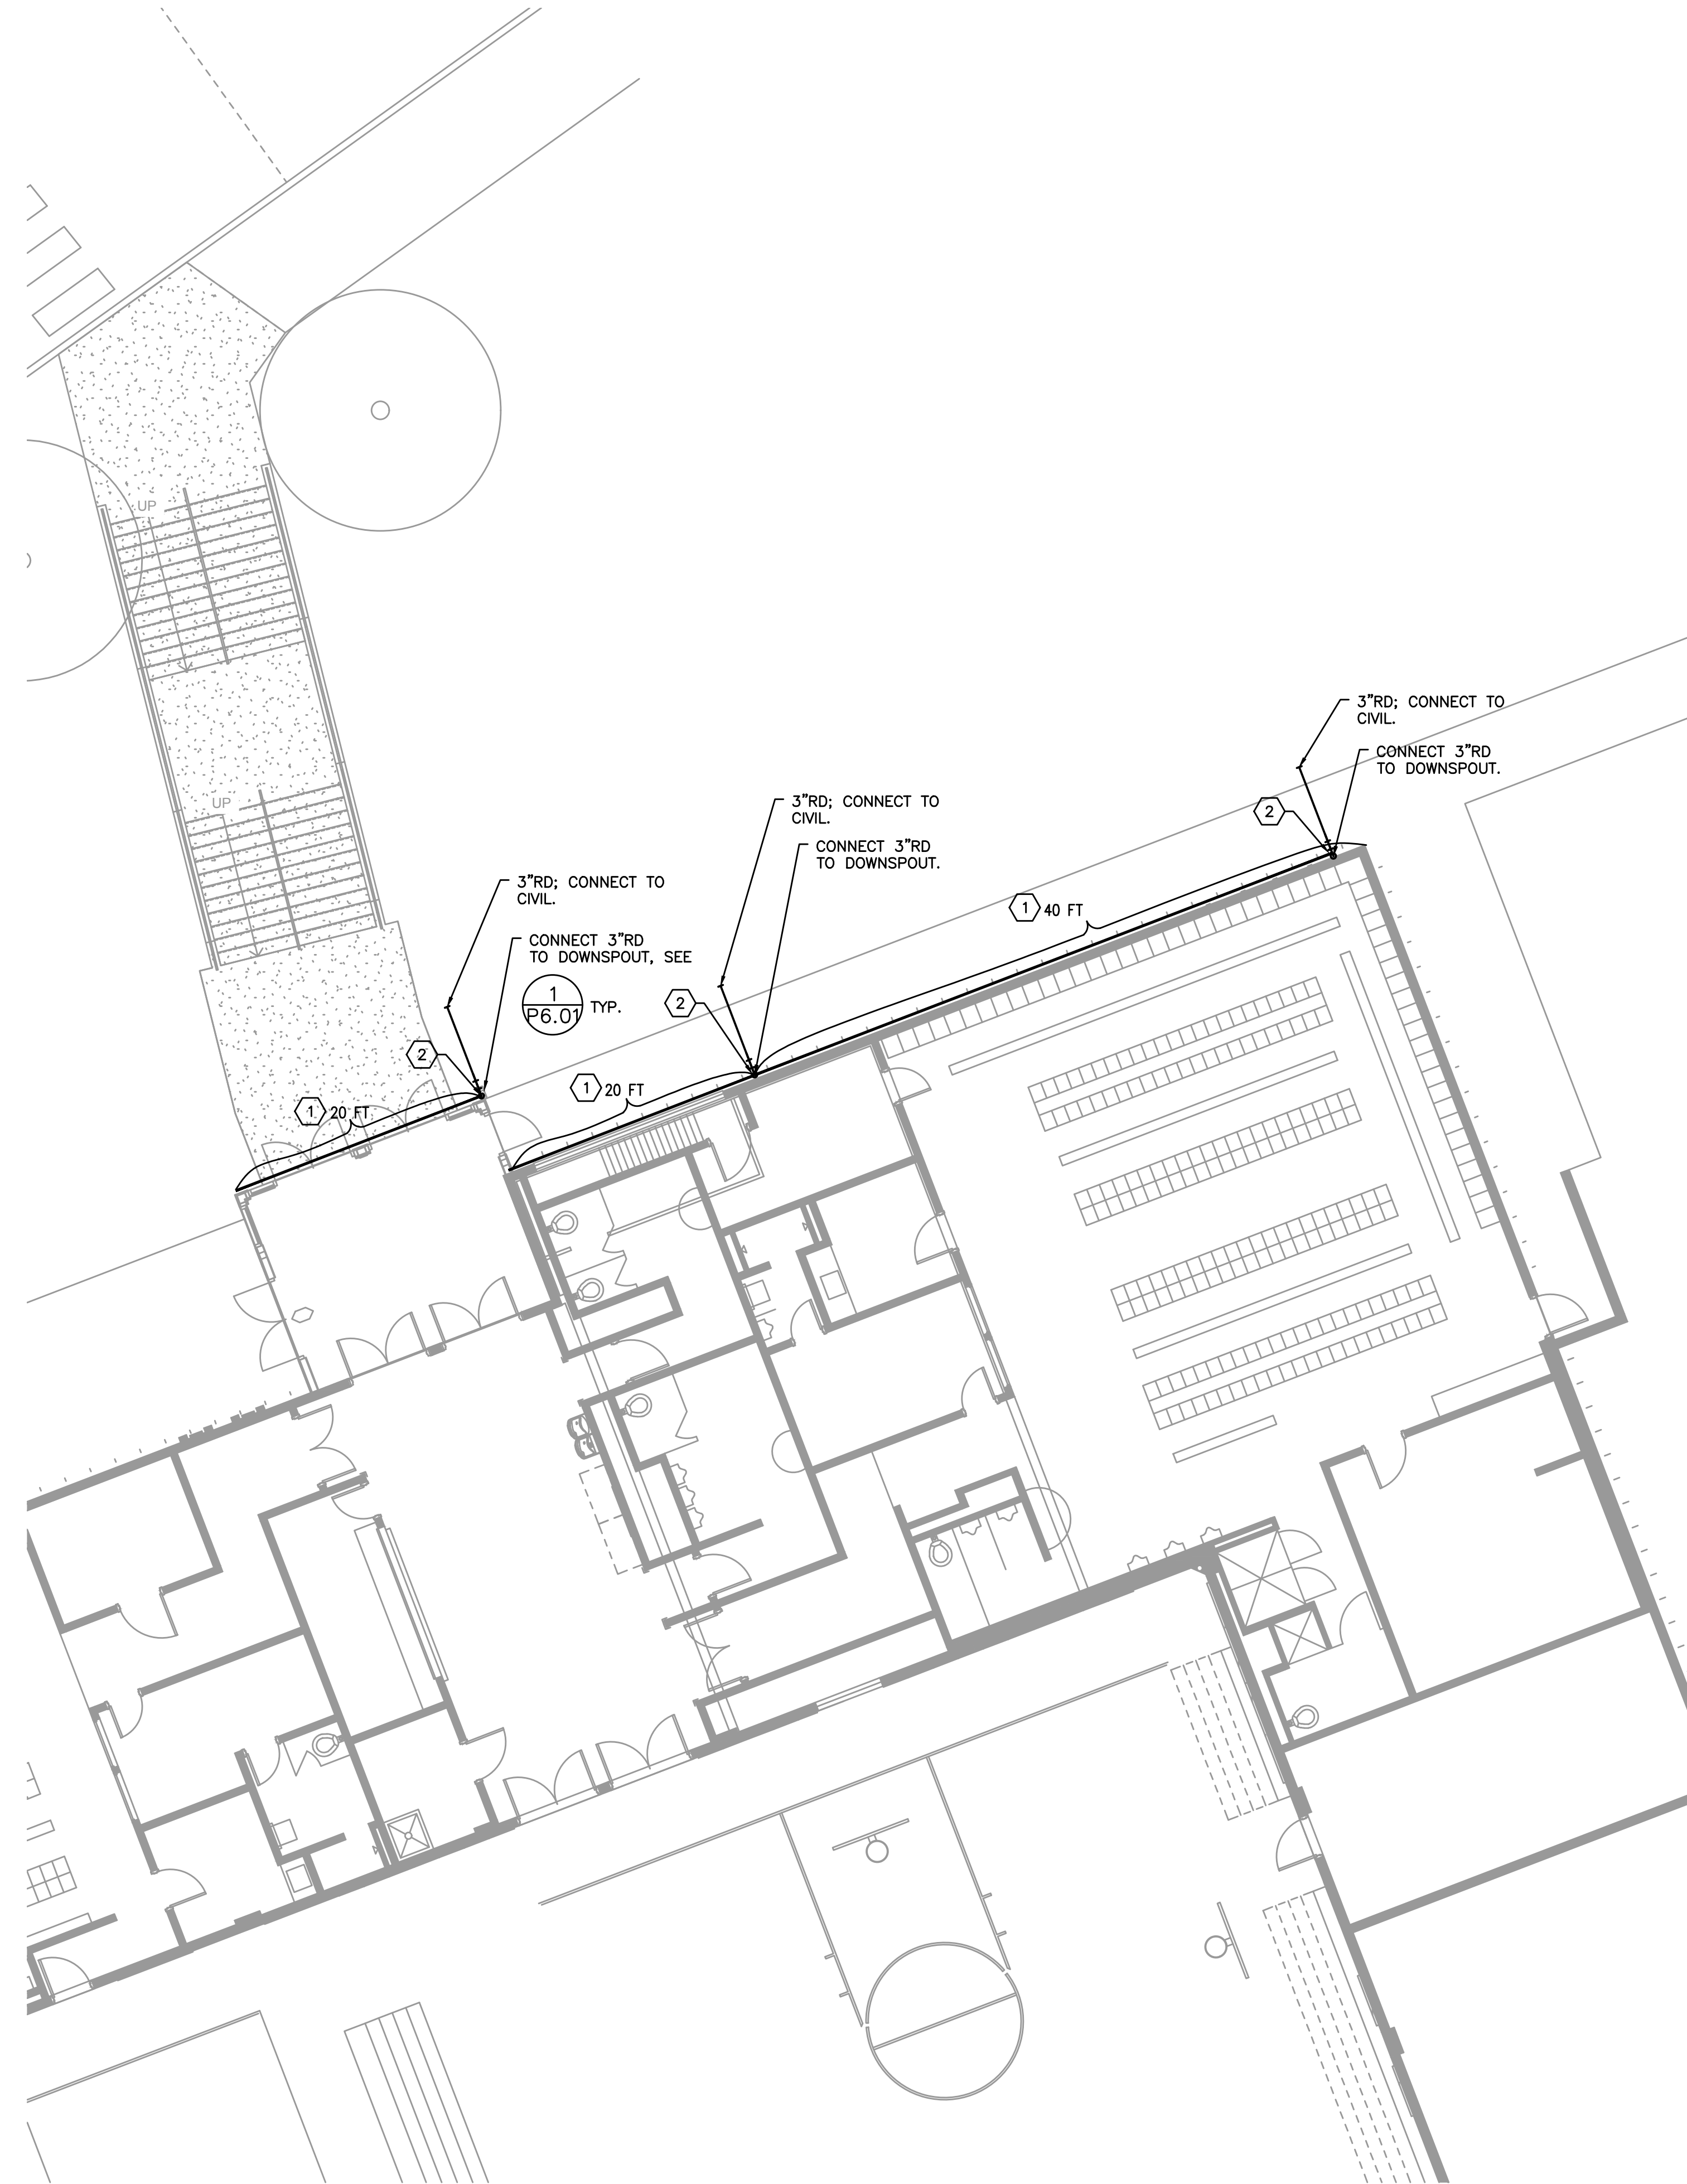



KEYED NOTES:
 1. PROVIDE SELF-REGULATING ICE MELT CABLE IN THE GUTTER.
 2. PROVIDE SELF-REGULATING ICE MELT CABLE IN THE DOWNSPOUT. APPROX. LENGTH = 20 FT.

City Of Bend Approval Stamp:

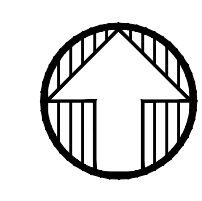

 2 PLUMBING PLAN - BUILDING A-ALTERNATE #2
 P2.01 SCALE: 1/8"=1'-0"

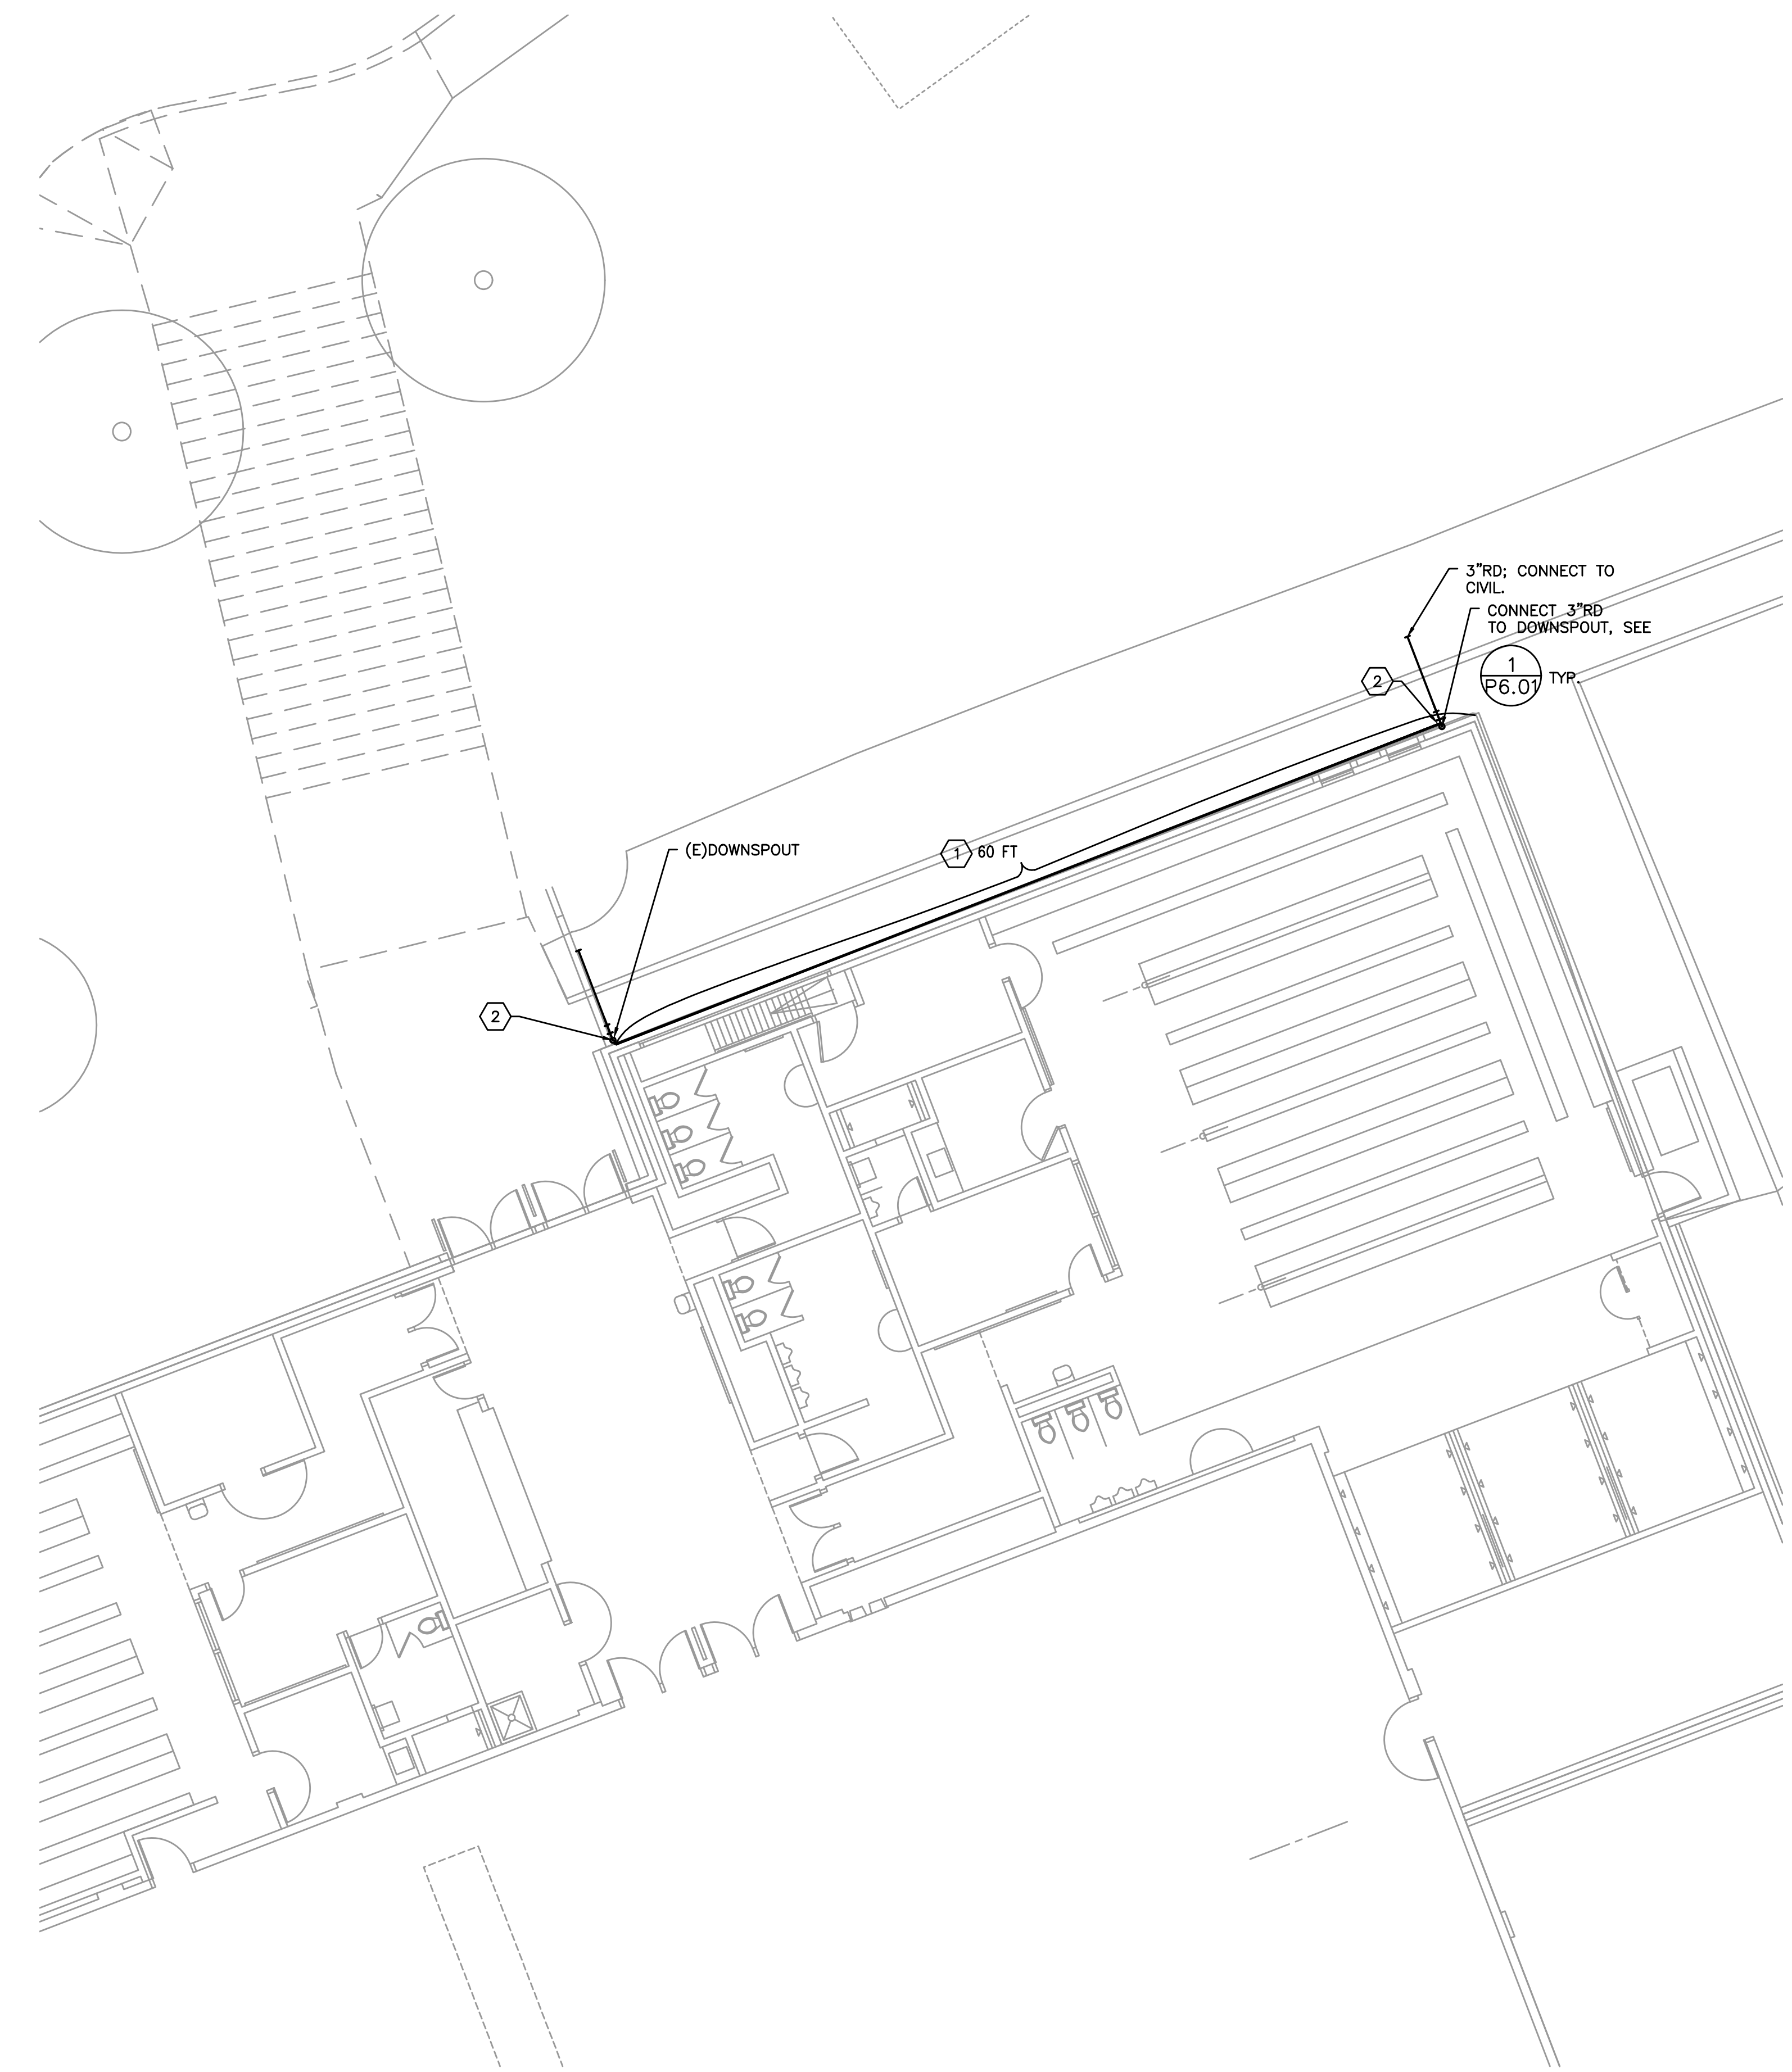

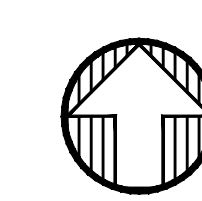 1 PLUMBING PLAN - BUILDING A
 P2.01 SCALE: 1/8"=1'-0"

#	Date	Description
1	2/19/18	DISTRICT REVIEW COMMENTS


BID SET

PILOT BUTTE MIDDLE SCHOOL - BUILDING A
 1501 NE Neff Road
 Bend OR 97701

BLRB architects

Drawing Title: PLUMBING PLAN - BUILDING A	
Date : 02.19.2018	Drawn By : TB
Revised Date :	Project No. 17.34B
Stamp	Sheet No.

MFI Consulting Engineers
 2007 S.E. Ash St.
 Portland, OR 97214
 PH: (503) 234-0548
 FAX: (503) 234-0877
 INC. WWW.MFIA-ENG.COM
 CONTACT: YAKAKO BAKER

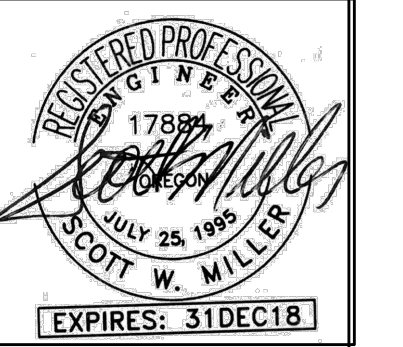

P2.01


PLUMBING LEGEND

AFF ABOVE FINISHED FLOOR	---	(CW) COLD WATER
ARCH ARCHITECTURAL	---	(HW) HOT WATER
B.G. BELOW GRADE	---	(HWR) HOT WATER RECIRC
BTU BRITISH THERMAL UNIT	---A---A	(HT) HOT WATER HEAT TRACED
CAP. CAPACITY	---	(W) BELOW GRADE WASTE
C.I. CAST IRON	---	(W) ABOVE GRADE WASTE
COMP. COMPARTMENT	---V---V	(V) VENT
CONT. CONTINUATION	---AV---AV	(AV) ACID VENT
CU CUBIC	---RD---	(RD) RAIN DRAIN
DF DRINKING FOUNTAIN	---OD---	(OD) OVERFLOW RAIN DRAIN
DI DEIONIZED (WATER)	---FDC---	(FDC) FIRE DEPARTMENT CONNECTION
DIA. DIAMETER	---A---	(A) COMPRESSED AIR
ELEV. ELEVATION	---PHW---	(PHW) PROCESS HOT WATER
EWC ELECTRIC WATER COOLER	---PCW---	(PCW) PROCESS COLD WATER
FD FLOOR DRAIN	---VAC---	VACUUM
FDC FIRE DEPARTMENT CONNECTION	---G---	(G) NATURAL GAS
F.F. FINISH FLOOR	---F---	(F) FIRE WATER
FLG. FLANGE	---GW---	(GW) GREASE WASTE
FT FOOT / FEET	---AW---	(AW) ACID WASTE
G GAS		
GA. GALVANIZED		
GALV. GALVANIZED		
GPM GALLONS PER MINUTE		
G.V. GATE VALVE		
HP HORSEPOWER		
HR. HOUR		
I.E. INVERT ELEVATION		
KW KILOWATT		
LAV LAVATORY		
LBS POUNDS		
MAX. MAXIMUM		
MBH THOUSANDS OF BTUs PER HOUR		
MIN. MINIMUM		
M.J. MECHANICAL JOINT		
N.I.M. NOT IN MECHANICAL		
OS&Y OUTSIDE STEM & YOKE		
PROT. PROTECTION		
PRV PRESSURE REDUCING VALVE		
PSI, PSIG POUNDS PER SQUARE INCH		
P/T PRESSURE / TEMPERATURE		
REQ'D REQUIRED		
RBP REDUCED PRESSURE BACKFLOW PREVENTER		
RPM REVOLUTIONS PER MINUTE		
TYP. TYPICAL		
UR URINAL		
VTR VENT THROUGH ROOF		
WC WATER CLOSET		

 EQUIPMENT MARK NUMBER	 PRESSURE/TEMP RELIEF VALVE
 FIXTURE MARK	 BUTTERFLY VALVE
(E) EXISTING	 GAS PRESSURE REGULATING VALVE
 NOTE	 TOP CONNECTION
 CONNECT TO EXISTING	 BOTTOM CONNECTION
 CAP	 PIPE TURNED UP, PIPE TURNED DOWN
 TEE	 GATE VALVE
 ELBOW	 BALL VALVE
 CLEANOUT	 BALANCING VALVE
		 CHECK VALVE
		 UNION
		 DOUBLE CHECK ASSEMBLY

PLUMBING CONNECTION SCHEDULE

MARK	FIXTURE	W	V	CW	HW	REMARKS
DS-1	DOWNSPOUT					SEE 1/P6.01

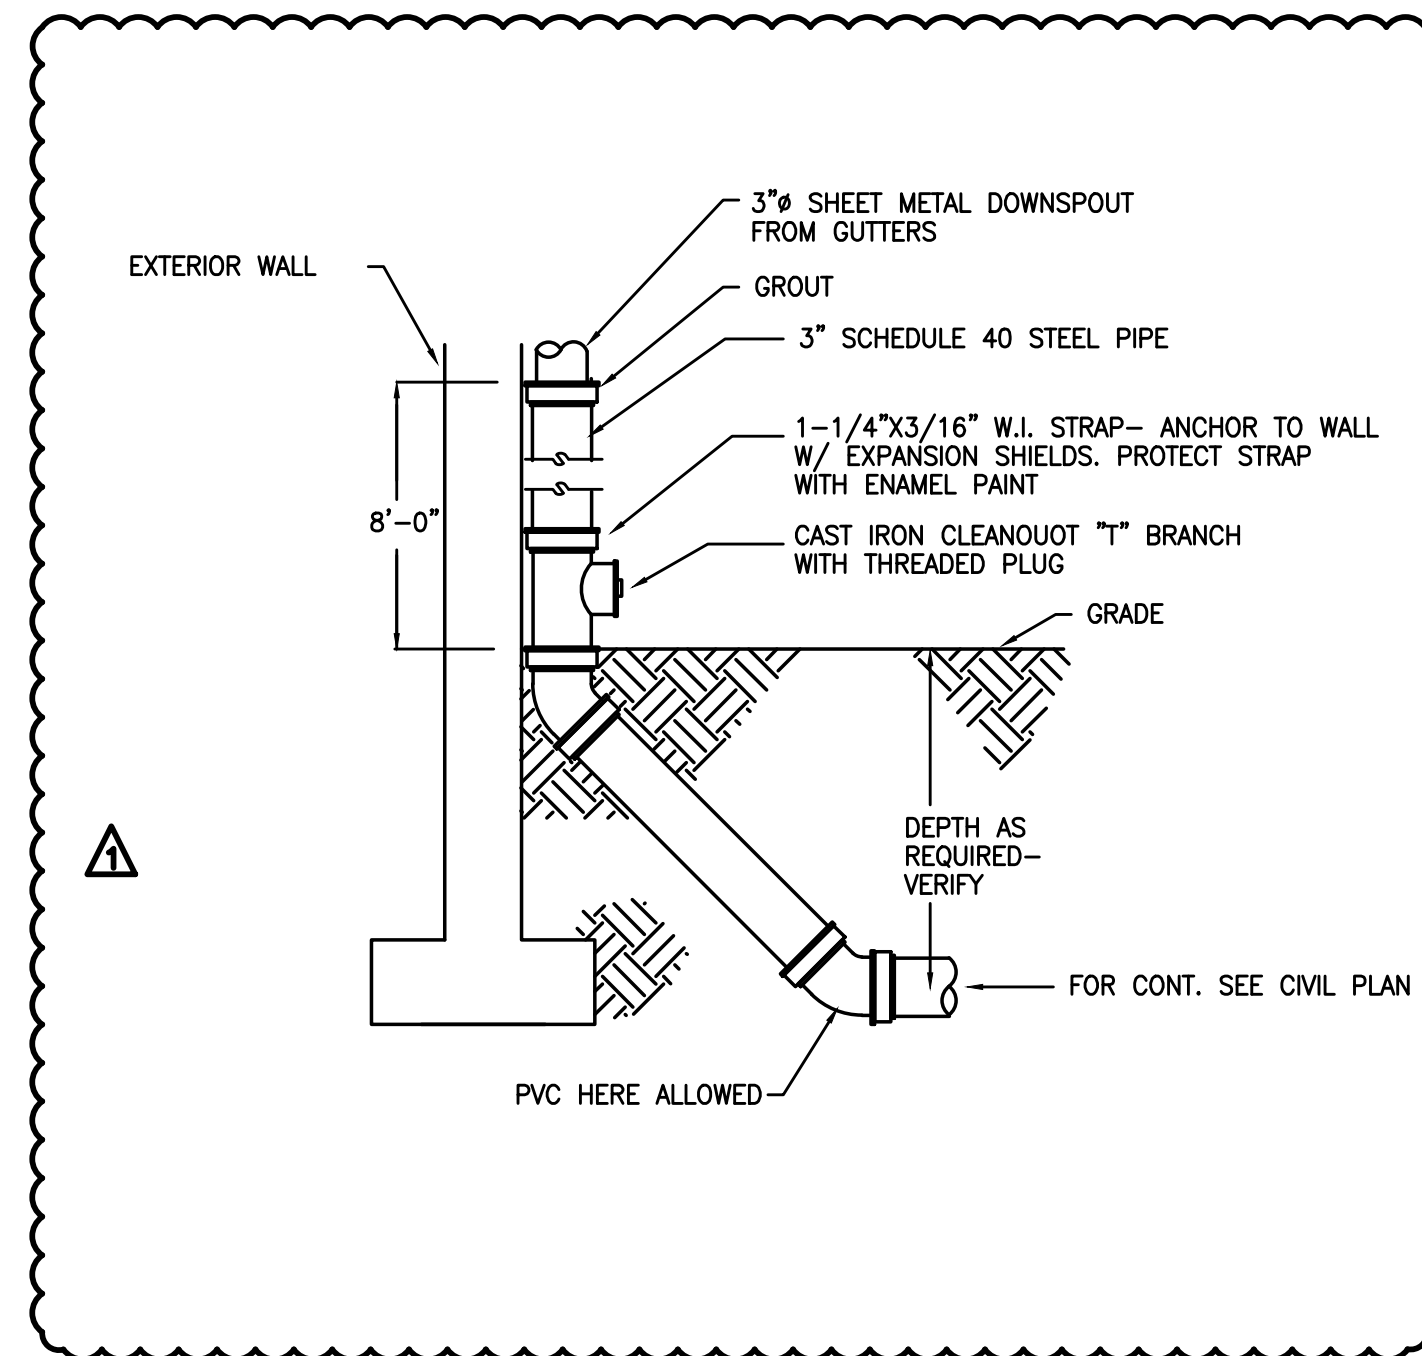

City Of Bend Approval Stamp:

#	Date	Description
1	2/19/18	DISTRICT REVIEW COMMENTS


BID SET

PILOT BUTTE MIDDLE SCHOOL - BUILDING A
 1501 NE Neff Road
 Bend OR 97701

BLRB architects

Drawing Title:
PLUMBING LEGEND AND SCHEDULES

Date :	02.19.2018	Drawn By :	TB
Revised Date :		Project No. :	17.34B
Stamp :		Sheet No. :	

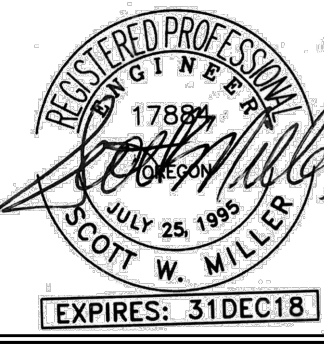


P6.01

1 2 3 4 5 6

A
B
C
D
E
F
G
H
J
K

City Of Bend Approval Stamp:

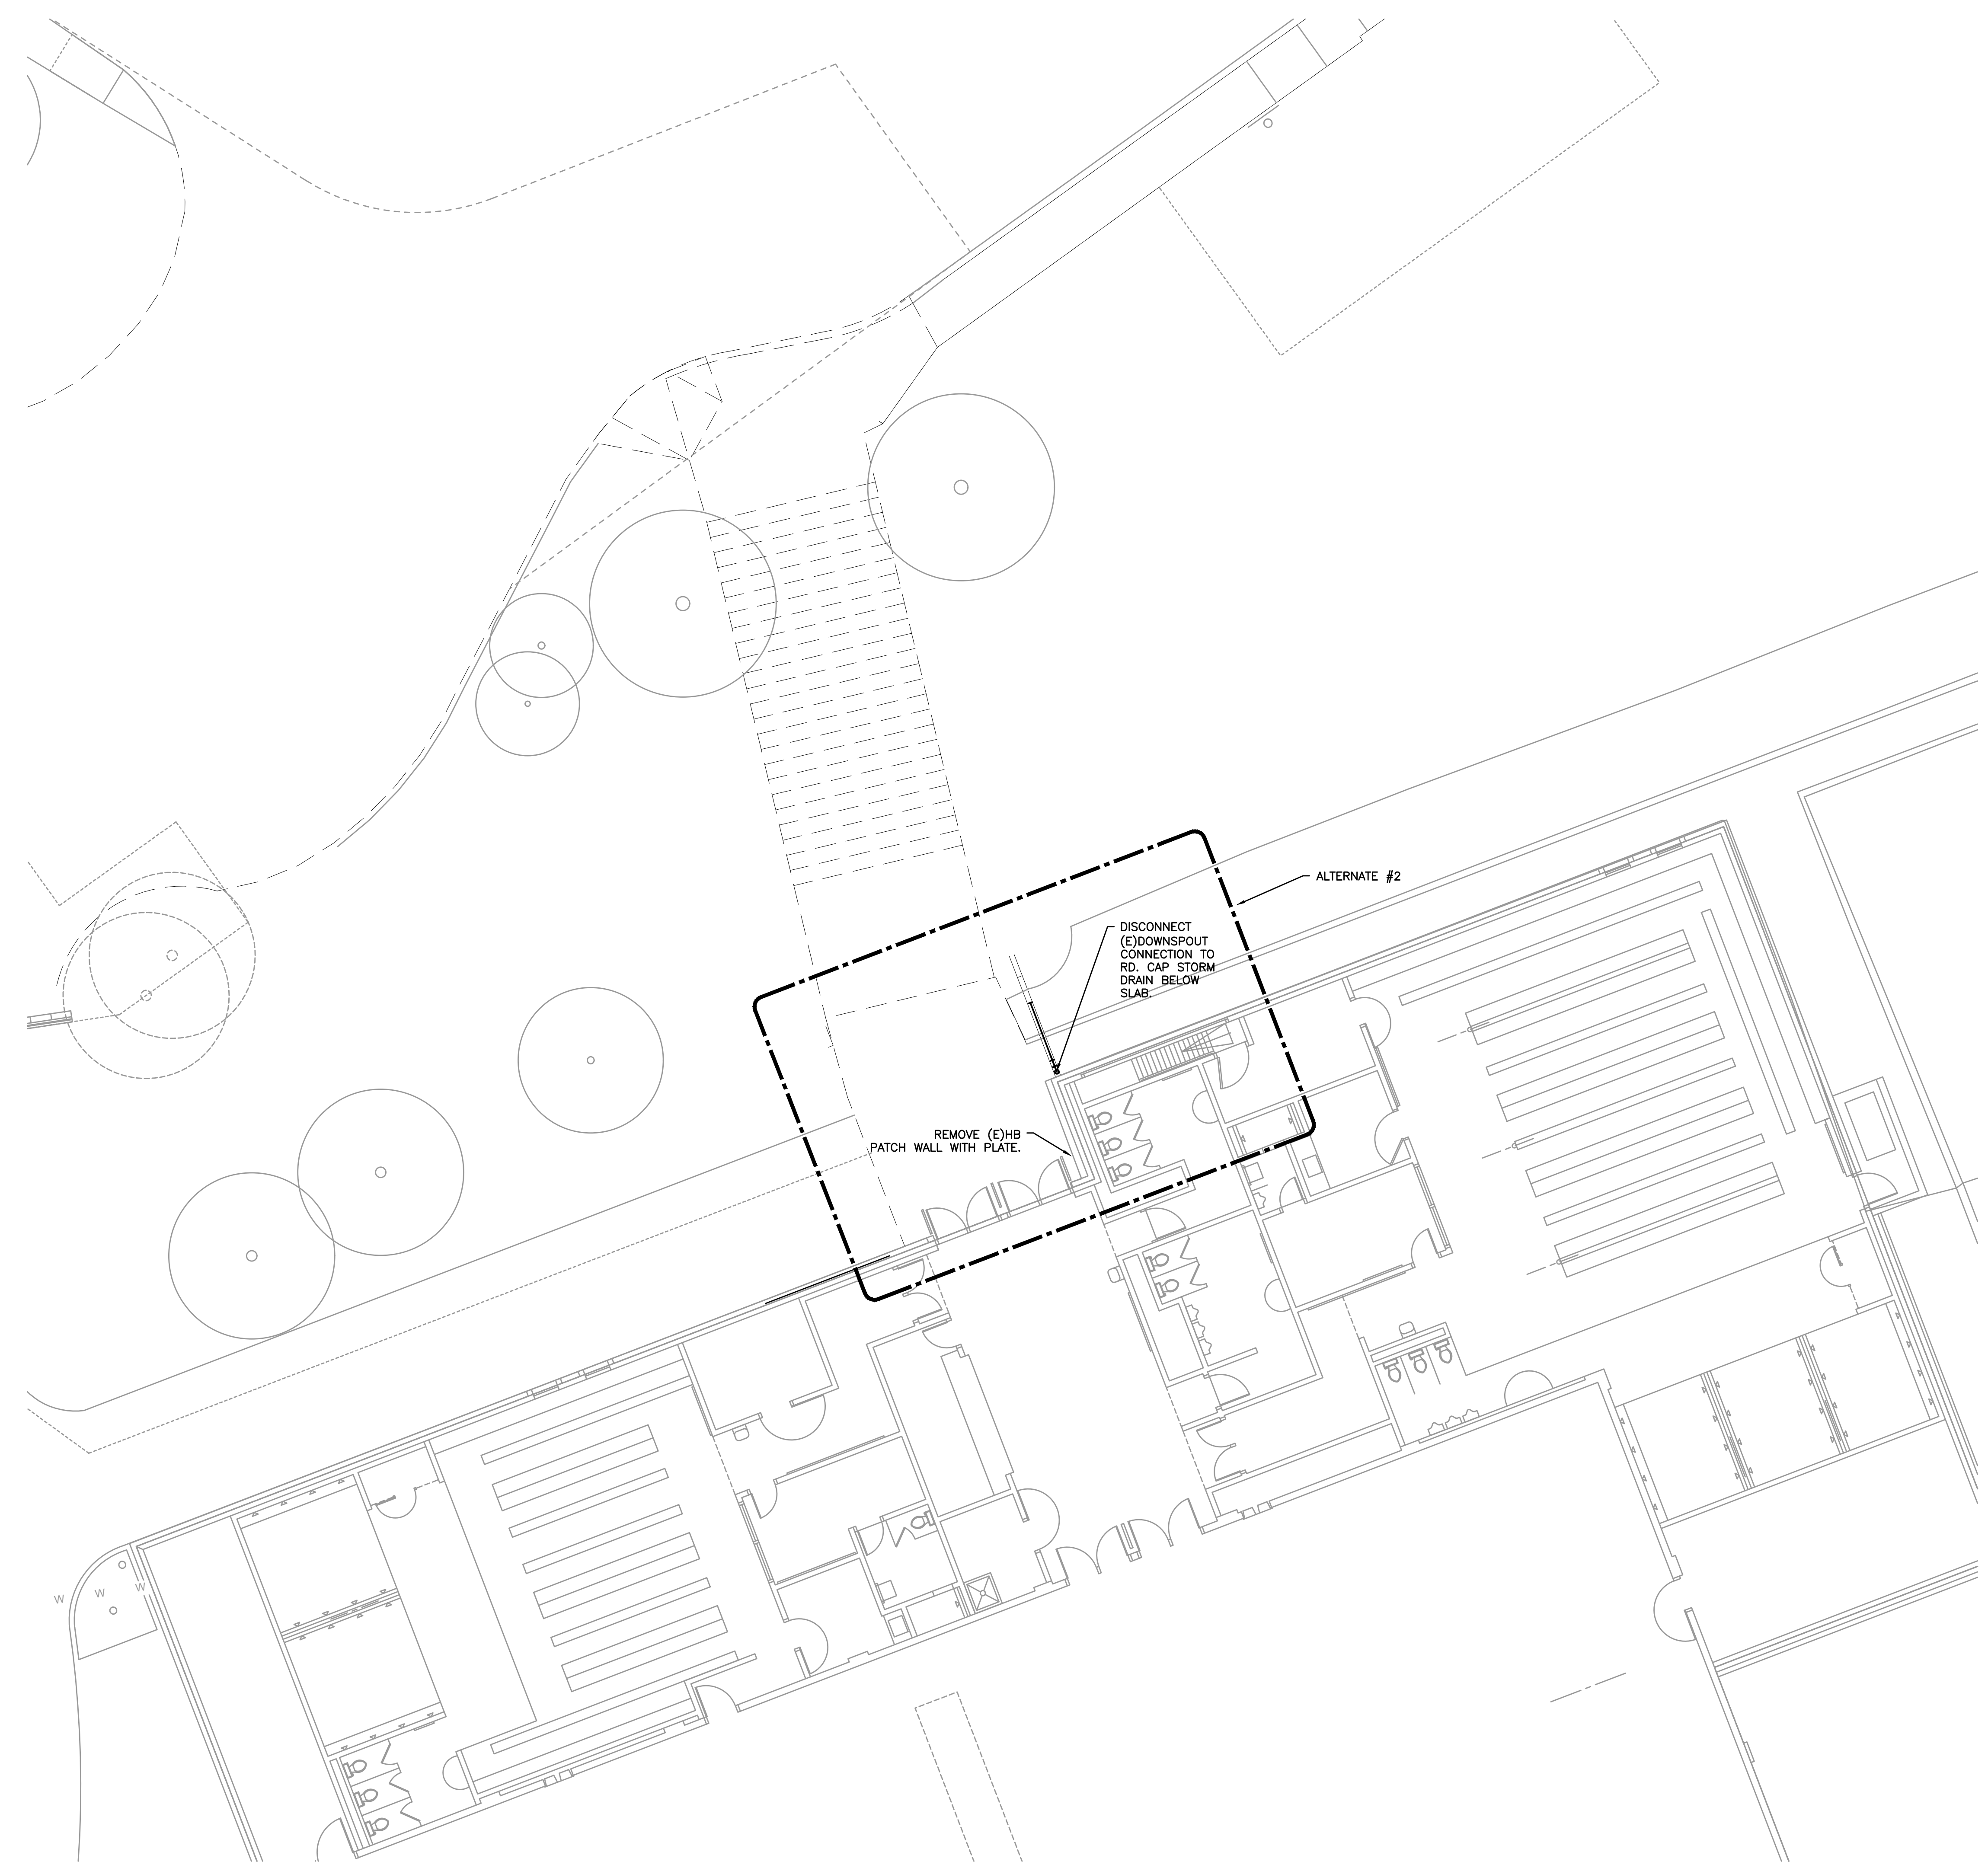

#	Date	Description
1	2/19/18	DISTRICT REVIEW COMMENTS

Revision Schedule

BID SET

PILOT BUTTE MIDDLE SCHOOL - BUILDING A
 1501 NE Neff Road
 Bend OR 97701


BLRB architects

Drawing Title:
PLUMBING DEMO PLAN - BUILDING A

Date :	02.19.2018	Drawn By :	TB
Revised Date :		Project No. :	17.34B
Stamp :		Sheet No. :	

1 PLUMBING DEMO PLAN — BUILDING A
 PD2.01 SCALE: 1/8"=1'-0"

M E I A
 Consulting Engineers
 2007 S.E. Ash St.
 Portland, OR 97214
 PHN: (503) 234-0548
 FAX: (503) 234-0677
 WWW.MEIA-ENG.COM
 CONTACT: TAKAKO BAKER

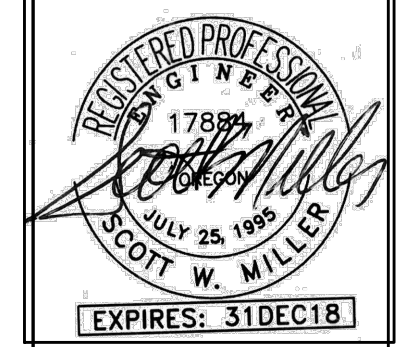

PD2.01