


KEY PLAN



PARTIAL FLOOR PLAN - HVAC  
M2.4 SCALE: 1/8"=1'-0"

- KEYED NOTES
- 1. DEDICATED 120V CIRCUIT FOR CONTROLS. SEE SPECIFICATION SECTION 555 FOR ADDITIONAL INFORMATION.
  - 2. SEE SHEET M2.2 FOR CONTINUATION.
  - 3. CONNECT 4" ALUMINUM VENT TO DRYER. RUN VENT THROUGH ROOF TO VENT CAP.
  - 4. SEE SHEET M2.3 FOR CONTINUATION.

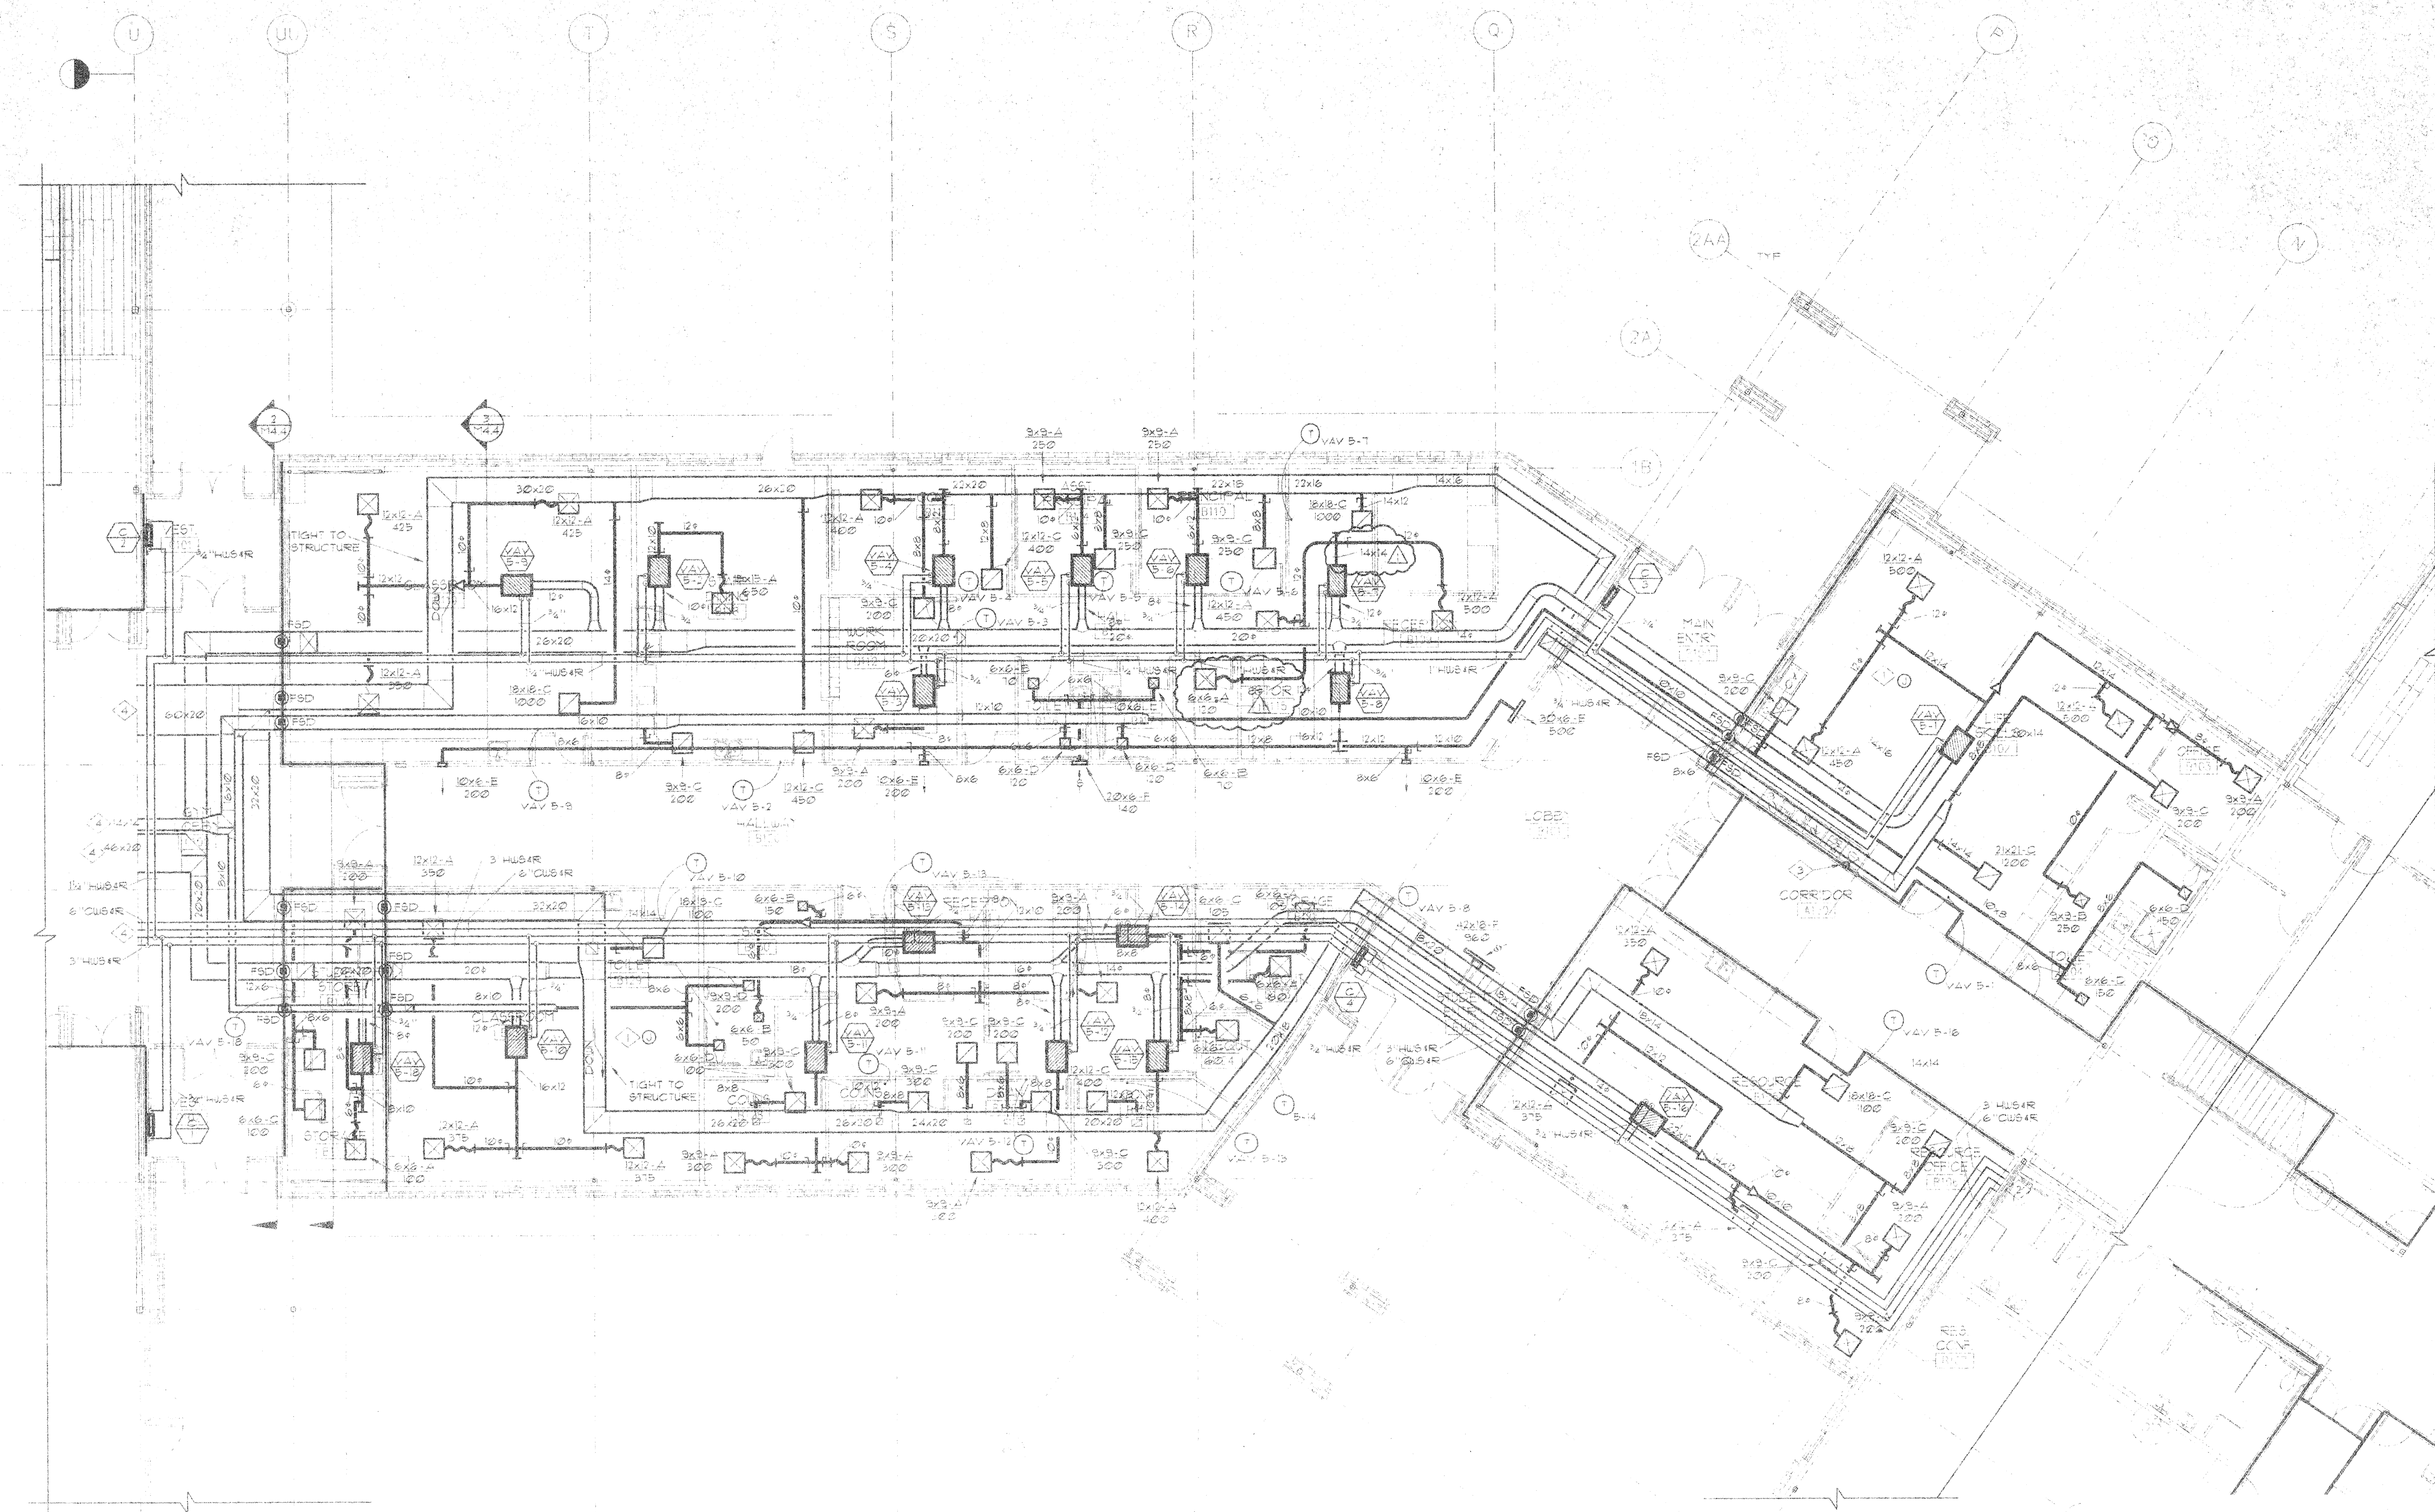