


ACCESS CONTROL NOTES

1. 12"x12"x6" NEMA BOX, HOFFMAN OR APPROVED EQUAL ON SECURED SIDE OF DOOR. TERMINATE (2) CATEGORY 6 CABLES INSIDE NEMA ENCLOSURE. SCHOOL DISTRICT WILL SUPPLY "POE" DOOR CONTROLLER.
2. DOOR STATUS CONTACT, ONLY NEEDED WHEN STRIKE DOES NOT HAVE INTEGRAL SWITCH.
3. DOUBLE GANG BOX WITH SINGLE GANG REDUCER RING IF NEEDED BY SECURITY DEVICE. COORDINATE WITH ARCHITECT TO MEET ADA REQUIREMENTS. PROVIDE 24AWG, 12 CONDUCTOR TO DOOR CONTROLLER.
4. "REX" ONLY NEEDED AT LOCATIONS WITH ELECTRIC STRIKE (CONFIRM WITH DOOR HARDWARE). PROVIDE 18AWG, 6 CONDUCTOR TO DOOR CONTROLLER.
5. 3/4" CONDUIT CONCEALED IN WALL WITH 16AWG 6 CONDUCTOR TO CRASH BAR OR ELECTRIC STRIKE.

2 ACCESS CONTROL DETAIL
T2.1 SCALE: NOT TO SCALE

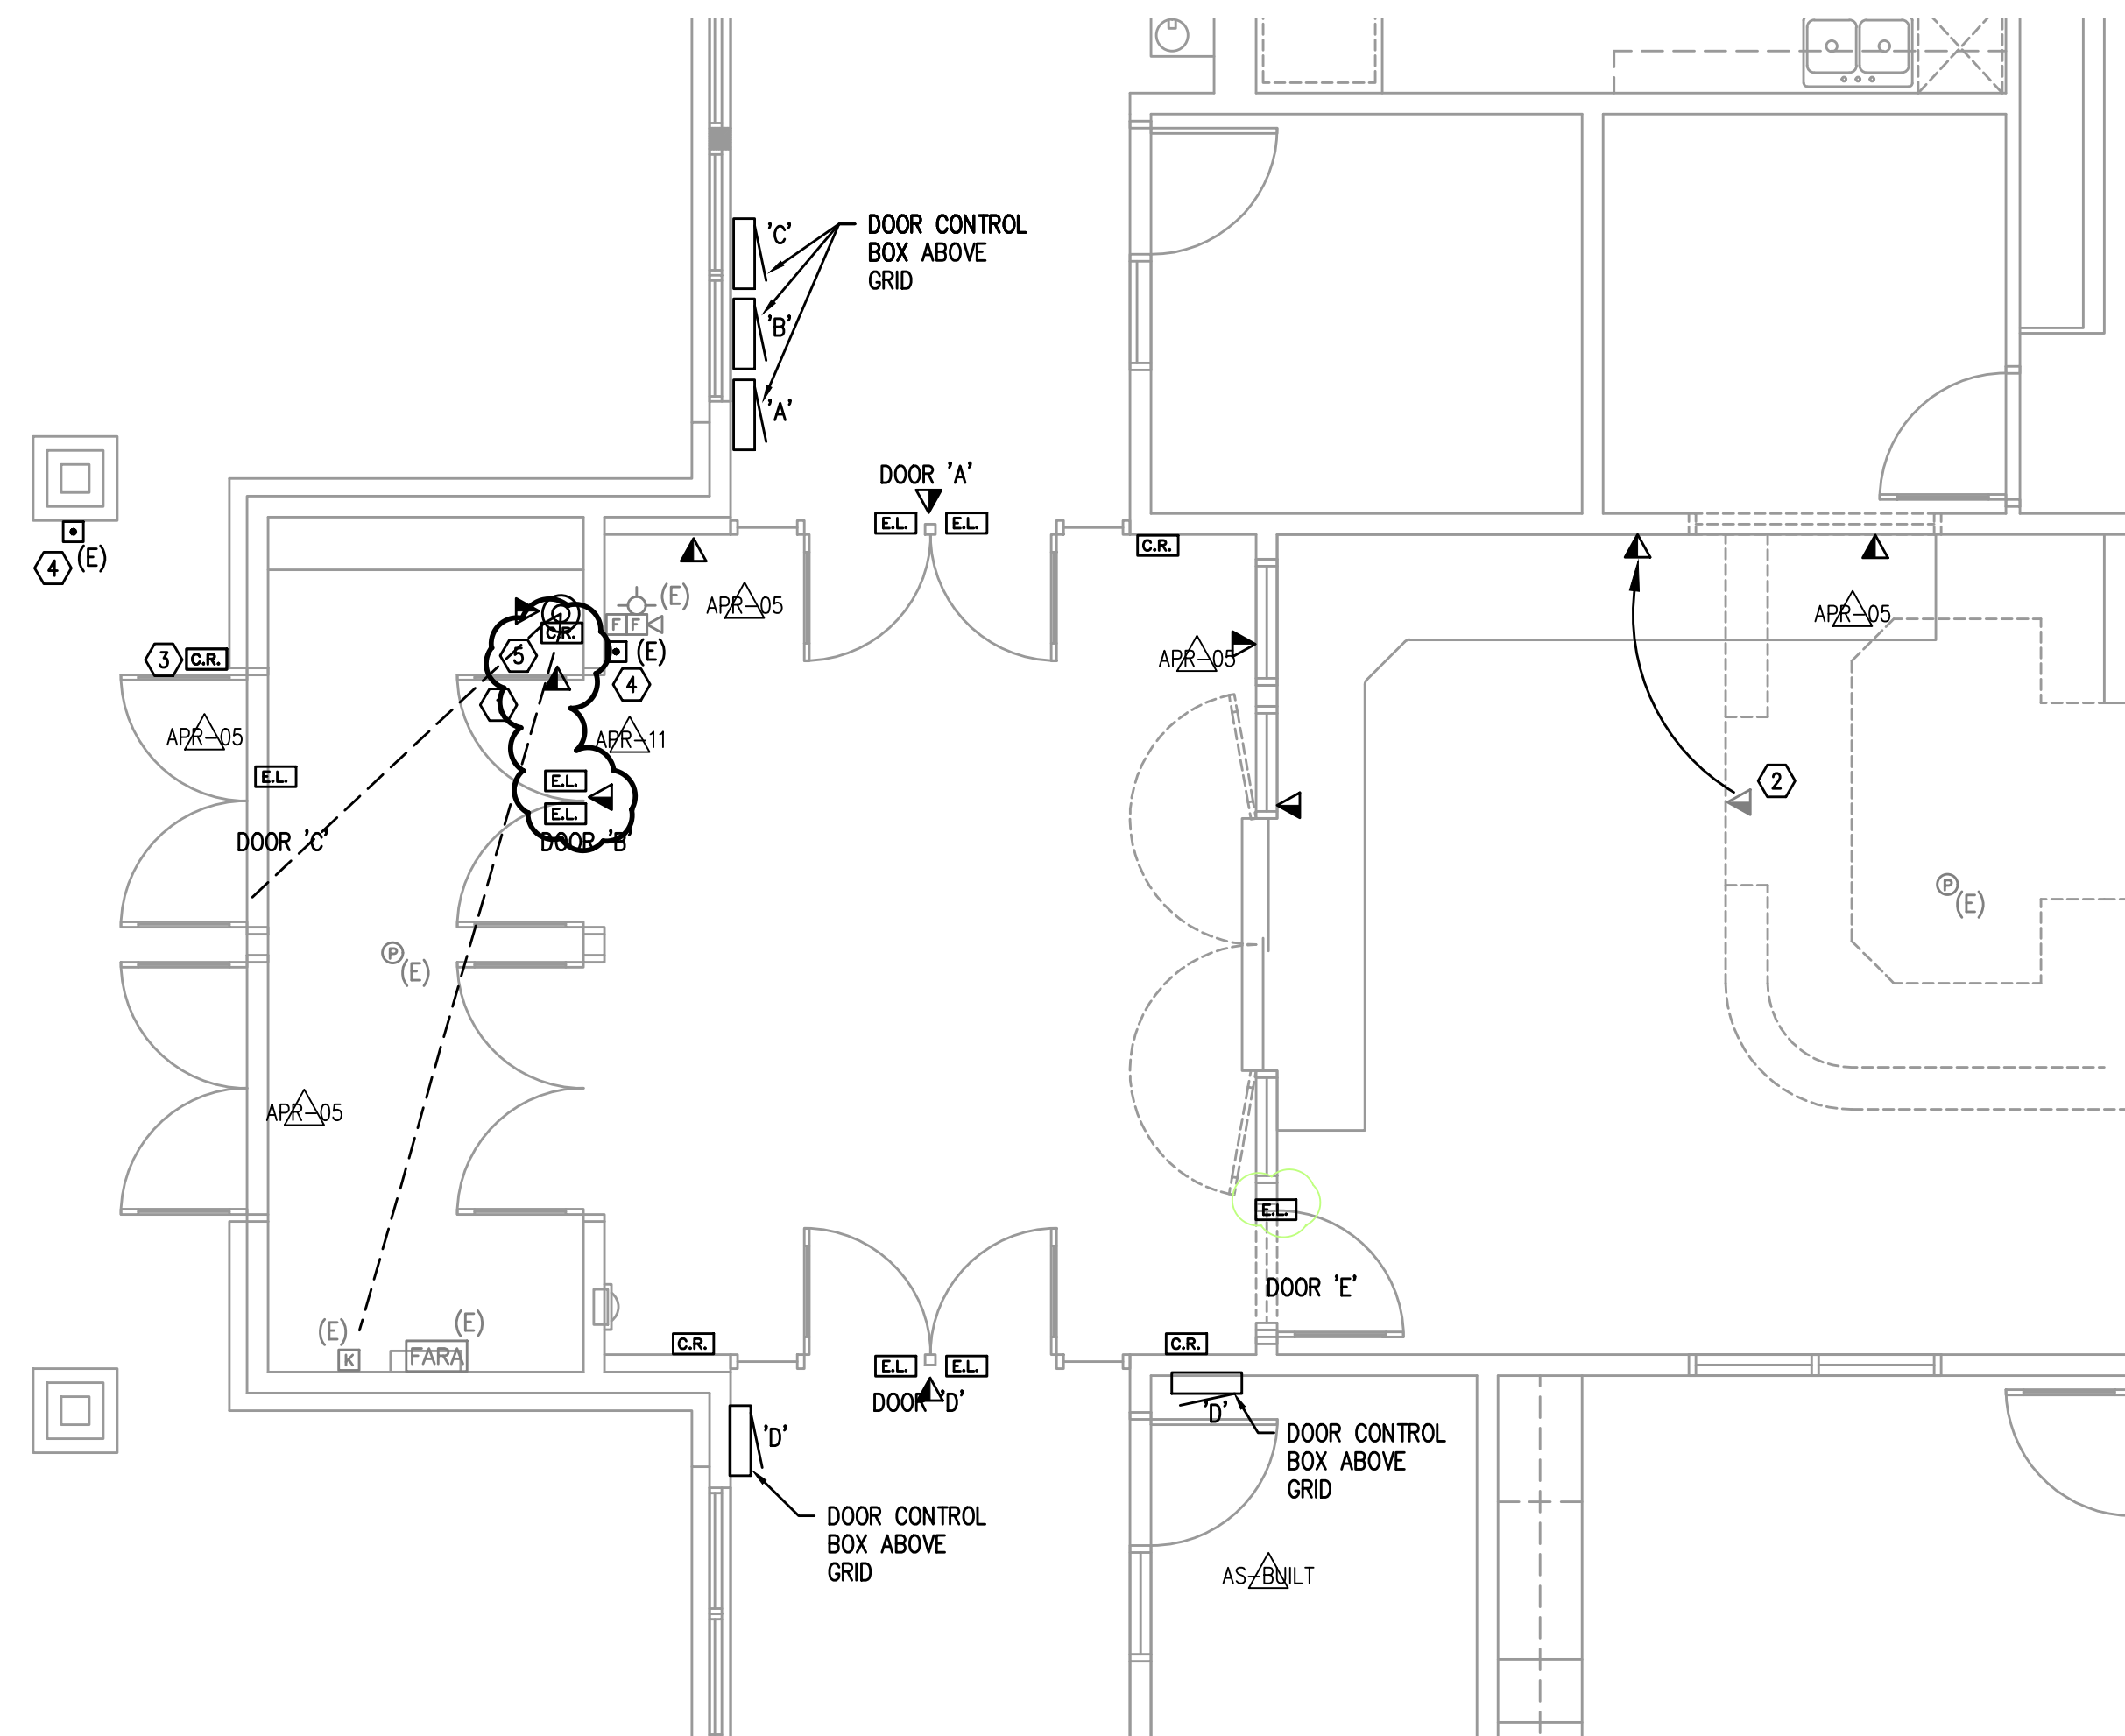

1
T2.1 ENLARGED FLOOR PLAN — TELCOM
SCALE: 1/4" = 1'-0"

NOTES:

1. APPROXIMATE VIEW REQUIRED OF CAMERA, VERIFY PROPER FRAMING OF VIEW WITH STAFF AT TIME OF INSTALLATION. PROVIDE (2) CATEGORY 6 CABLES FROM NEAREST MDF/IDF.
2. RELOCATE DATA OUTLET, TERMINATE, AND TEST.
3. ROUGH-IN FOR CARD READER IS EXISTING.
4. EXISTING ADA DOOR OPENER BUTTON.

5. PROVIDE 'TALKAPHONE MODEL VOIP-200C' INTERCOM CALL BUTTON AND (2) CATEGORY 6 CABLEING TO NEAREST MDF/IDF, TERMINATE TO PATCH PANEL FOR SCHOOL DISTRICT CONNECTION.

RECORD DRAWING:

THIS DRAWING HAS BEEN UPDATED TO REFLECT CHANGES MADE DURING CONSTRUCTION BASED UPON INFORMATION FURNISHED TO THE ENGINEER BY THE INSTALLATION CONTRACTOR. NO WARRANTY EITHER EXPLICIT OR IMPLIED IS GIVEN BY MFIA, INC. AS TO THE ACCURACY AND/OR COMPLETENESS OF THIS INFORMATION.

TBB

A R C H I T E C T S
1160 SW Simpson Ave. - Suite 100 - Bend, Oregon 97702
t 541.382.5535 | f 541.389.8033

Bend-La Pine Schools SECURITY UPGRADES
Ponderosa Elementary School

**3790 NE Purcell Blvd
Bend, Oregon 97701**

ISSUED:	DATE:
PERMIT SET / BID SET	02/14/18
CONFORMANCE SET	03/28/18
APR-05	05/15/18
APR-11	06/08/18
AS-BUILT	09/04/18

JOB NUMBER:	1708
DRAWN BY:	GMA
CHECKED BY:	RLC

SHEET TITLE

ENLARGED
FLOOR PLAN
TELCOM

SHEET NUMBER

T2.1