



Copyright © 2017 BBT Architects
Bend-La Pine Schools Security Upgrades
Pine Ridge Elementary School
19840 Hollygrape Street
Bend, Oregon 97702
t 541.382.5535 | f 541.389.8033

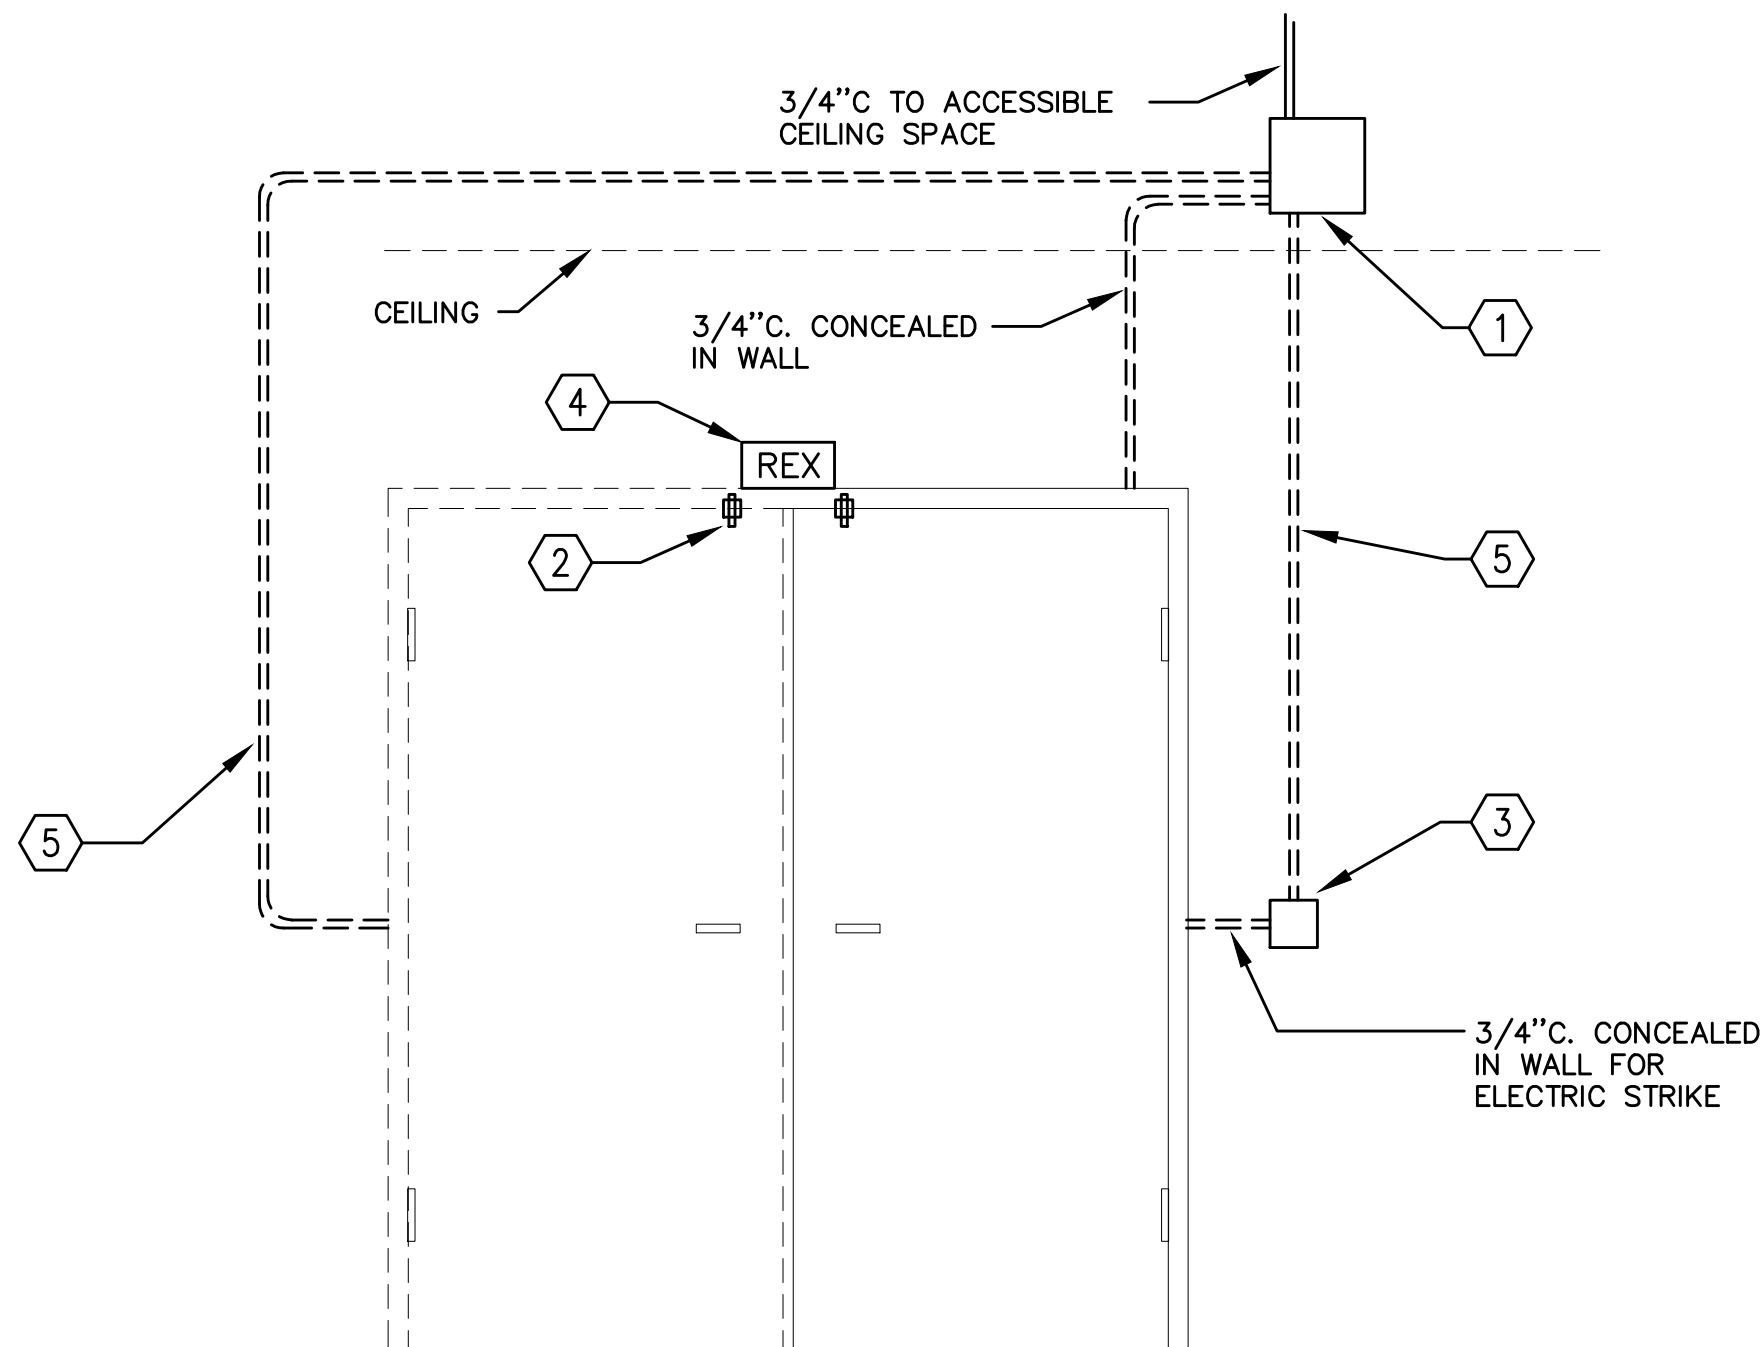

ACCESS CONTROL NOTES

1. 12"x12"x6" NEMA BOX, HOFFMAN OR APPROVED EQUAL, ON SECURED SIDE OF DOOR. TERMINATE (2) CATEGORY 6 CABLES INSIDE NEMA ENCLOSURE. SCHOOL DISTRICT WILL SUPPLY 'POE' DOOR CONTROLLER.
2. DOOR STATUS CONTACT, ONLY NEEDED WHEN STRIKE DOES NOT HAVE INTEGRAL SWITCH.
3. DOUBLE GANG BOX WITH SINGLE GANG REDUCER RING IS NEEDED BY SECURITY DEVICE. COORDINATE WITH ARCHITECT TO MEET ADA REACH RANGE. PROVIDE 24AWG, 12 CONDUCTOR TO DOOR CONTROLLER.
4. 'REX' ONLY NEEDED AT LOCATIONS WITH ELECTRIC STRIKE (CONFIRM WITH DOOR HARDWARE). PROVIDE 18AWG, 6 CONDUCTOR TO DOOR CONTROLLER.
5. 3/4" CONDUIT CONCEALED IN WALL WITH 16AWG 6 CONDUCTOR TO CRASH BAR OR ELECTRIC STRIKE.

2 ACCSS CONTROL DETAIL
T2.1 SCALE: NOT TO SCALE

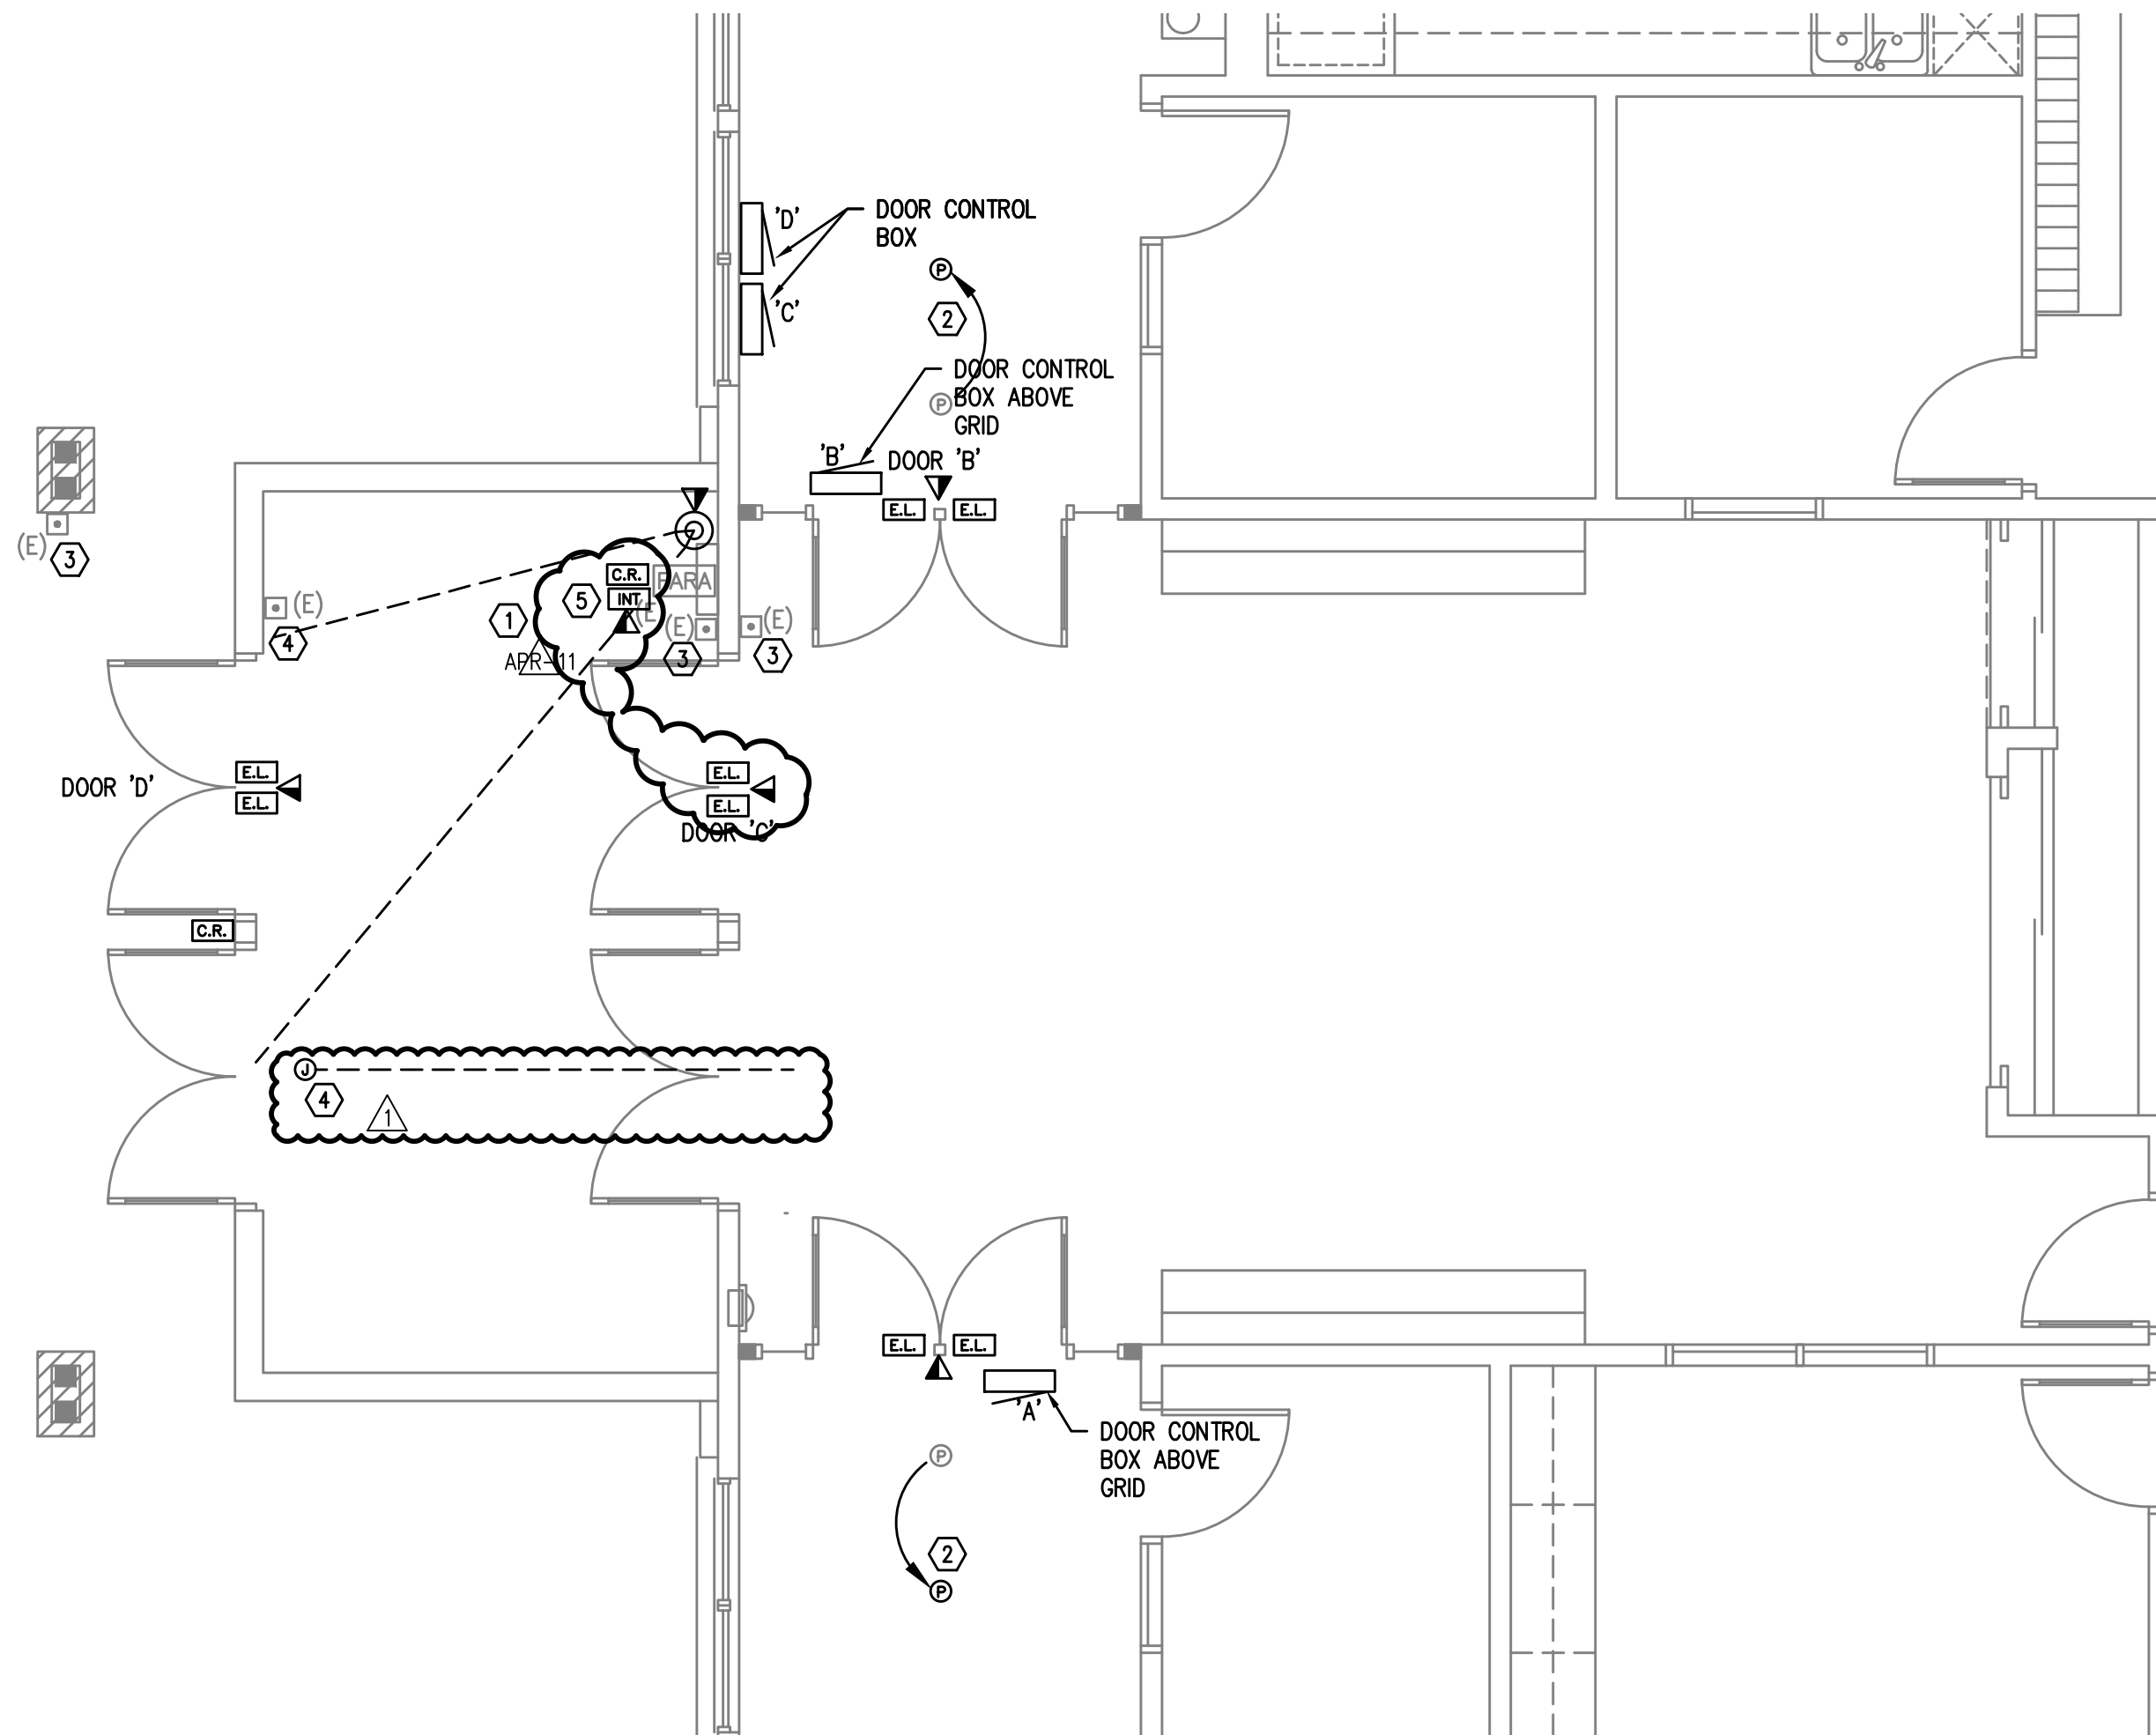

1 ENLARGED FLOOR PLAN - TELCOM
T2.1 SCALE: 1/4" = 1'-0"

NOTES:

1. APPROXIMATE VIEW REQUIRED OF CAMERA, VERIFY PROPER FRAMING OF VIEW WITH STAFF AT TIME OF INSTALLATION. PROVIDE (2) CATEGORY 6 CABLES FROM NEAREST MDF/IDF.
2. SMOKE DETECTORS NEED TO BE REMOVED, RELOCATED AND REINSTALLED FOR LIGHTING CHANGES TAKING PLACE.
3. EXISTING ADA DOOR OPENER BUTTON.

4. SINGLE GANG JUNCTION BOX WITH 3/4" CONDUIT TO ACCESSIBLE CEILING SPACE FOR FUTURE LOCK DOWN SYSTEM.
5. PROVIDE 'TALKPHONE MODEL VOIP-200C' INTERCOM CALL BUTTON AND (2) CATEGORY 6 CABLEING TO NEAREST MDF/IDF, TERMINATE TO PATCH PANEL FOR SCHOOL DISTRICT CONNECTION.

RECORD DRAWING:

THIS DRAWING HAS BEEN UPDATED TO REFLECT CHANGES MADE DURING CONSTRUCTION BASED UPON INFORMATION FURNISHED TO THE ENGINEER BY THE INSTALLATION CONTRACTOR. NO WARRANTY EITHER EXPLICIT OR IMPLIED IS GIVEN BY MFIA, INC. AS TO THE ACCURACY AND/OR COMPLETENESS OF THIS INFORMATION.

Bend-La Pine Schools SECURITY UPGRADES
Pine Ridge Elementary School
19840 Hollygrape Street
Bend, Oregon 97702

ISSUED:	DATE:
PERMIT SET / BID SET	02/14/18
CONFORMANCE SET	03/28/18
APR-11	06/08/18
AS-BUILT	09/04/18

JOB NUMBER:	1708
DRAWN BY:	GMA
CHECKED BY:	RLC

SHEET TITLE
ENLARGED
FLOOR PLAN
TELCOM

SHEET NUMBER

T2.1