


ACCESS CONTROL NOTES

1. 12"x12"x6" NEMA BOX, HOFFMAN OR APPROVED EQUAL, ON SECURED SIDE OF DOOR. TERMINATE (2) CATEGORY 6 CABLES INSIDE NEMA ENCLOSURE. SCHOOL DISTRICT WILL SUPPLY 'POE' DOOR CONTROLLER.
2. DOOR STATUS CONTACT, ONLY NEEDED WHEN STRIKE DOES NOT HAVE INTEGRAL SWITCH.
3. DOUBLE GANG BOX WITH SINGLE GANG ~~REDUCER RING IF NEEDED~~ BY SECURITY DEVICE. COORDINATE WITH ARCHITECT TO MEET ADA REACH RANGE. PROVIDE 24AWG, 12 CONDUCTOR TO DOOR CONTROLLER.
4. 'REX' ONLY NEEDED AT LOCATIONS WITH ELECTRIC STRIKE (CONFIRM WITH DOOR HARDWARE). PROVIDE 18AWG, 6 CONDUCTOR TO DOOR CONTROLLER.
5.  $\frac{3}{4}$ " CONDUIT CONCEALED IN WALL WITH 16AWG 6 CONDUCTOR TO CRASH BAR OR ELECTRIC STRIKE.

2 ACCSS CONTROL DETAIL  
T2 1 SCALE: NOT TO SCALE

SCALE: NOT TO SCALE

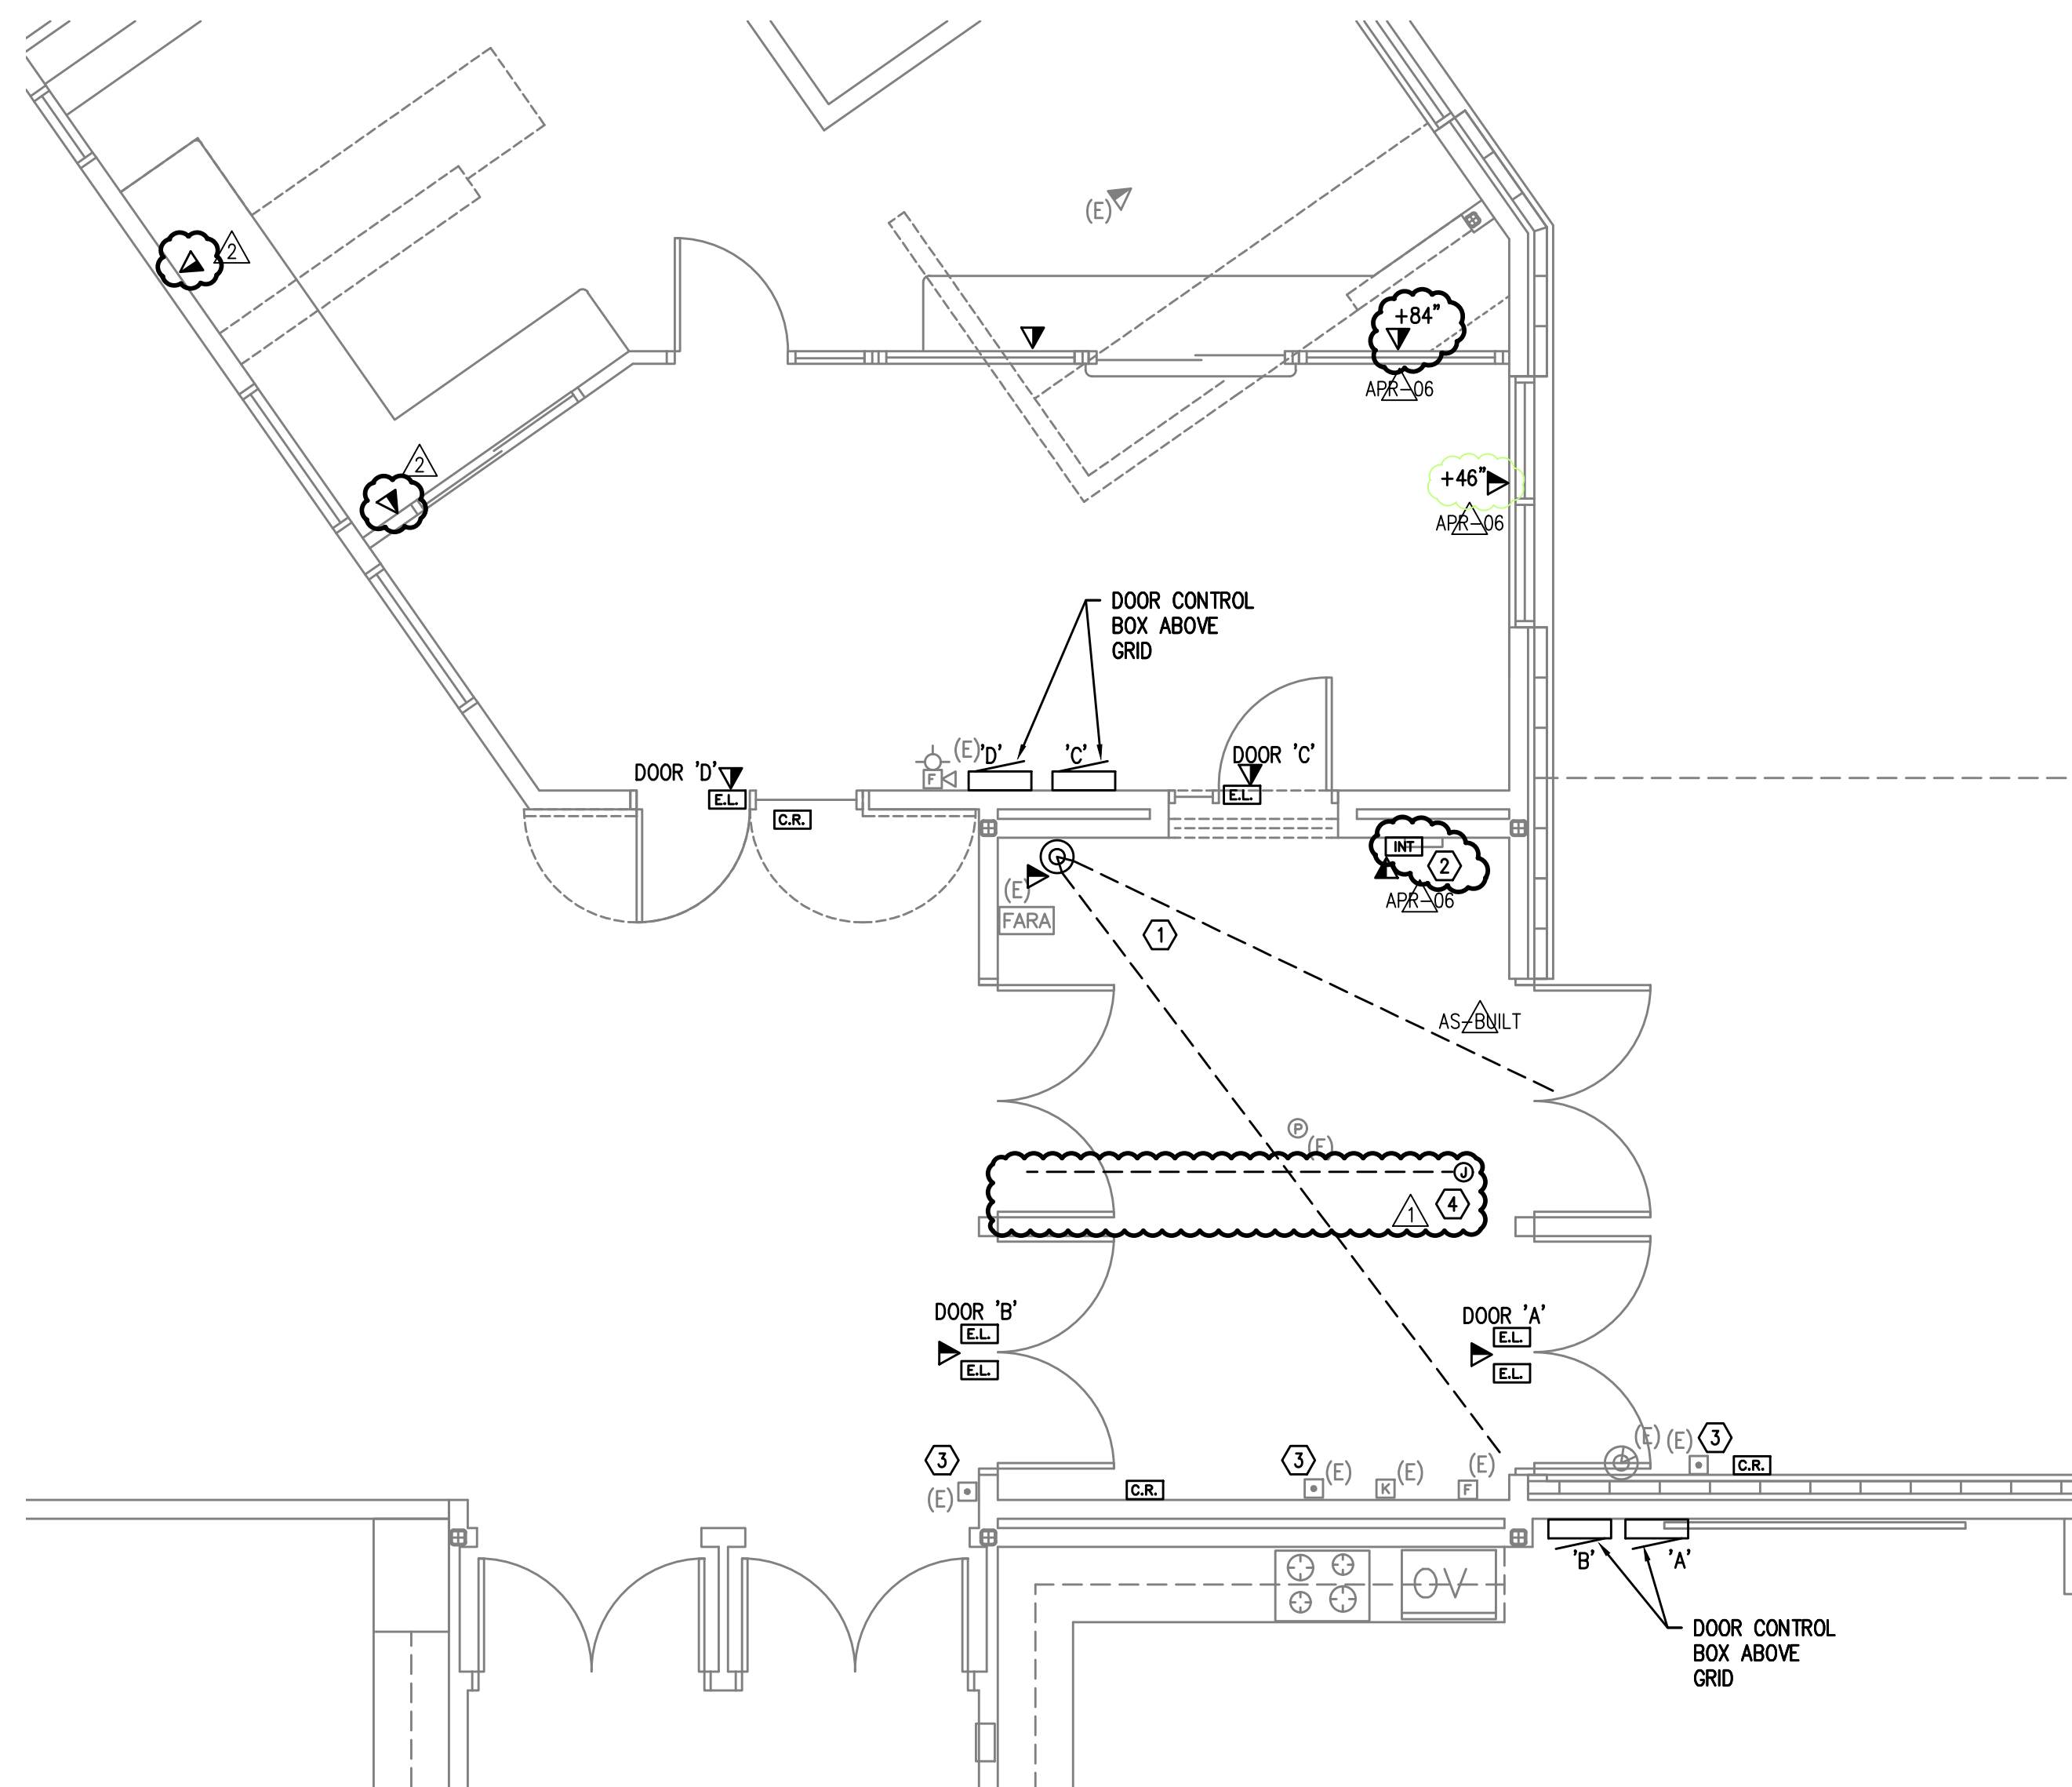

1 ENLARGED FLOOR PLAN - TELCOM  
T2.1 SCALE: 1/4" = 1'-0"

SCALE:  $1/4" = 1'-0"$

⬡ NOTES:

1. APPROXIMATE VIEW REQUIRED OF CAMERA. VERIFY PROPER FRAMING OF VIEW WITH STAFF AT TIME OF INSTALLATION. PROVIDE (2) CATEGORY 6 CABLES FROM NEAREST MDF/IDF.
2. PROVIDE 'TALKPHONE MODEL VOIP-200C' INTERCOM CALL BUTTON AND (2) CATEGORY 6 CABLE TO NEAREST MDF/IDF, TERMINATE TO PATCH PANEL FOR SCHOOL DISTRICT CONNECTION
3. EXISTING ADA DOOR OPENER BUTTON.
4. SINGLE GANG JUNCTION BOX WITH 3/4" CONDUIT TO ACCESSIBLE CEILING SPACE FOR FUTURE LOCK DOWN SYSTEM.

## RECORD DRAWING:

THIS DRAWING HAS BEEN UPDATED TO REFLECT CHANGES MADE DURING CONSTRUCTION BASED UPON INFORMATION FURNISHED TO THE ENGINEER BY THE INSTALLATION CONTRACTOR. NO WARRANTY EITHER EXPLICIT OR IMPLIED IS GIVEN BY MFA, INC. AS TO THE ACCURACY AND/OR COMPLETENESS OF THIS INFORMATION.

# TBB

**A R C H I T E C T S**  
1160 sw Simpson Ave. - Suite 100 - Bend, Oregon 97702  
t 541.382.5535 | f 541.389.8033

## Bend-La Pine Schools SECURITY UPGRADES Sky View Middle School

**63555 NE 18th Street  
Bend, Oregon 97701**

ISSUED:	DATE:
PERMIT SET / BID SET	02/14/18
<u>Δ</u> APR #1	03/28/18
CONFORMANCE SET	03/28/18
APR-06	05/16/18
AS-BUILT	09/04/18

JOB NUMBER:	1708
DRAWN BY:	GMA
CHECKED BY:	RLC

SHEET TITLE

ENLARGED  
FLOOR PLAN  
TELCOM

SHEET NUMBER

## T2.1