



2 ENLARGED FLOOR PLAN – TELCOM

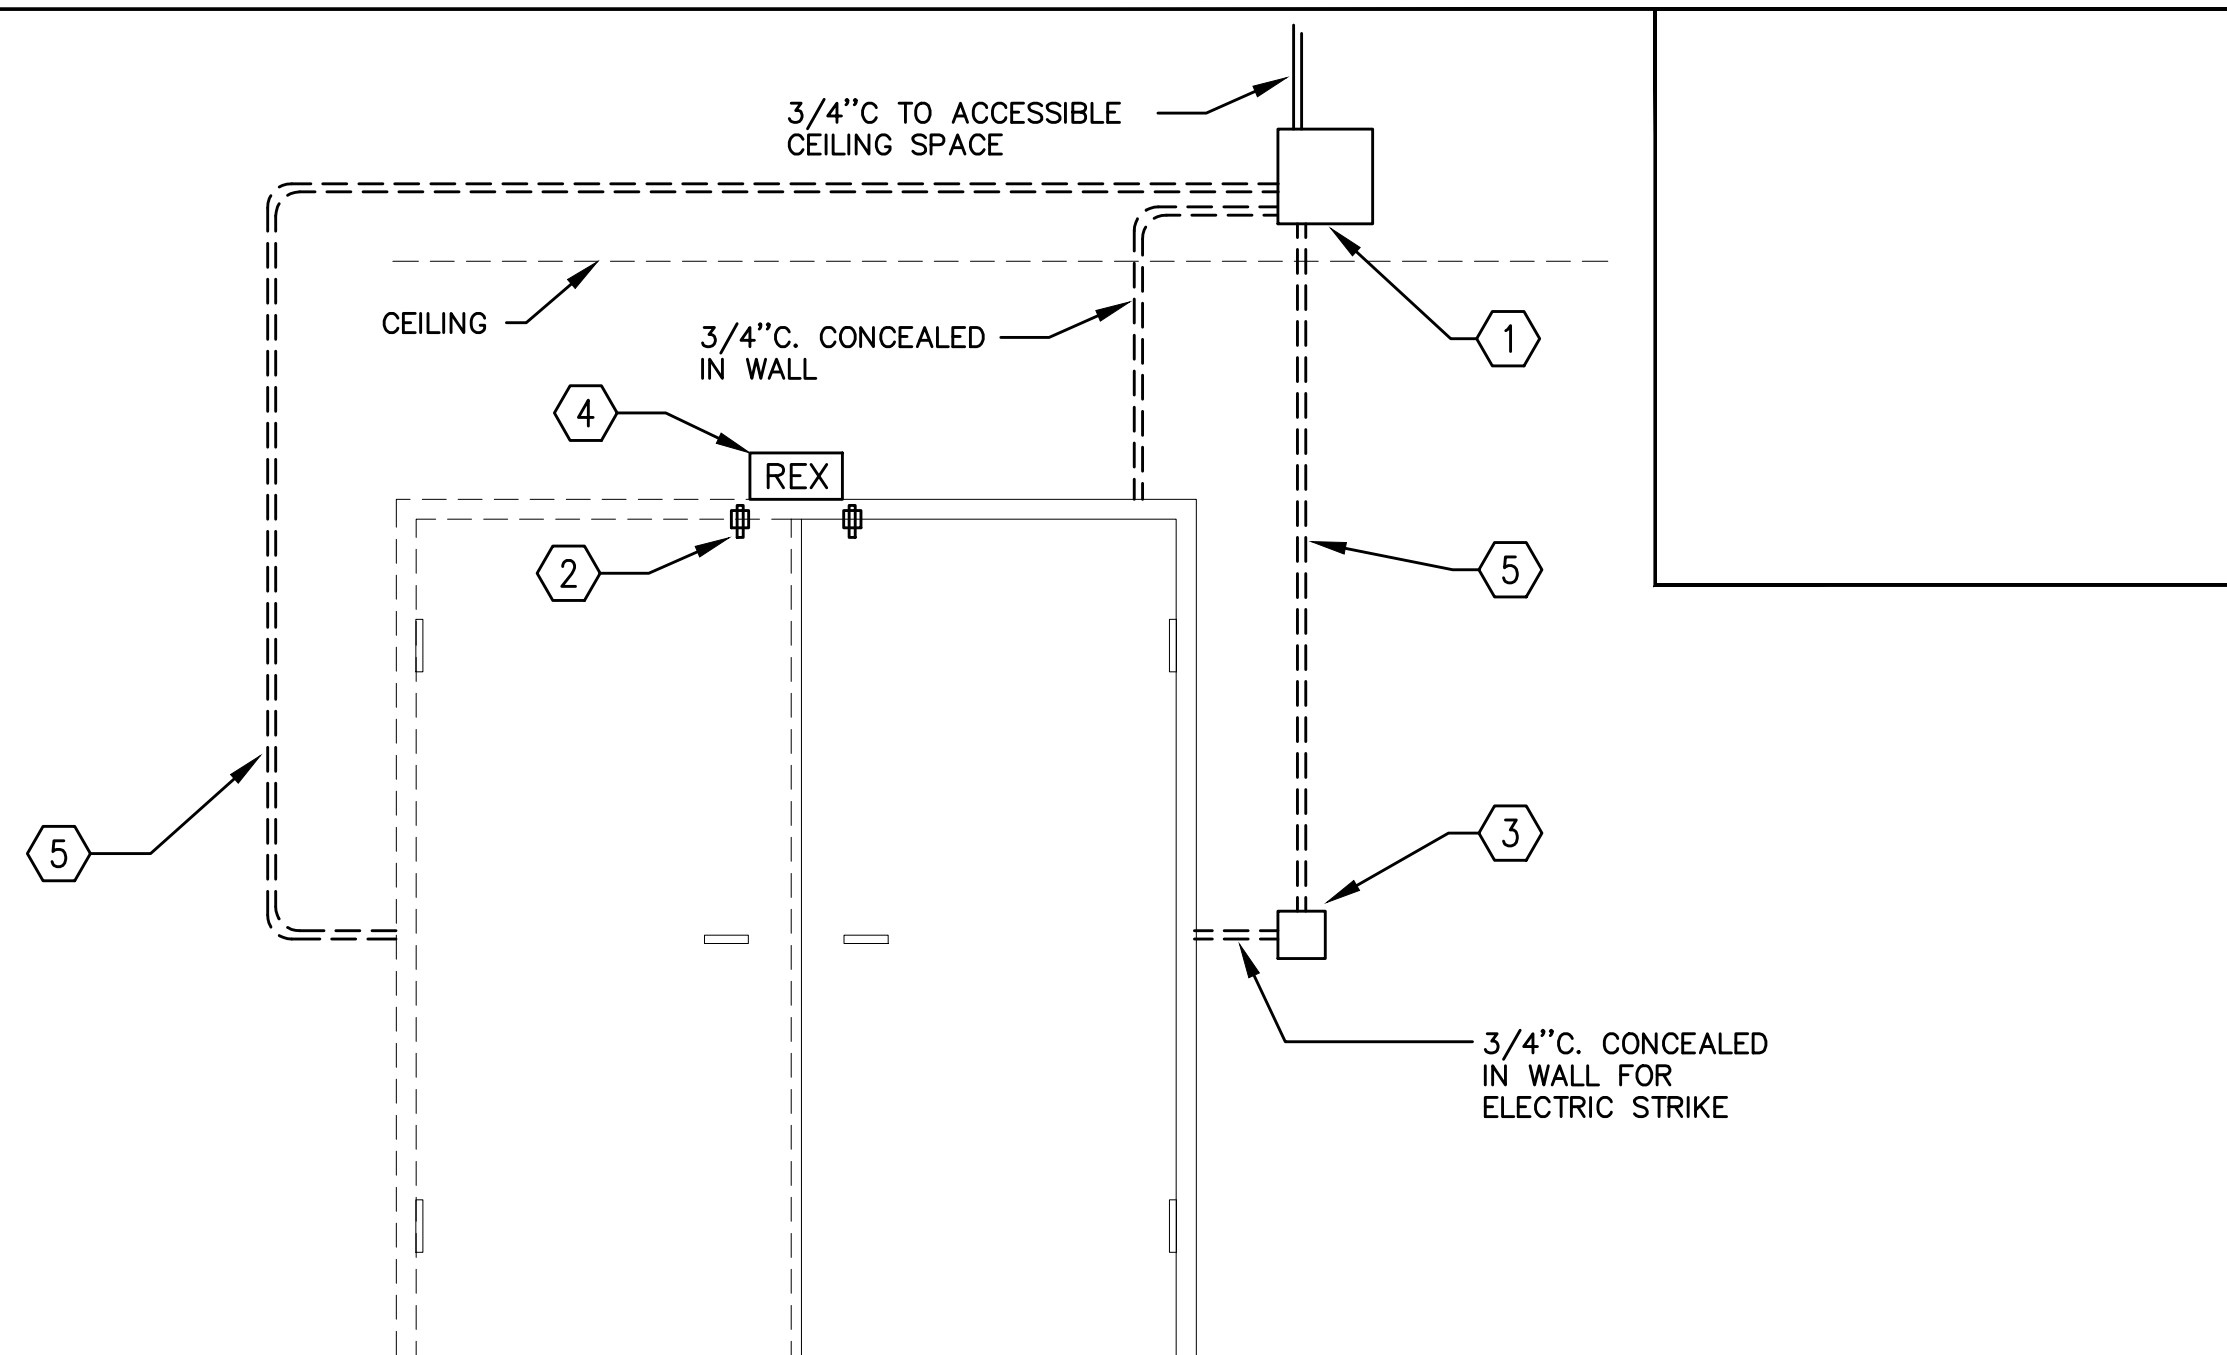

ACCESS CONTROL NOTES

1. 12"x12"x6" NEMA BOX, HOFFMAN OR APPROVED EQUAL, ON SECURED SIDE OF DOOR. TERMINATE (2) CATEGORY 6 CABLES INSIDE NEMA ENCLOSURE. SCHOOL DISTRICT WILL SUPPLY 'POE' DOOR CONTROLLER.
2. DOOR STATUS CONTACT, ONLY NEEDED WHEN STRIKE DOES NOT HAVE INTEGRAL SWITCH.
3. DOUBLE GANG BOX WITH SINGLE GANG ~~REDUCER RING IS NEEDED~~ BY SECURITY DEVICE. COORDINATE WITH ARCHITECT TO MEET ~~ADA REACH RANGE~~. PROVIDE 24AWG, 12 CONDUCTOR TO DOOR CONTROLLER.
4. 'REX' ONLY NEEDED AT LOCATIONS WITH ELECTRIC STRIKE (CONFIRM WITH DOOR HARDWARE). PROVIDE 18AWG, 6 CONDUCTOR TO DOOR CONTROLLER.
5. 3" CONDUIT CONCEALED IN WALL WITH 16AWG 6 CONDUCTOR TO CRASH BAR OR ELECTRIC STRIKE.

2 ACCSS CONTROL DETAIL

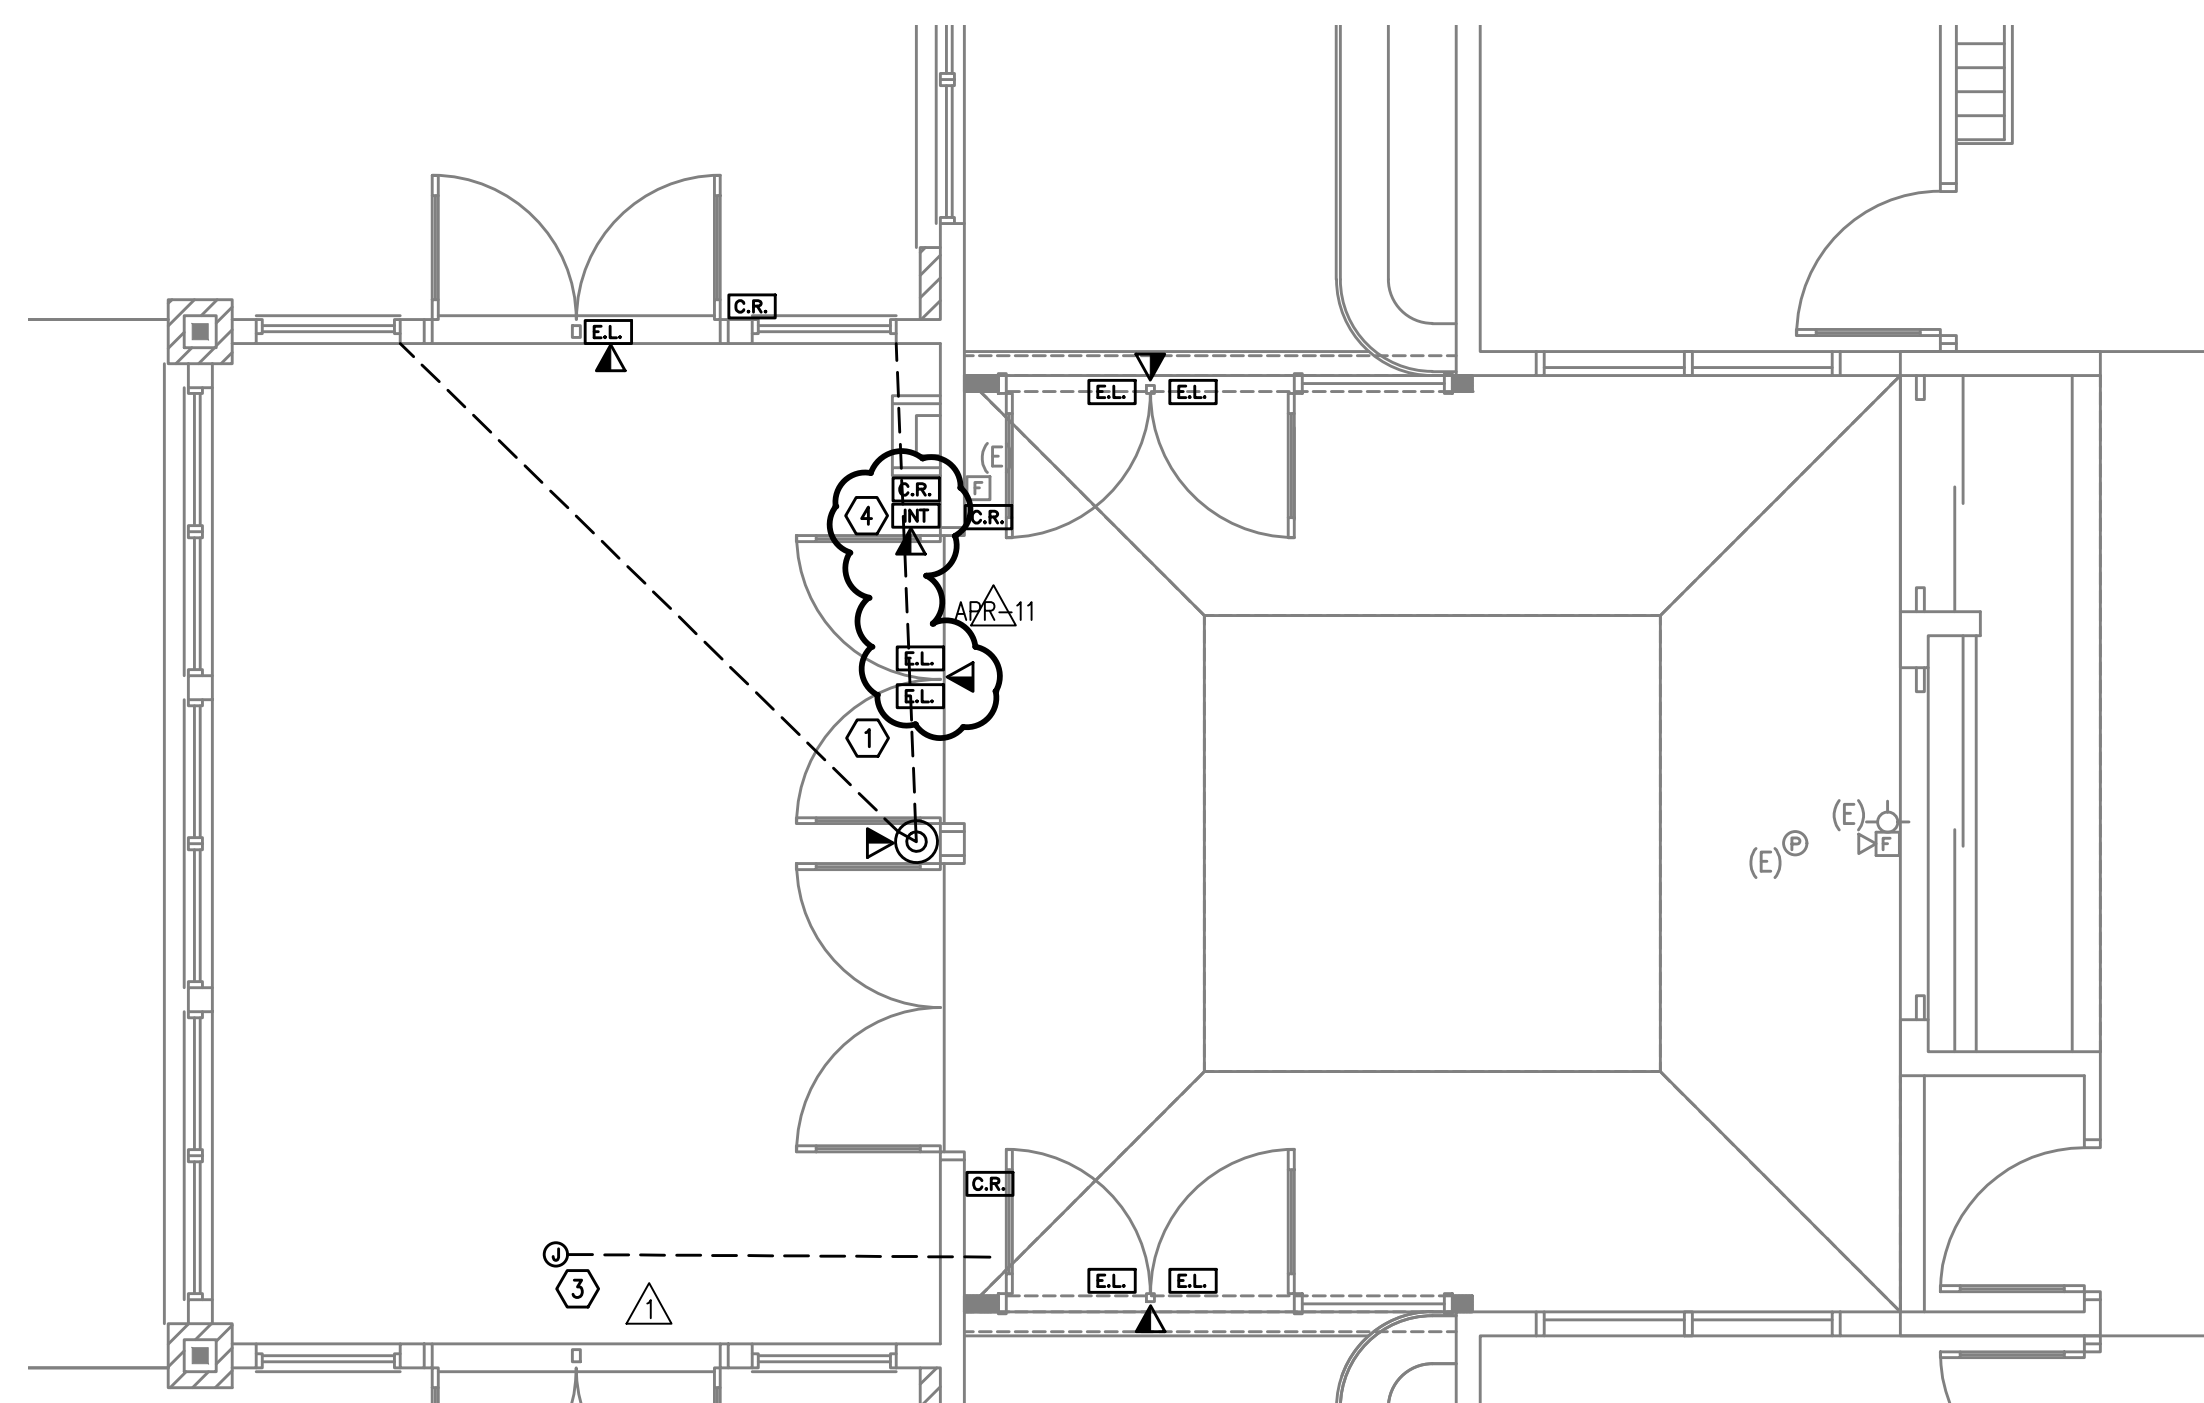

1 ENLARGED FLOOR PLAN – TELCOM
T2.1 SCALE: 1/4" = 1'-0"

NOTES:

1. APPROXIMATE VIEW REQUIRED OF CAMERA, VERIFY PROPER FRAMING OF VIEW WITH STAFF AT TIME OF INSTALLATION. PROVIDE (2) CATEGORY 6 CABLES FROM NEAREST MDF/IDF.
2. OUTPUT MODULE TO CONNECT FIRE ALARM PANEL TO POWER RELAY TO SHUT DOWN FANS WHEN FIRE ALARM ACTIVATED.
3. SINGLE GANG JUNCTION BOX WITH 3" CONDUIT TO ACCESSIBLE CEILING SPACE FOR FUTURE LOCK DOWN SYSTEM.
4. PROVIDE "TALKPHONE MODEL VOIP-200C" INTERCOM CALL BUTTON AND (2) CATEGORY 6 CABLEING TO NEAREST MDF/IDF, TERMINATE TO PATCH PANEL FOR SCHOOL DISTRICT CONNECTION.

RECORD DRAWING:

THIS DRAWING HAS BEEN UPDATED TO REFLECT
CHANGES MADE DURING CONSTRUCTION BASED
UPON INFORMATION FURNISHED TO THE ENGINEER
BY THE INSTALLATION CONTRACTOR. NO WARRANTY
EITHER EXPLICIT OR IMPLIED IS GIVEN BY MFIA, INC.
AS TO THE ACCURACY AND/OR COMPLETENESS OF
THIS INFORMATION.

B B T

A R C H I T E C T S

1160 av Simpson Ave. - Suite 100 - Bend, Oregon 97702
t 541.382.5535 | f 541.389.8083

Bend-La Pine Schools SECURITY UPGRADES
Lava Ridge Elementary
20805 Cooley Road
Bend, Oregon 97701

**20805 Cooley Road
Bend, Oregon 97701**

ISSUED:	DATE:
PERMIT SET / BID SET	02/14/18
<u>Δ</u> ADDENDUM #3	03/07/18
CONFORMANCE SET	03/28/18
<u>Δ</u> APR #4	04/09/18
AS-BUILT	09/04/18

JOB NUMBER:	1708
DRAWN BY:	GMA
CHECKED BY:	RLC

SHEET TITLE

ENLARGED
FLOOR PLAN
TELCOM

SHEET NUMBER

T2.1