


ACCESS CONTROL NOTES

1. 12"x12"x6" NEMA BOX, HOFFMAN OR APPROVED EQUAL, ON SECURED SIDE OF DOOR. TERMINATE (2) CATEGORY 6 CABLES INSIDE NEMA ENCLOSURE. SCHOOL DISTRICT WILL SUPPLY 'POE' DOOR CONTROLLER.
2. DOOR STATUS CONTACT, ONLY NEEDED WHEN STRIKE DOES NOT HAVE INTEGRAL SWITCH.
3. DOUBLE GANG BOX WITH SINGLE GANG ~~REDUCES RING IF NEEDED~~ BY SECURITY DEVICE. COORDINATE WITH ARCHITECT TO MEET ADA REACH RANGE. PROVIDE 24AWG, 12 CONDUCTOR TO DOOR CONTROLLER.
4. 'REX' ONLY NEEDED AT LOCATIONS WITH ELECTRIC STRIKE (CONFIRM WITH DOOR HARDWARE). PROVIDE 18AWG, 6 CONDUCTOR TO DOOR CONTROLLER.
5. 3" CONDUIT CONCEALED IN WALL WITH 16AWG 6 CONDUCTOR TO CRASH BAR OR ELECTRIC STRIKE.

## 2 ACCSS CONTROL DETAIL

### T2.1 SCALE: NOT TO SCALE

SCALE: NOT TO SCALE

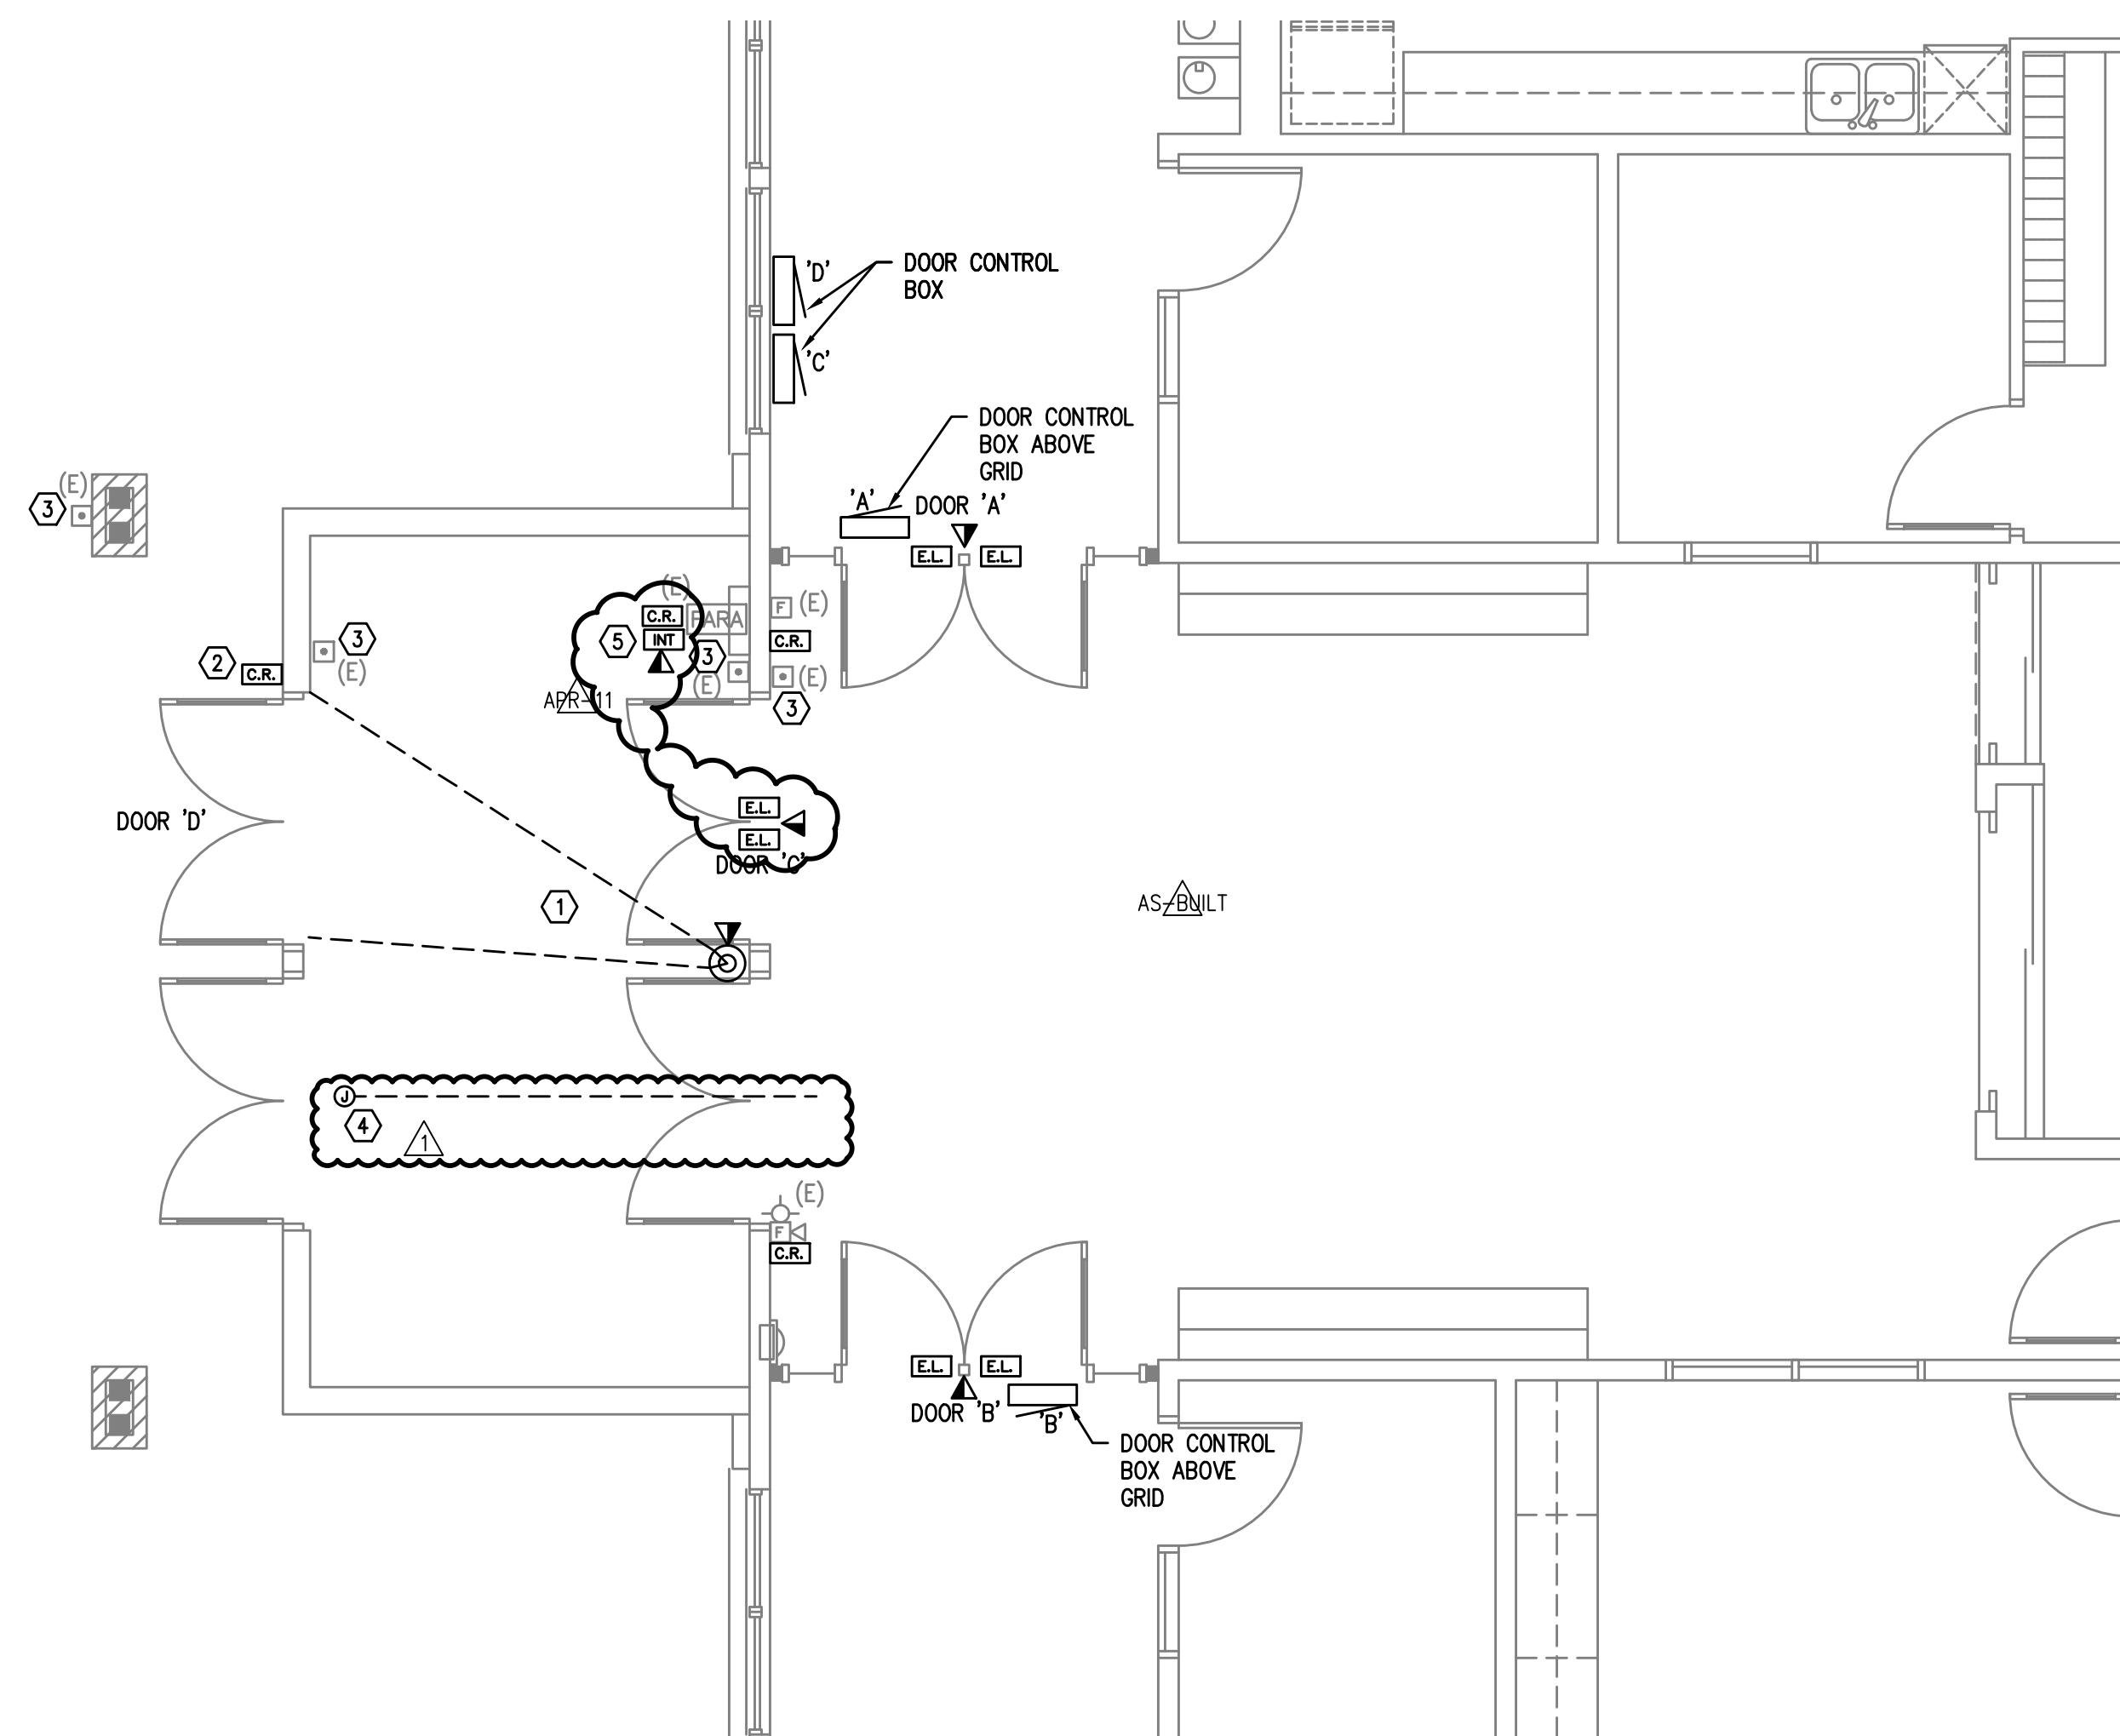

1 ENLARGED FLOOR PLAN – TELCOM  
T2.1 SCALE: 1/4" = 1'-0"

SCALE: 1/4" = 1'-0"

NOTES:

1. APPROXIMATE VIEW REQUIRED OF CAMERA, VERIFY PROPER FRAMING OF VIEW WITH STAFF AT TIME OF INSTALLATION. PROVIDE (2) CATEGORY 6 CABLES FROM NEAREST MDF/IDF.
2. CARD READER LOCATION IS GOING TO REQUIRE CONTRACTOR COORDINATION TO DETERMINE BEST LOCATION WITH CABLE ACCESS.
3. EXISTING ADA DOOR OPENER BUTTON.

4. SINGLE GANG JUNCTION BOX WITH  $\frac{3}{4}$ " CONDUIT TO ACCESSIBLE CEILING SPACE FOR FUTURE LOCK DOWN SYSTEM.
5. PROVIDE 'TALKPHONE MODEL VOIP-200C' INTERCOM CALL BUTTON AND (2) CATEGORY 6 CABLEING TO NEAREST MDF/IDF, TERMINATE TO PATCH PANEL FOR SCHOOL DISTRICT CONNECTION.

## RECORD DRAWING:

THIS DRAWING HAS BEEN UPDATED TO REFLECT  
CHANGES MADE DURING CONSTRUCTION BASED  
UPON INFORMATION FURNISHED TO THE ENGINEER  
BY THE INSTALLATION CONTRACTOR. NO WARRANTY  
EITHER EXPLICIT OR IMPLIED IS GIVEN BY MFIA, INC.  
AS TO THE ACCURACY AND/OR COMPLETENESS OF  
THIS INFORMATION.

# TBB

A R C H I T E C T S  
1160 SW Simpson Ave. - Suite 100 - Bend, Oregon 97702  
t 541.382.5535 | f 541.389.8033

# Bend-La Pine Schools SECURITY UPGRADES High Lakes Elementary School

**2500 NW High Lakes Loop  
Bend, Oregon 97703**

ISSUED:	DATE:
PERMIT SET / BID SET	02/14/18
CONFORMANCE SET	03/28/18
APR-11	06/08/18
AS-BUILT	09/04/18

JOB NUMBER:	
DRAWN BY:	GMA
CHECKED BY:	RLC

SHEET TITLE

ENLARGED  
FLOOR PLAN  
TELCOM

SHEET NUMBER

# T2.1