


- ① RELOCATE EXISTING LIGHTING FIXTURE AS SHOWN. EXTEND EXISTING BRANCH CIRCUIT TO NEW LOCATION AND RE-CONNECT.
- ② EXISTING RECEPTACLE TO REMAIN.
- ③ CONNECT TO SPARE 20A/1P CIRCUIT BREAKER IN EXISTING PANEL.
- ④ DOOR CONTROLLER POWER SUPPLY CONNECTION. COORDINATE EXACT LOCATION WITH DOOR HARDWARE SPECIFICATIONS AND DOOR HARDWARE SUPPLIER.
- ⑤ EXISTING SWITCHES TO REMAIN.


'A'	LIGHT FIXTURE TYPE (SEE FIXTURE LIST)
(E)	EXISTING
G.F.I.	GROUND FAULT INTERRUPTER
W.P.	WEATHERPROOF

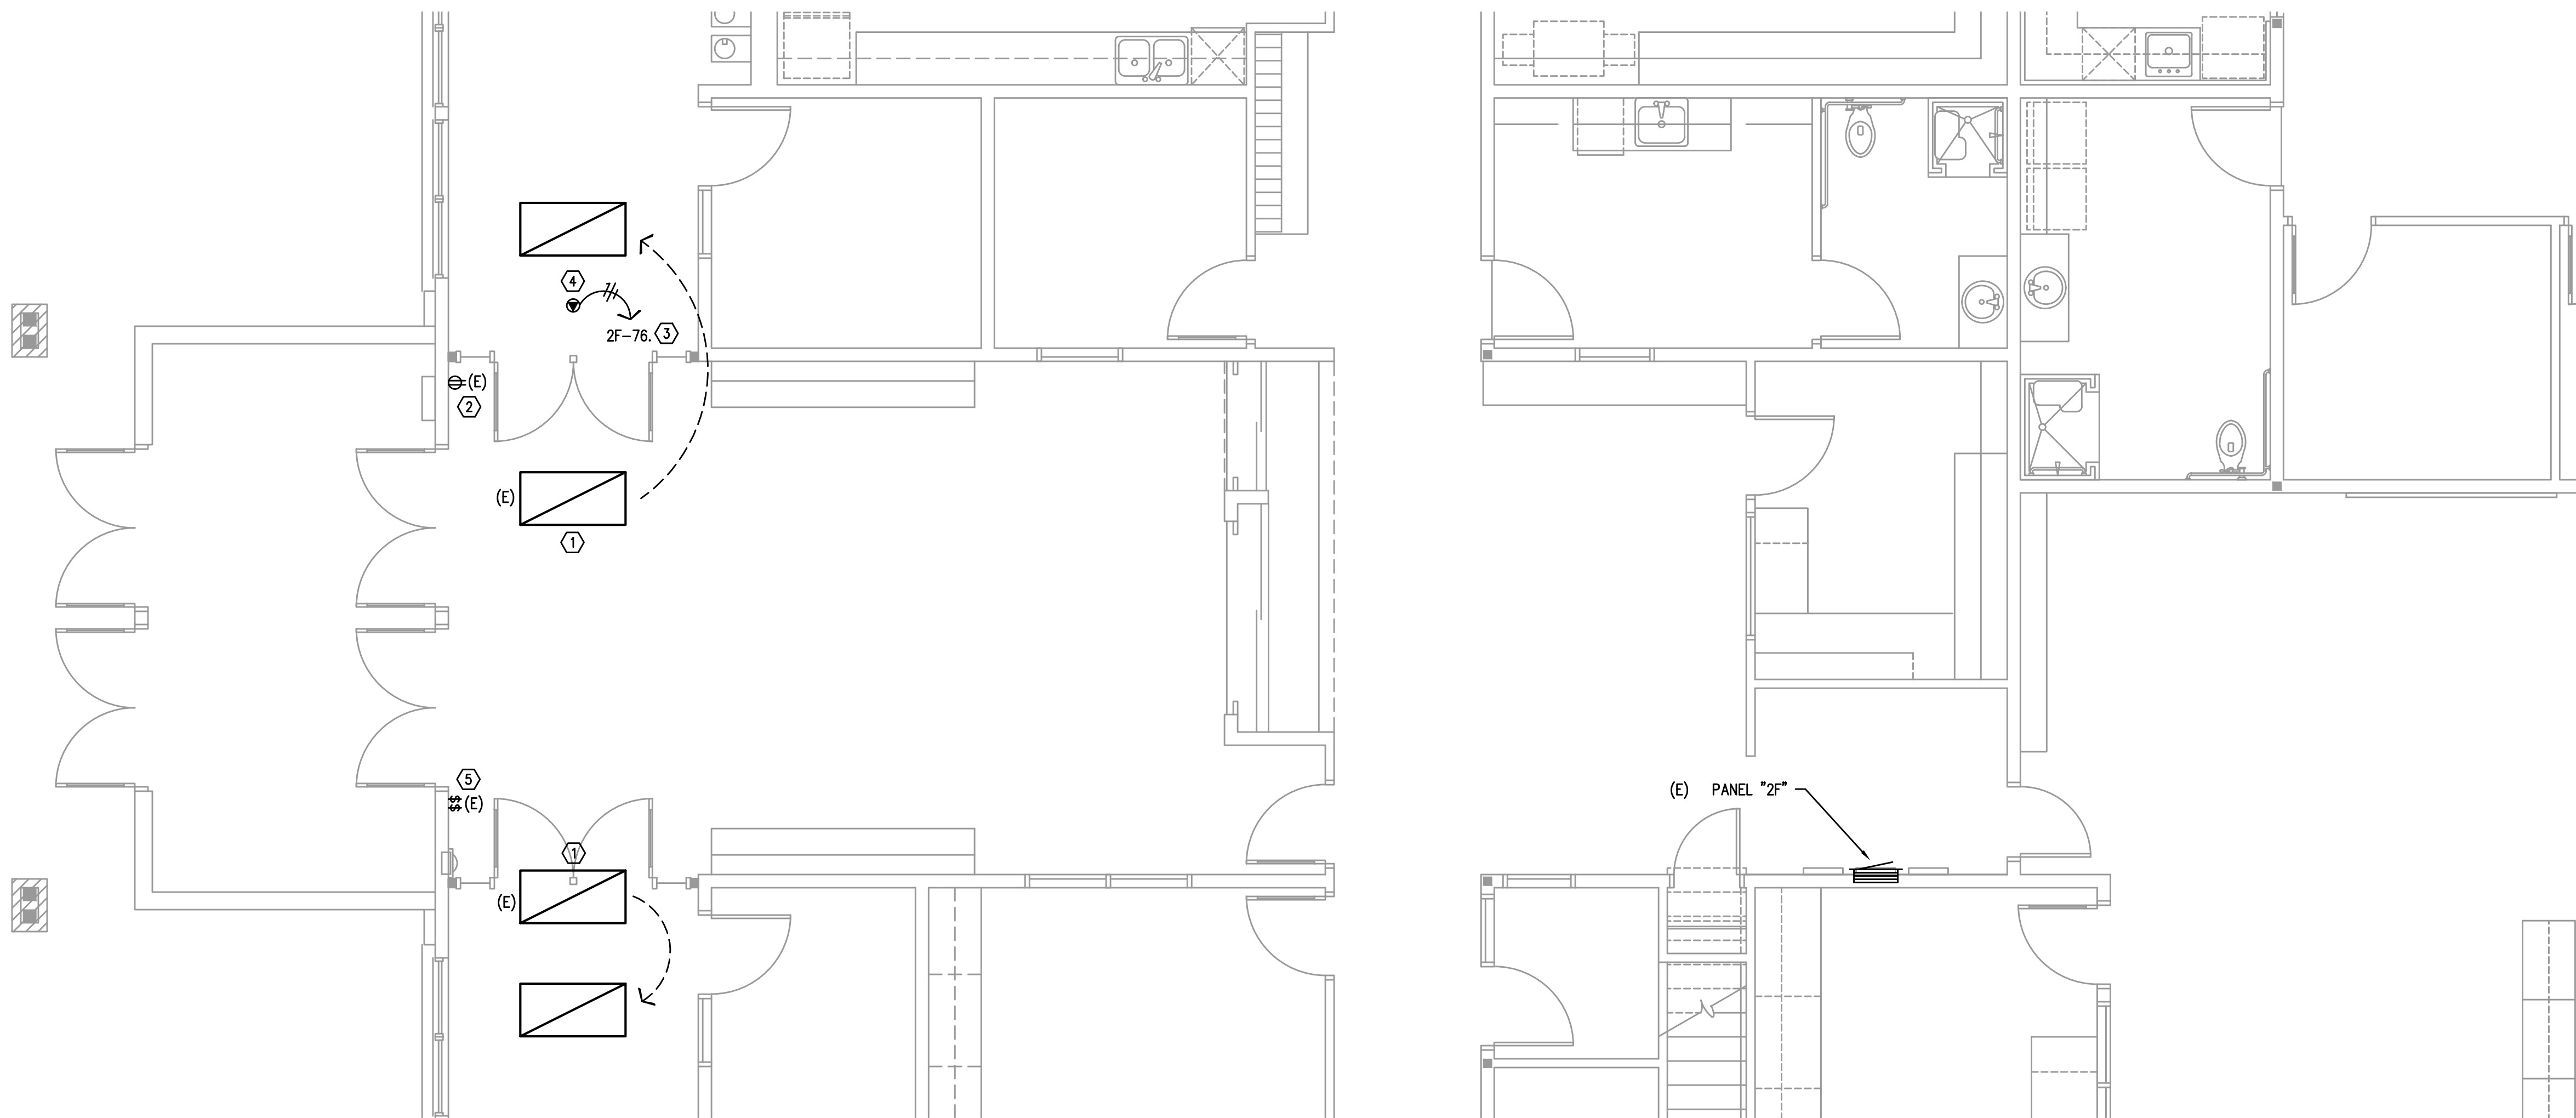

1 E1.1 ENLARGED FLOOR PLAN – ELECTRICAL

SCALE: 1/4" = 1'-0"

**M
F
A
INC.** Consulting Engineers
2007 S.E. Ash St.
Portland, OR 97214
PHN: (503) 234-0548
FAX: (503) 234-0677
WWW.MFIA-ENG.COM
CONTACT: CHRIS WINER

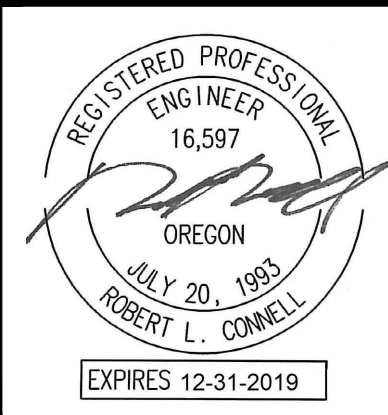

B B T

A R C H I T E C T S

1160 av Simpson Ave. - Suite 100 - Bend, Oregon 97702
t 541.382.5535 f 541.389.8033

Bend-La Pine Schools SECURITY UPGRADES
High Lakes Elementary School
2500 NW High Lakes Loop
Bend, Oregon 97703

ISSUED:	DATE:
PERMIT SET / BID SET	02/14/18

JOB NUMBER:	
DRAWN BY:	CAW
CHECKED BY:	RLC

SHEET TITLE

ENLARGED
FLOOR PLAN
ELECTRICAL

SHEET NUMBER
E1.1