



- ① RELOCATE EXISTING LIGHTING FIXTURE AS SHOWN.
EXTEND EXISTING BRANCH CIRCUIT TO NEW LOCATION AND RE-CONNECT.
- ② RELOCATE EXISTING RECEPTACLE AS SHOWN.
EXTEND EXISTING BRANCH CIRCUIT TO NEW LOCATION AND RE-CONNECT.
- ③ CONNECT TO SPARE 20A/1P CIRCUIT BREAKER IN EXISTING PANEL.
- ④ DOOR CONTROLLER POWER SUPPLY CONNECTION.
COORDINATE EXACT LOCATION WITH DOOR HARDWARE SPECIFICATIONS AND DOOR HARDWARE SUPPLIER.
- ⑤ EXISTING SWITCHES TO REMAIN.

'A'	LIGHT FIXTURE TYPE (SEE FIXTURE LIST)
(E)	EXISTING
G.F.I.	GROUND FAULT INTERRUPTER
W.P.	WEATHERPROOF

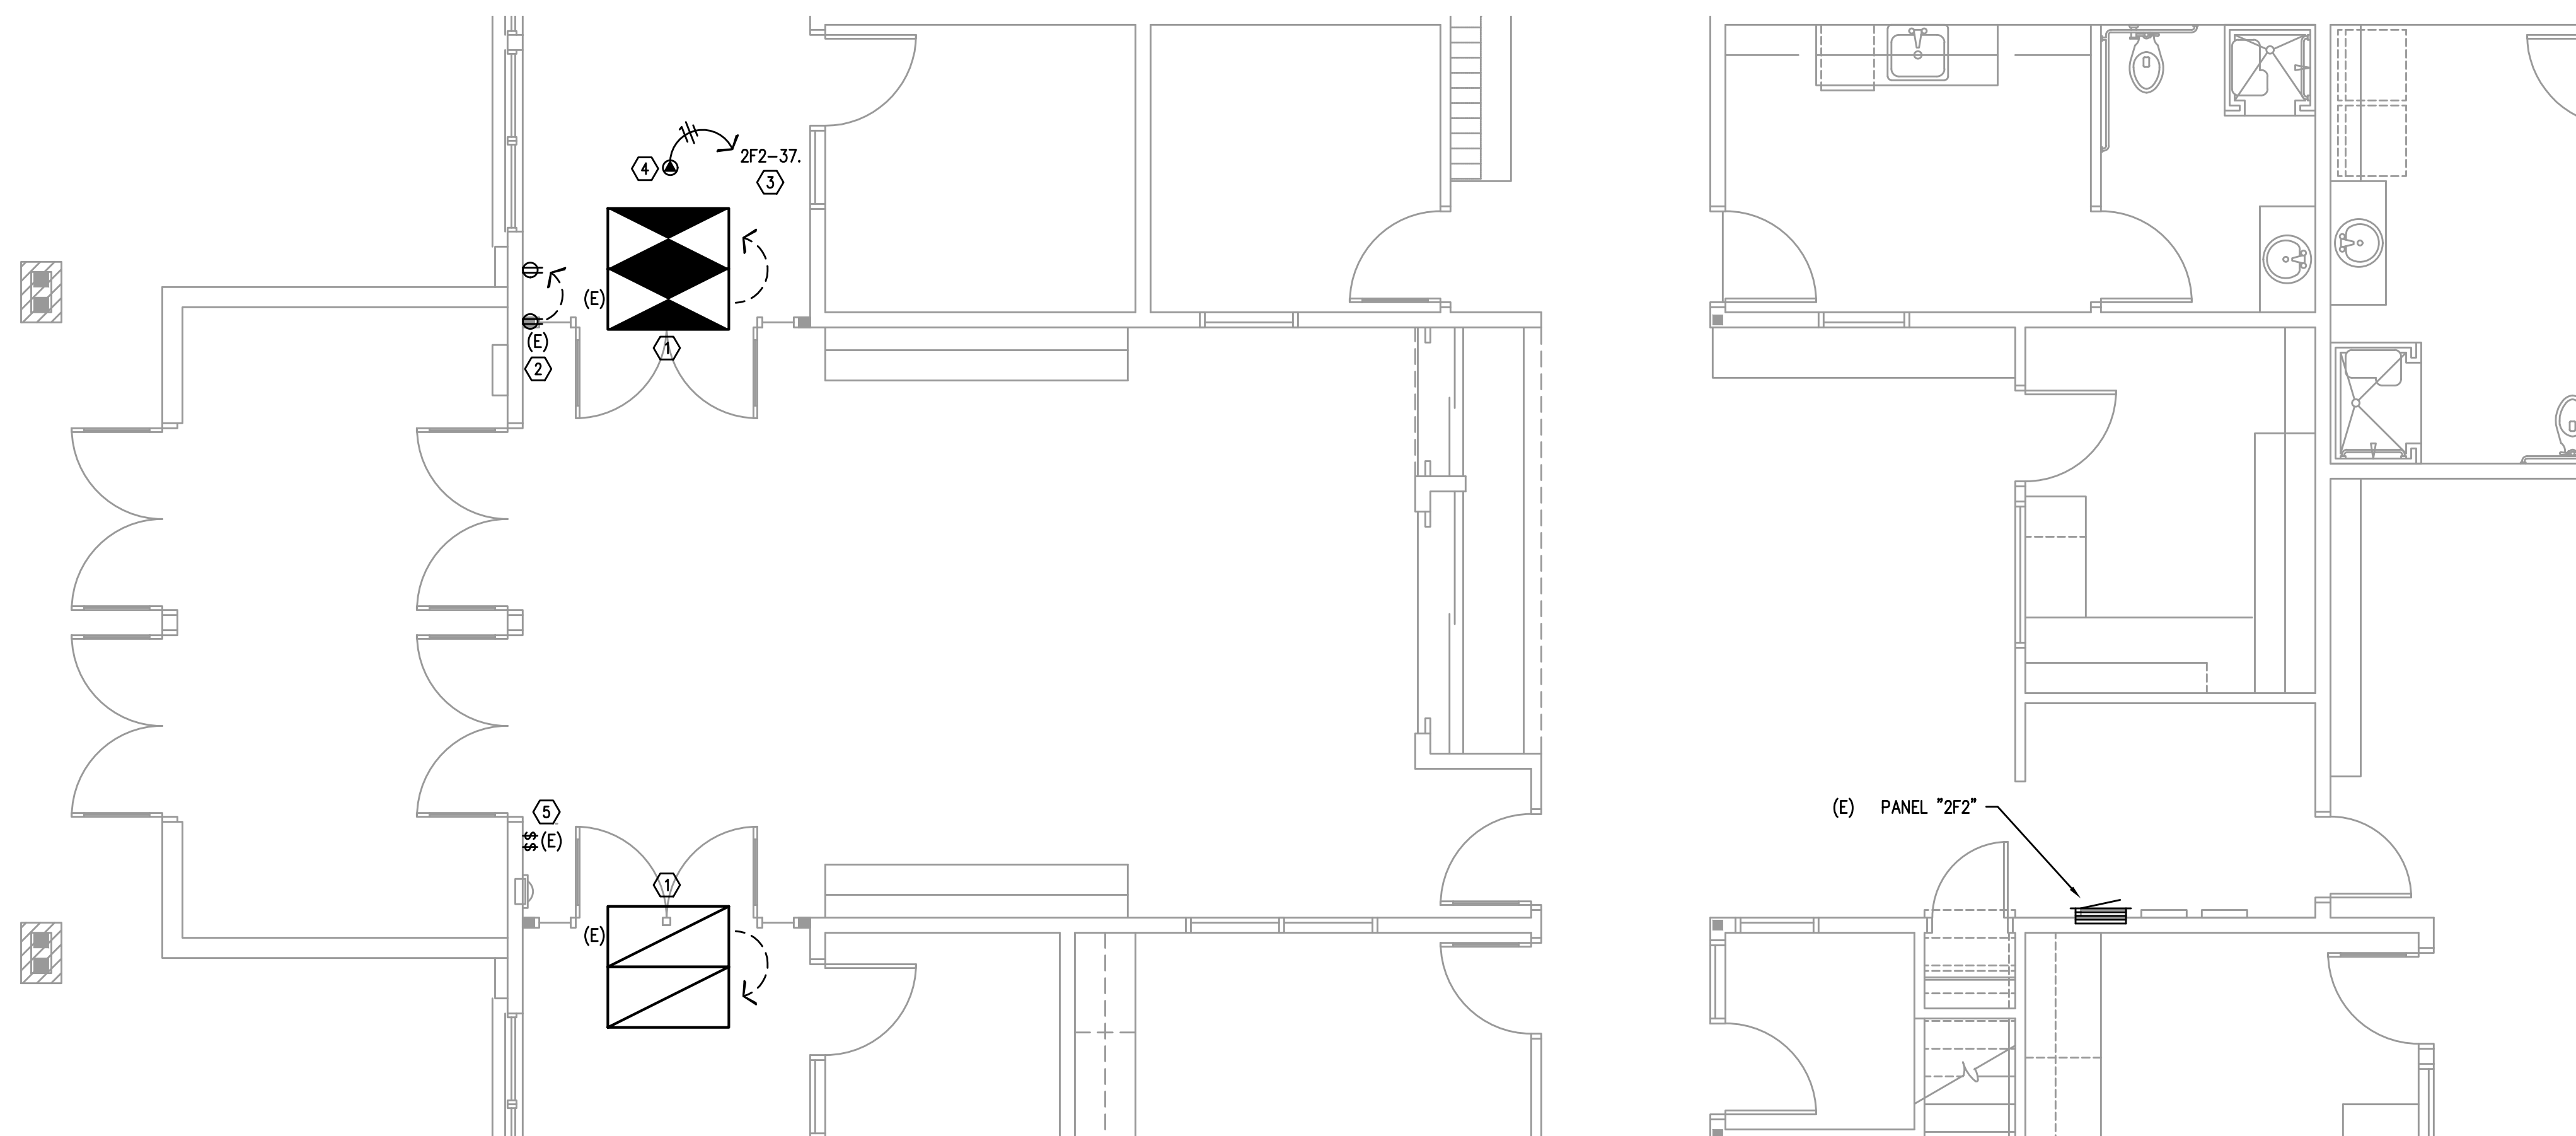

1 ENLARGED FLOOR PLAN - ELECTRICAL
E1.1 SCALE: 1/4" = 1'-0"

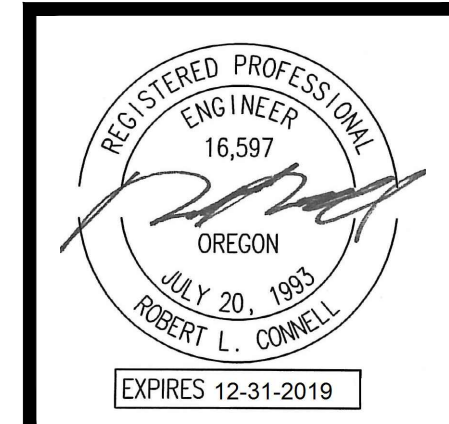

B B T

A R C H I T E C T S

1160 sw Simpson Ave. • Suite 100 • Bend, Oregon 97702
t 541.382.5535 f 541.389.8033

Bend-La Pine Schools SECURITY UPGRADES
Pine Ridge Elementary School
19840 Hollygrape Street
Bend, Oregon 97702

ISSUED:	DATE:
PERMIT SET / BID SET	02/14/18

JOB NUMBER:	1708
DRAWN BY:	CAW
CHECKED BY:	RLC

SHEET TITLE

ENLARGED
FLOOR PLAN
ELECTRICAL

SHEET NUMBER

E1.1