


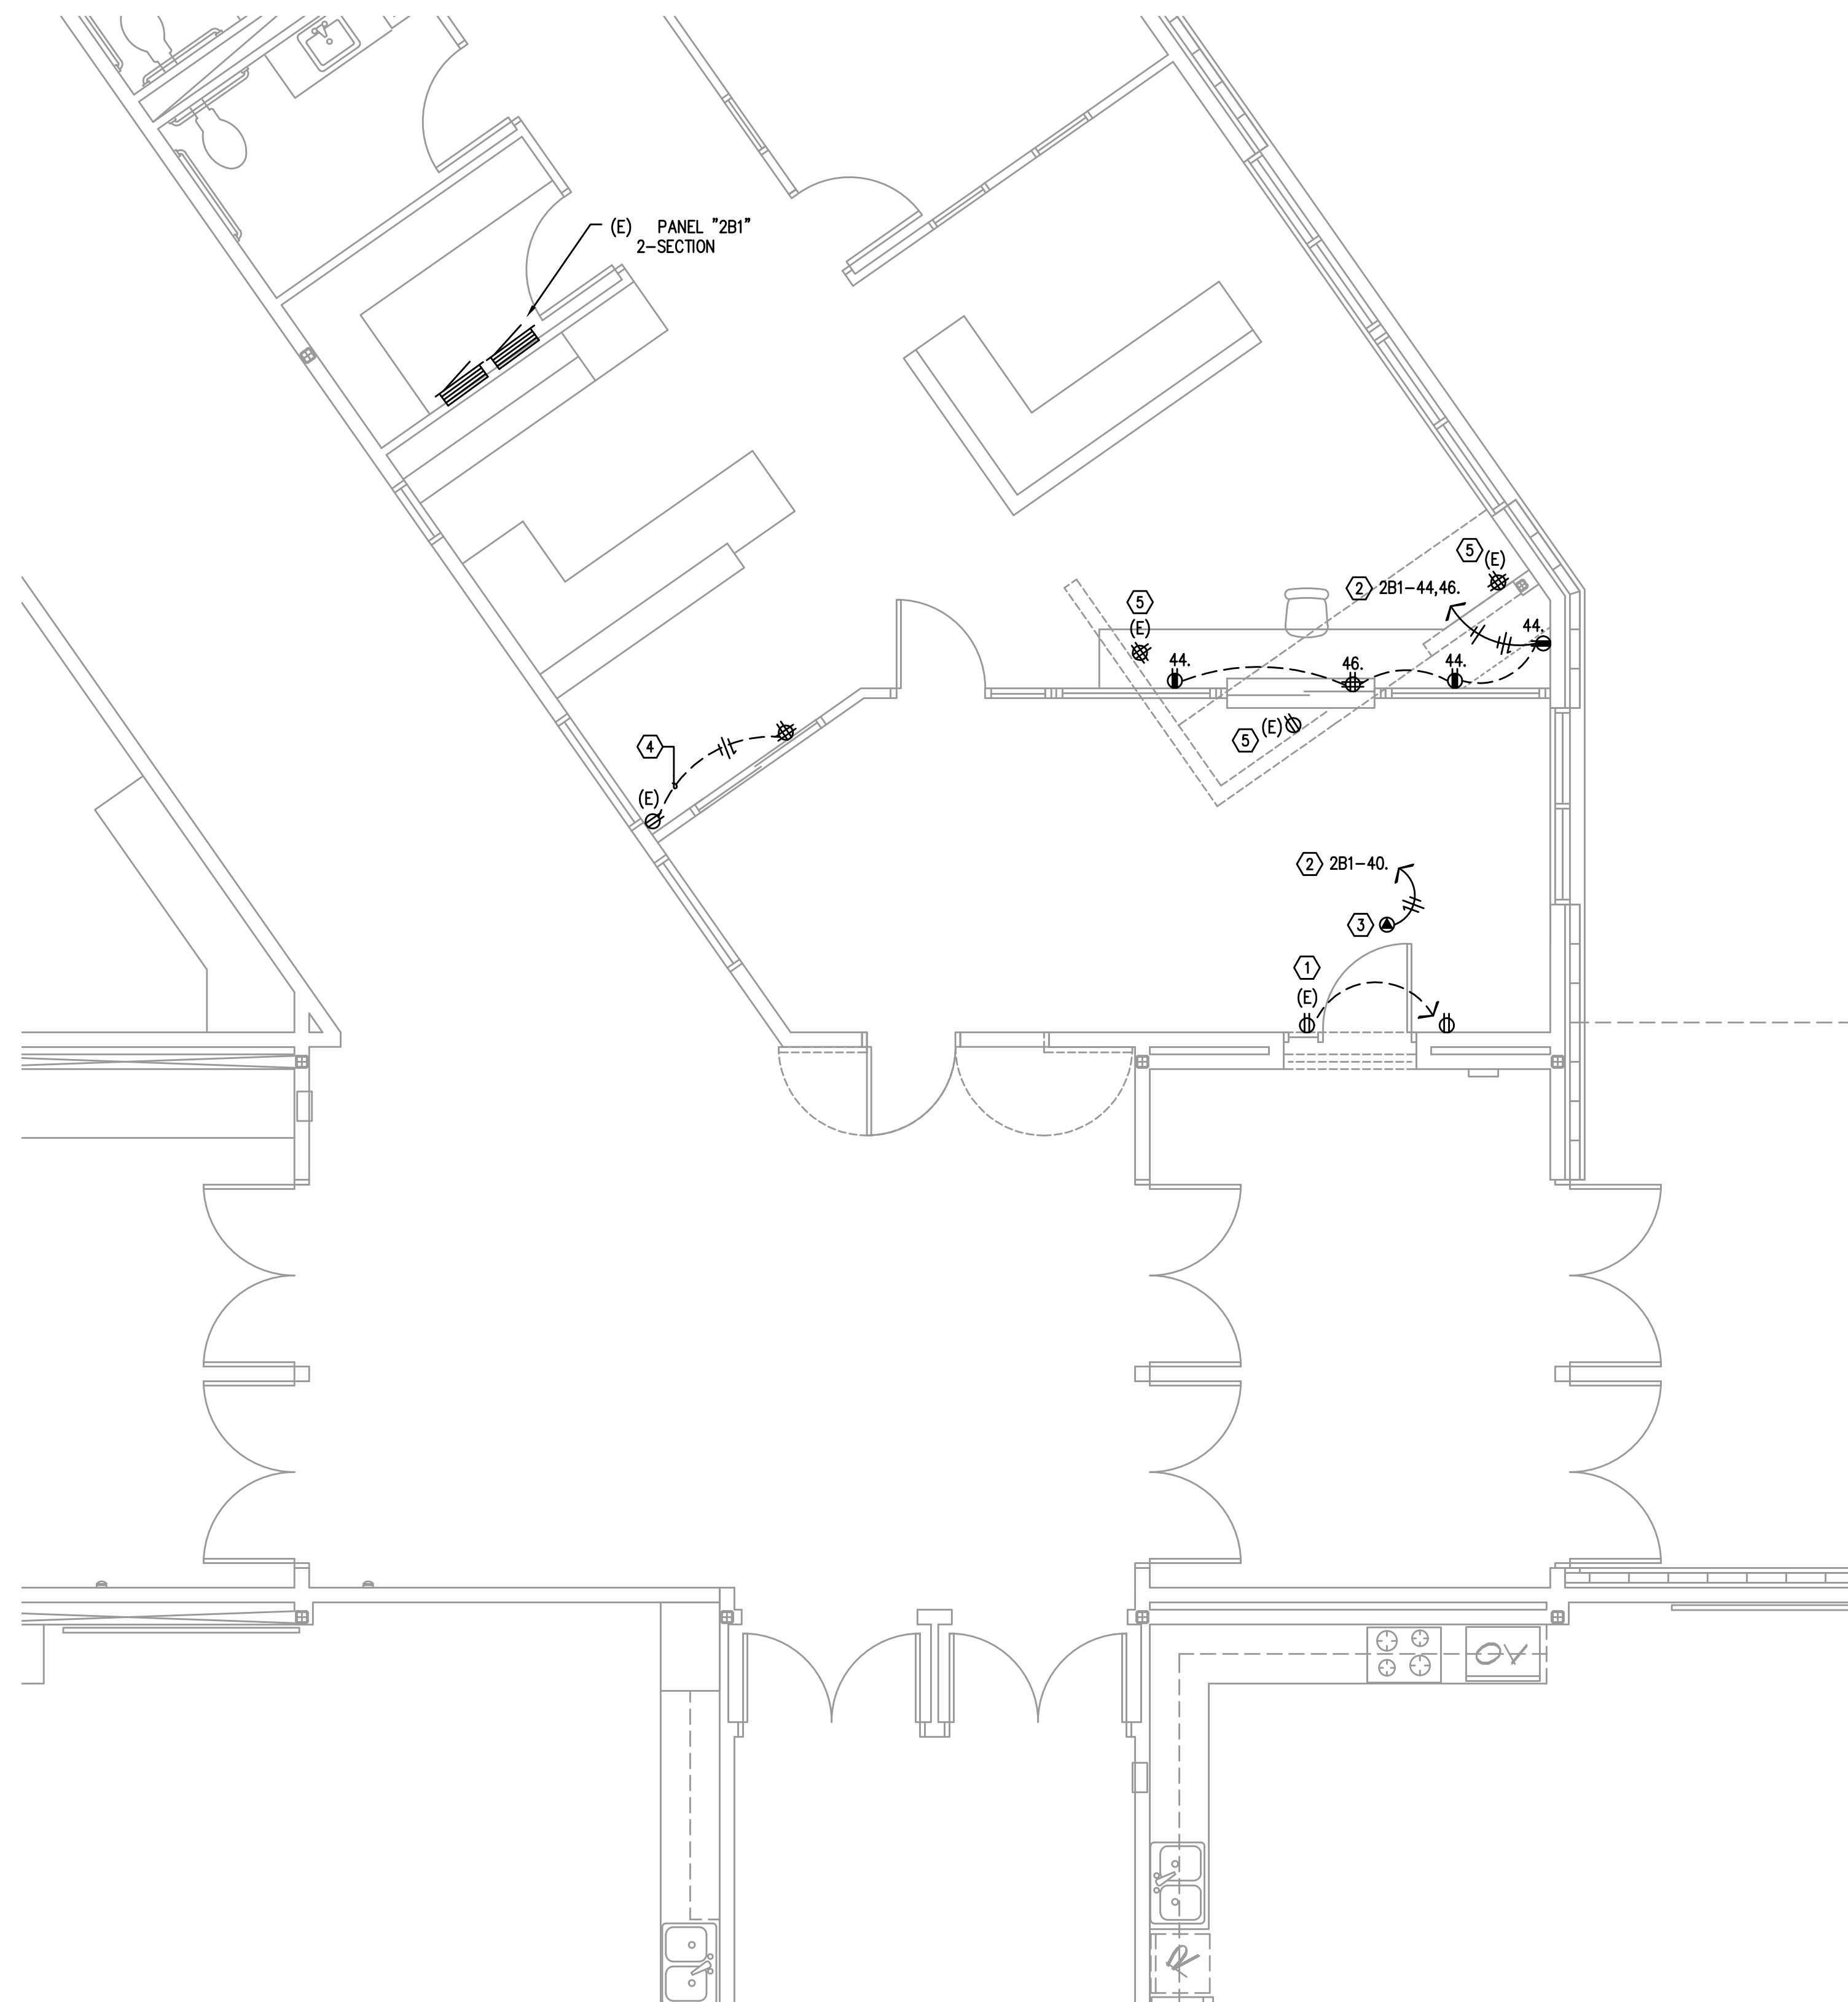


PLAN NOTES

- ① RELOCATE EXISTING RECEPTACLE AS SHOWN. EXTEND EXISTING BRANCH CIRCUITING TO NEW LOCATION AND RE-CONNECT.
- ② CONNECT TO SPARE 20A/1P CIRCUIT BREAKER IN EXISTING PANEL.
- ③ DOOR CONTROLLER POWER SUPPLY CONNECTION. COORDINATE EXACT LOCATION WITH DOOR HARDWARE SPECIFICATIONS AND DOOR HARDWARE SUPPLIER.
- ④ EXTEND EXISTING BRANCH CIRCUIT TO SERVE NEW RECEPTACLE AS SHOWN.
- ⑤ EXISTING RECEPTACLE, RACEWAY, AND BRANCH CIRCUITING TO BE REMOVED.

ELECTRICAL SYMBOLS LIST

LIGHTING SYMBOLS

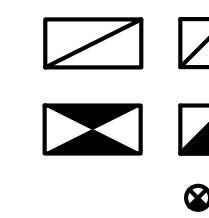

LIGHT FIXTURE, RECESSED

LIGHT FIXTURE, RECESSED EMERGENCY

EXIT SIGN

SWITCH SYMBOLS

\$ SWITCH, SPST +48" A.F.F.

\$3 SWITCH, 3-WAY +48" A.F.F.

Ⓞ OCCUPANCY SENSOR, CEILING MOUNT

POWER SYMBOLS

RECEPTACLE, DUPLEX +18" A.F.F.

RECEPTACLE, DUPLEX ABOVE COUNTER


RECEPTACLE, QUAD +18" A.F.F.

— ELECTRICAL DISTRIBUTION PANEL

ELECTRICAL CONNECTION

ⓐ ELECTRICAL JUNCTION BOX

WIRING SYMBOLS

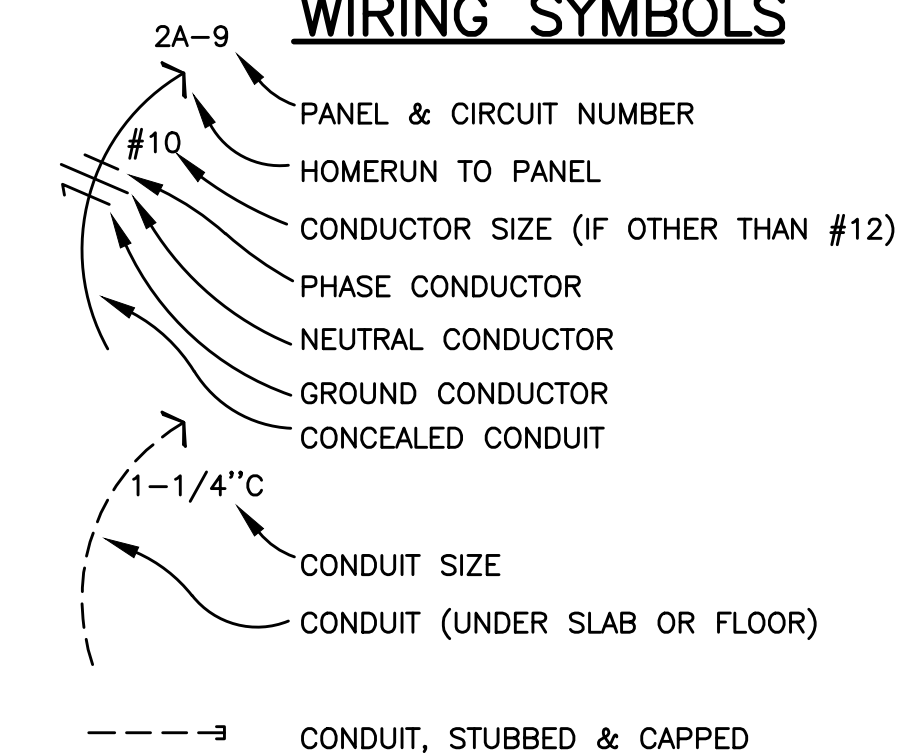

NOTATIONS

 DRAWING NOTE


 DETAIL REFERENCE: TOP=DETAIL NO., BOTTOM=SHEET NO.

ABBREVIATIONS


'A' LIGHT FIXTURE TYPE (SEE FIXTURE LIST)

(E) EXISTING

G.F.I. GROUND FAULT INTERRUPTER

(R) RELOCATED

W.P. WEATHERPROOF

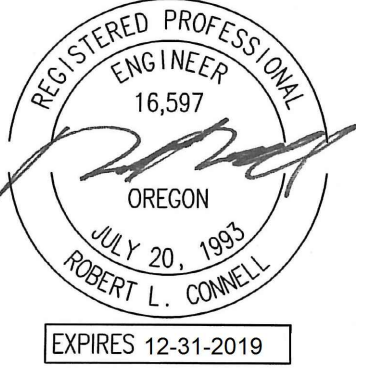

B B T

A R C H I T E C T S

1160 sw Simpson Ave. - Suite 100 - Bend, Oregon 97702
t 541.382.5535 | f 541.389.8033

Bend-La Pine Schools SECURITY UPGRADES
Sky View Middle School
63555 NE 18th Street
Bend, Oregon 97701

ISSUED:	DATE:
PERMIT SET / BID SET	02/14/18

JOB NUMBER:	1708
DRAWN BY:	CAW
CHECKED BY:	RLC


SHEET TITLE

ENLARGED
FLOOR PLAN
POWER

SHEET NUMBER
E1.1

MEI
INC. Consulting Engineers
2007 S.E. Ash St.
Portland, OR 97214
PHN: (503) 234-0548
FAX: (503) 234-0677
WWW.MFIA-ENG.COM
CONTACT: CHRIS WINER

Copyright © 2017 BBT Architects
C:\Users\Brenda.Lumpkin\Documents\2018\Bend-La Pine Schools Security Upgrades\Bend-La Pine Middle School\Bend-La Pine Middle School - Lighting - E2.1.dwg
C:\Users\Brenda.Lumpkin\Documents\2018\Bend-La Pine Schools Security Upgrades\Bend-La Pine Middle School\Bend-La Pine Middle School - Lighting - E2.1.dwg

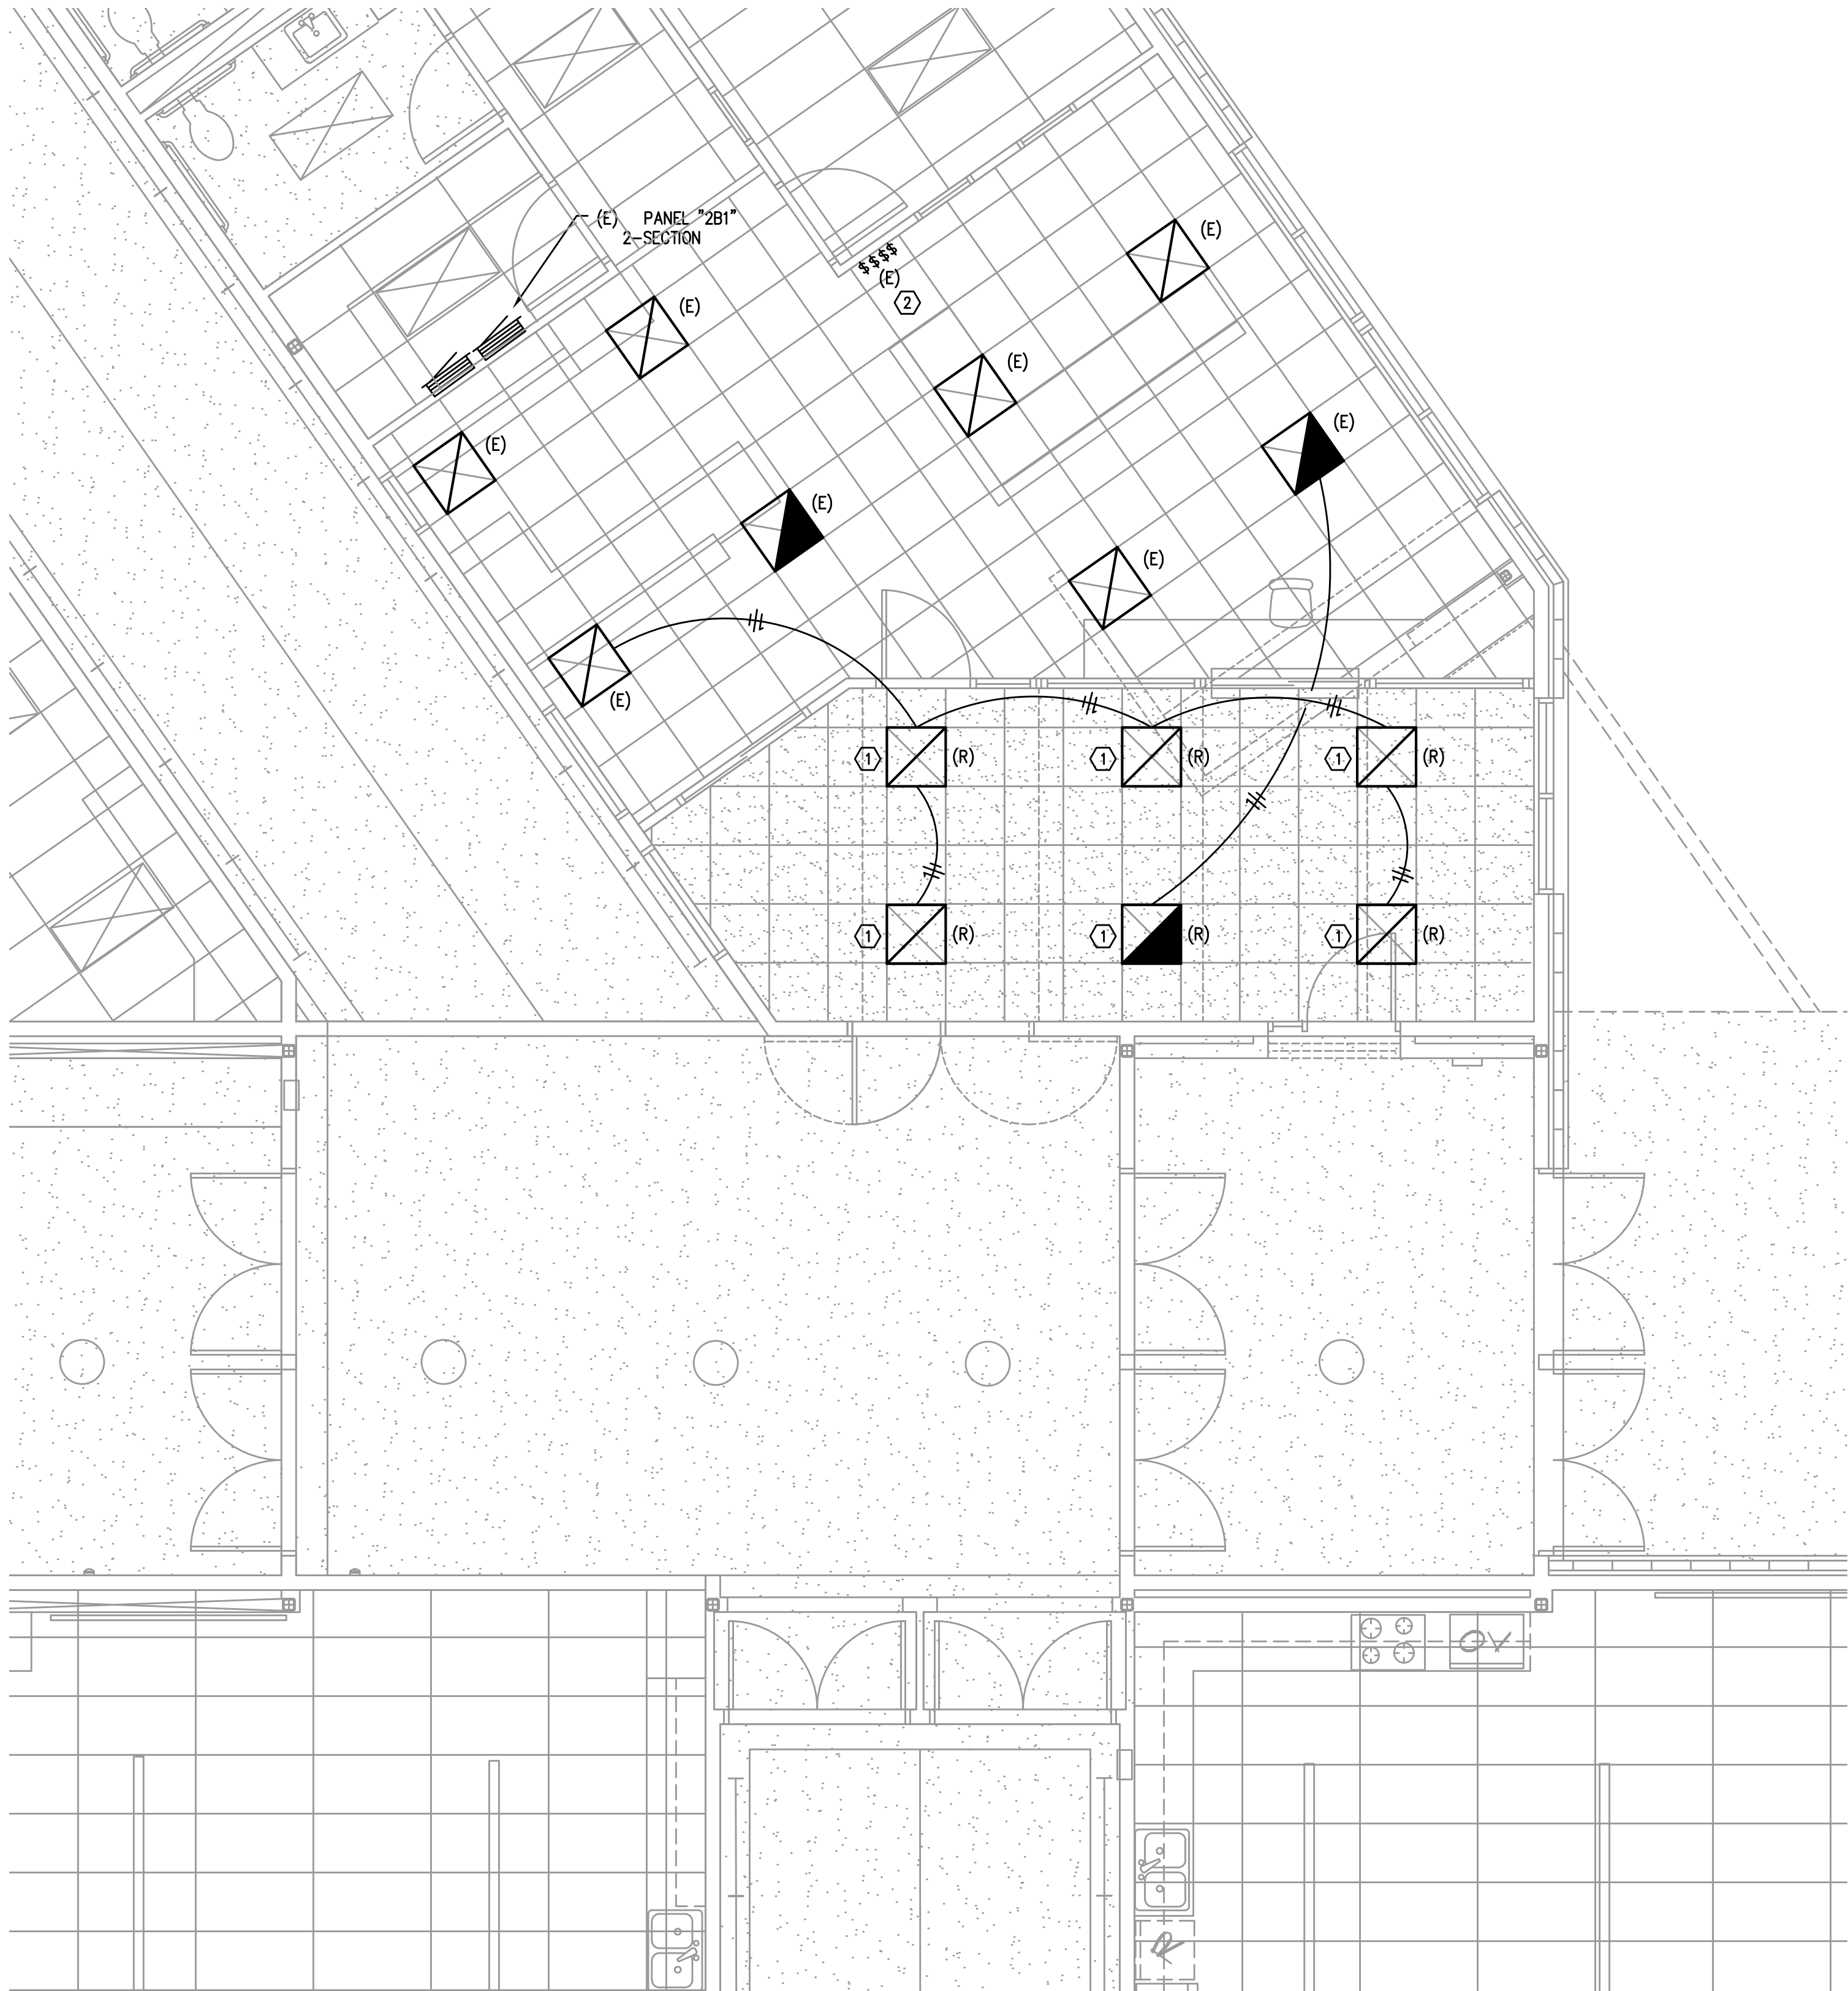


PLAN NOTES

- ① RELOCATED LIGHT FIXTURE. PROVIDE NEW BRANCH CIRCUITING AND RE-CONNECT TO EXISTING LIGHTING AS INDICATED.
- ② EXISTING LIGHTING CONTROL SWITCHES TO REMAIN.

1
E2.1 ENLARGED FLOOR PLAN — LIGHTING
SCALE: 1/4" = 1'-0"

M
F
A
INC. Consulting Engineers
2007 S.E. Ash St.
Portland, OR 97214
PHN: (503) 234-0548
FAX: (503) 234-0677
WWW.MFIA-ENG.COM
CONTACT: CHRIS WINER

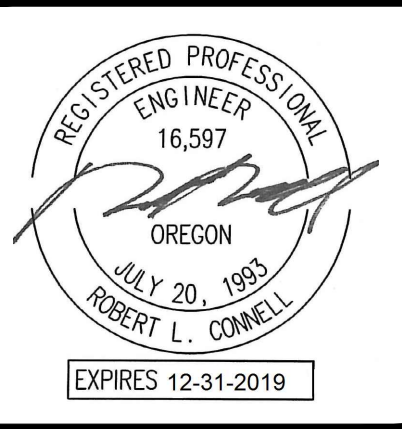

BBT
ARCHITECTS
1160 NW Simpson Ave., Suite 100 - Bend, Oregon 97702
t 541.382.5535 | f 541.389.8033

Bend-La Pine Schools SECURITY UPGRADES
Sky View Middle School
63555 NE 18th Street
Bend, Oregon 97701

ISSUED:	DATE:
PERMIT SET / BID SET	02/14/18

JOB NUMBER:	1708
DRAWN BY:	CAW
CHECKED BY:	RLC

SHEET TITLE
ENLARGED
FLOOR PLAN
LIGHTING

SHEET NUMBER
E2.1