



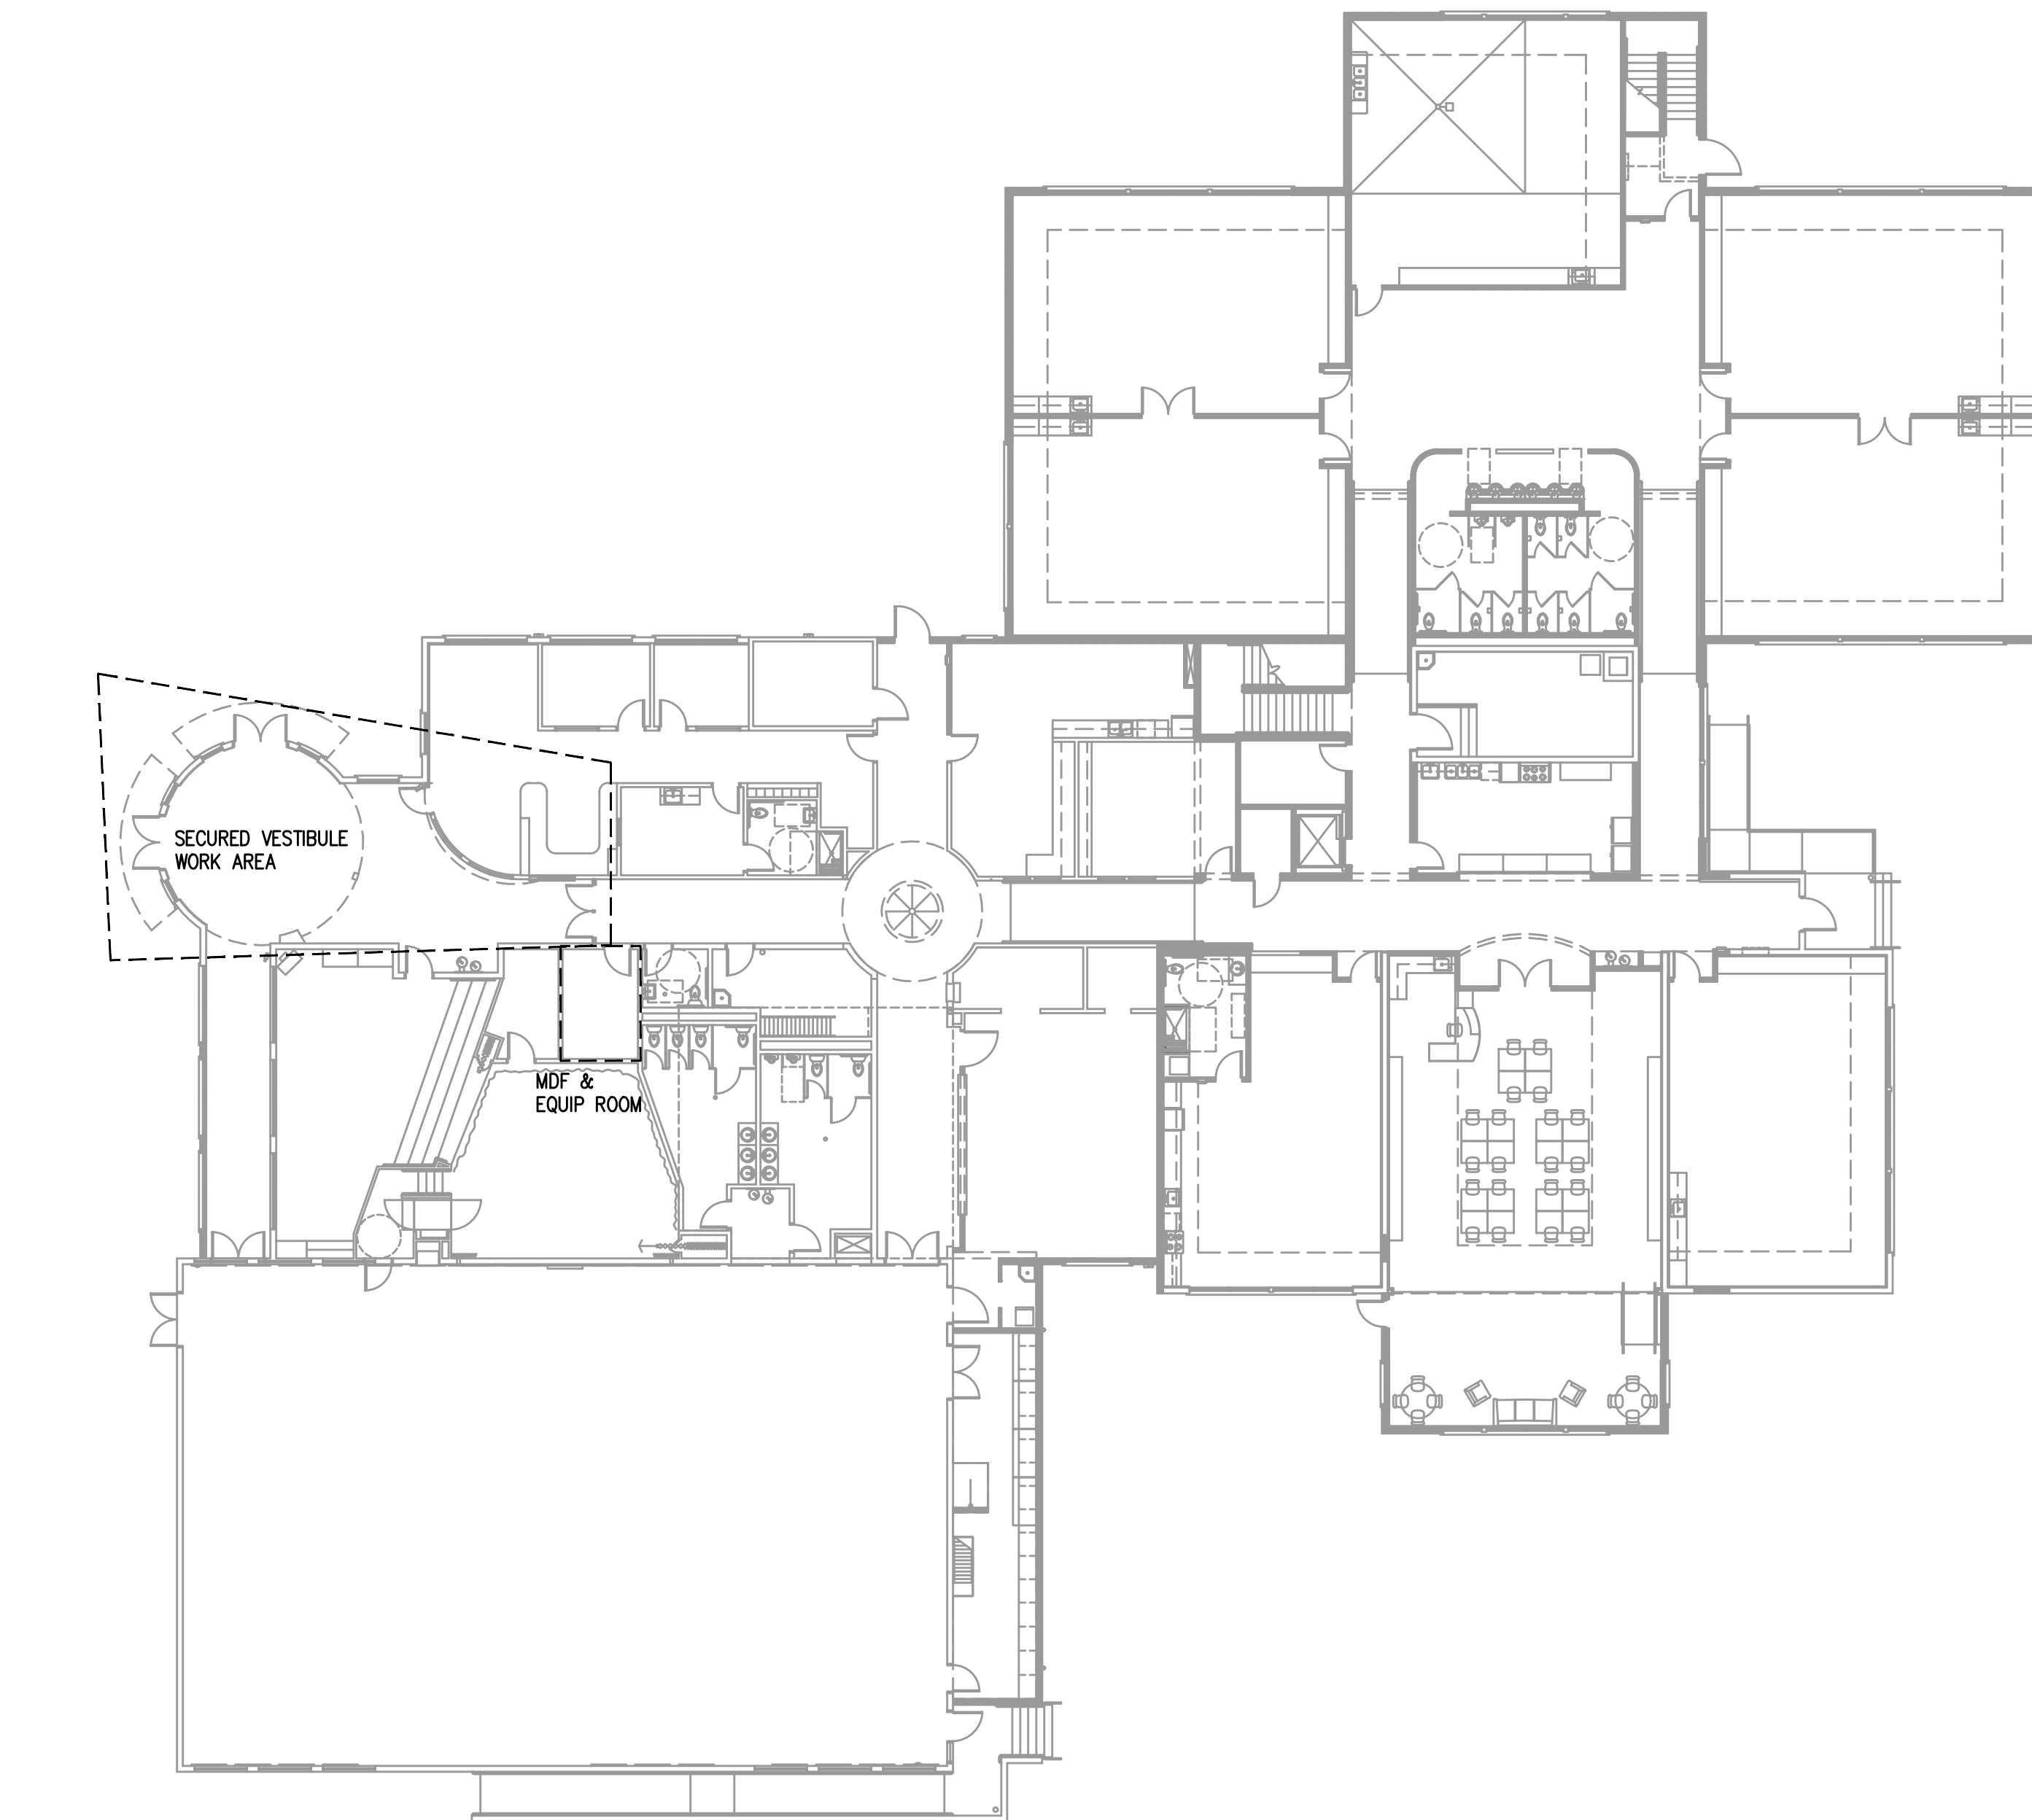

1 OVERALL FLOOR PLAN — TELCOM
T1.1 SCALE: 1/16" = 1'-0"

**M
F
A
INC.** Consulting Engineers
2007 S.E. Ash St.
Portland, OR 97214
PHN: (503) 234-0548
FAX: (503) 234-0677
www.MFIA-ENG.com
CONTACT: GARY ADOWNIK

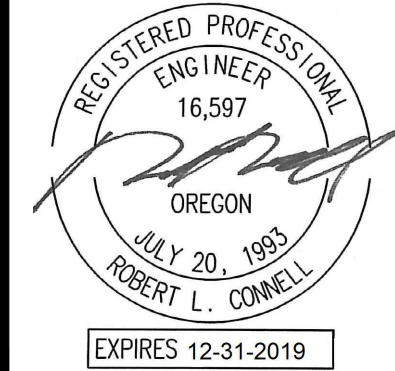

BBT

A R C H I T E C T S

1160 av Simpson Ave. - Suite 100 - Bend, Oregon 97702
t 541.382.5535 | f 541.389.8003

Bend-La Pine Schools SECURITY UPGRADES
Kingston Elementary School
1101 NW 12th Street
Bend, Oregon 97703

ISSUED:	DATE:
PERMIT SET / BID SET	02/14/18

JOB NUMBER:	1708
DRAWN BY:	GMA
CHECKED BY:	RLC

SHEET TITLE

OVERALL
FLOOR PLAN
TELCOM

SHEET NUMBER
T1.1