


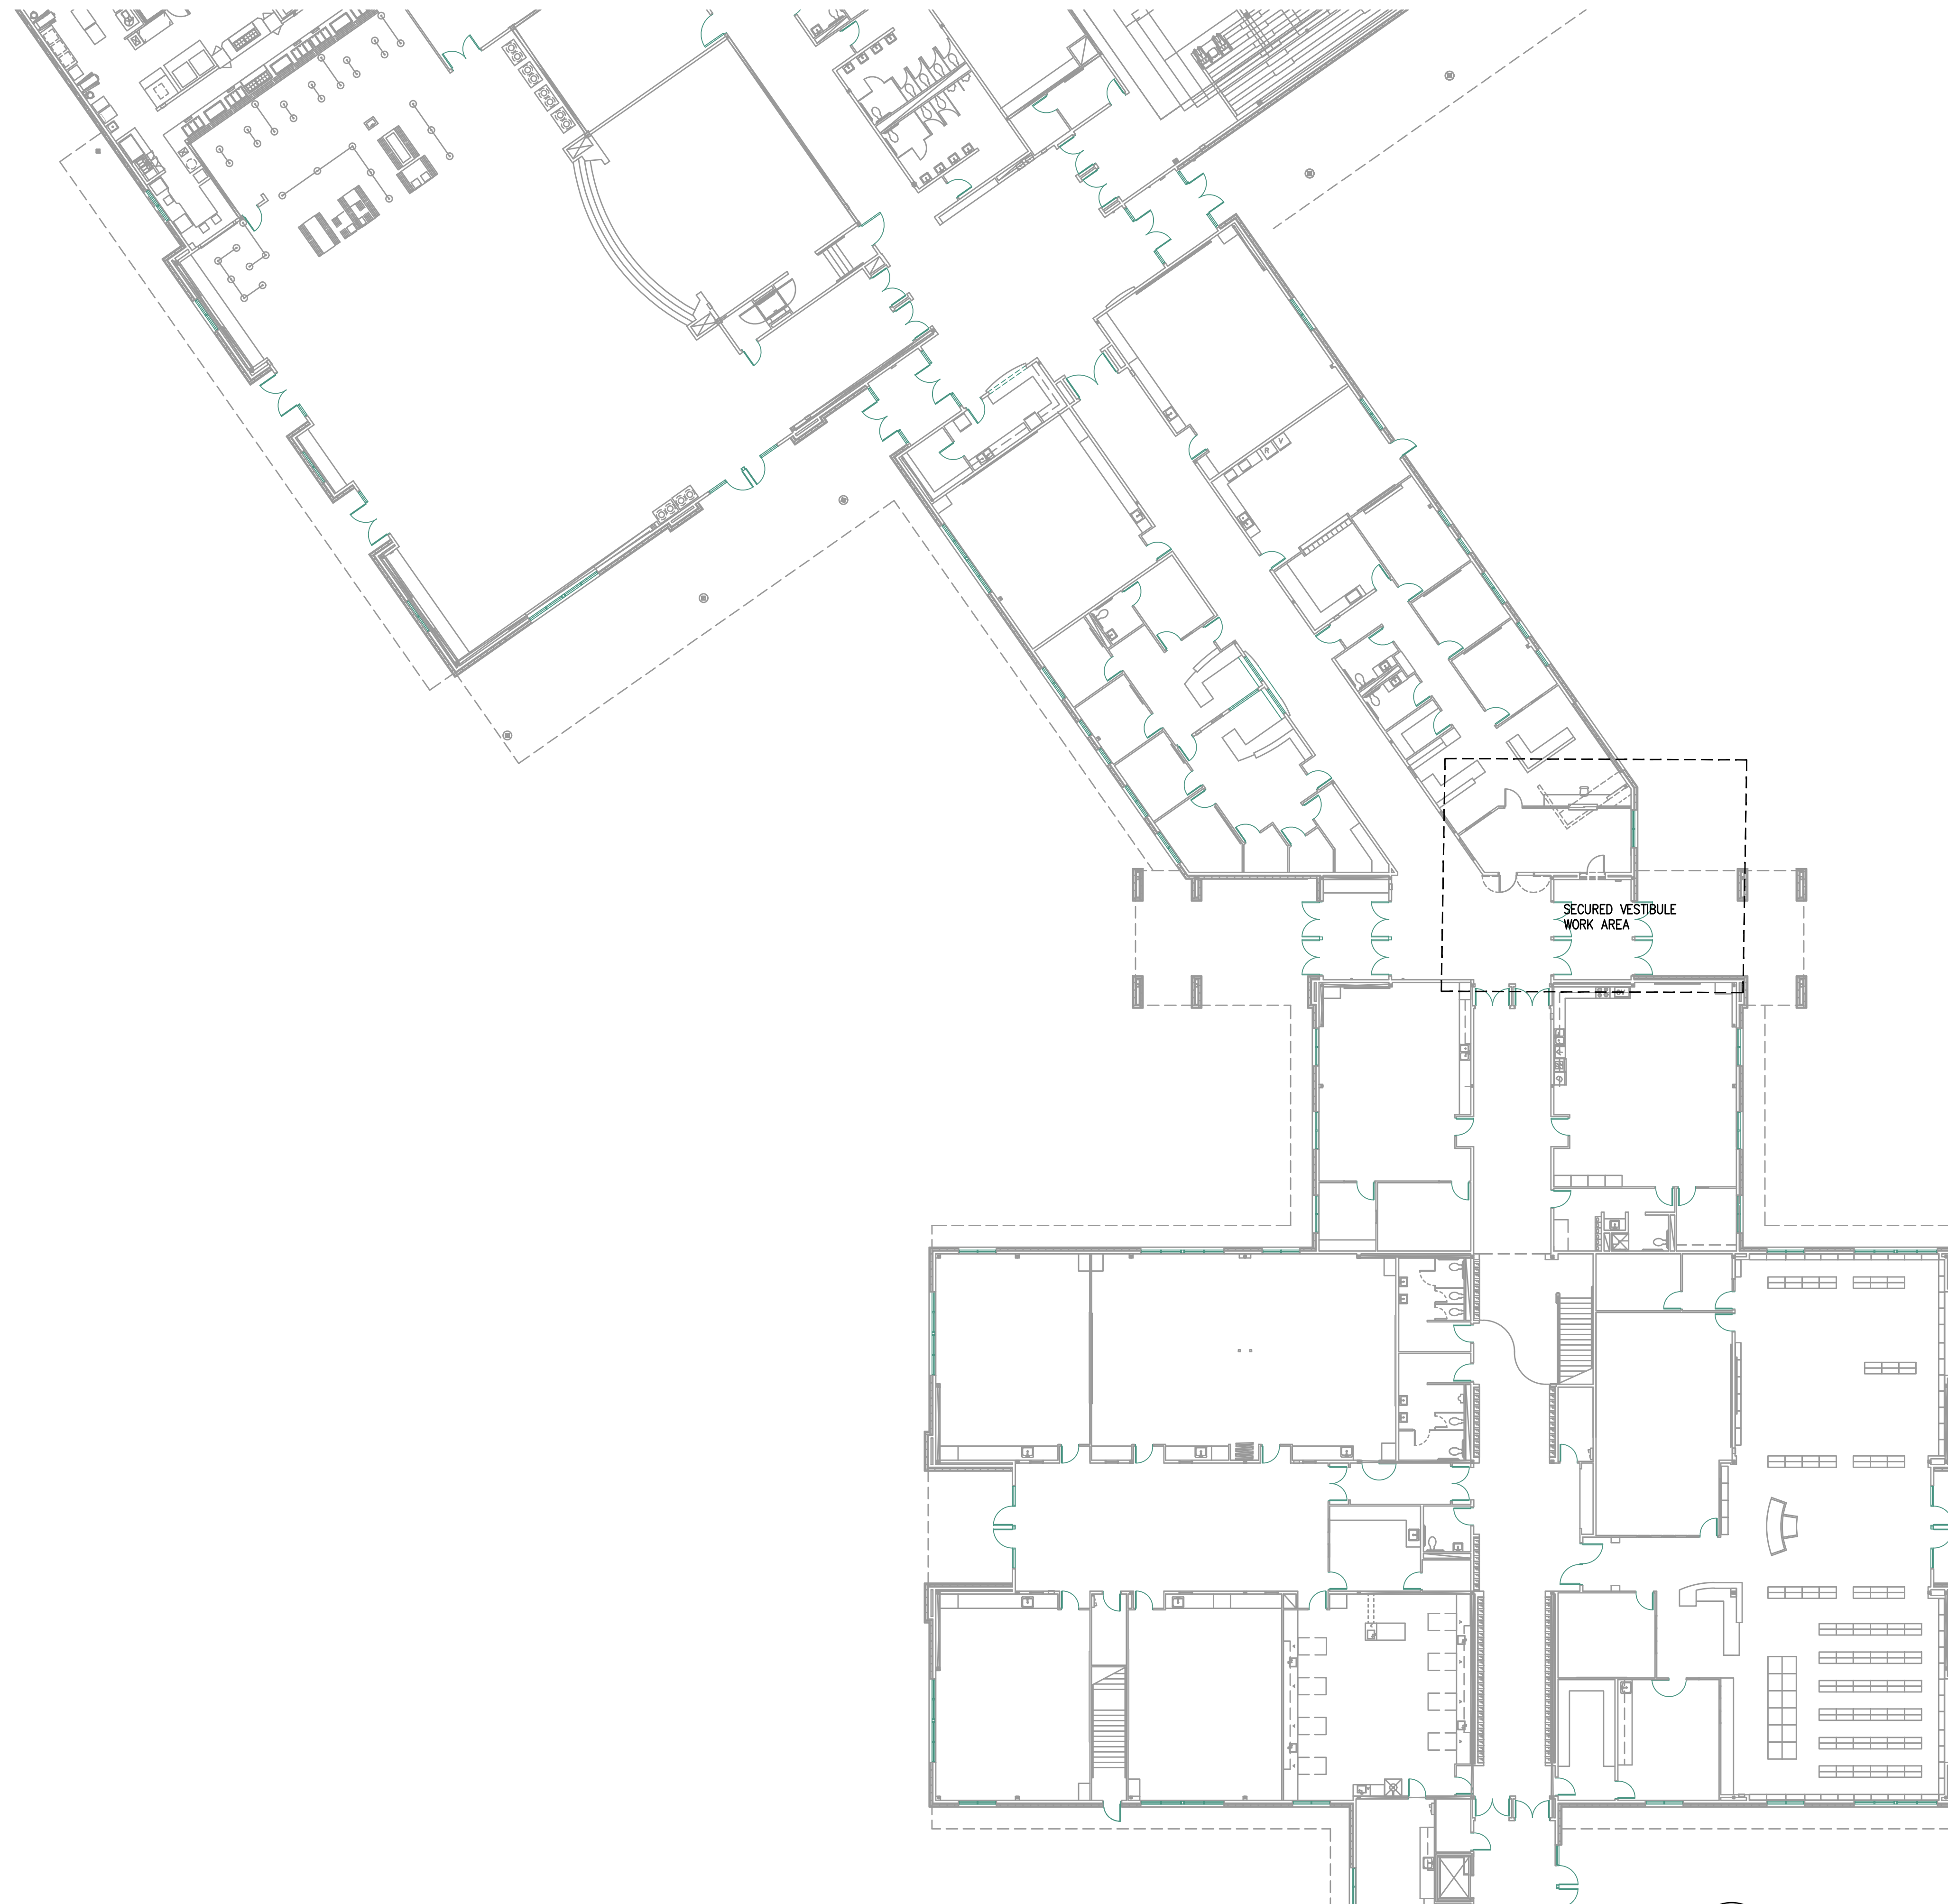

SECURED VESTIBULE
WORK AREA

1 CORE FLOOR PLAN — TELCOM
T1.1 SCALE: 1/16" = 1'-0"

MFIA Consulting Engineers
2007 S.E. Ash St.
Portland, OR 97214
PHN: (503) 234-0548
FAX: (503) 234-0677
INC. WWW.MFIA-ENG.COM
CONTACT: GARY ADOVNIK



BT

A R C H I T E C T S

1160 av Simpson Ave. - Suite 100 - Bend, Oregon 97702
t 541.382.5535 | f 541.389.8033

Bend-La Pine Schools SECURITY UPGRADES
Sky View Middle School
6355 NE 18th Street
Bend, Oregon 97701

ISSUED:	DATE:
PERMIT SET / BID SET	02/14/18

JOB NUMBER:	1708
DRAWN BY:	GMA
CHECKED BY:	RLC

SHEET TITLE

CORE
FLOOR PLAN
TELCOM

SHEET NUMBER
T1.1