


KEYED NOTES:


- 1 - 6" INSULATED OSA DUCT UP THRU ROOF WITH A MANUAL BALANCING DAMPER AND A 2-POS CONTROL DAMPER. SEE 8/M6.02 FOR DETAIL. SEE EQUIPMENT SCHEDULE FOR OSA AIRFLOW.
- 2 - 8" INSULATED OSA DUCT UP THRU ROOF WITH A MANUAL BALANCING DAMPER AND A 2-POS CONTROL DAMPER. SEE 8/M6.02 FOR DETAIL. SEE EQUIPMENT SCHEDULE FOR OSA AIRFLOW.
- 3 - UNDERCUT DOOR BY 3/4".
- 4 - TERMINATE 4" DRYER DUCT AT EXTERIOR WALL PER MFR'S INSTALLATION MANUAL.
- 5 - 14" WELDED S.S. GREASE DUCT UP THRU ROOF TO GREASE FAN.
- 6 - CONNECT 24X12 SA TO SUPPLY PLENUM ON THE GREASE HOOD. BALANCE AIRFLOW TO 560 CFM AT EACH CONNECTION.
- 7 - CONNECT 28X12 SA TO SUPPLY PLENUM ON THE GREASE HOOD. BALANCE AIRFLOW TO 662 CFM AT EACH CONNECTION.
- 8 - 10" EXHAUST DUCT FROM DISHWASHER HOOD. ROUTE UP THRU ROOF TO EXHAUST FAN.
- 9 - 14" WELDED S.S. GREASE EXHAUST DUCT UP THRU ROOF TO EXHAUST FAN.
- 10 - 18X16 SA UP THRU ROOF TO MAKE-UP AIR UNIT.
- 11 - 3" PP COMBUSTION AIR/ VENT FROM WATER HEATERS UP THRU ROOF. TERMINATE WITH A CONCENTRIC FITTING. SEE 7/M6.02.
- 12 - 24X12 TRANSFER GRILLE
- 13 - 8X6 SA/RA 125 CFM
- 14 - 24X24 EGG CRATE RA GRILLE

GENERAL NOTES:

1. SEE 1/P6.01 FOR SEISMIC PIPE SUPPORT.
2. SEE 2/P6.01 FOR NON-SEISMIC PIPE SUPPORT.
3. SEE 3/P6.01 FOR ACOUSTICAL WALL PENETRATION DETAIL.

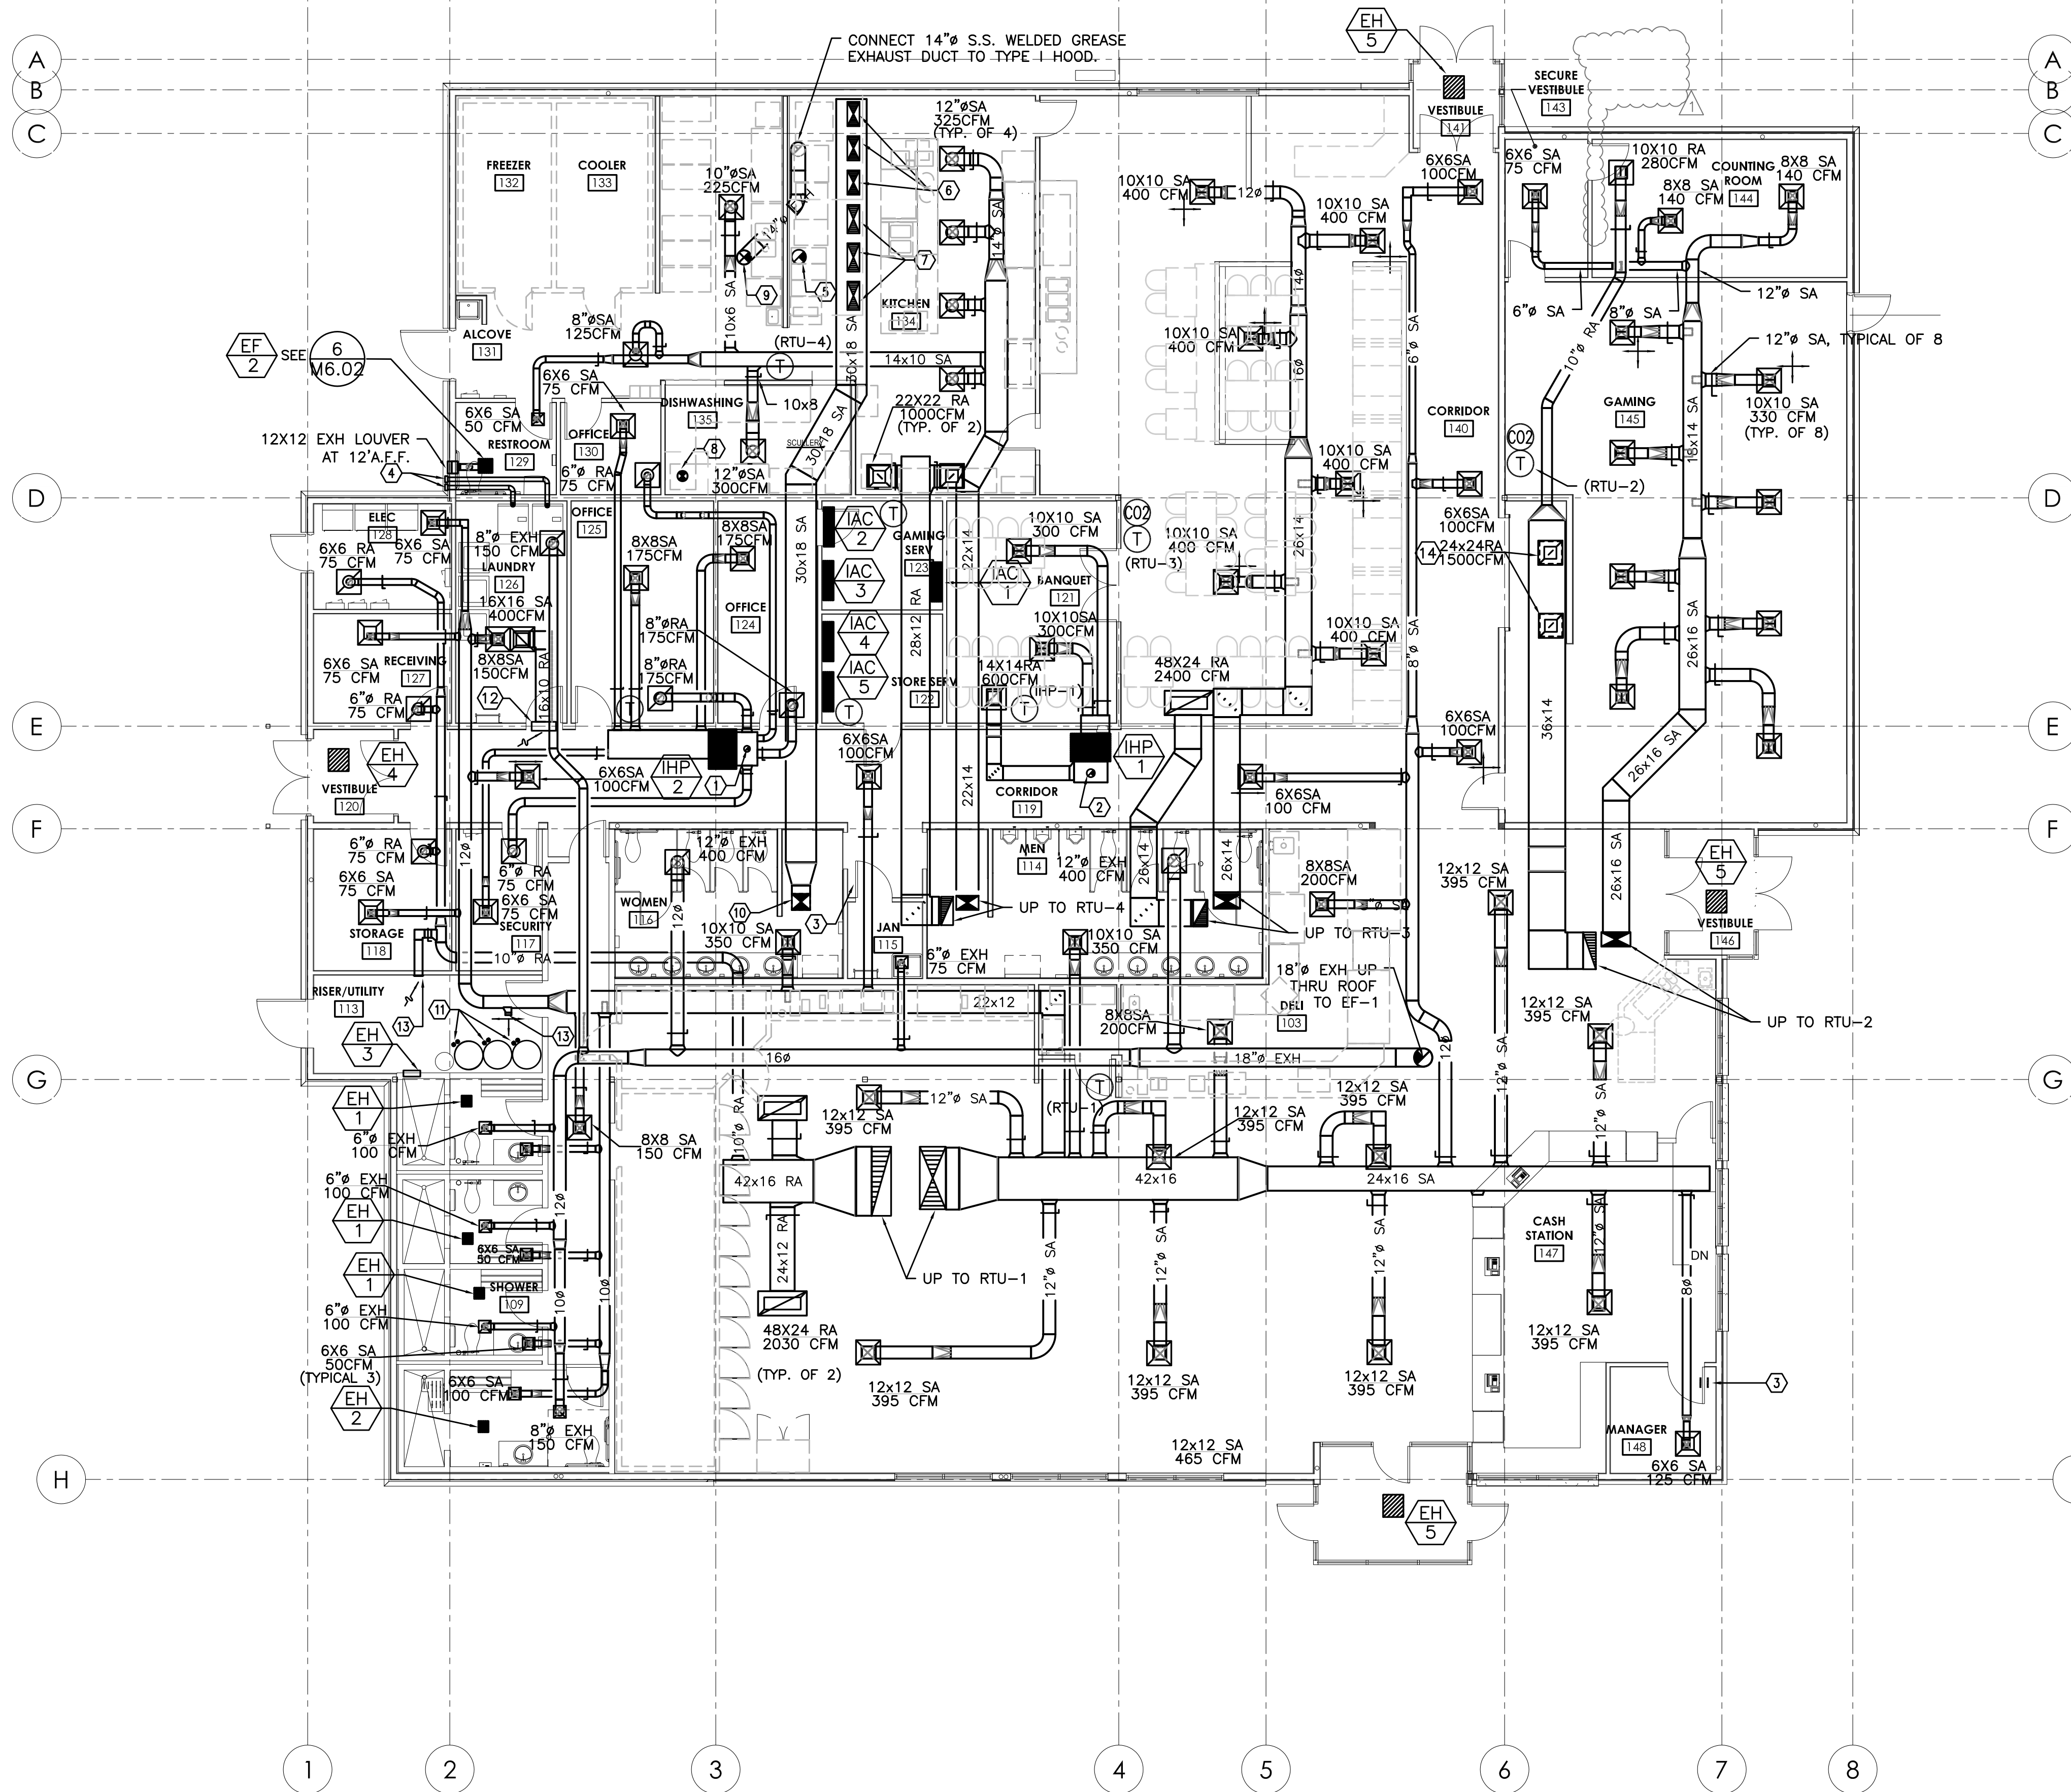

1 HVAC FLOOR PLAN
M2.01 SCALE: 1/8" = 1'-0"

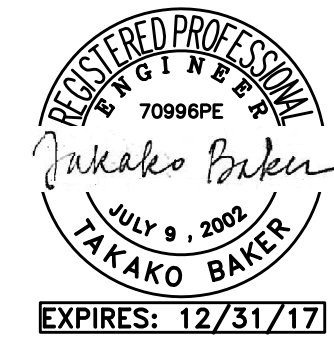

BBT
ARCHITECTS

1160 sw Simpson Ave. - Suite 100 - Bend, Oregon 97702
1.541.382.5535 | 1.541.389.8033

M
Consulting Engineers
2007 S.E. Ash St.
Portland, OR 97214
PHN: (503) 234-0548
FAX: (503) 234-0577
E-MAIL: WWW.MFIA-ENG.COM
CONTACT: TAKAKO BAKER

WARM SPRINGS TRAVEL CENTER

Madras, OR

No.	Description	Date
1	Owner/CMGC Revisions	10/19/2016

Project Number	1519
Date	OCT 19, 2016
Drawn By	TB
Checked By	TB

HVAC FLOOR
PLAN

M2.01

BID SET