
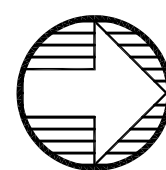


KEYED NOTES:

- ① - 1/2" CW/HW & 1-1/2" V UP THRU SLAB IN WALL TO CEILING SPACE.
- ② - 1/2" CW/HW UP THRU SLAB AND CONNECT TO SINK. SEE 2/P6.01 FOR DETAIL.
- ③ - 1/2" CW UP THRU SLAB IN WALL TO CEILING SPACE.
- ④ - 1/2" CW UP THRU SLAB TO FILL FAUCET.
- ⑤ - 1-1/2" V UP IN WALL.
- ⑥ - 3" HUB DRAIN FOR CONDENSATE DRAINS FROM COOLER/FREEZER EVAPORATOR COILS.

GENERAL NOTES:

1. SEE P4.01 FOR CONDENSATE PIPING AND REFRIGERANT PIPING PLAN.
2. SEE 1/M6.03 FOR DUCT SUPPORT.
3. SEE 2/M6.03 FOR PIPE SUPPORT.
4. SEE 3/M6.03 FOR SEISMIC DUCT SUPPORT.
5. SEE 4/M6.03 FOR SEISMIC PIPE SUPPORT.

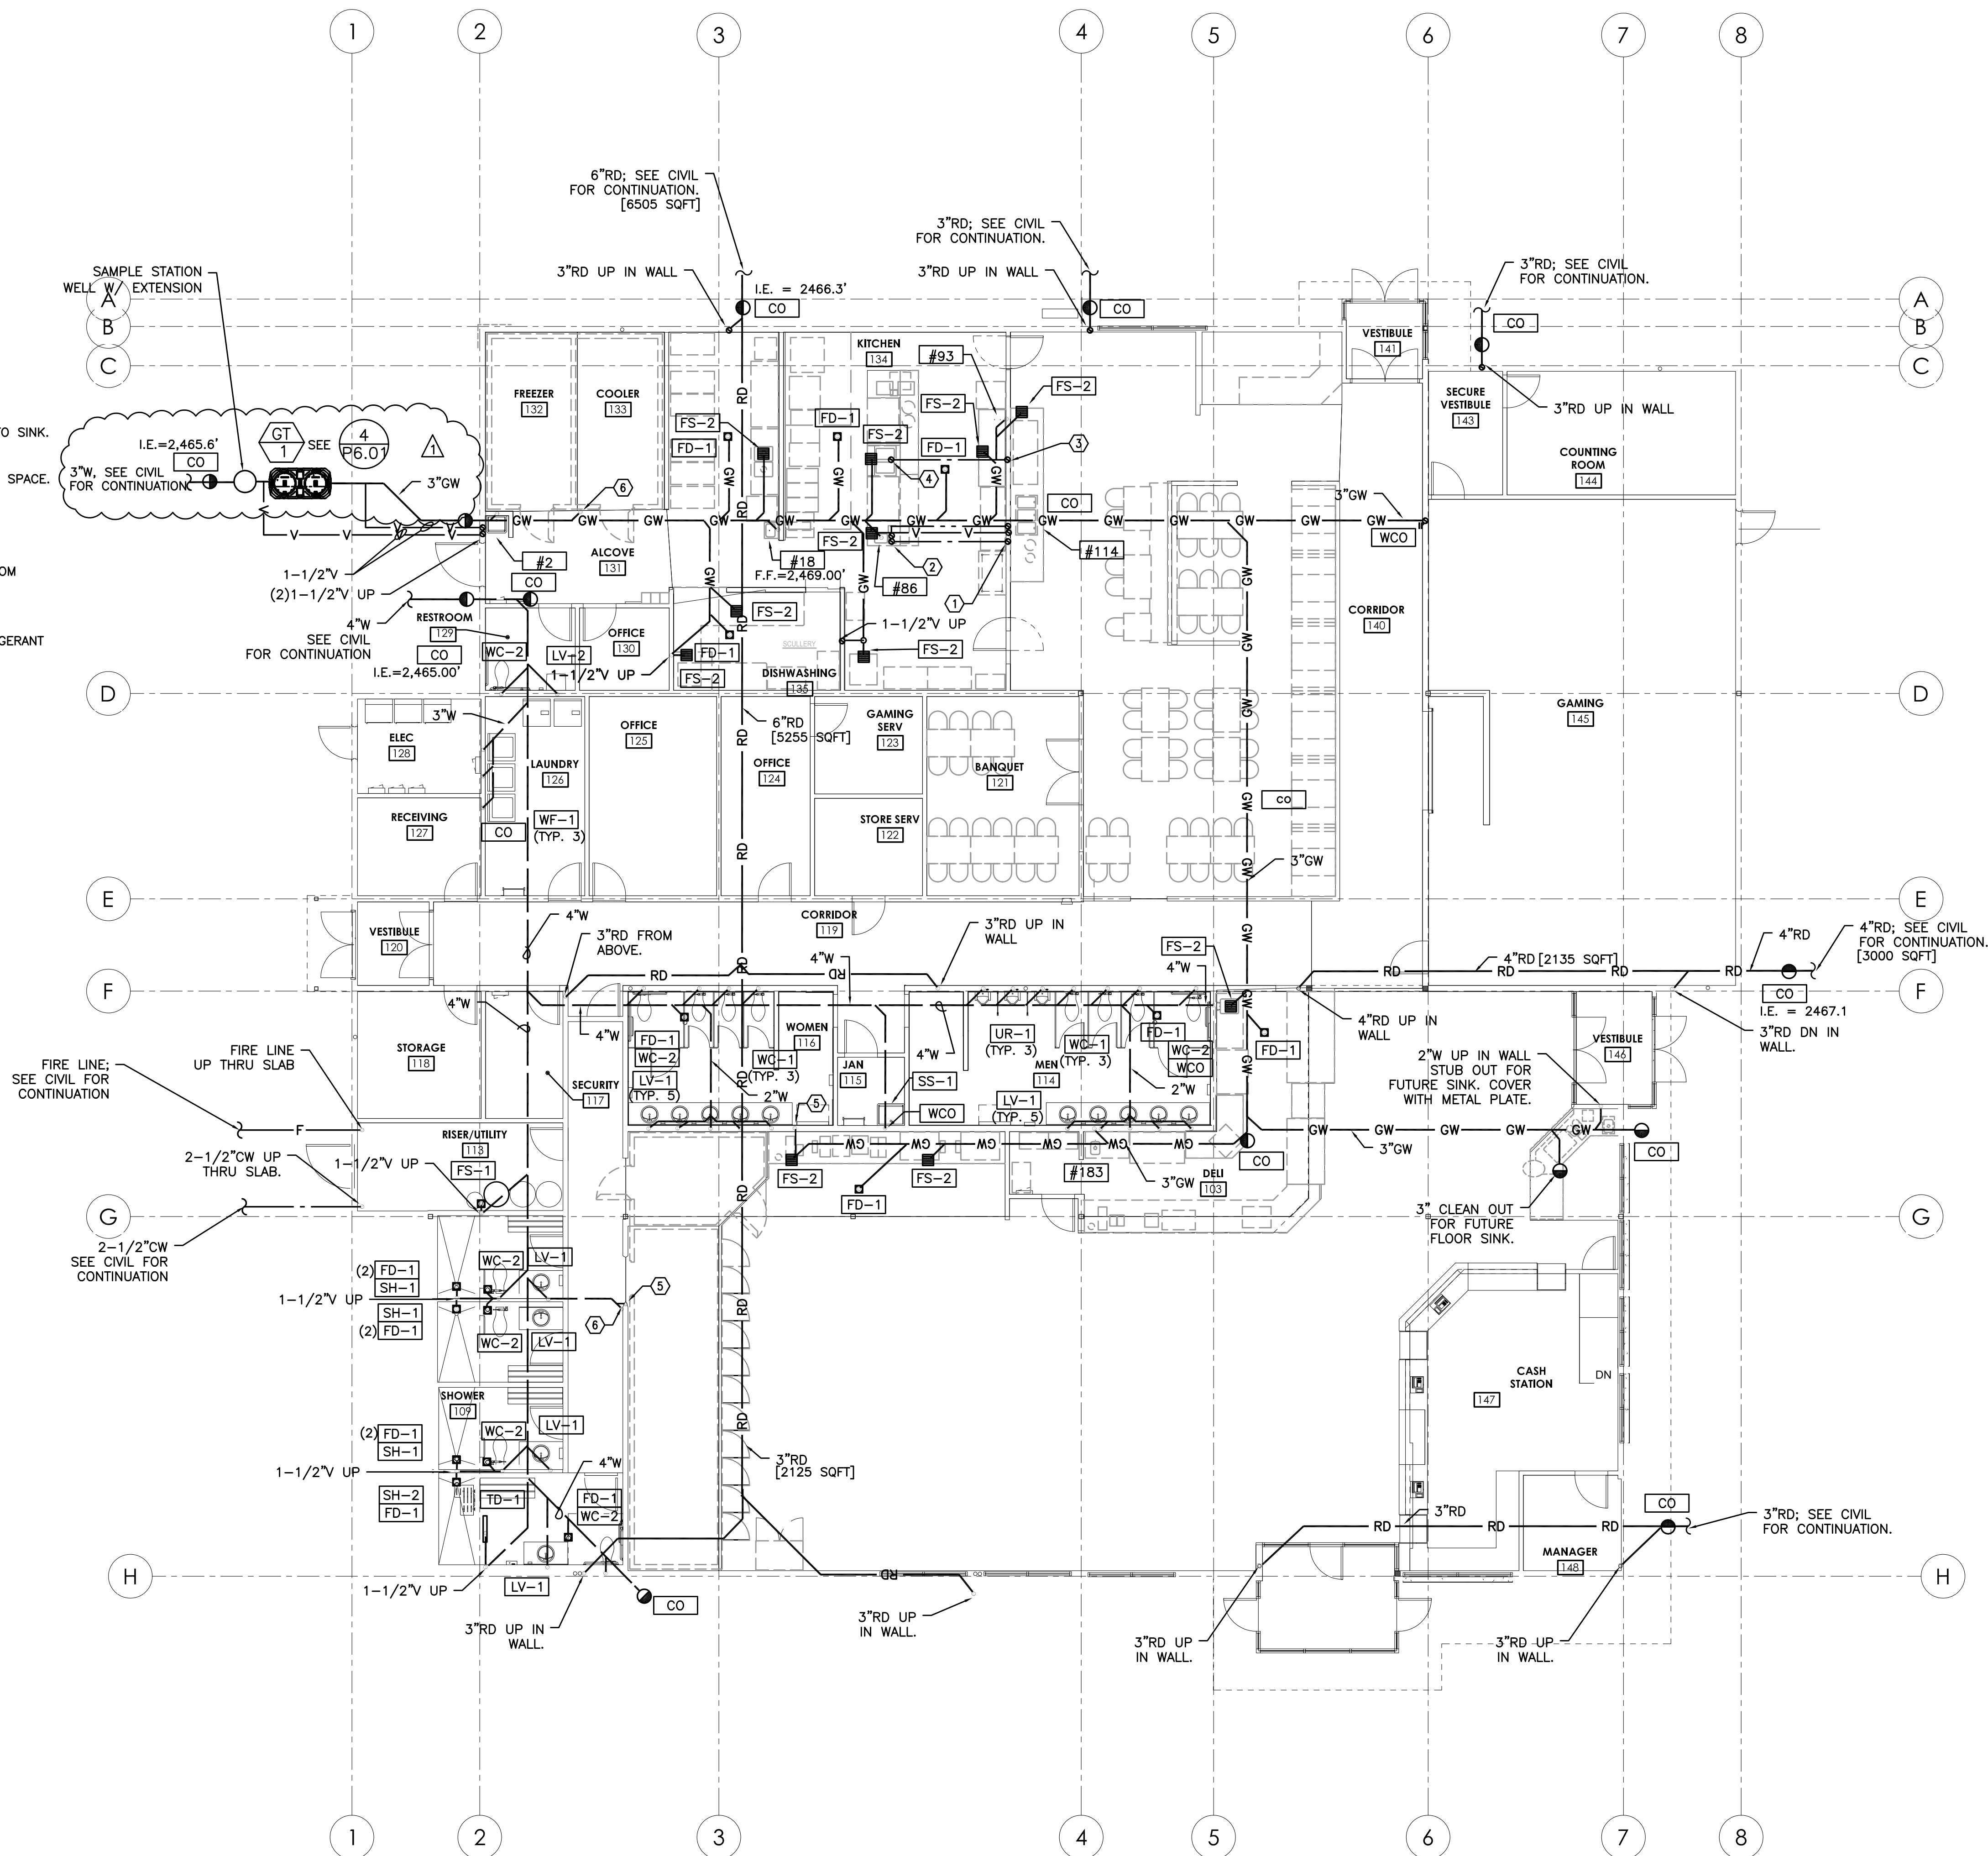

1 UNDER SLAB PLUMBING PLAN  
P2.01 SCALE: 1/8" = 1'-0"



**B B T**  
ARCHITECTS  
1160 sw Simpson Ave. - Suite 100 - Bend, Oregon 97702  
1.541.382.5535 | 1.541.389.8033

**FM**  
Consulting Engineers  
2007 S.E. Ash St.  
Portland, OR 97214  
PHN: (503) 234-0548  
FAX: (503) 234-0677  
WWW.FMIA-ENG.COM  
CONTACT: TAKAKO BAKER

WARM SPRINGS TRAVEL CENTER  
Madras, OR

| No. | Description          | Date       |
|-----|----------------------|------------|
| 1   | Owner/CMGC Revisions | 10/19/2016 |
|     |                      |            |
|     |                      |            |
|     |                      |            |

Project Number 1519  
Date AUGUST 22, 2016  
Drawn By TB  
Checked By JVB

UNDER SLAB  
PLUMBING  
PLAN

P2.01

BID SET