



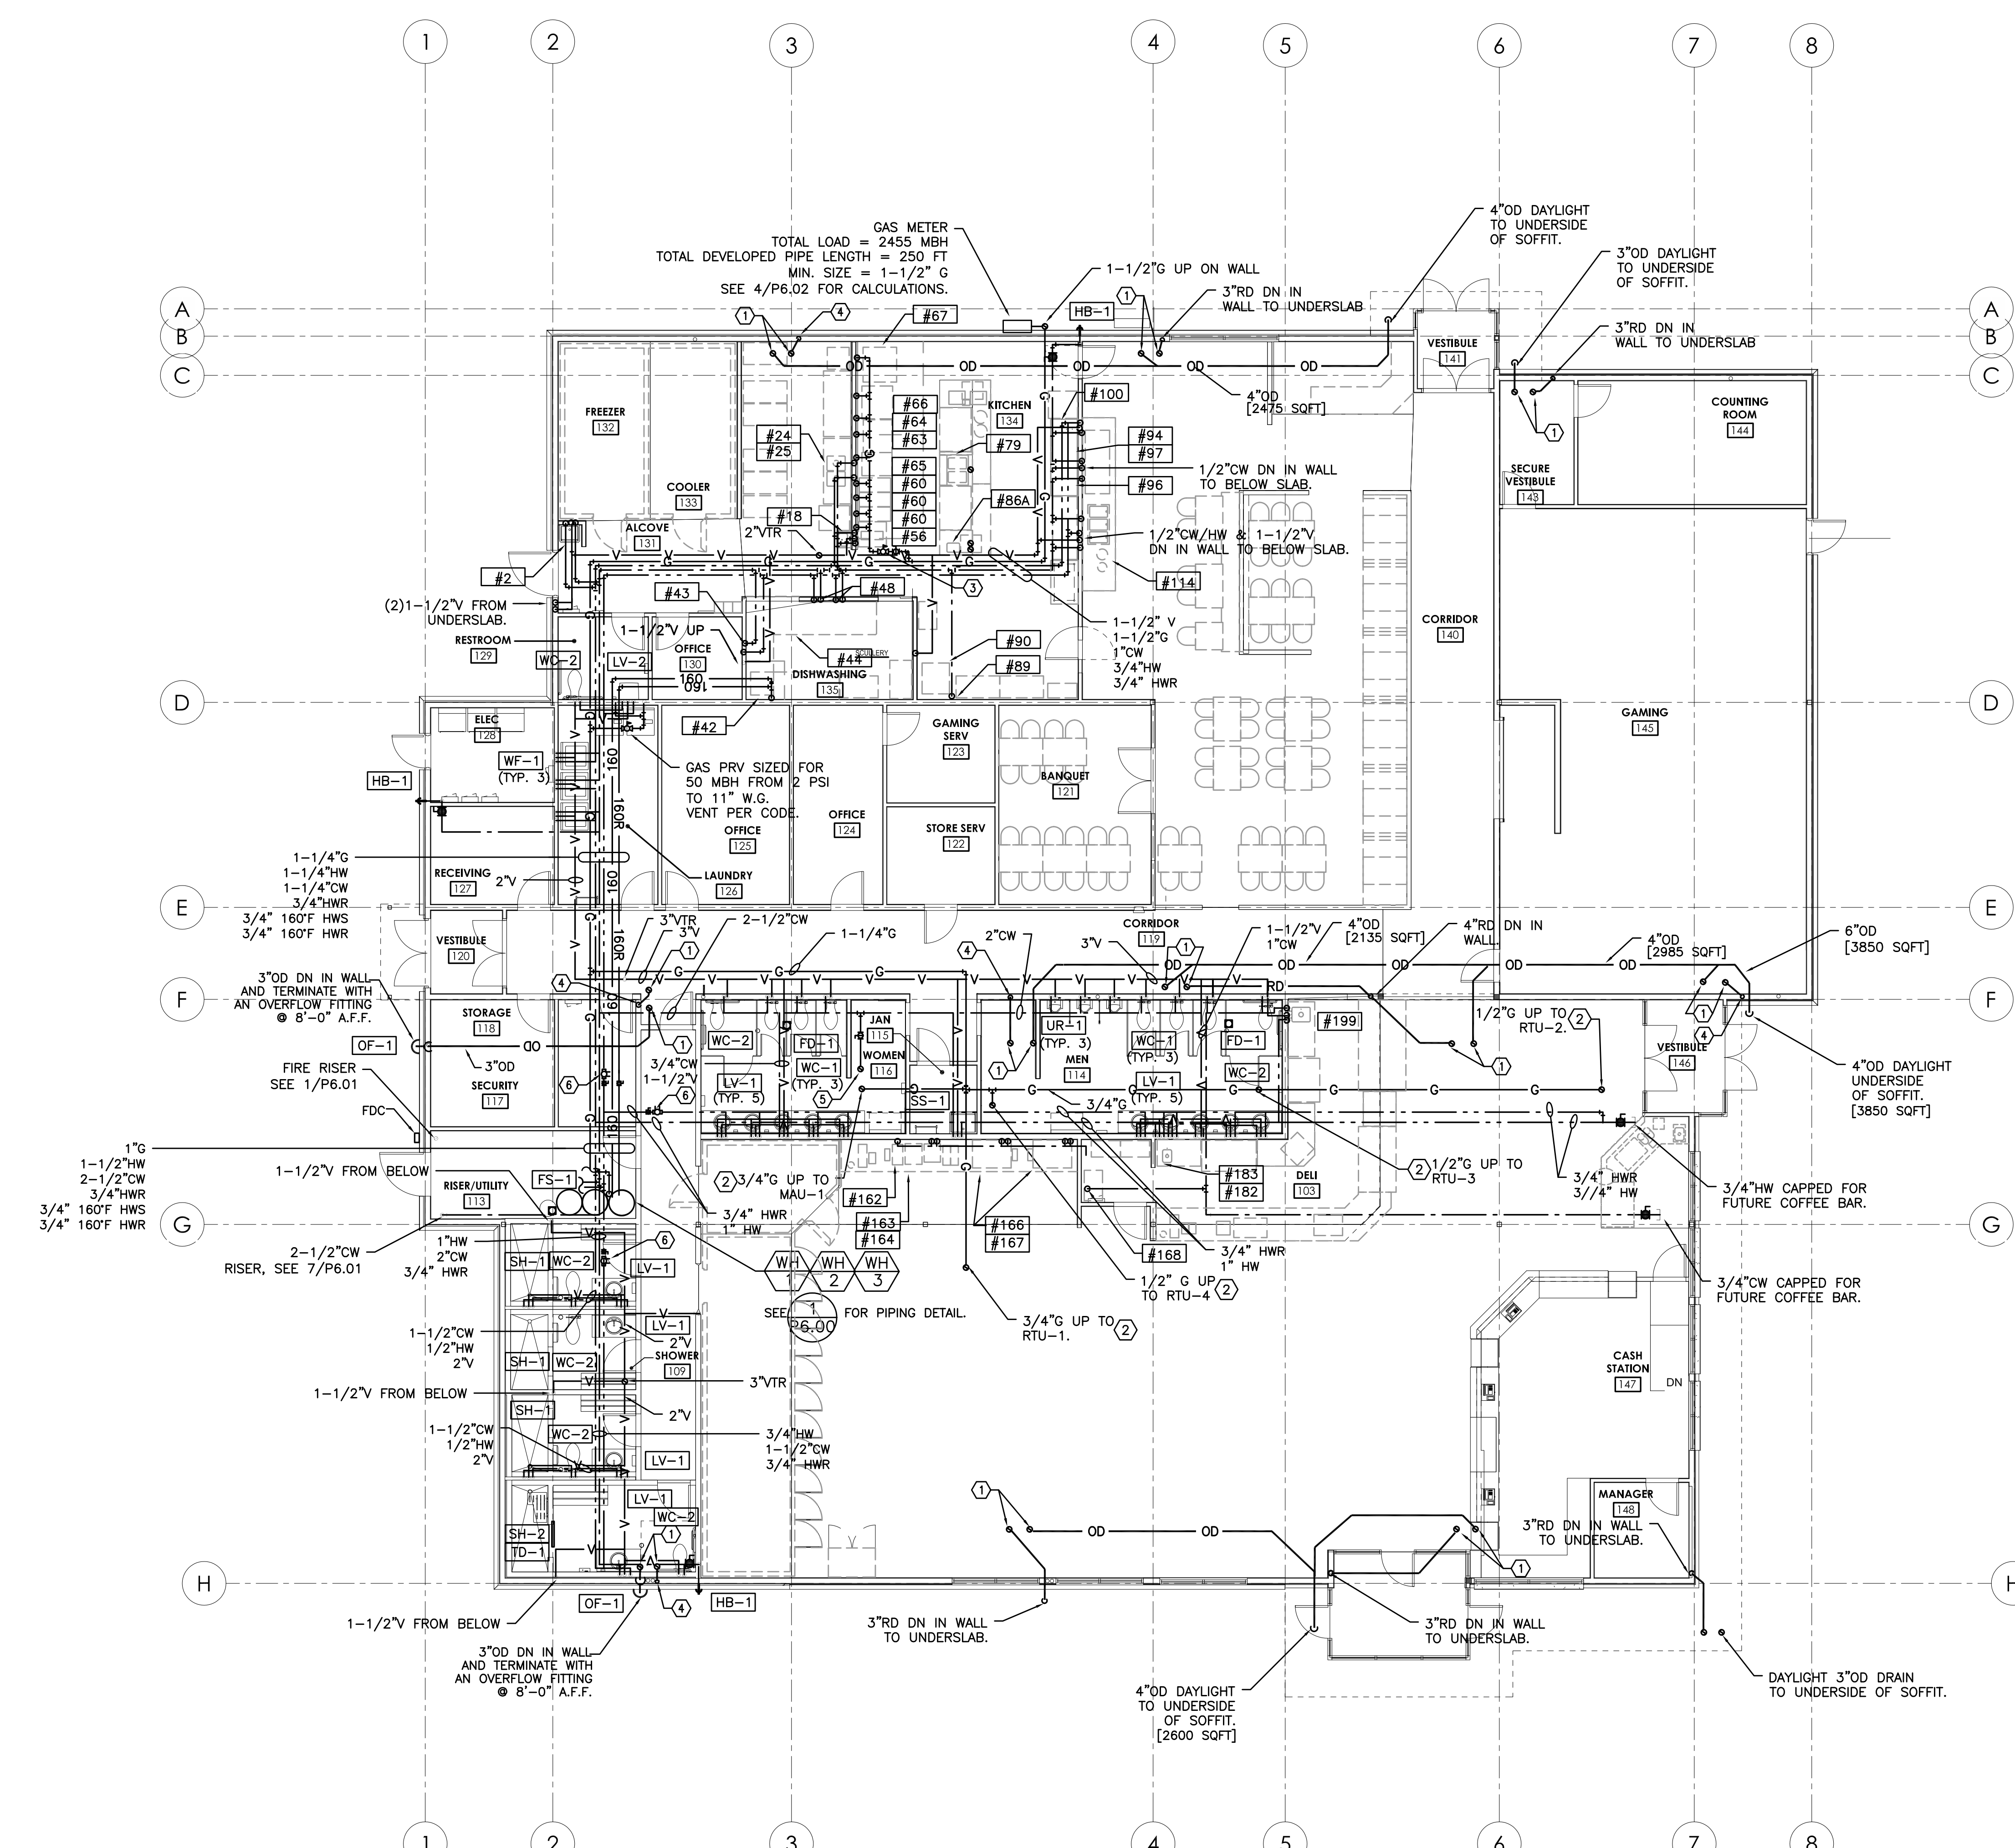

- KEYED NOTES:**
- ① - 3"RD / OD FROM ABOVE.
 - ② - INSTALL GAS PIPE UP THRU CURB TO ROOF TOP EQUIPMENT, AND INSTALL A PRV SIZED FOR EQUIPMENT GAS LOAD FROM 2 PSI TO 7" W.G. SEE 1/M601 AND 2/M601 FOR DETAIL.
 - ③ - PRV AND GAS AUTO SHUT-OFF. GAS PRV SIZED FOR 687 MBH FROM 2 PSI SEE 5/P6.01 FOR DETAIL.
 - ④ - 3"RD DN IN WALL TO BELOW SLAB.
 - ⑤ - 1/2"CW MAKE-UP WATER TO MAKE-UP AIR UNIT ON ROOF. INSTALL WITH DOUBLE CHECK BACK-FLOW PREVENTER.
 - ⑥ - GRISWOLD AUTOMATIC FLOW CONTROL VALVE, SET TO 1 GPM.
- GENERAL NOTES:**
- 1. SEE P4.01 FOR CONDENSATE PIPING AND REFRIGERANT PIPING PLAN.
 - 2. SEE 1/M6.03 FOR DUCT SUPPORT.
 - 3. SEE 2/M6.03 FOR PIPE SUPPORT.
 - 4. SEE 3/M6.03 FOR SEISMIC DUCT SUPPORT.
 - 5. SEE 4/M6.03 FOR SEISMIC PIPE SUPPORT.
 - 6. SEE 4/P6.02 FOR GAS PIPING ISOMETRIC AND CALCULATIONS.

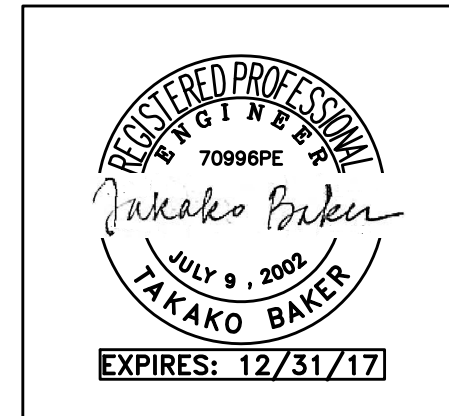

BBT
ARCHITECTS
1160 sw Simpson Ave., Suite 100 - Bend, Oregon 97702
1.541.382.5535 | 1.541.389.8033

MFA
Consulting Engineers
2007 S.E. Ash St.
Portland, OR 97214
PHN: (503) 234-0548
FAX: (503) 234-0677
WWW.MFA-ENG.COM
CONTACT: TAKAKO BAKER

WARM SPRINGS TRAVEL CENTER
Madras, OR

No.	Description	Date
1	Owner/CMGC Revisions	10/19/2016

Project Number 1519
Date OCT. 19, 2016
Drawn By TB
Checked By JVB

PLUMBING
FLOOR PLAN

P2.02

1 PLUMBING FLOOR PLAN
P2.02 SCALE: 1/8"=1'-0"

BID SET