


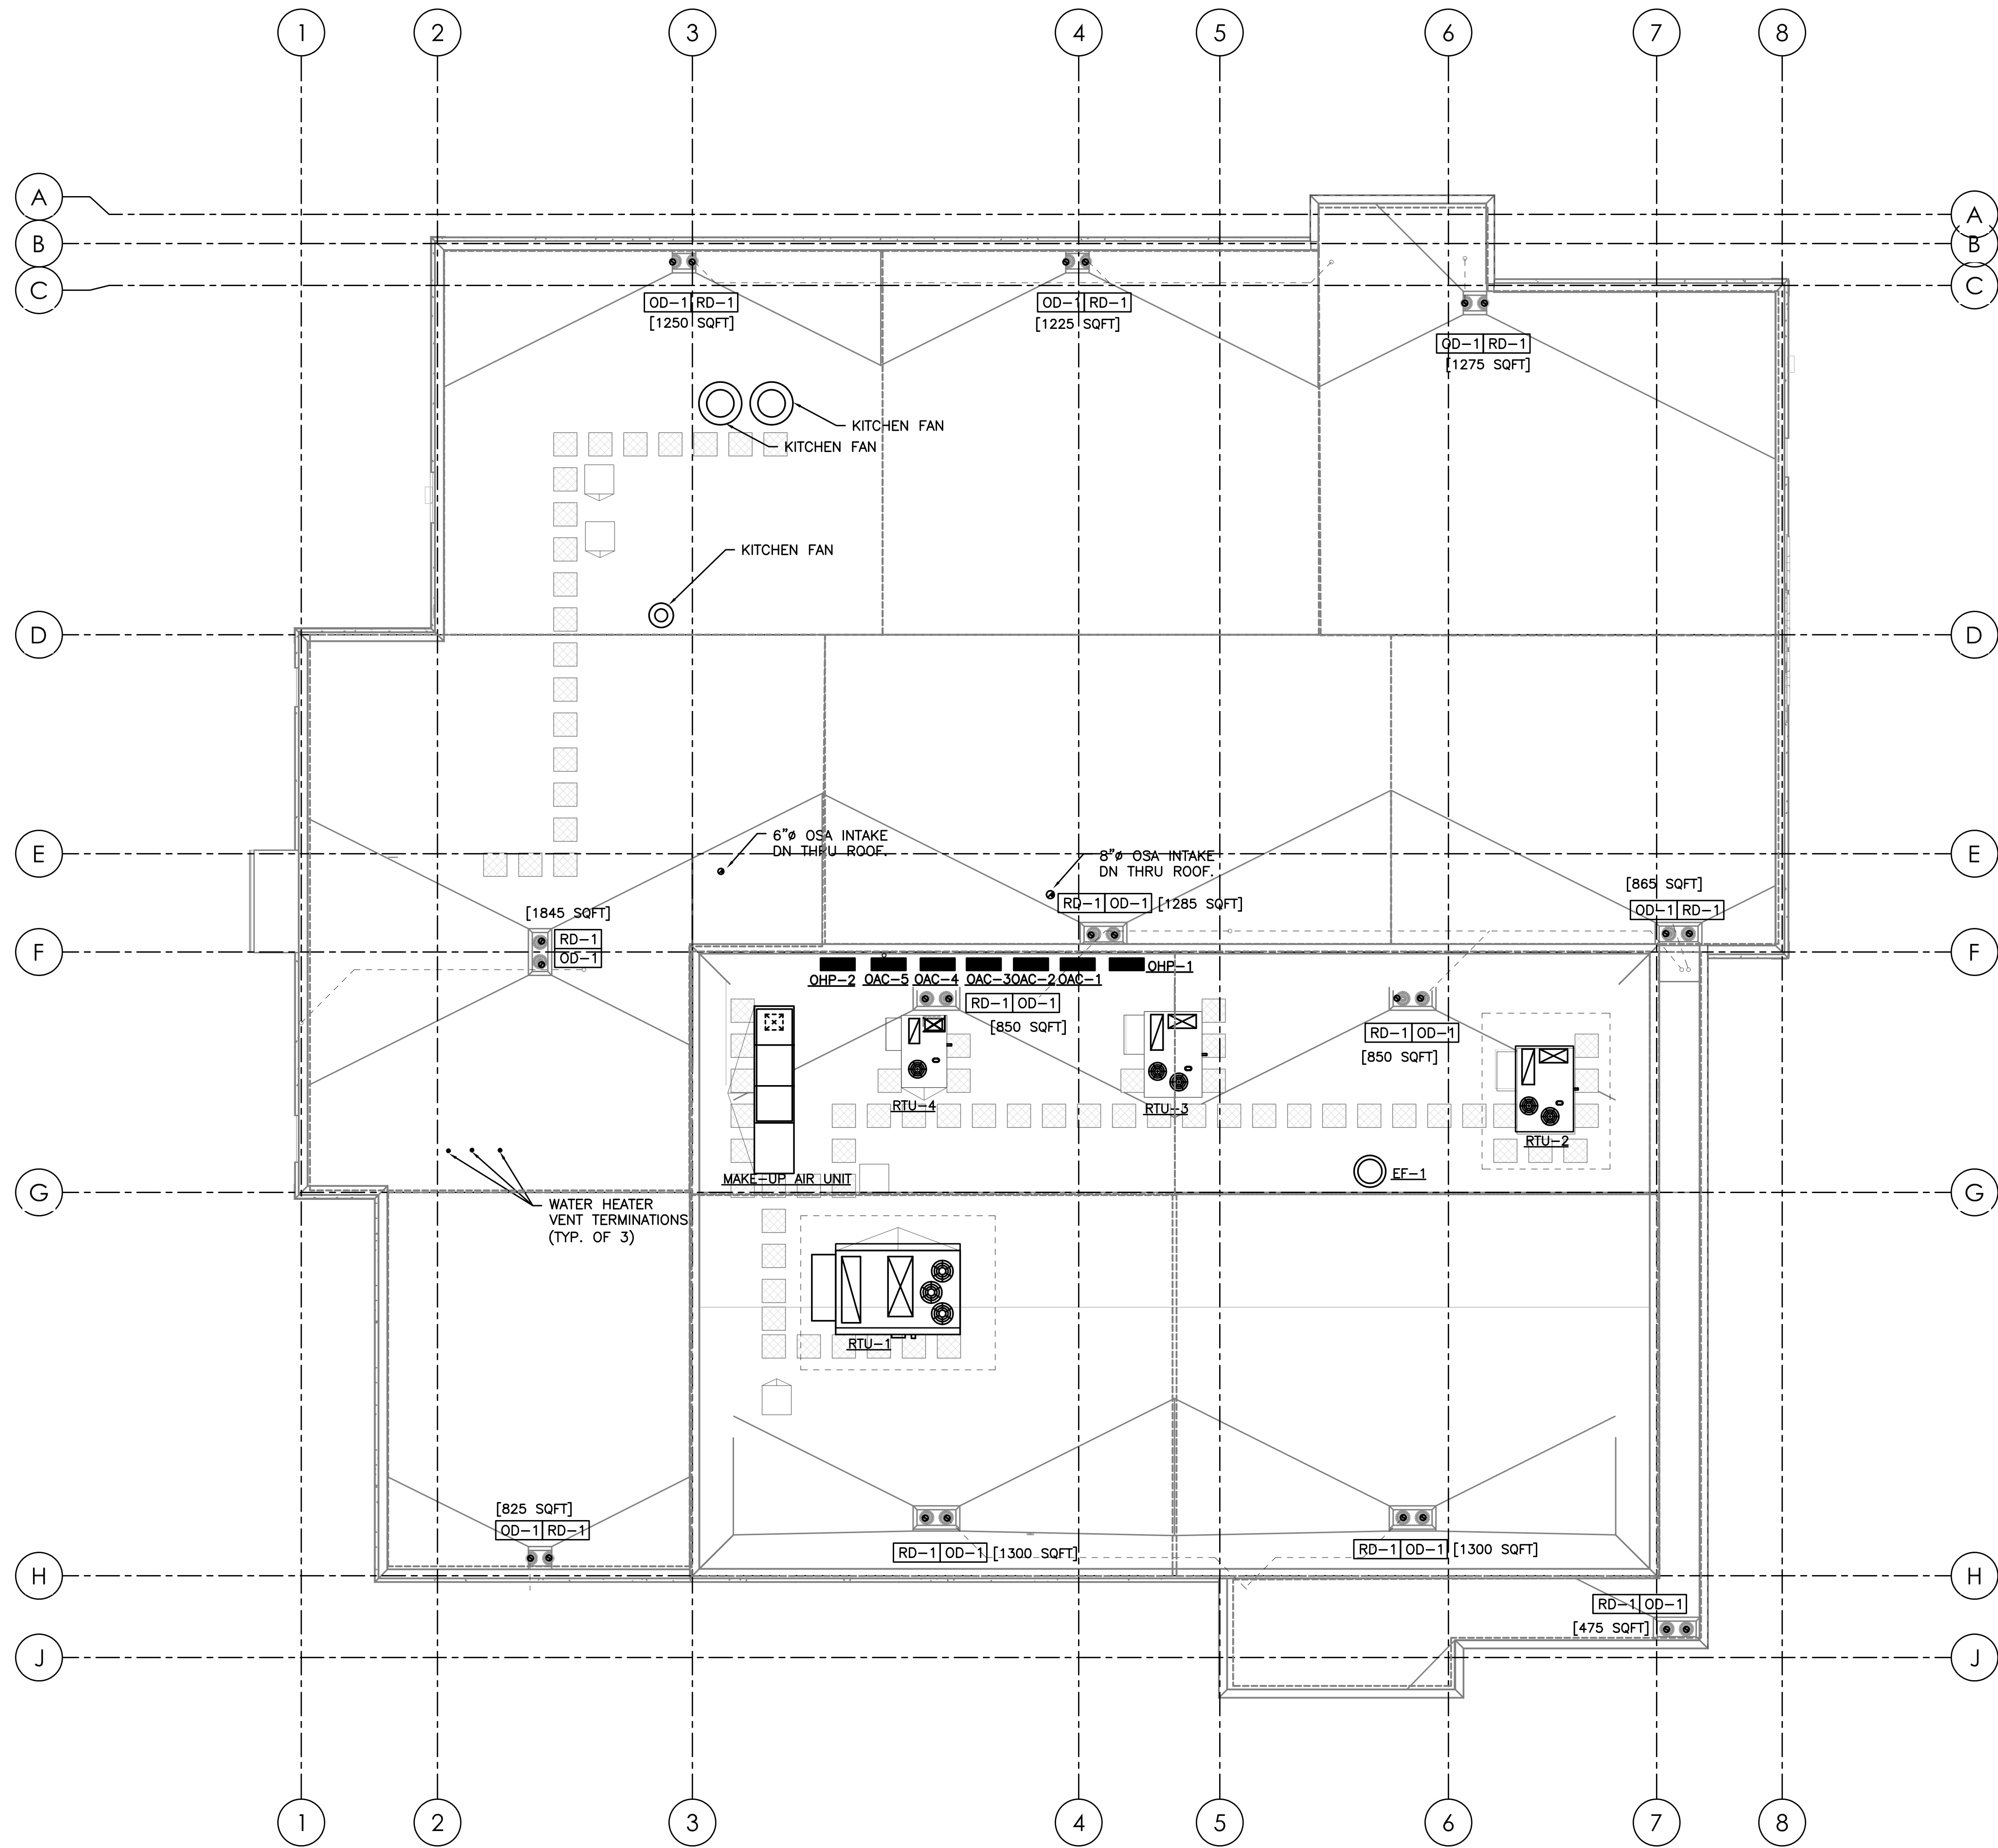

1 HVAC ROOF PLAN
M3.01 SCALE: 1/8" = 1'-0"



BBT
ARCHITECTS
1160 sw Simpson Ave. - Suite 100 - Bend, Oregon 97702
1.541.382.5535 | 1.541.389.8033

MFA Consulting Engineers
2007 S.E. Ash St.
Portland, OR 97214
PHN: (503) 234-0548
FAX: (503) 234-0877
INC. WWW.MFA-ENG.COM
CONTACT: TAKAKO BAKER

WARM SPRINGS TRAVEL CENTER

Madras, OR

No.	Description	Date
1	Owner/CMGC Revisions	10/19/2016

Project Number	1519
Date	OCT. 19, 2016
Drawn By	TB
Checked By	TB

PLUMBING
ROOF PLAN

P3.01

BID SET