
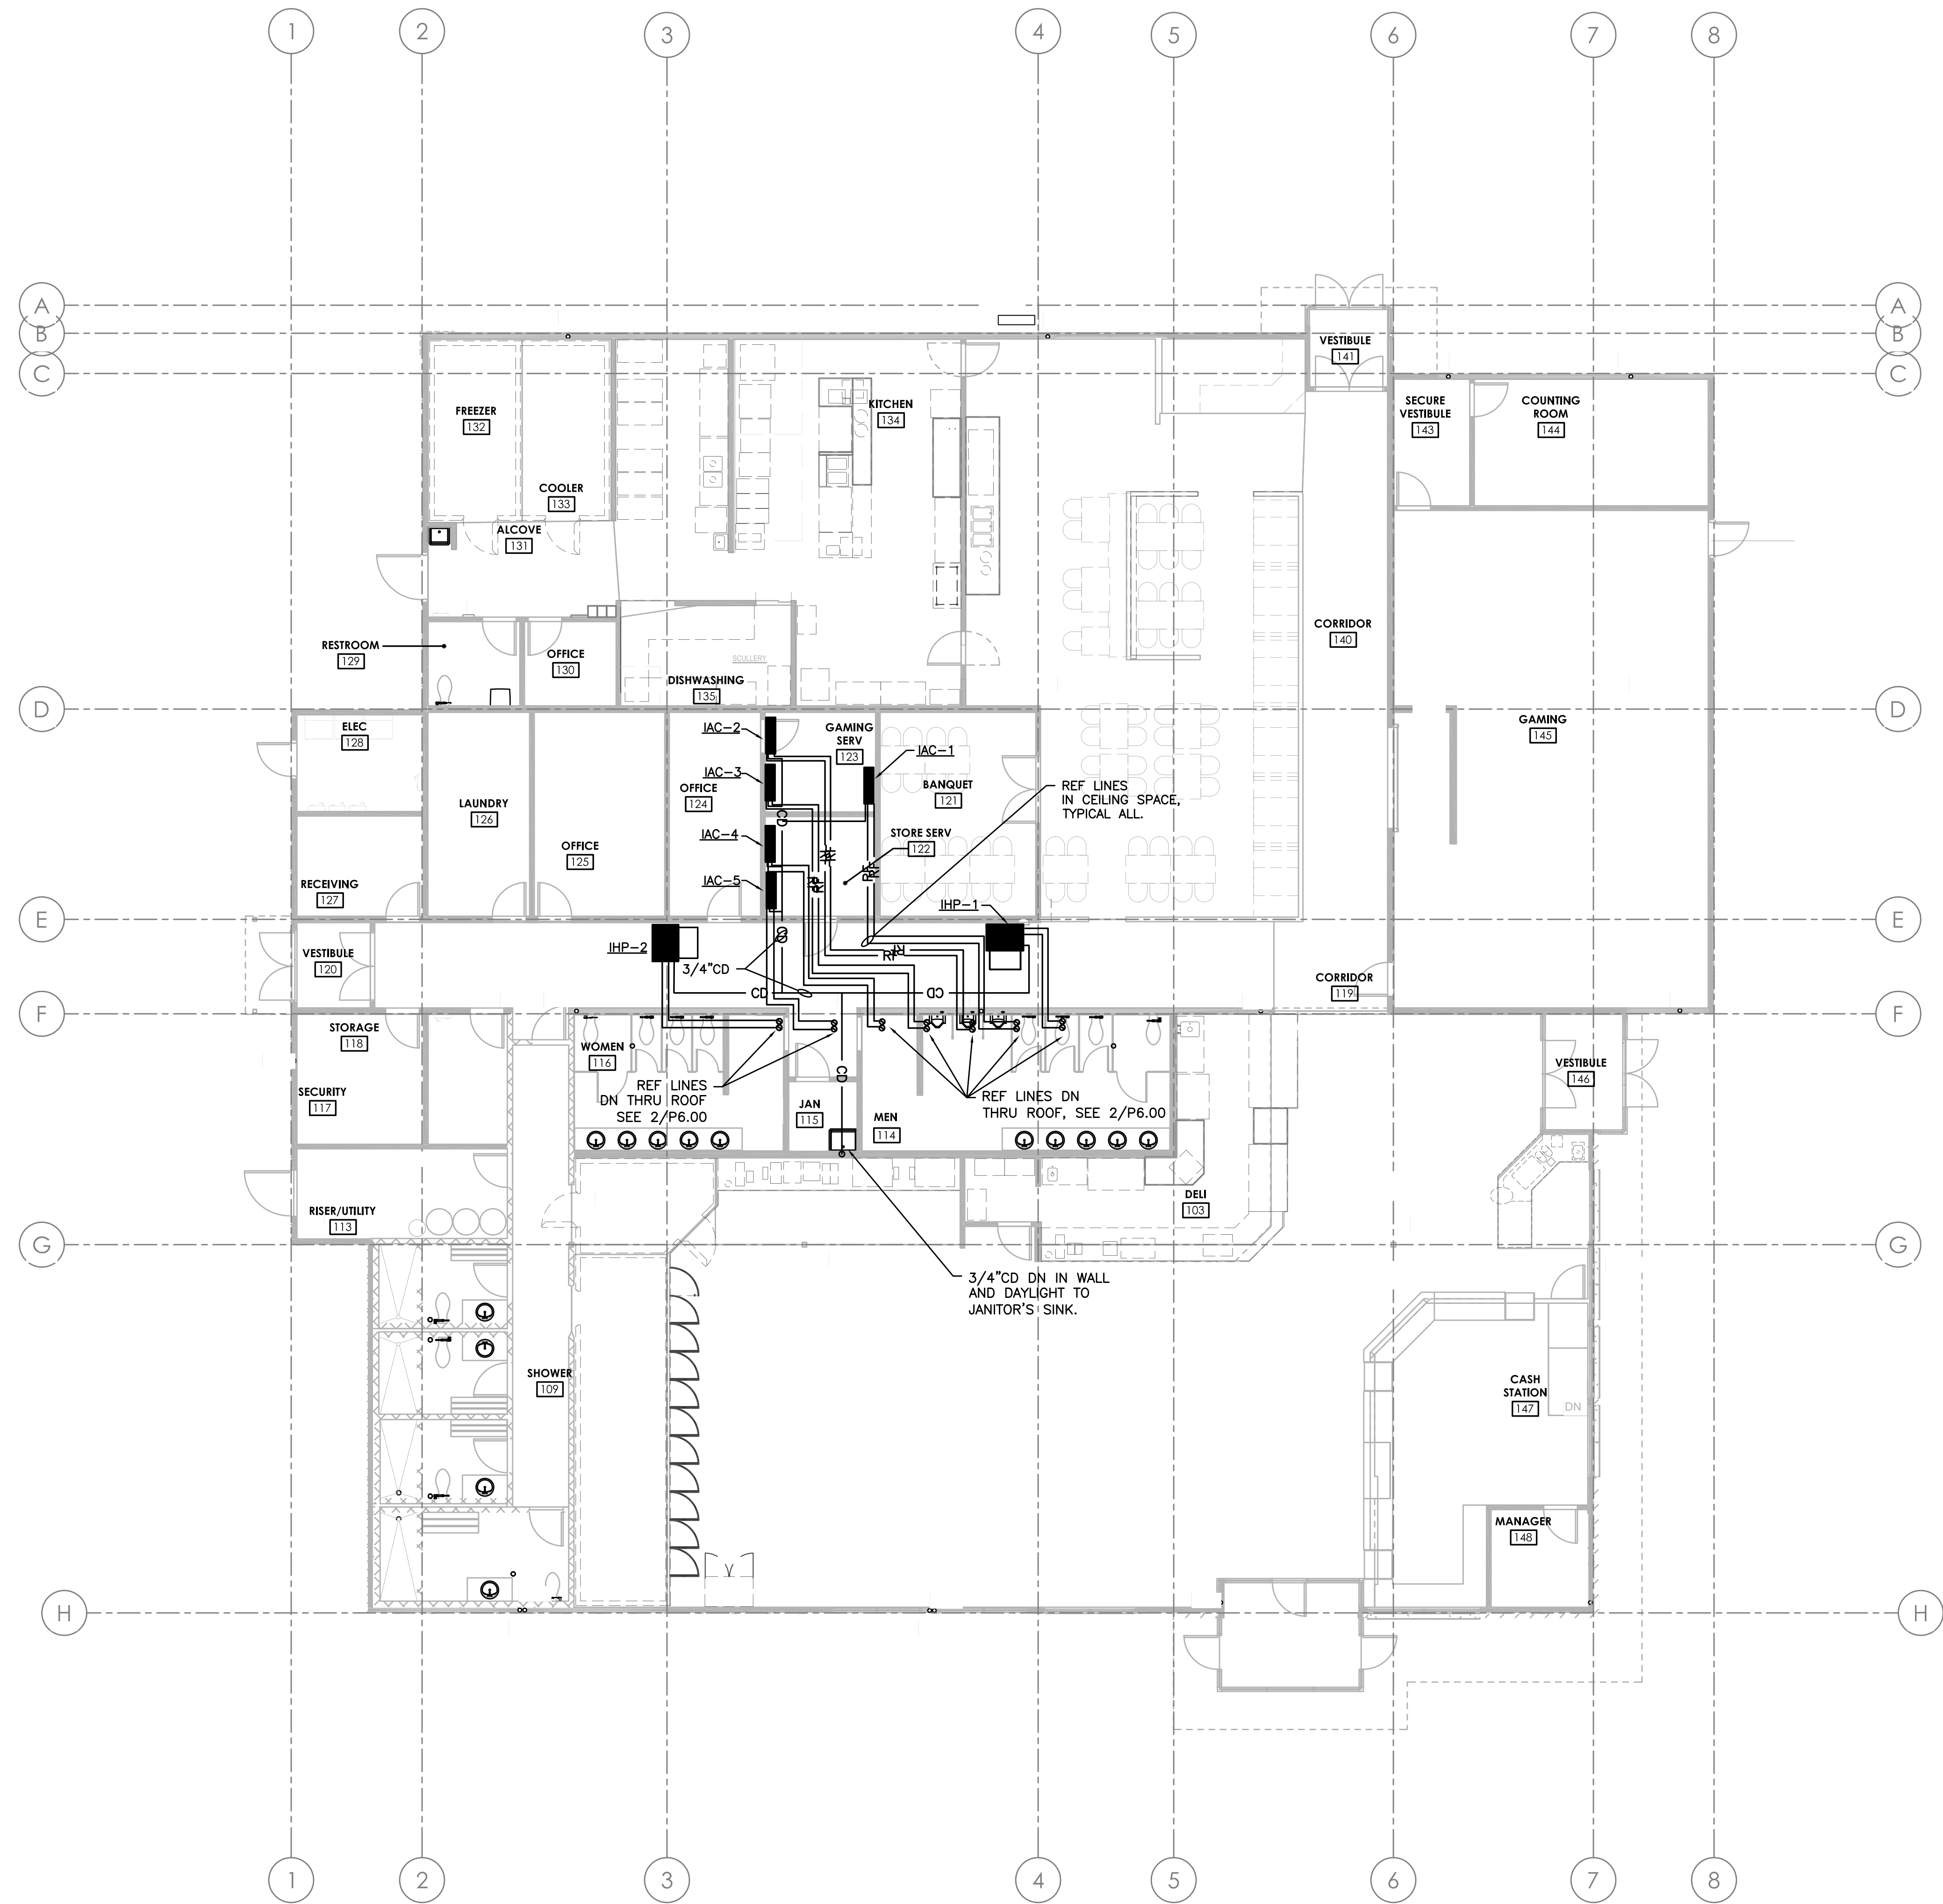


1 CONDENSATE DRAIN AND REF PIPING PLAN
P4.01
SCALE: 1/8" = 1'-0"

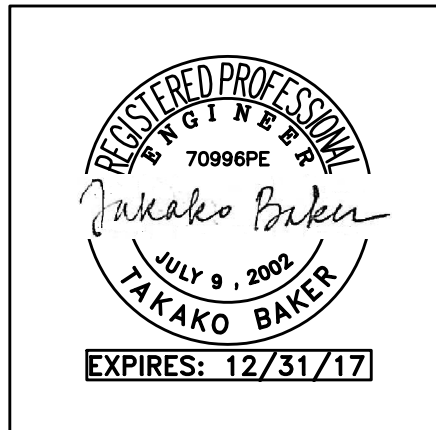

B B T
ARCHITECTS
1160 sw Simpson Ave., Suite 100 - Bend, Oregon 97702
1.541.382.5535 | 1.541.389.8033

M E I A
Consulting Engineers
2007 S.E. Ash St.
Portland, OR 97214
PHN: (503) 234-0548
FAX: (503) 234-0677
WWW.MEIA-ENG.COM
CONTACT: TAKAKO BAKER

WARM SPRINGS TRAVEL CENTER
Madras, OR

No.	Description	Date
1	Owner/CMGC Revisions	10/19/2016

Project Number	1519
Date	OCT. 19, 2016
Drawn By	TB
Checked By	JVB

CONDENSATE
DRAINS & REF
PIPING PLAN

P4.01

BID SET