
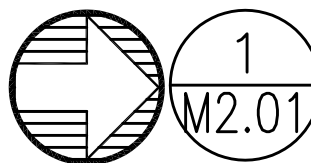


KEYED NOTES:

- ① - 6"ø INSULATED OSA DUCT UP THRU ROOF WITH A MANUAL BALANCING DAMPER AND A 2-POS CONTROL DAMPER. SEE 8/M6.02 FOR DETAIL. SEE EQUIPMENT SCHEDULE FOR OSA AIRFLOW.
- ② - 8"ø INSULATED OSA DUCT UP THRU ROOF WITH A MANUAL BALANCING DAMPER AND A 2-POS CONTROL DAMPER. SEE 8/M6.02 FOR DETAIL. SEE EQUIPMENT SCHEDULE FOR OSA AIRFLOW.
- ③ - 6X6 DOOR TRANSFER GRILLES. INSTALL @ 6" A.F.F.

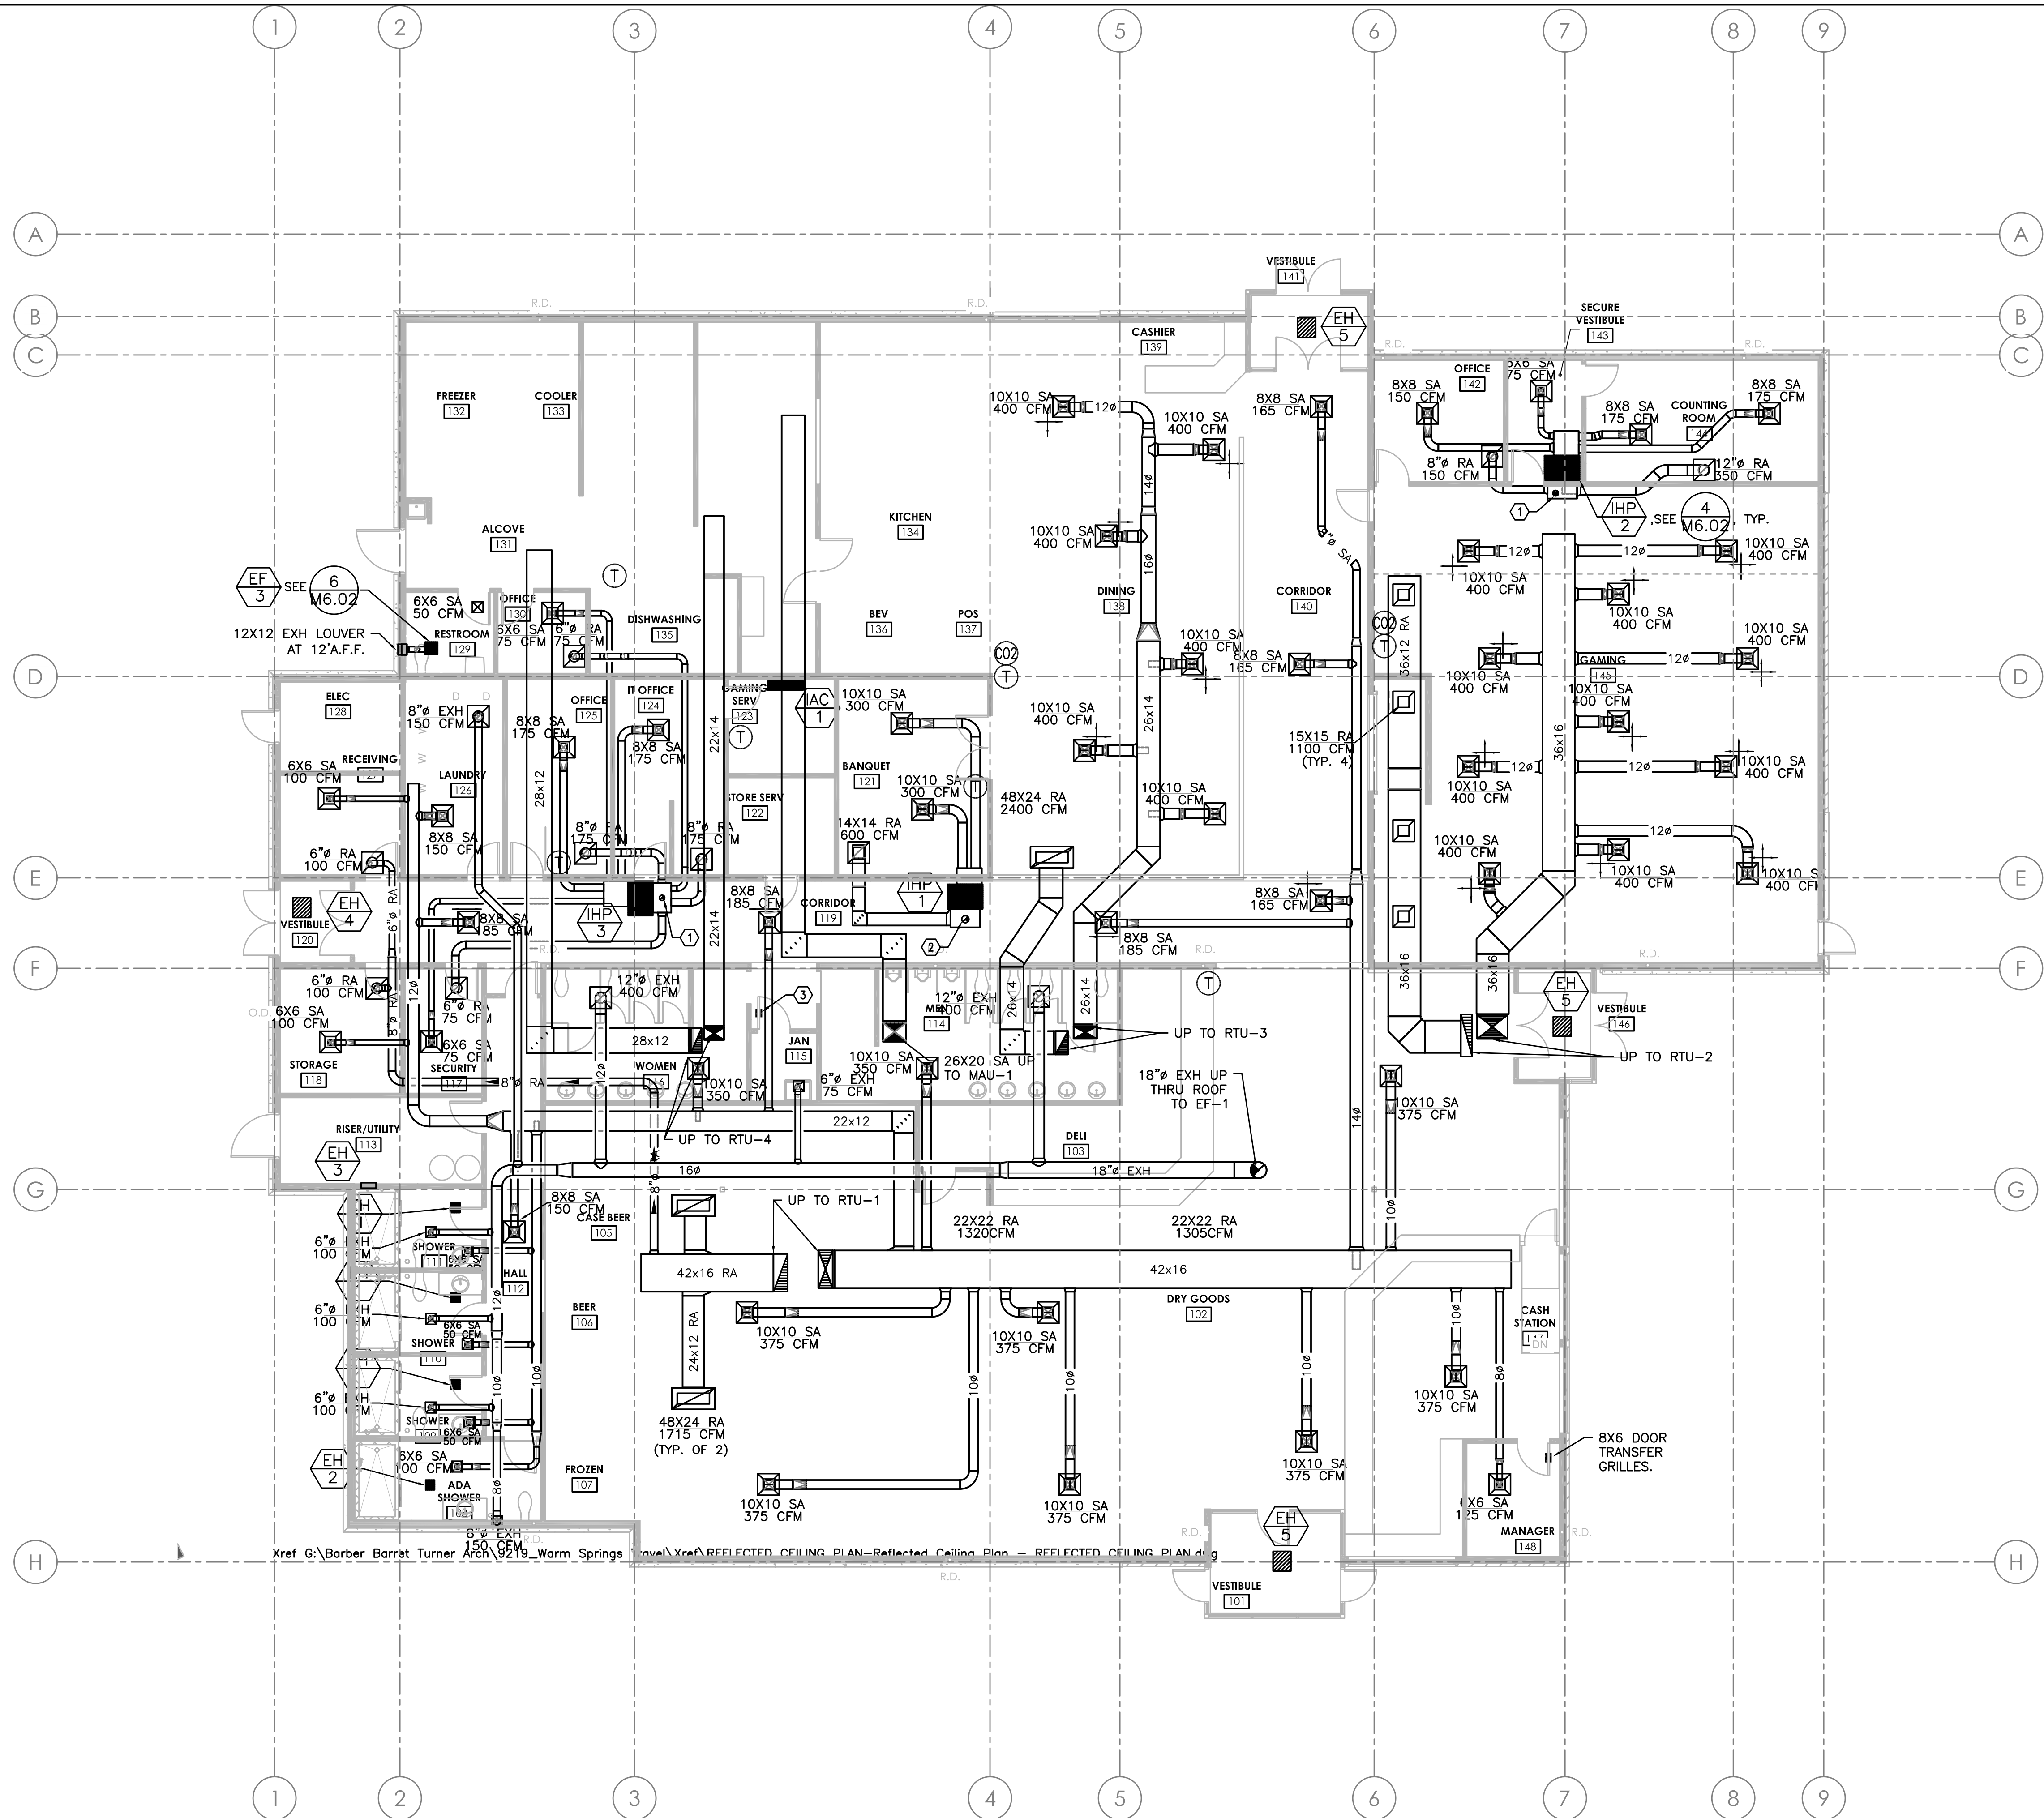

1 HVAC FLOOR PLAN

SCALE: 1/8" = 1'-0"

WARM SPRINGS TRAVEL CENTER

Madras, OR

No.	Description	Date

Project Number	1519
Date	JAN. 12, 2016
Drawn By	TB
Checked By	TB

HVAC FLOOR PLAN

M2.01

BBT
ARCHITECTS

1160 sw Simpson Ave. - Suite 100 - Bend, Oregon 97702
1.541.382.5535 | 1.541.389.8033

M Consulting Engineers
2007 S.E. Ash St.
Portland, OR 97214
PHN: (503) 234-0548
FAX: (503) 234-0677
WWW.MFIA-ENG.COM
CONTACT: TAKAKO BAKER

PRELIMINARY NOT FOR CONSTRUCTION