
 


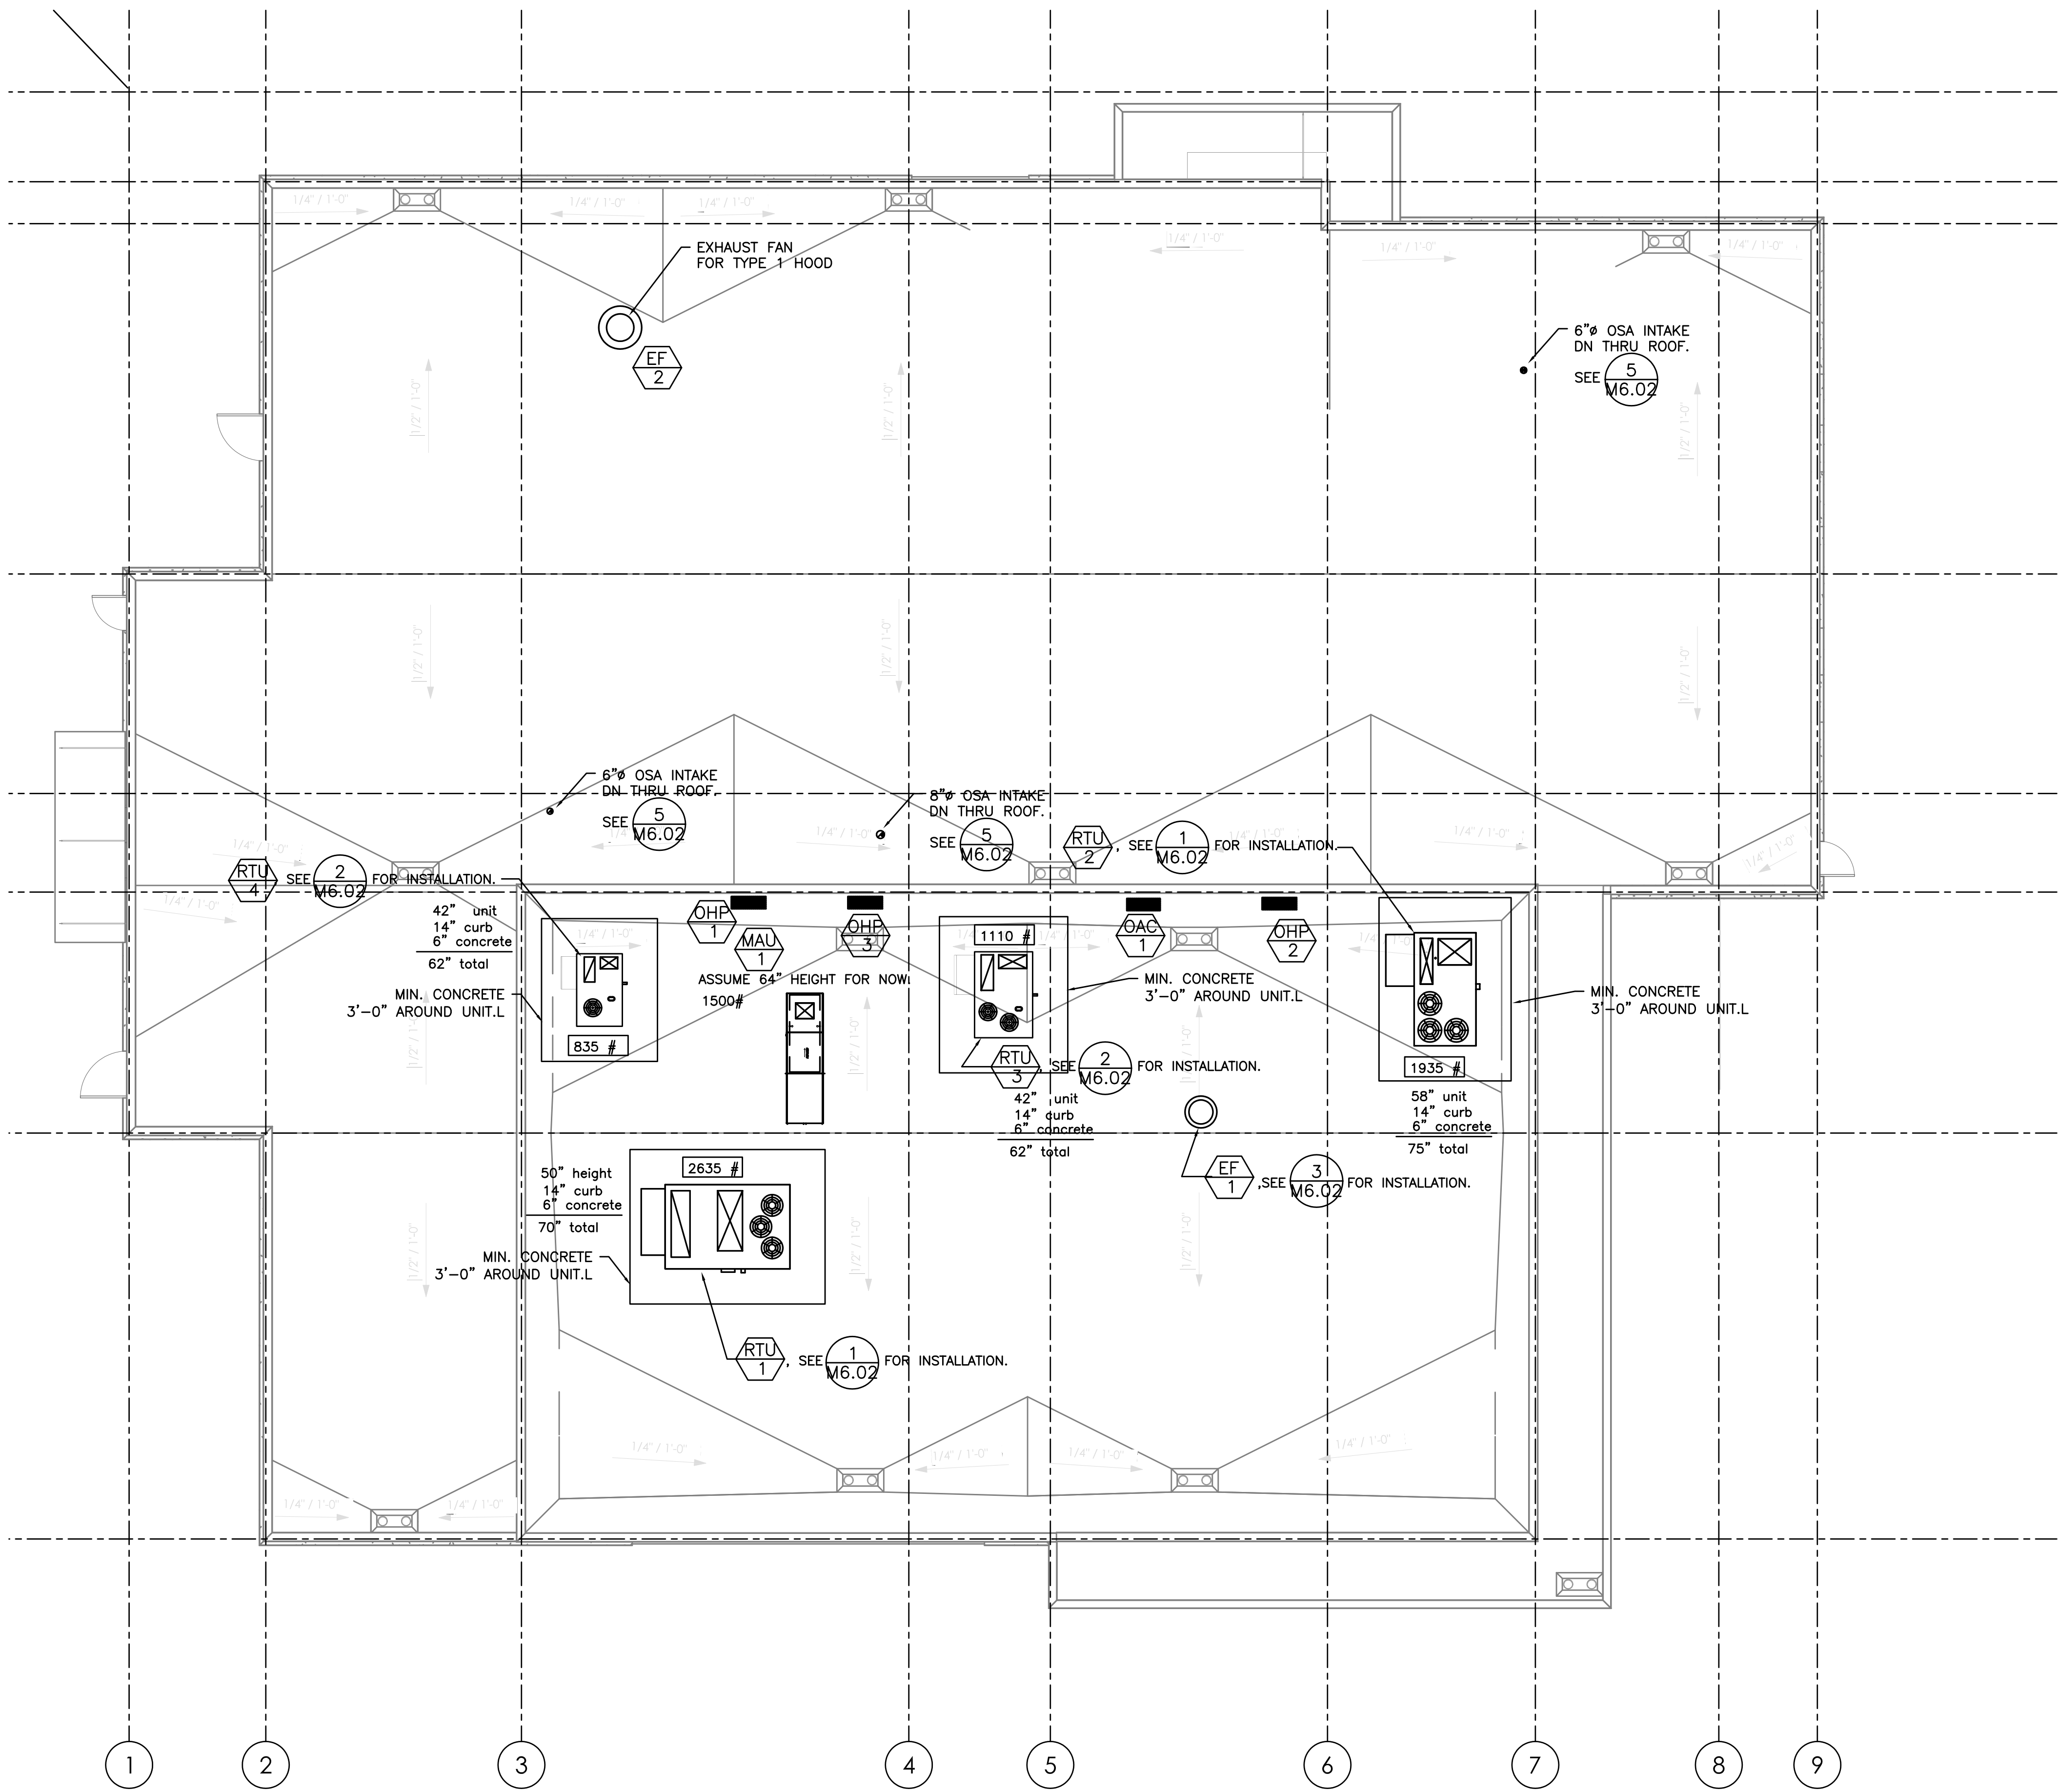

1 HVAC ROOF PLAN
M3.01 SCALE: 1/8"=1'-0"



BBT
ARCHITECTS
1160 sw Simpson Ave. - Suite 100 - Bend, Oregon 97702
1.541.382.5535 | 1.541.389.8033

MFA
Consulting Engineers
2007 S.E. Ash St.
Portland, OR 97214
PHN: (503) 234-0548
FAX: (503) 234-0877
INC. WWW.MFIA-ENG.COM
CONTACT: TAKAKO BAKER

WARM SPRINGS TRAVEL CENTER
Madras, OR

No.	Description	Date

Project Number	1519
Date	JAN. 12, 2016
Drawn By	TB
Checked By	TB

HVAC ROOF
PLAN

M3.01

PRELIMINARY NOT FOR CONSTRUCTION