


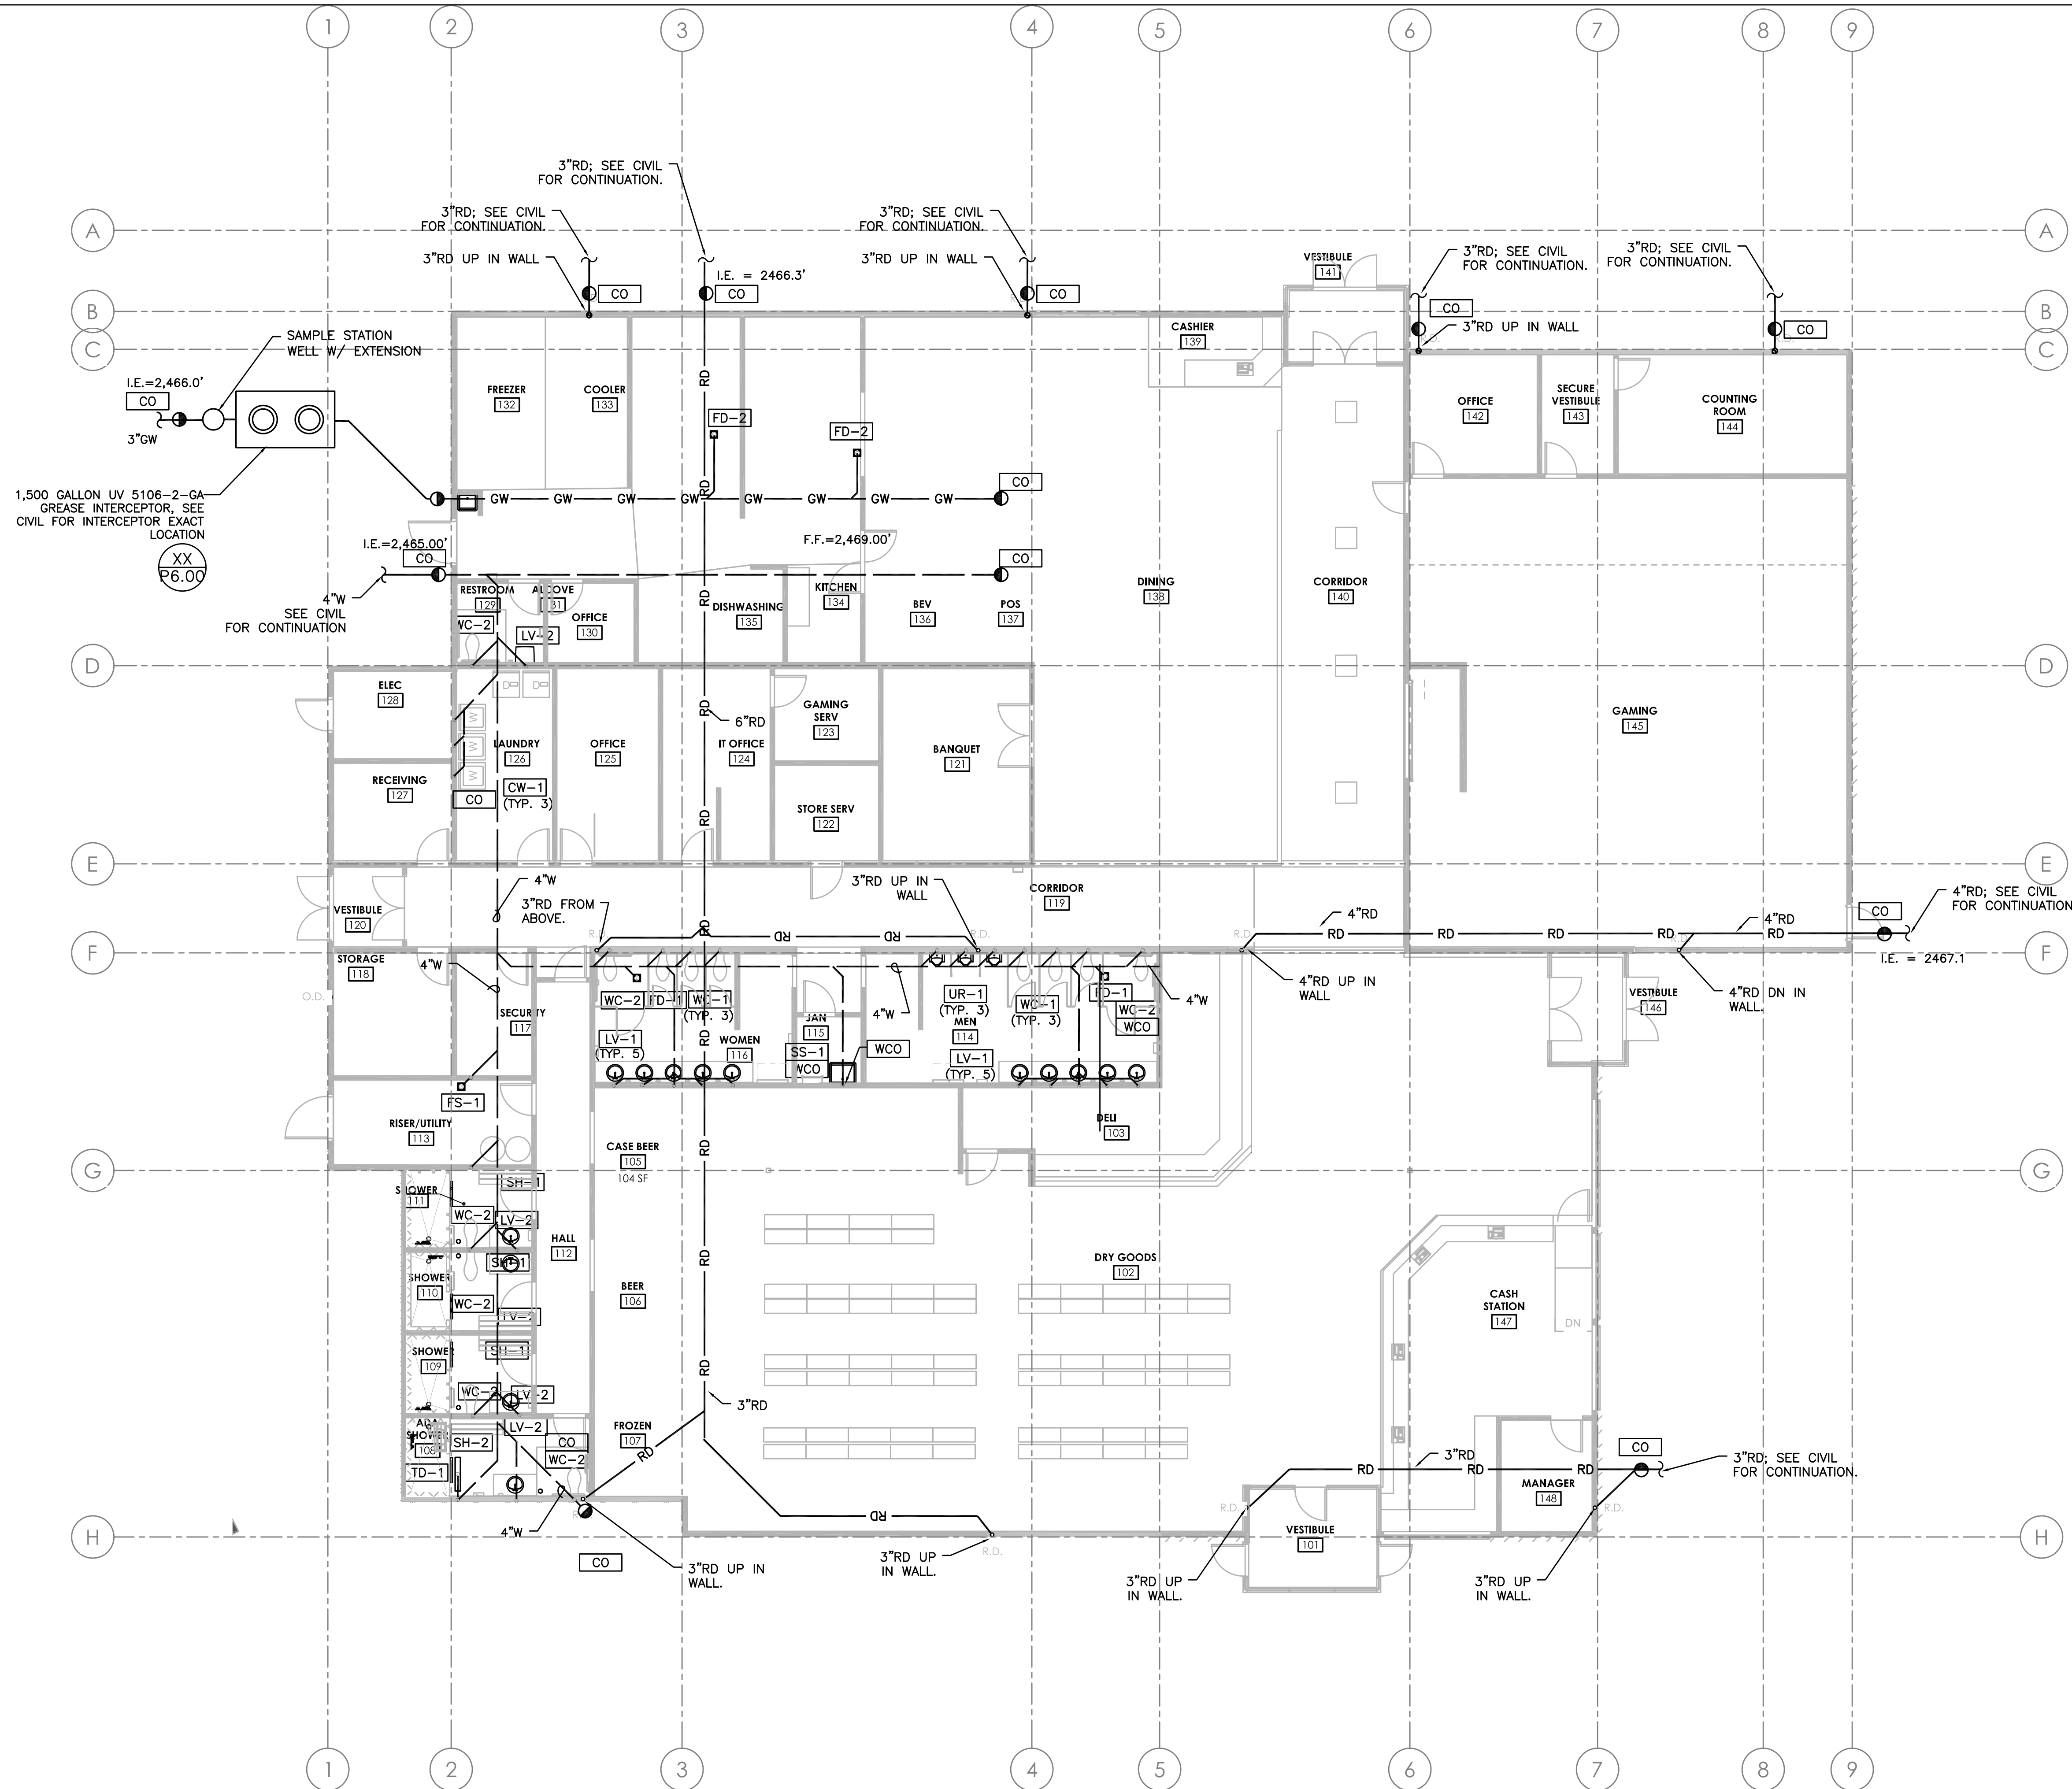

1 UNDER SLAB PLUMBING PLAN
P2.01 SCALE: 1/8" = 1'-0"

BBT

ARCHITECTS

1160 sw Simpson Ave. - Suite 100 - Bend, Oregon 97702
1.541.382.5535 | 1.541.389.8033

MEFA

Consulting Engineers

2007 S.E. Ash St.
Portland, OR 97214
PHN: (503) 234-0548
FAX: (503) 234-0677
C. WWW.MEFA-ENG.COM
CONTACT: TAKAKO BAKER

WARM SPRINGS TRAVEL CENTER

Madras, OR

No.	Description	Date

Project Number	1519
Date	JAN. 12, 2016
Drawn By	TB
Checked By	JVB

UNDER SLAB
PLUMBING
PLAN

P2.01

PRELIMINARY NOT FOR CONSTRUCTION