


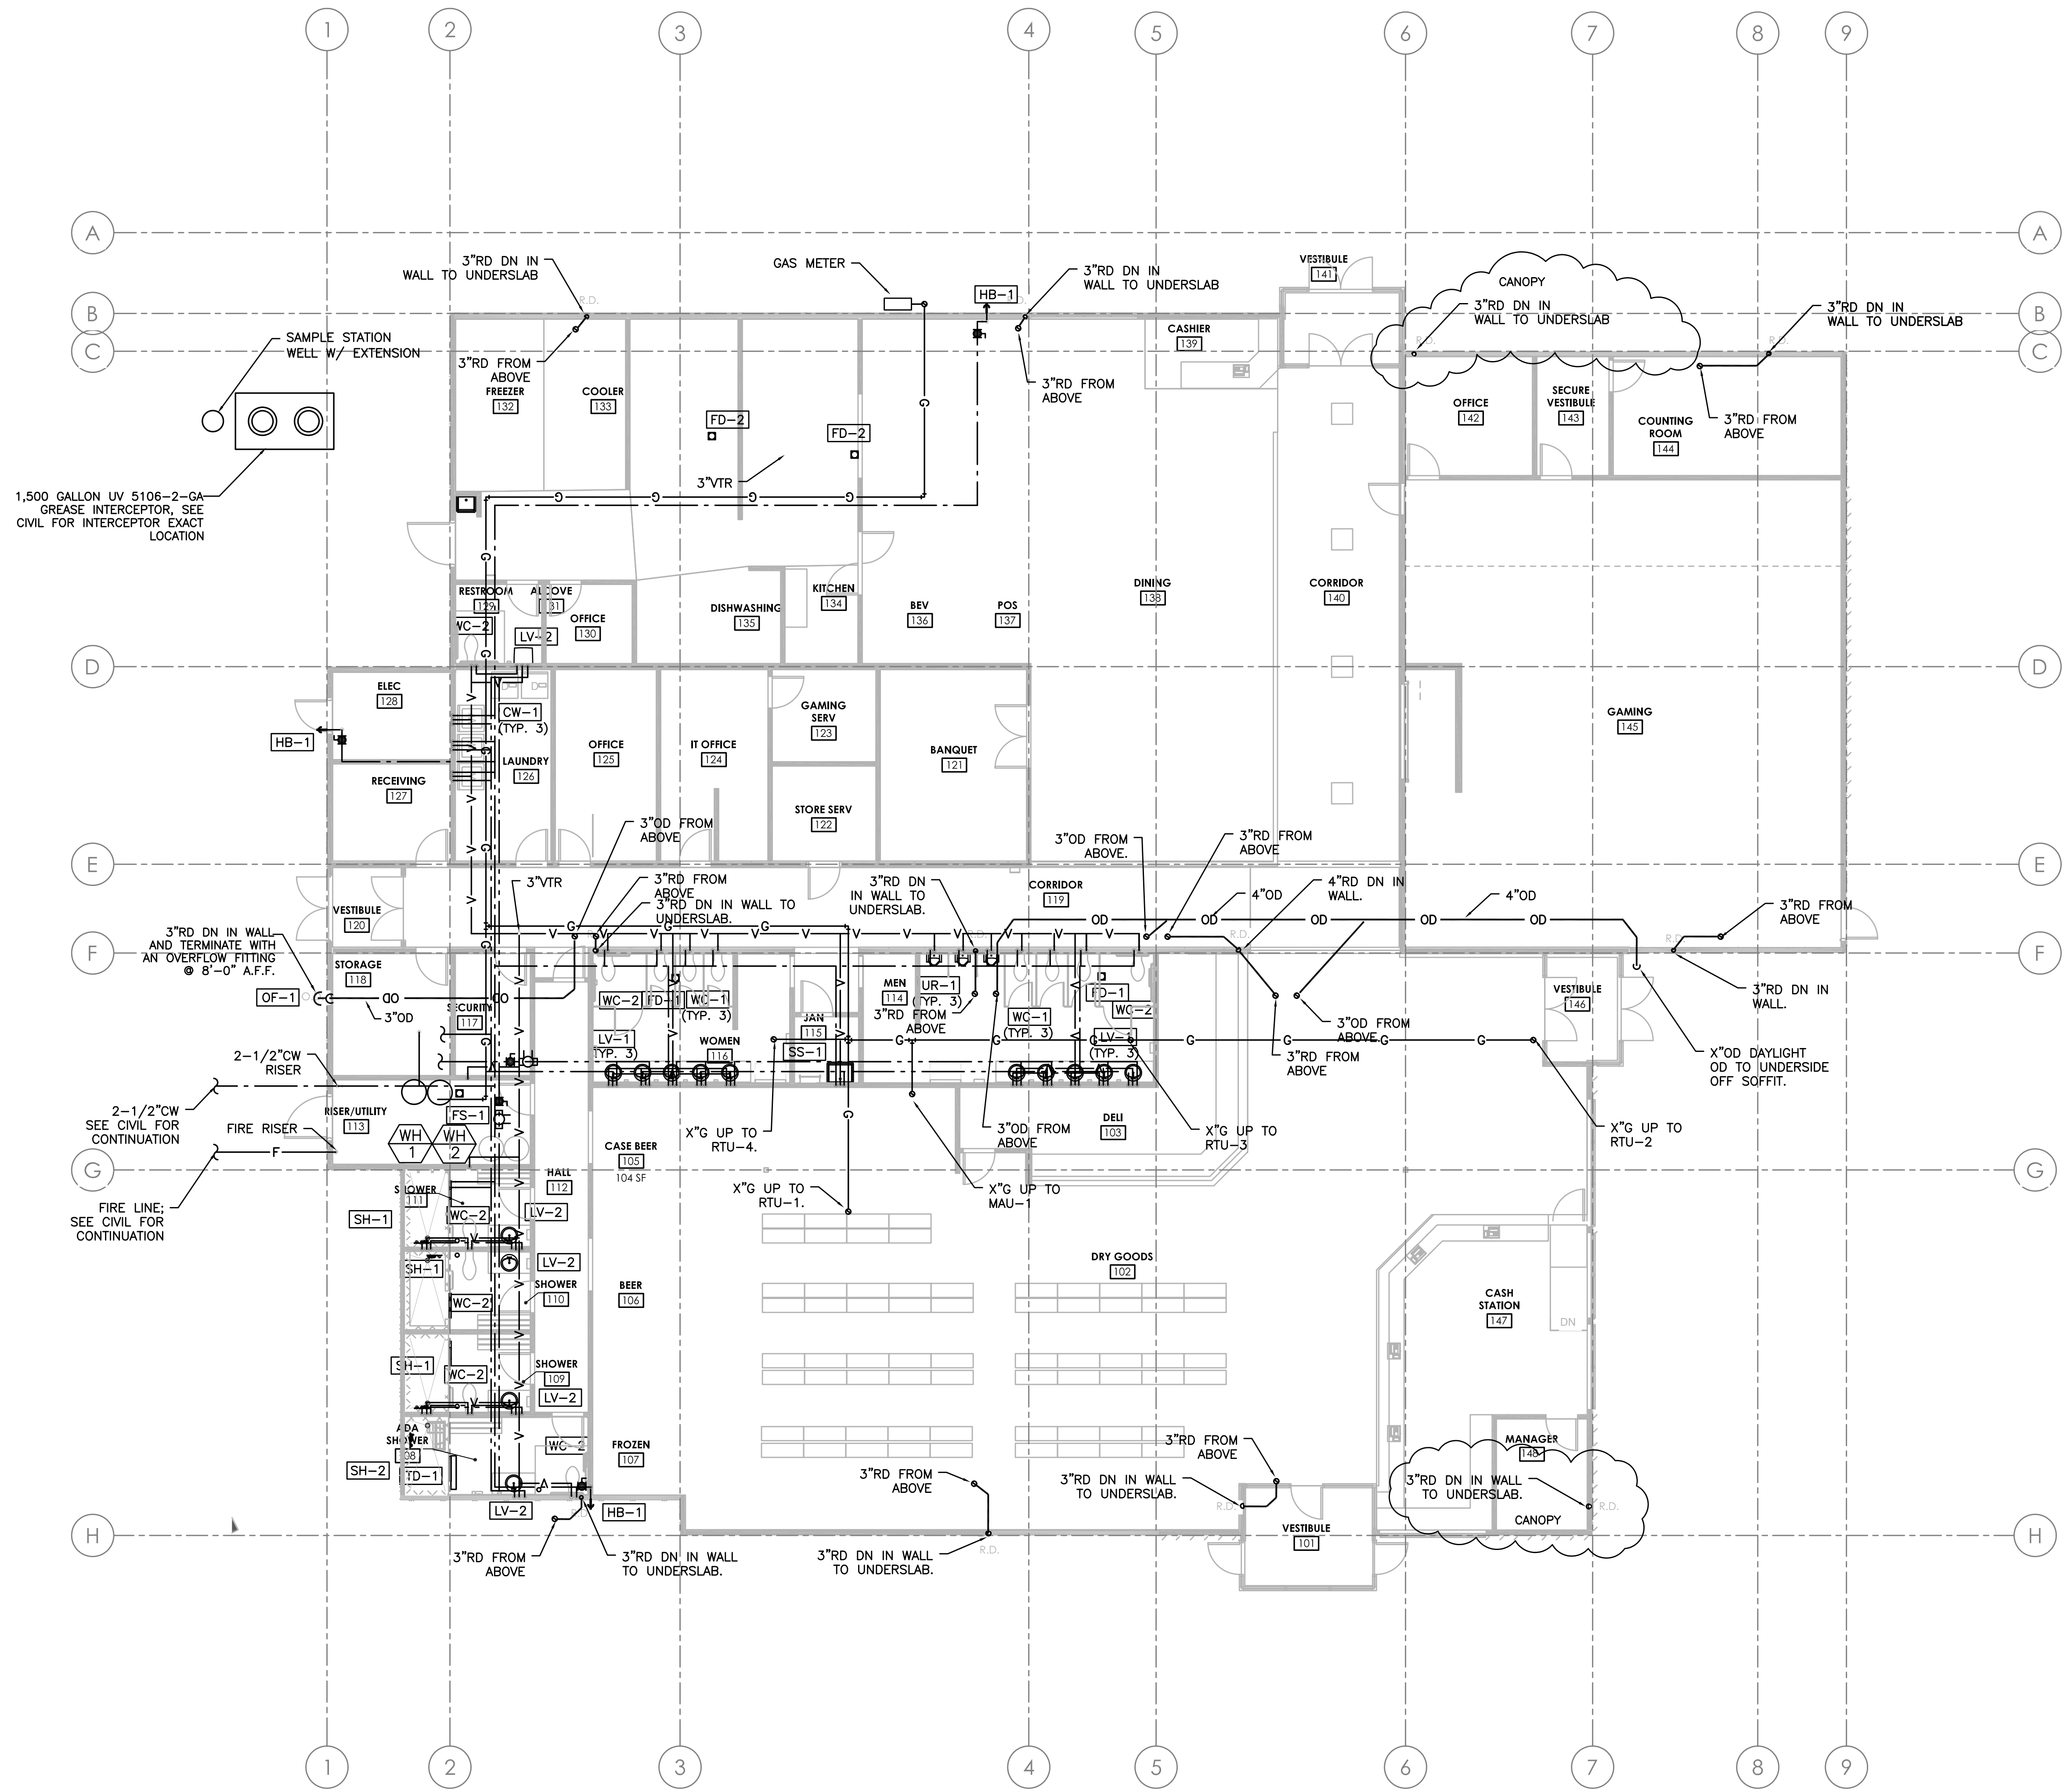

1,500 GALLON UV 5106-2-GA
GREASE INTERCEPTOR, SEE
CIVIL FOR INTERCEPTOR EXACT
LOCATION

3"RD DN IN WALL
AND TERMINATE WITH
AN OVERFLOW FITTING
@ 8'-0" A.F.F.

2-1/2"CW
SEE CIVIL FOR
CONTINUATION

FIRE RISER
SEE CIVIL FOR
CONTINUATION

1 PLUMBING FLOOR PLAN
SCALE: 1/8"=1'-0"

PRELIMINARY NOT FOR CONSTRUCTION

No.	Description	Date

Project Number	1519
Date	JAN. 12, 2016
Drawn By	TB
Checked By	JVB

PLUMBING
FLOOR PLAN

P2.02

BBT

ARCHITECTS

1160 sw Simpson Ave., Suite 100 - Bend, Oregon 97702
1.541.382.5535 | 1.541.389.8033

M
E
A
INC.

Consulting Engineers
2007 S.E. Ash St.
Portland, OR 97214
PHN: (503) 234-0548
FAX: (503) 234-0877
WWW.MEIA-ENG.COM
CONTACT: TAKAKO BAKER

WARM SPRINGS TRAVEL CENTER

Madras, OR