

 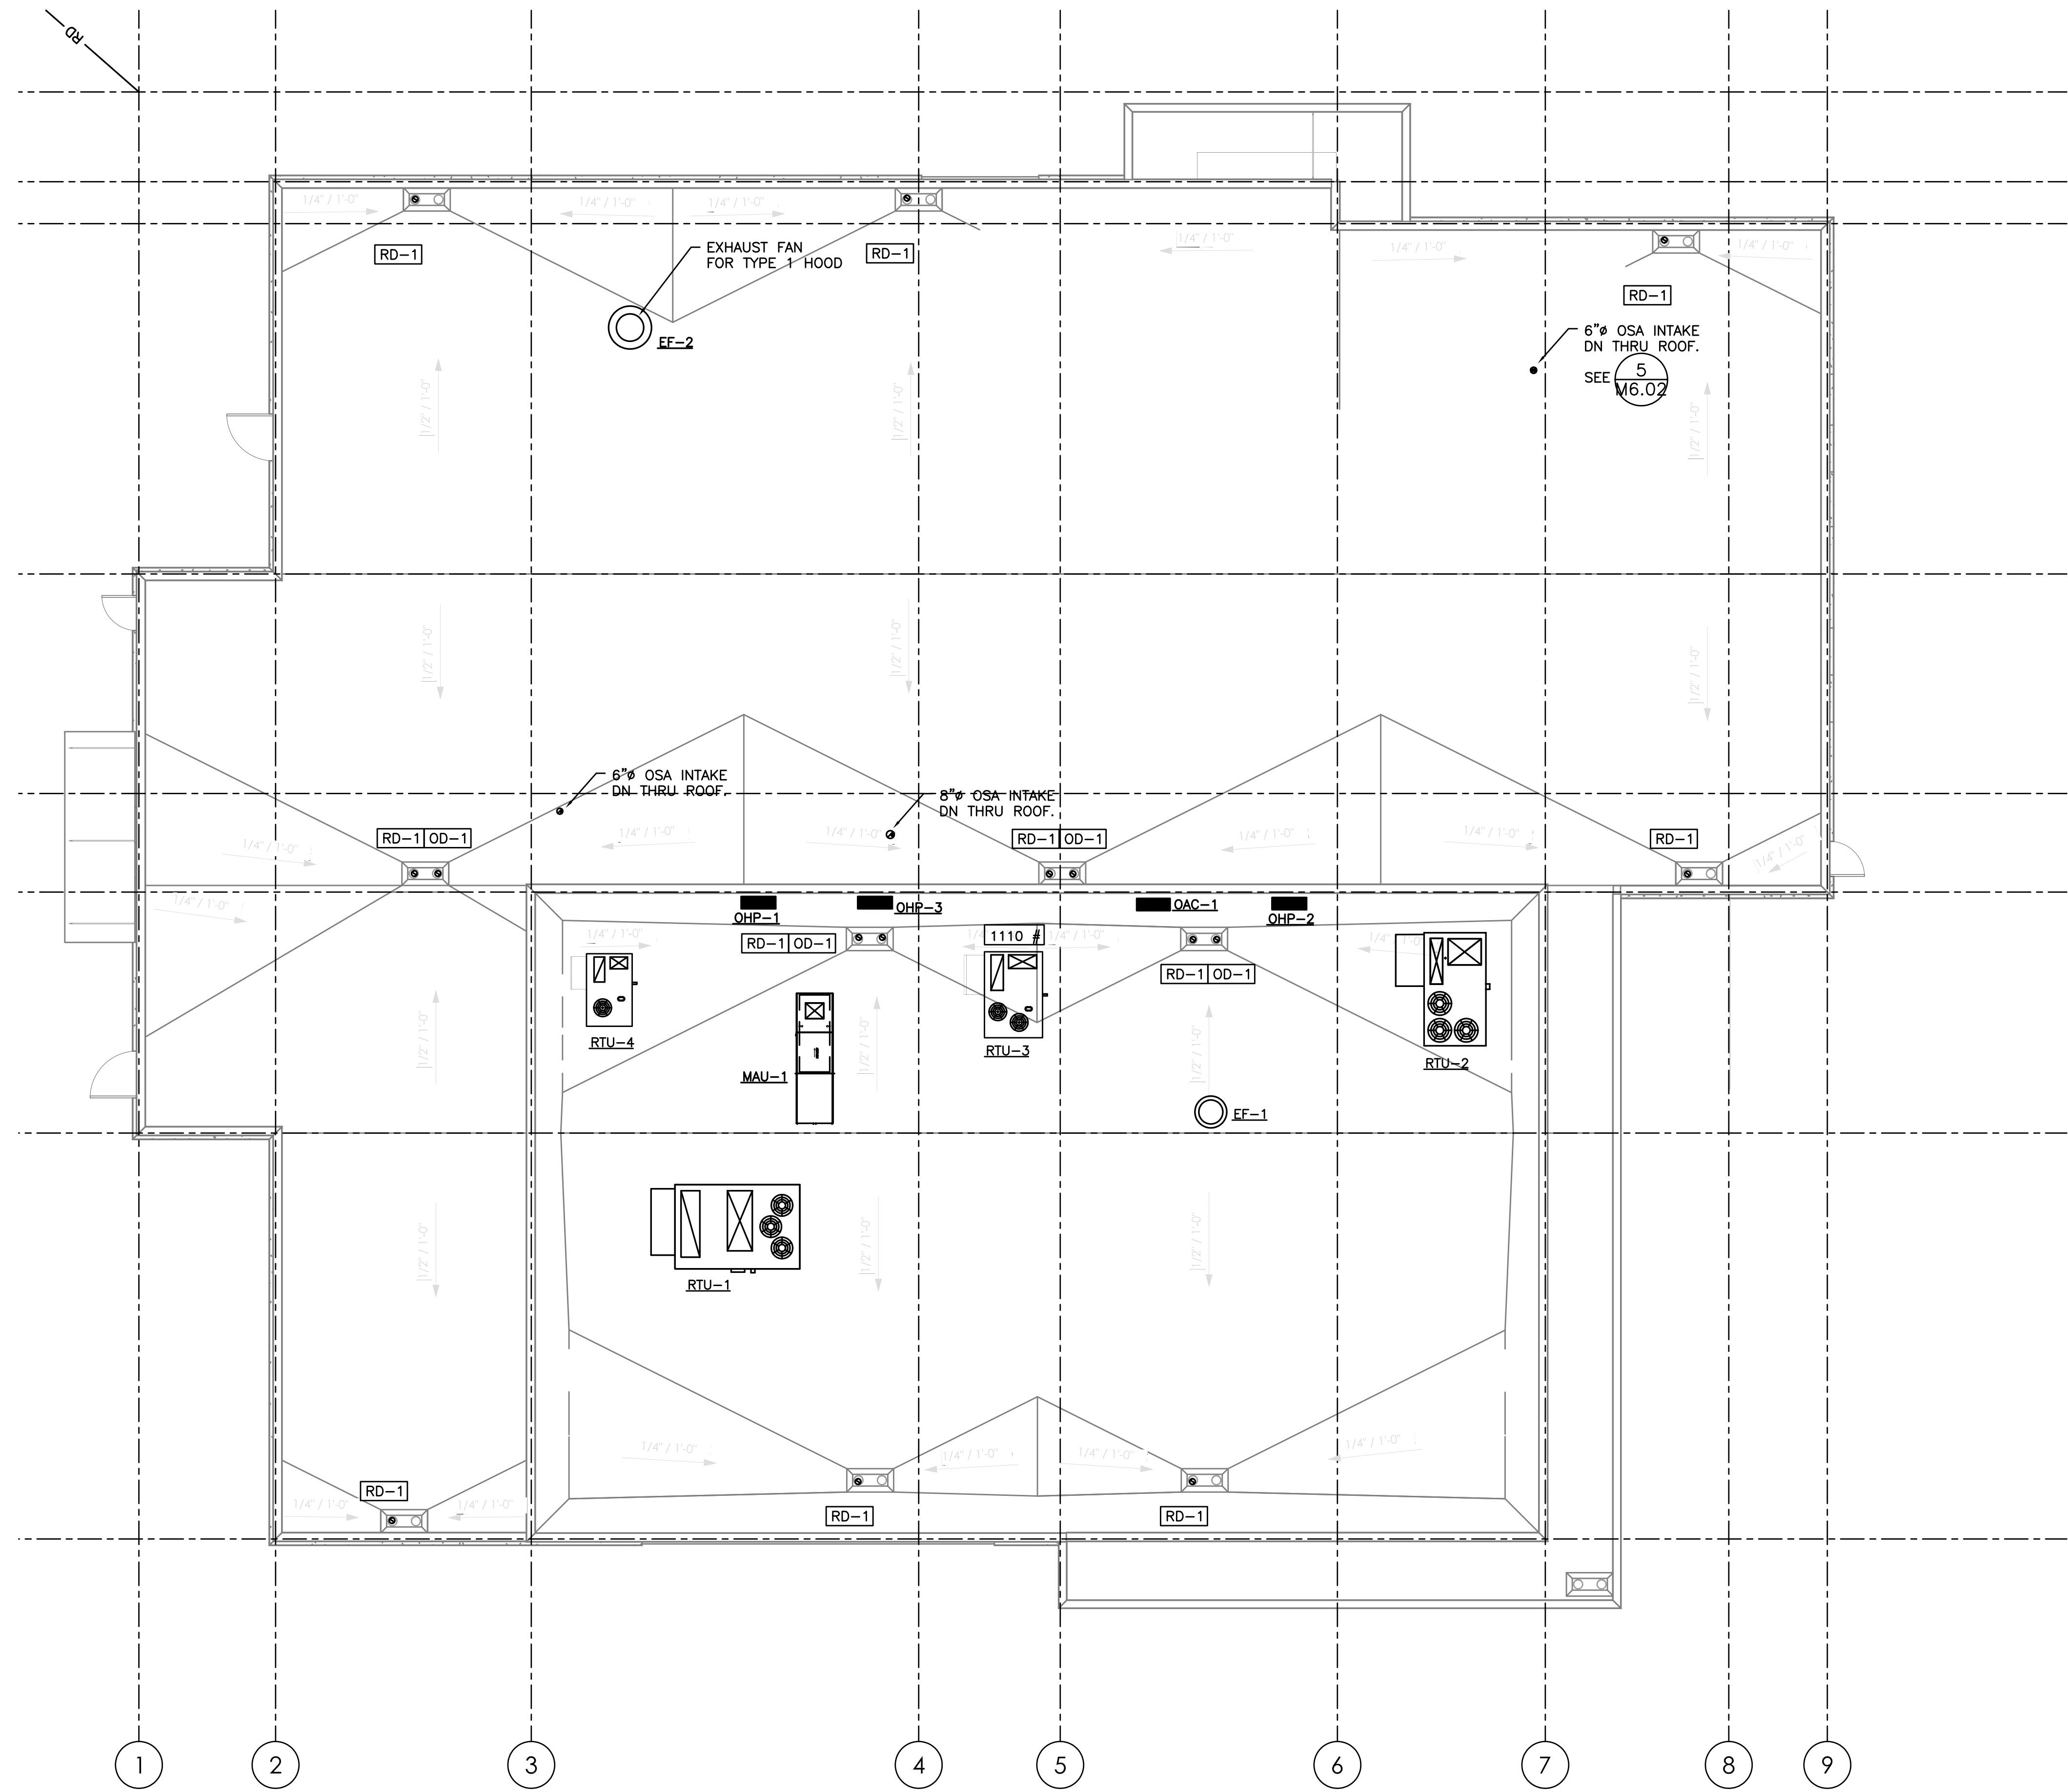


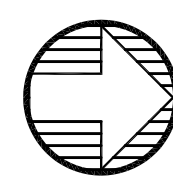

 1 HVAC ROOF PLAN
SCALE: 1/8"=1'-0"



B B T
ARCHITECTS

1160 sw Simpson Ave. - Suite 100 - Bend, Oregon 97702
1.541.382.5535 | 1.541.389.8033

M F I A
INC.

Consulting Engineers
2007 S.E. Ash St.
Portland, OR 97214
PHN: (503) 234-0548
FAX: (503) 234-0877
WWW.MFIA-ENG.COM
CONTACT: TAKAKO BAKER

WARM SPRINGS TRAVEL CENTER

Madras, OR

No.	Description	Date

Project Number	1519
Date	JAN. 12, 2016
Drawn By	TB
Checked By	TB

PLUMBING
ROOF PLAN

P3.01

PRELIMINARY NOT FOR CONSTRUCTION