


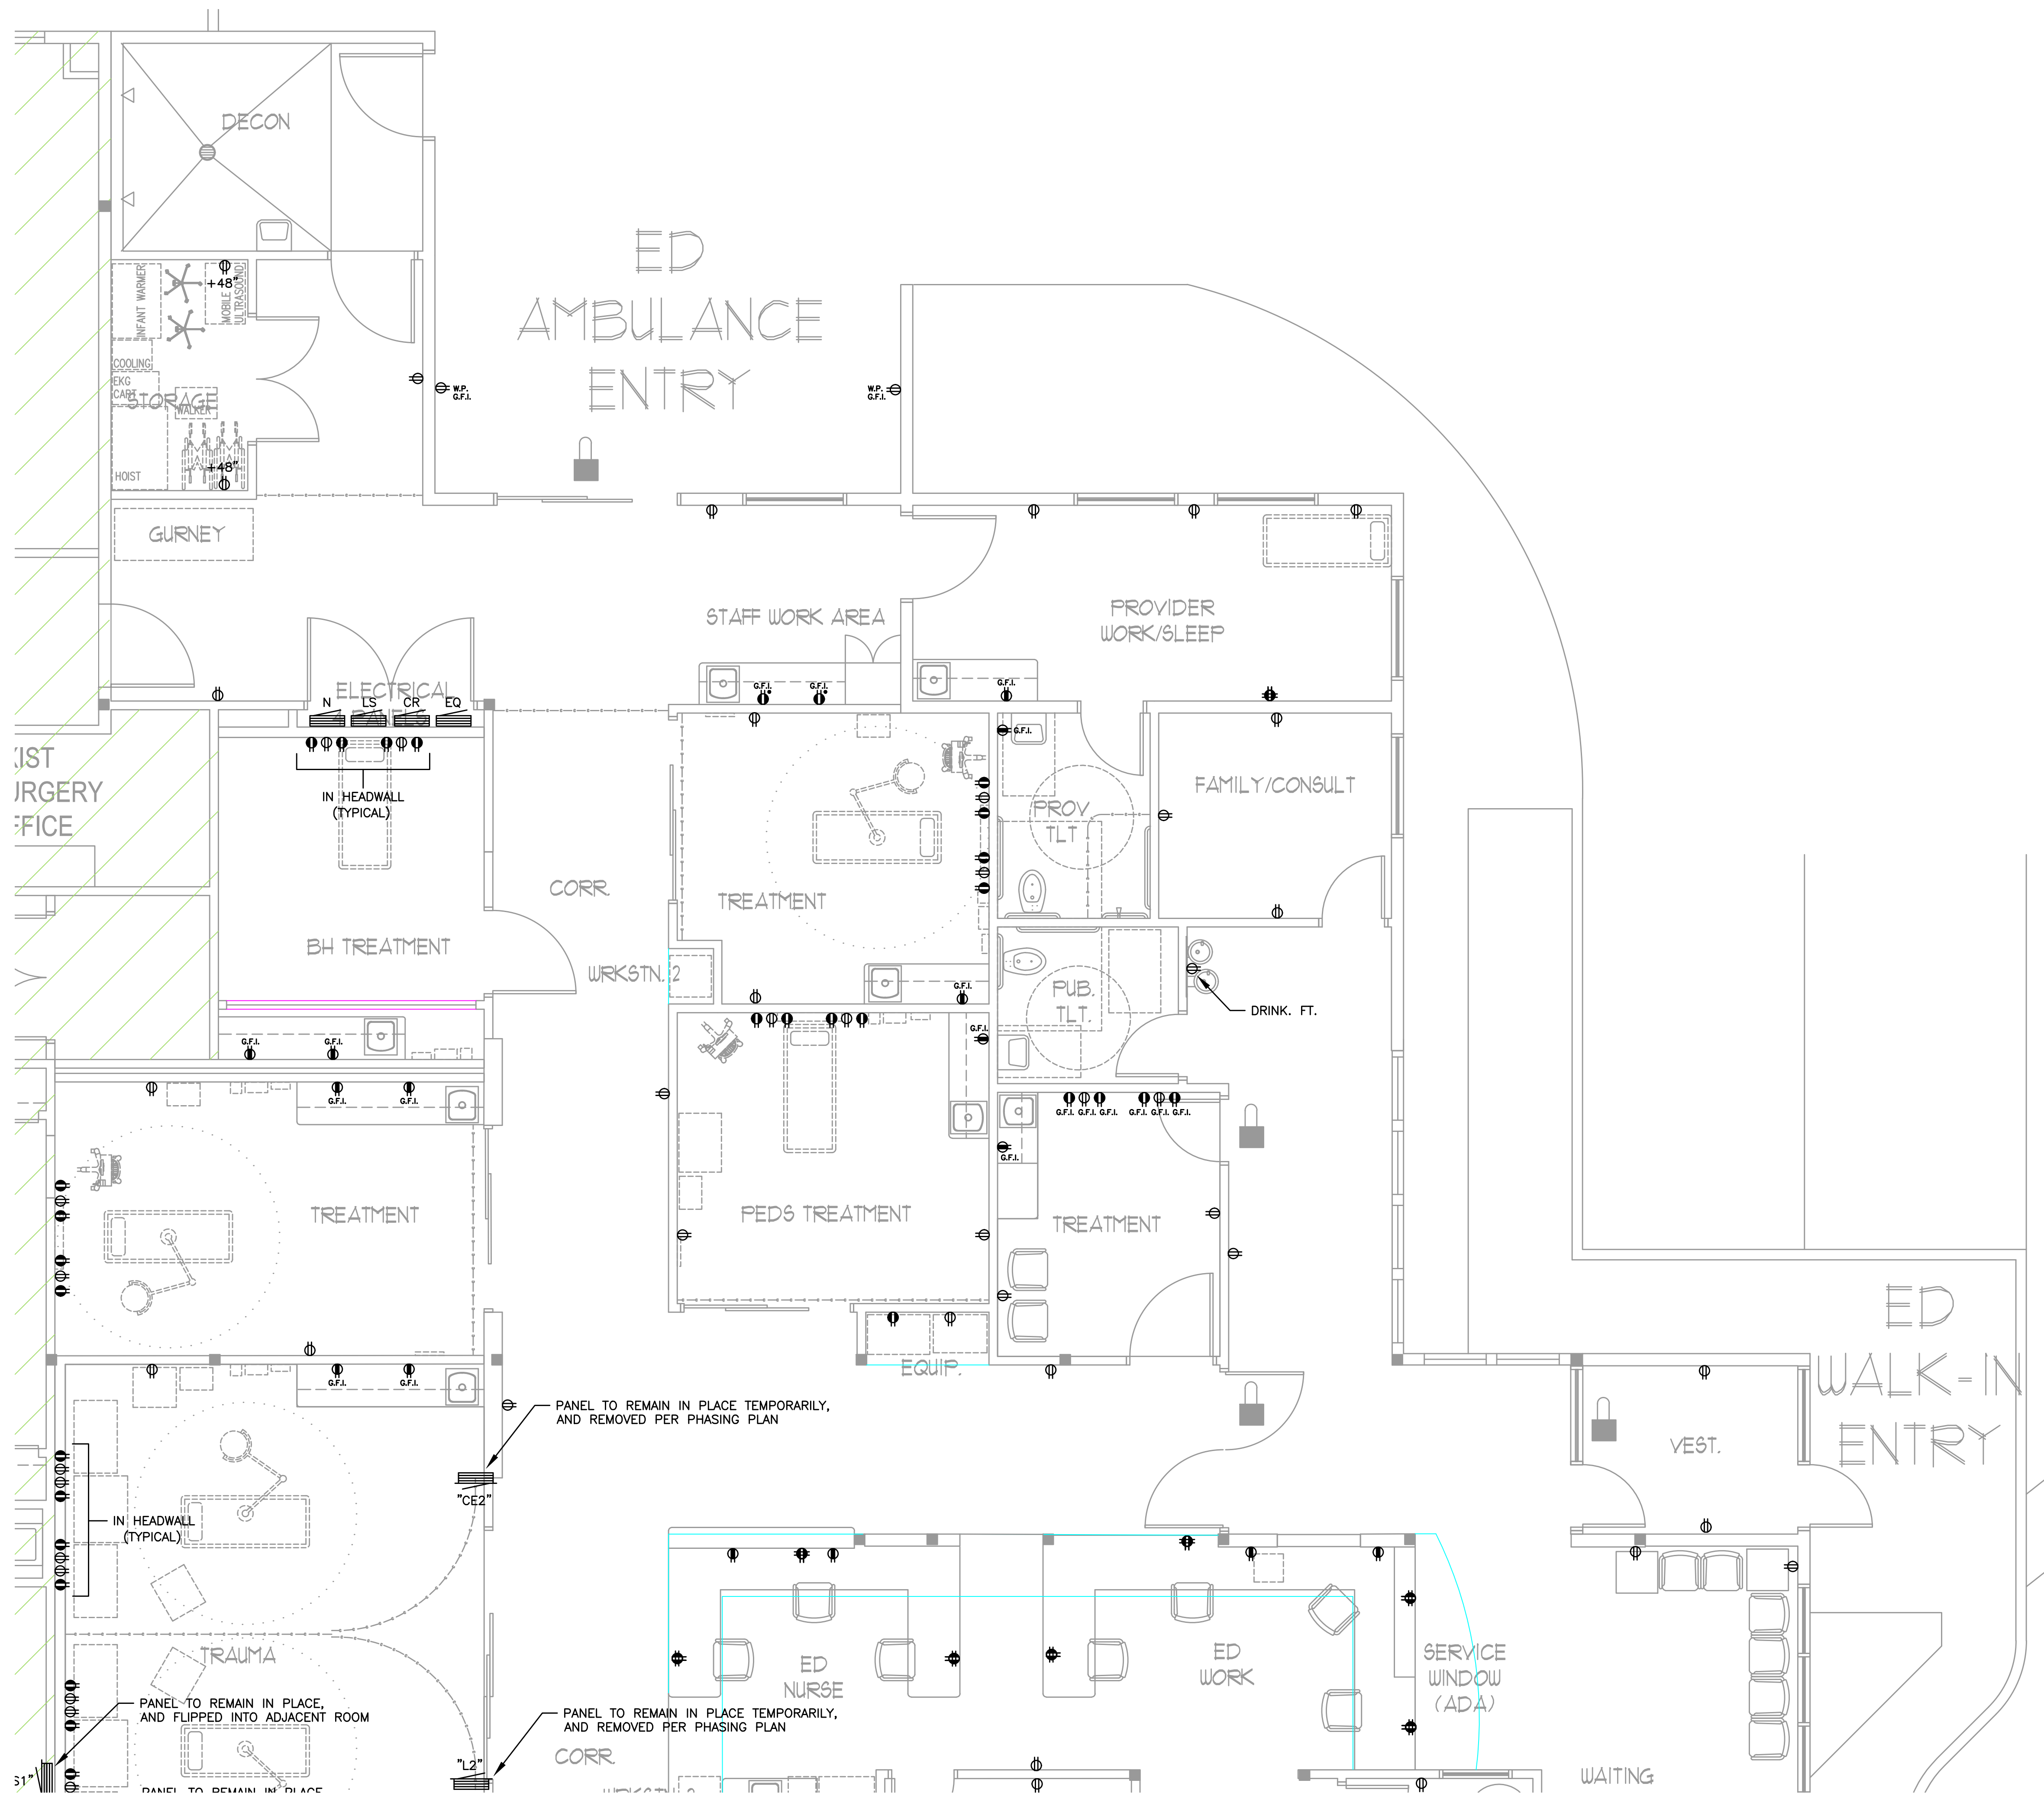

PLAN NOTES

① x



BLUE ROOM ARCHITECTURE & DESIGN, P.S.

PO BOX 628
SPOKANE VALLEY, WA 99037
(509) 456-6800

www.brdstudio.com

CIVIL ENGINEER

STRUCTURAL ENGINEER

MECHANICAL ENGINEER
MFIA INC CONSULTING ENGINEERS
2007 SE ASH STREET
PORTLAND, OR 97214
(503) 234-0548

ELECTRICAL ENGINEER
MFIA INC CONSULTING ENGINEERS
2007 SE ASH STREET
PORTLAND, OR 97214
(503) 234-0548

PRELIMINARY
NOT FOR
CONSTRUCTION

THIS PROJECT INCLUDES THE INTERIOR REMODEL OF AN EXISTING CRITICAL ACCESS HOSPITAL FACILITY THAT IS TO REMAIN OPERATIONAL AT ALL TIMES. CONTRACTOR BIDS SHALL BE BASED ON VERIFICATION OF EXISTING ON-SITE CONDITIONS. UNINTERRUPTED ESSENTIAL HEALTHCARE SERVICES DURING THE CONSTRUCTION PERIOD, ONGOING COORDINATION OF ALL RELATED TRADES FOR CURRENT CODE COMPLIANCE, PATIENT SAFETY, JURISDICTIONAL REVIEW, SYSTEM PERFORMANCE AND UNFORESEEN CLINICAL DISRUPTION(S).

INTERIOR REMODEL/ADDITION FOR:

SKYLINE
HOSPITAL
CRITICAL ACCESS HOSPITAL
MODERNIZATION
CRS #10 TO BE DETERMINED
211 SKYLINE DRIVE
WHITE SALMON, WASHINGTON 98672

PROJECT NUMBER: 180026
DATE: 10/31/2018
DRAWN: CU
REVISIONS:

NOT FOR CONSTRUCTION

POWER
PLAN

E3.1

© 2018 BLUE ROOM ARCHITECTURE & DESIGN, P.S.

MFIA
INC. Consulting Engineers
2007 S.E. Ash St.
Portland, OR 97214
PHN: (503) 234-0548
FAX: (503) 234-0877
WWW.MFIA-ENG.COM
CONTACT: CHRIS WINER

1 POWER PLAN
E3.1 SCALE: 1/4" = 1'-0"