


PLAN NOTES

① x

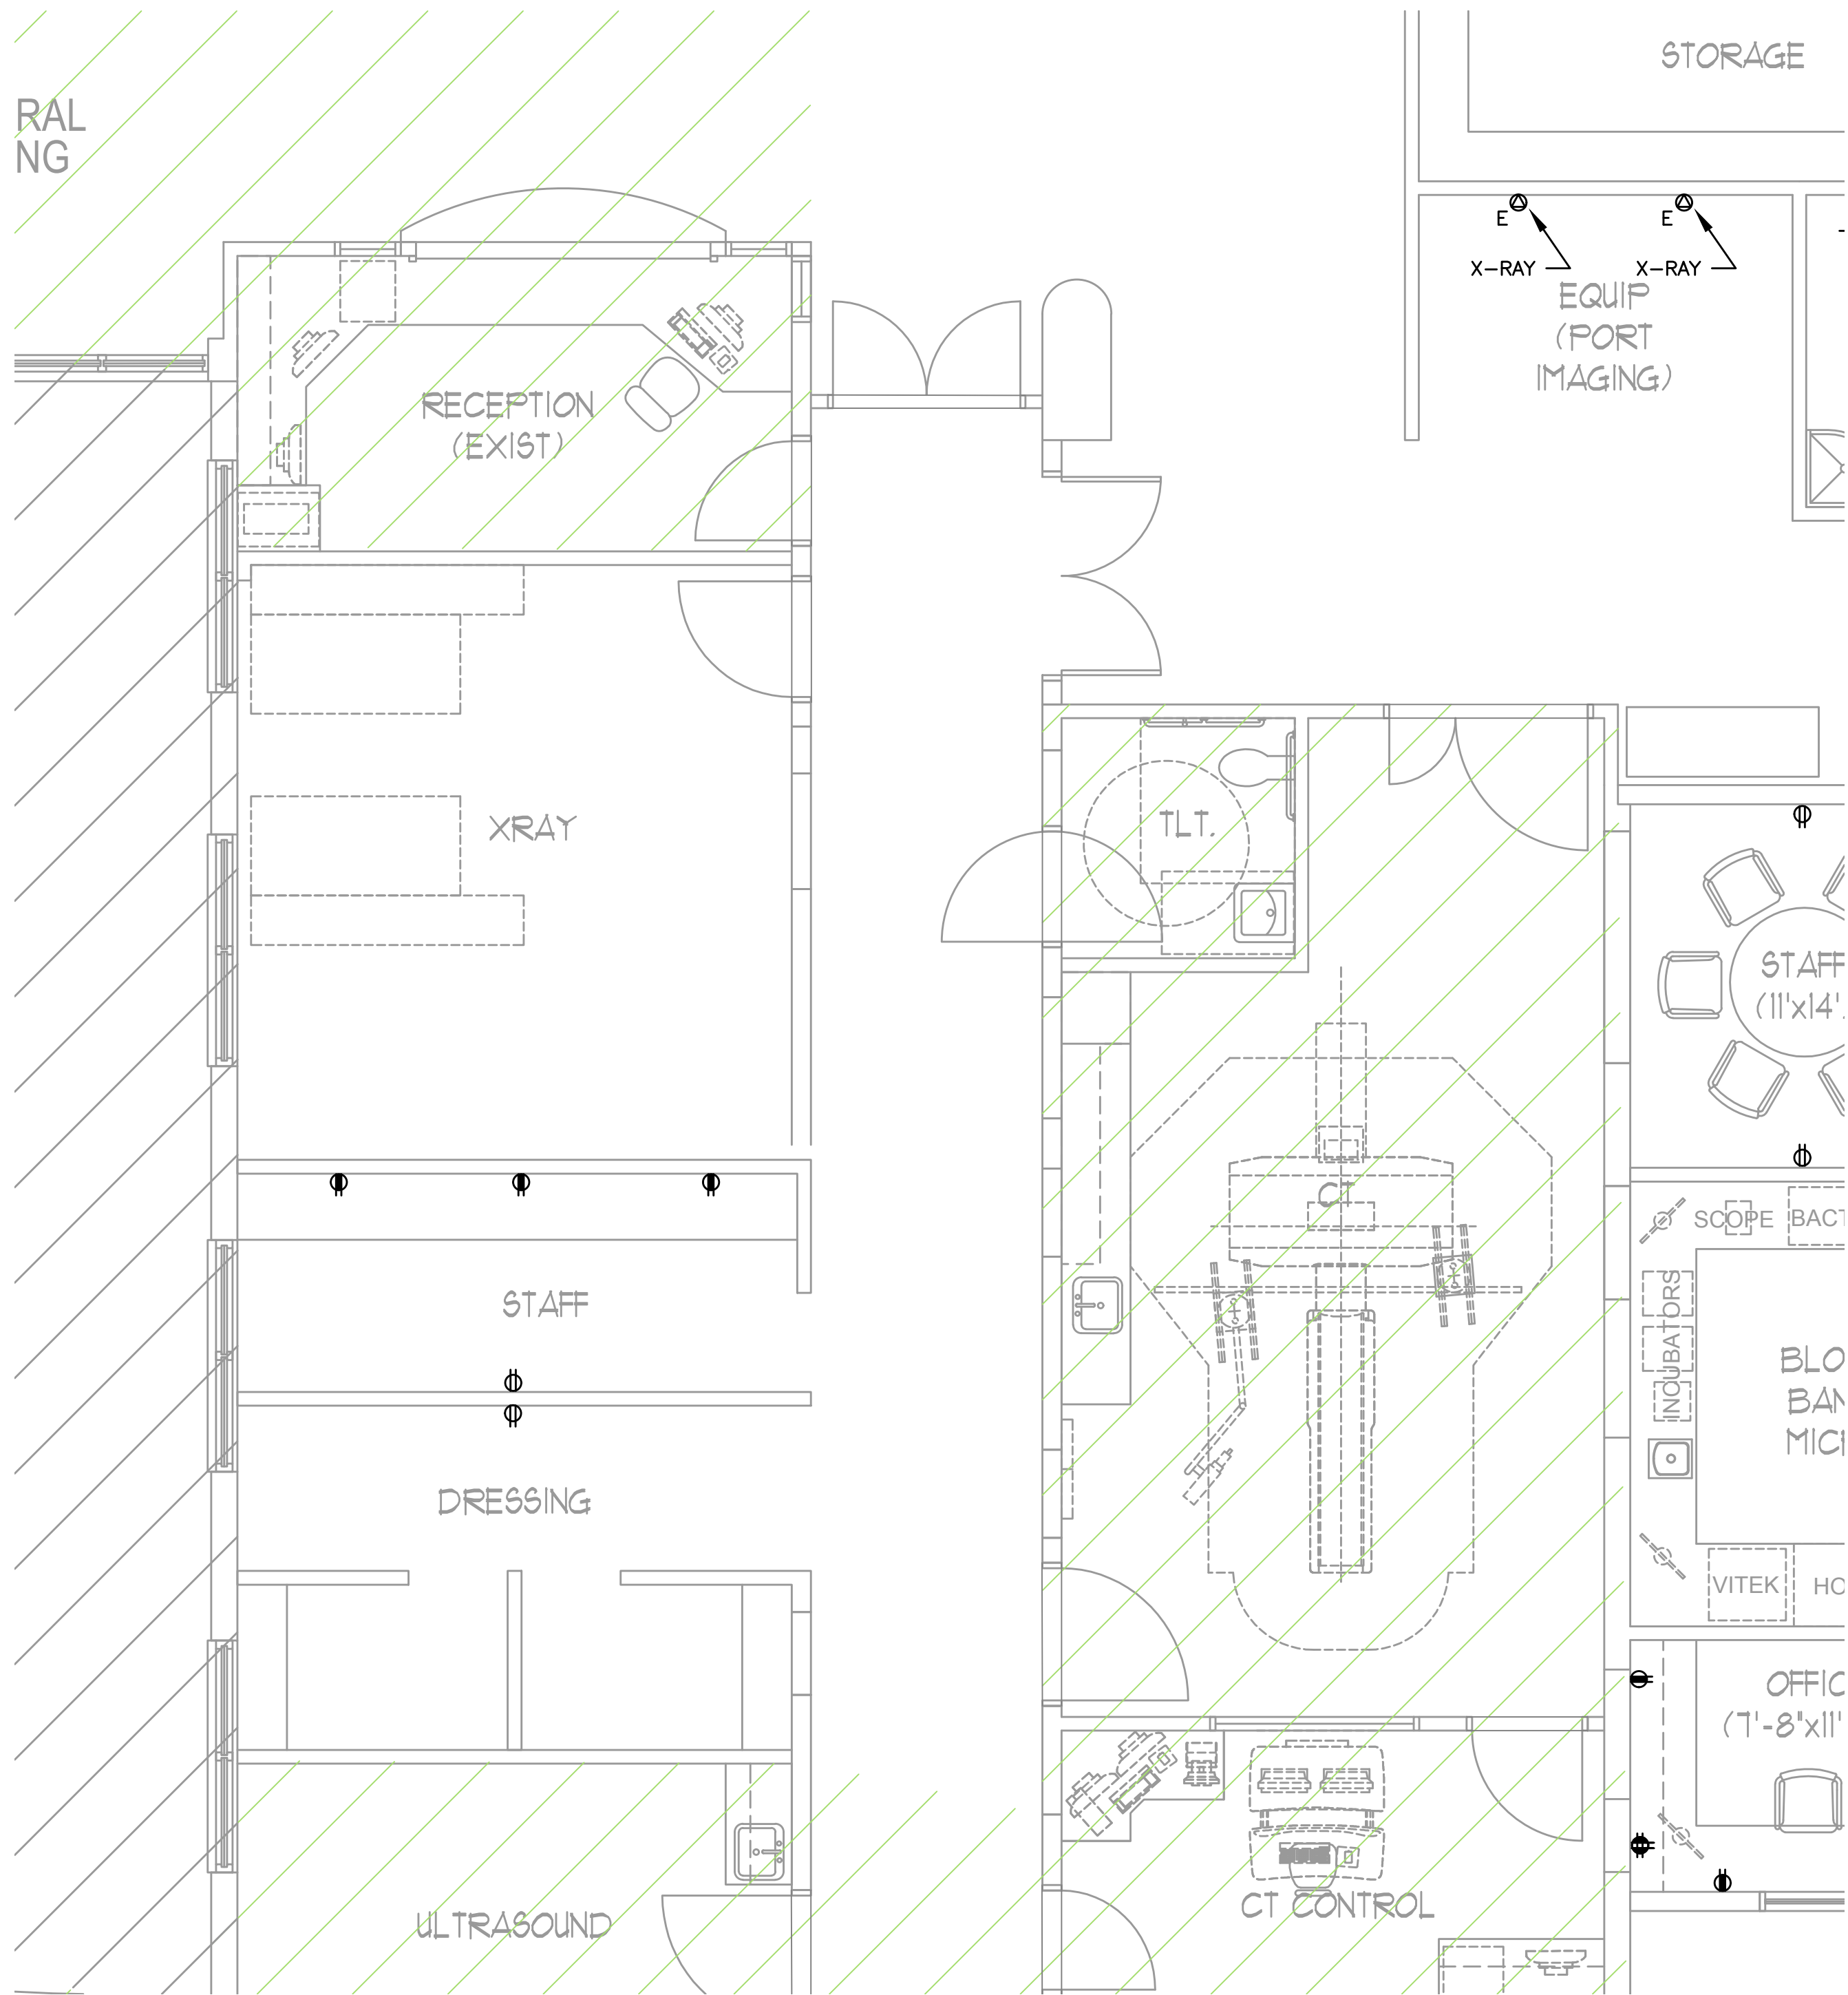

1 POWER PLAN  
E3.3 SCALE: 1/4" = 1'-0"

Consulting Engineers  
2007 S.E. Ash St.  
Portland, OR 97214  
PHN: (503) 234-0548  
FAX: (503) 234-0877  
www.MFIA-ENG.COM  
CONTACT: CHRIS WINER



BLUE ROOM ARCHITECTURE & DESIGN, P.S.

PO BOX 628  
SPOKANE VALLEY, WA 99037  
(509) 456-6800

www.brdstudio.com

CIVIL ENGINEER

STRUCTURAL ENGINEER

MECHANICAL ENGINEER  
MFIA INC CONSULTING ENGINEERS  
2007 SE ASH STREET  
PORTLAND, OR 97214  
(503) 234-0548

ELECTRICAL ENGINEER  
MFIA INC CONSULTING ENGINEERS  
2007 SE ASH STREET  
PORTLAND, OR 97214  
(503) 234-0548

PRELIMINARY  
NOT FOR  
CONSTRUCTION

THIS PROJECT INCLUDES THE INTERIOR REMODEL OF AN EXISTING  
CRITICAL ACCESS HOSPITAL FACILITY THAT IS TO REMAIN  
OPERATIONAL AT ALL TIMES. CONTRACTOR BIDS SHALL BE BASED  
ON VERIFICATION OF EXISTING ON-SITE CONDITIONS.  
UNINTERRUPTED ESSENTIAL HEALTHCARE SERVICES DURING THE  
CONSTRUCTION PERIOD, ONGOING COORDINATION OF ALL RELATED  
TRADES FOR CURRENT CODE COMPLIANCE, PATIENT SAFETY,  
JURISDICTIONAL REVIEW, SYSTEM PERFORMANCE AND UNFORESEEN  
CLINICAL DISRUPTION(S).

INTERIOR REMODEL/ADDITION FOR:

SKYLINE  
HOSPITAL  
CRITICAL ACCESS HOSPITAL  
MODERNIZATION  
CRS #10 TO BE DETERMINED  
211 SKYLINE DRIVE  
WHITE SALMON, WASHINGTON 98672

PROJECT NUMBER: 180026  
DATE: 10/31/2018  
DRAWN: CU  
REVISIONS:

NOT FOR CONSTRUCTION

POWER  
PLAN

E3.3

© 2018 BLUE ROOM ARCHITECTURE & DESIGN, P.S.