


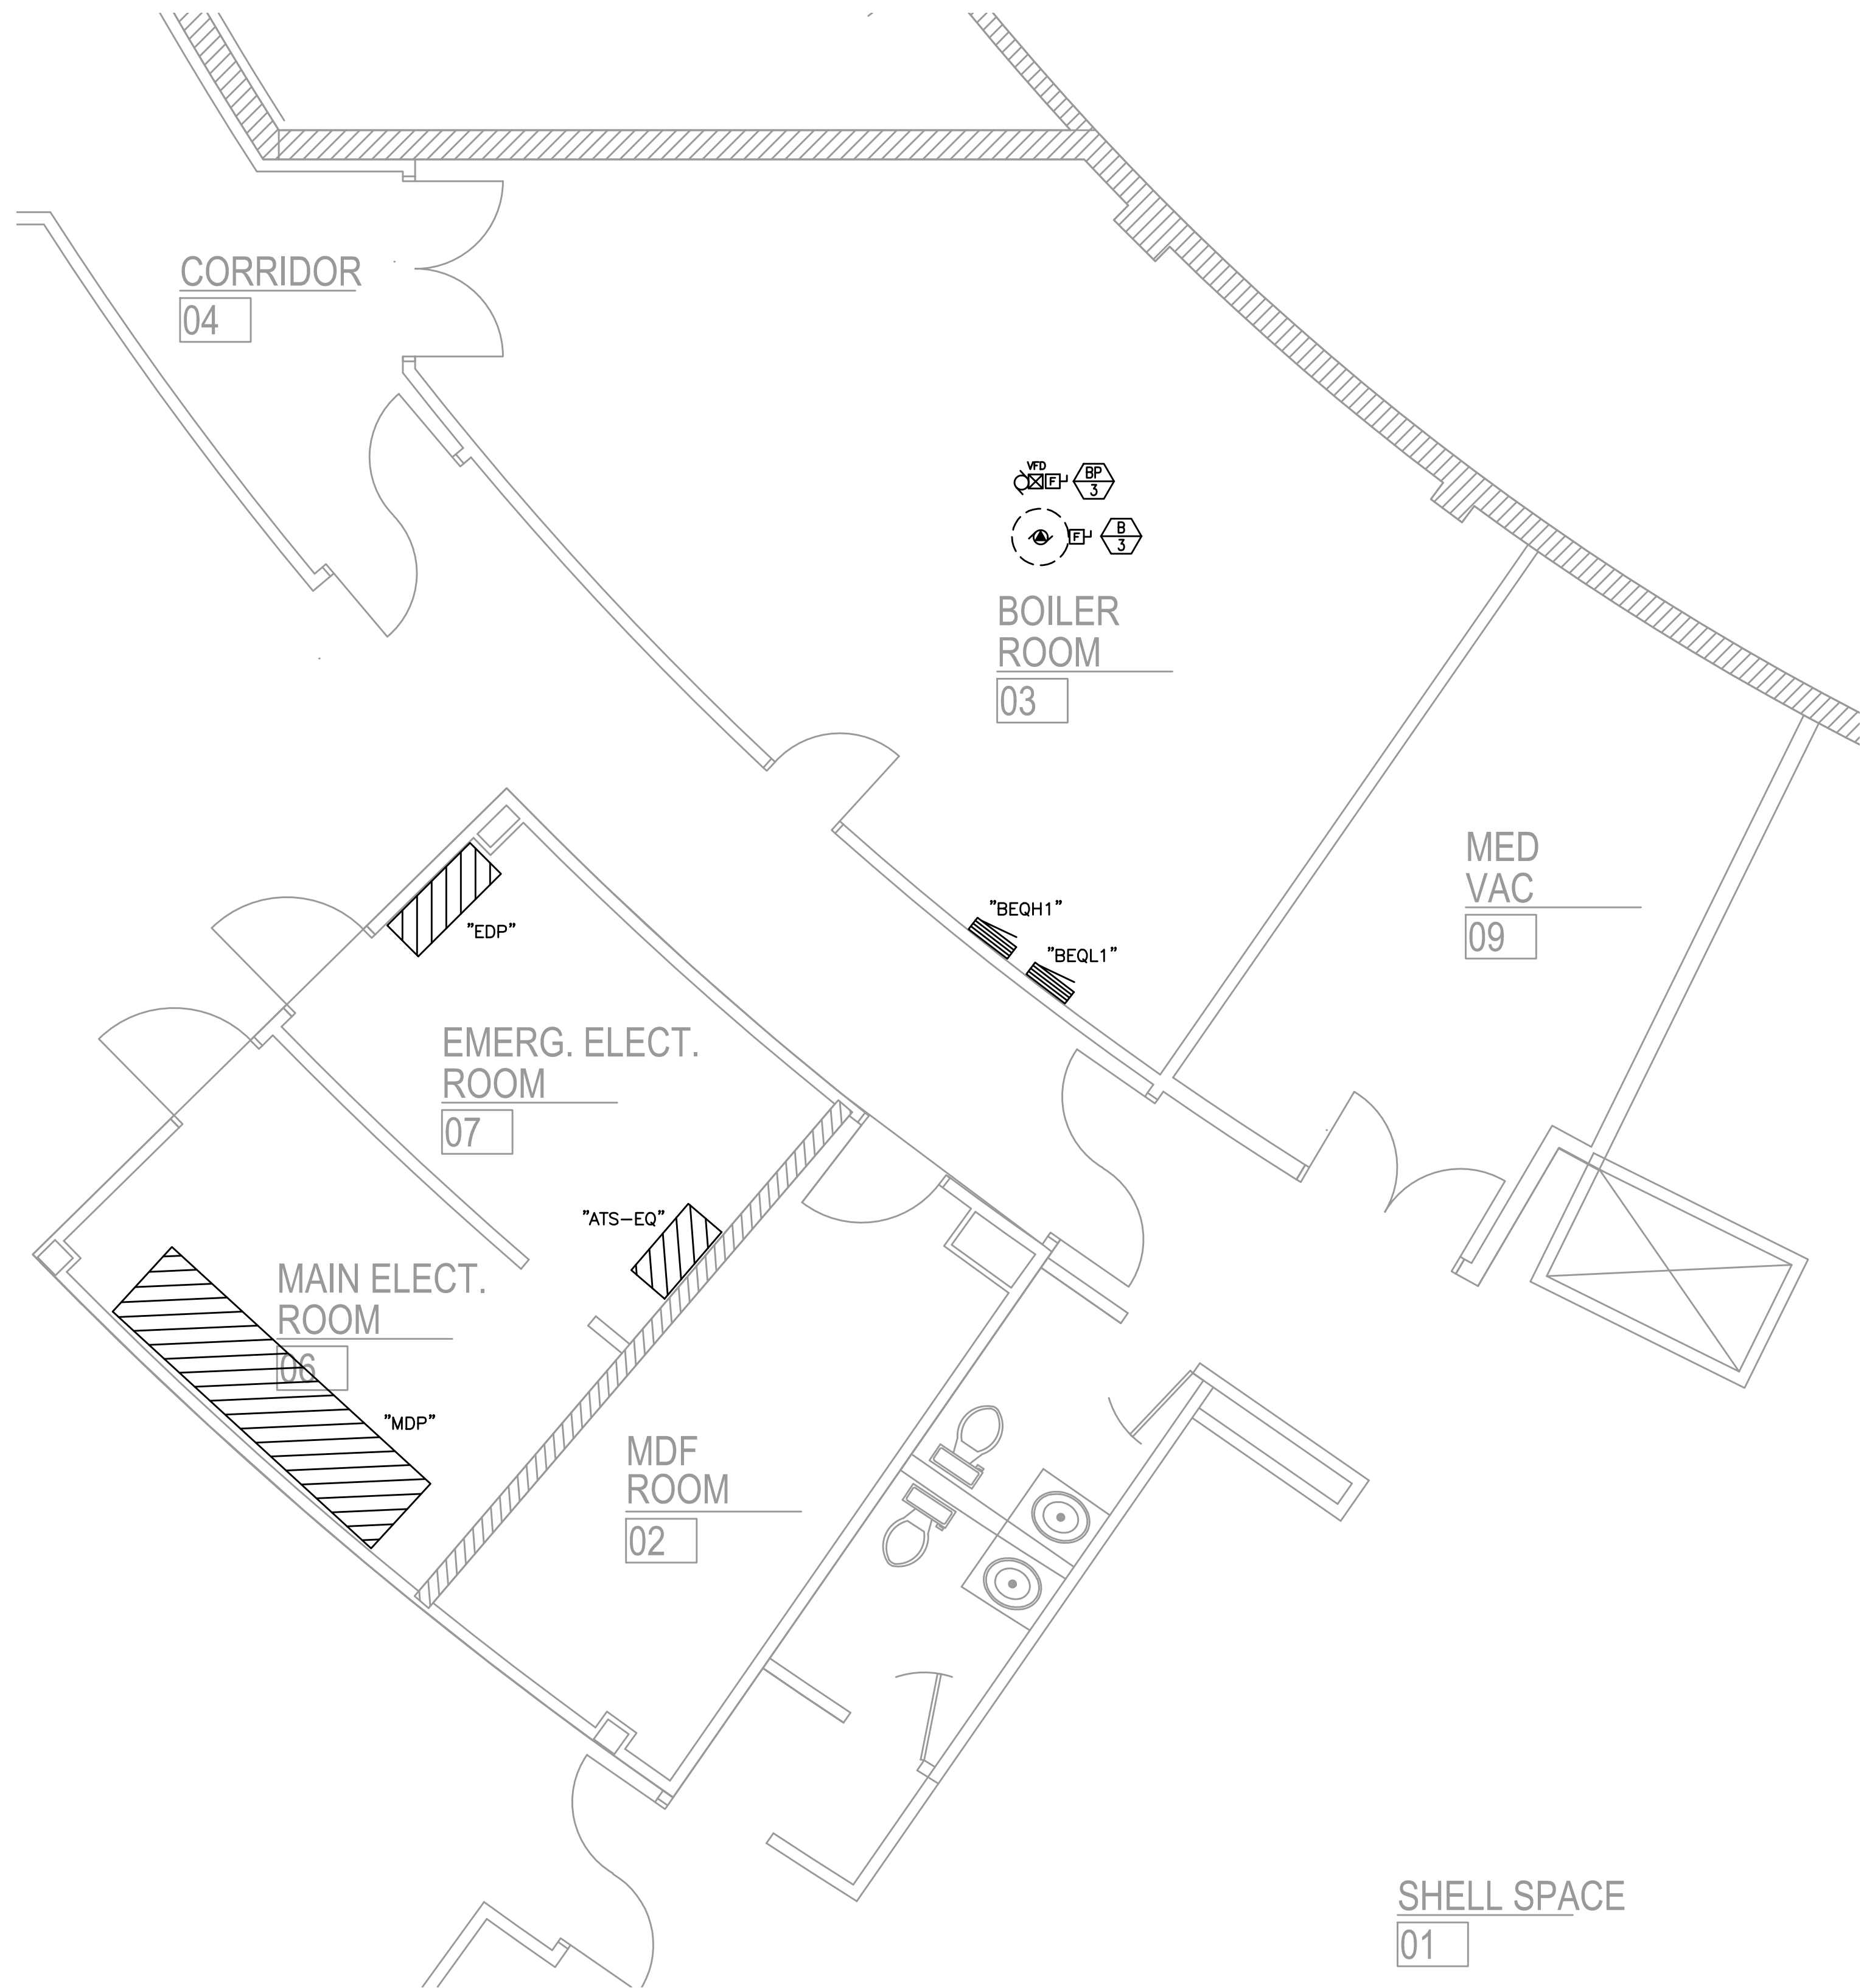

① x

PLAN NOTES

1 BASEMENT ELECTRICAL PLAN
E3.4 SCALE: 1/4" = 1'-0"

Consulting Engineers
2007 S.E. Ash St.
Portland, OR 97214
PHN: (503) 234-0548
FAX: (503) 234-0877
WWW.MFIA-ENG.COM
CONTACT: CHRIS WINER



BLUE ROOM ARCHITECTURE & DESIGN, P.S.

PO BOX 628
SPOKANE VALLEY, WA 99037
(509) 456-6800

www.brdstudio.com

CIVIL ENGINEER

STRUCTURAL ENGINEER

MECHANICAL ENGINEER
MFIA INC CONSULTING ENGINEERS
2007 SE ASH STREET
PORTLAND, OR 97214
(503) 234-0548

ELECTRICAL ENGINEER
MFIA INC CONSULTING ENGINEERS
2007 SE ASH STREET
PORTLAND, OR 97214
(503) 234-0548

PRELIMINARY
NOT FOR
CONSTRUCTION

THIS PROJECT INCLUDES THE INTERIOR REMODEL OF AN EXISTING
CRITICAL ACCESS HOSPITAL FACILITY THAT IS TO REMAIN
OPERATIONAL AT ALL TIMES. CONTRACTOR BIDS SHALL BE BASED
ON VERIFICATION OF EXISTING ON-SITE CONDITIONS.
UNINTERRUPTED ESSENTIAL HEALTHCARE SERVICES DURING THE
CONSTRUCTION PERIOD, ONGOING COORDINATION OF ALL RELATED
TRADES FOR CURRENT CODE COMPLIANCE, PATIENT SAFETY,
JURISDICTIONAL REVIEW, SYSTEM PERFORMANCE AND UNFORESEEN
CLINICAL DISRUPTION(S).

INTERIOR REMODEL/ADDITION FOR:

SKYLINE
HOSPITAL
CRITICAL ACCESS HOSPITAL
MODERNIZATION
CRS #10 TO BE DETERMINED
211 SKYLINE DRIVE
WHITE SALMON, WASHINGTON 98672

PROJECT NUMBER: 180026
DATE: 10/31/2018
DRAWN: CU
REVISIONS:

NOT FOR CONSTRUCTION

BASEMENT
ELECTRICAL
PLAN

E3.4

© 2018 BLUE ROOM ARCHITECTURE & DESIGN, P.S.