


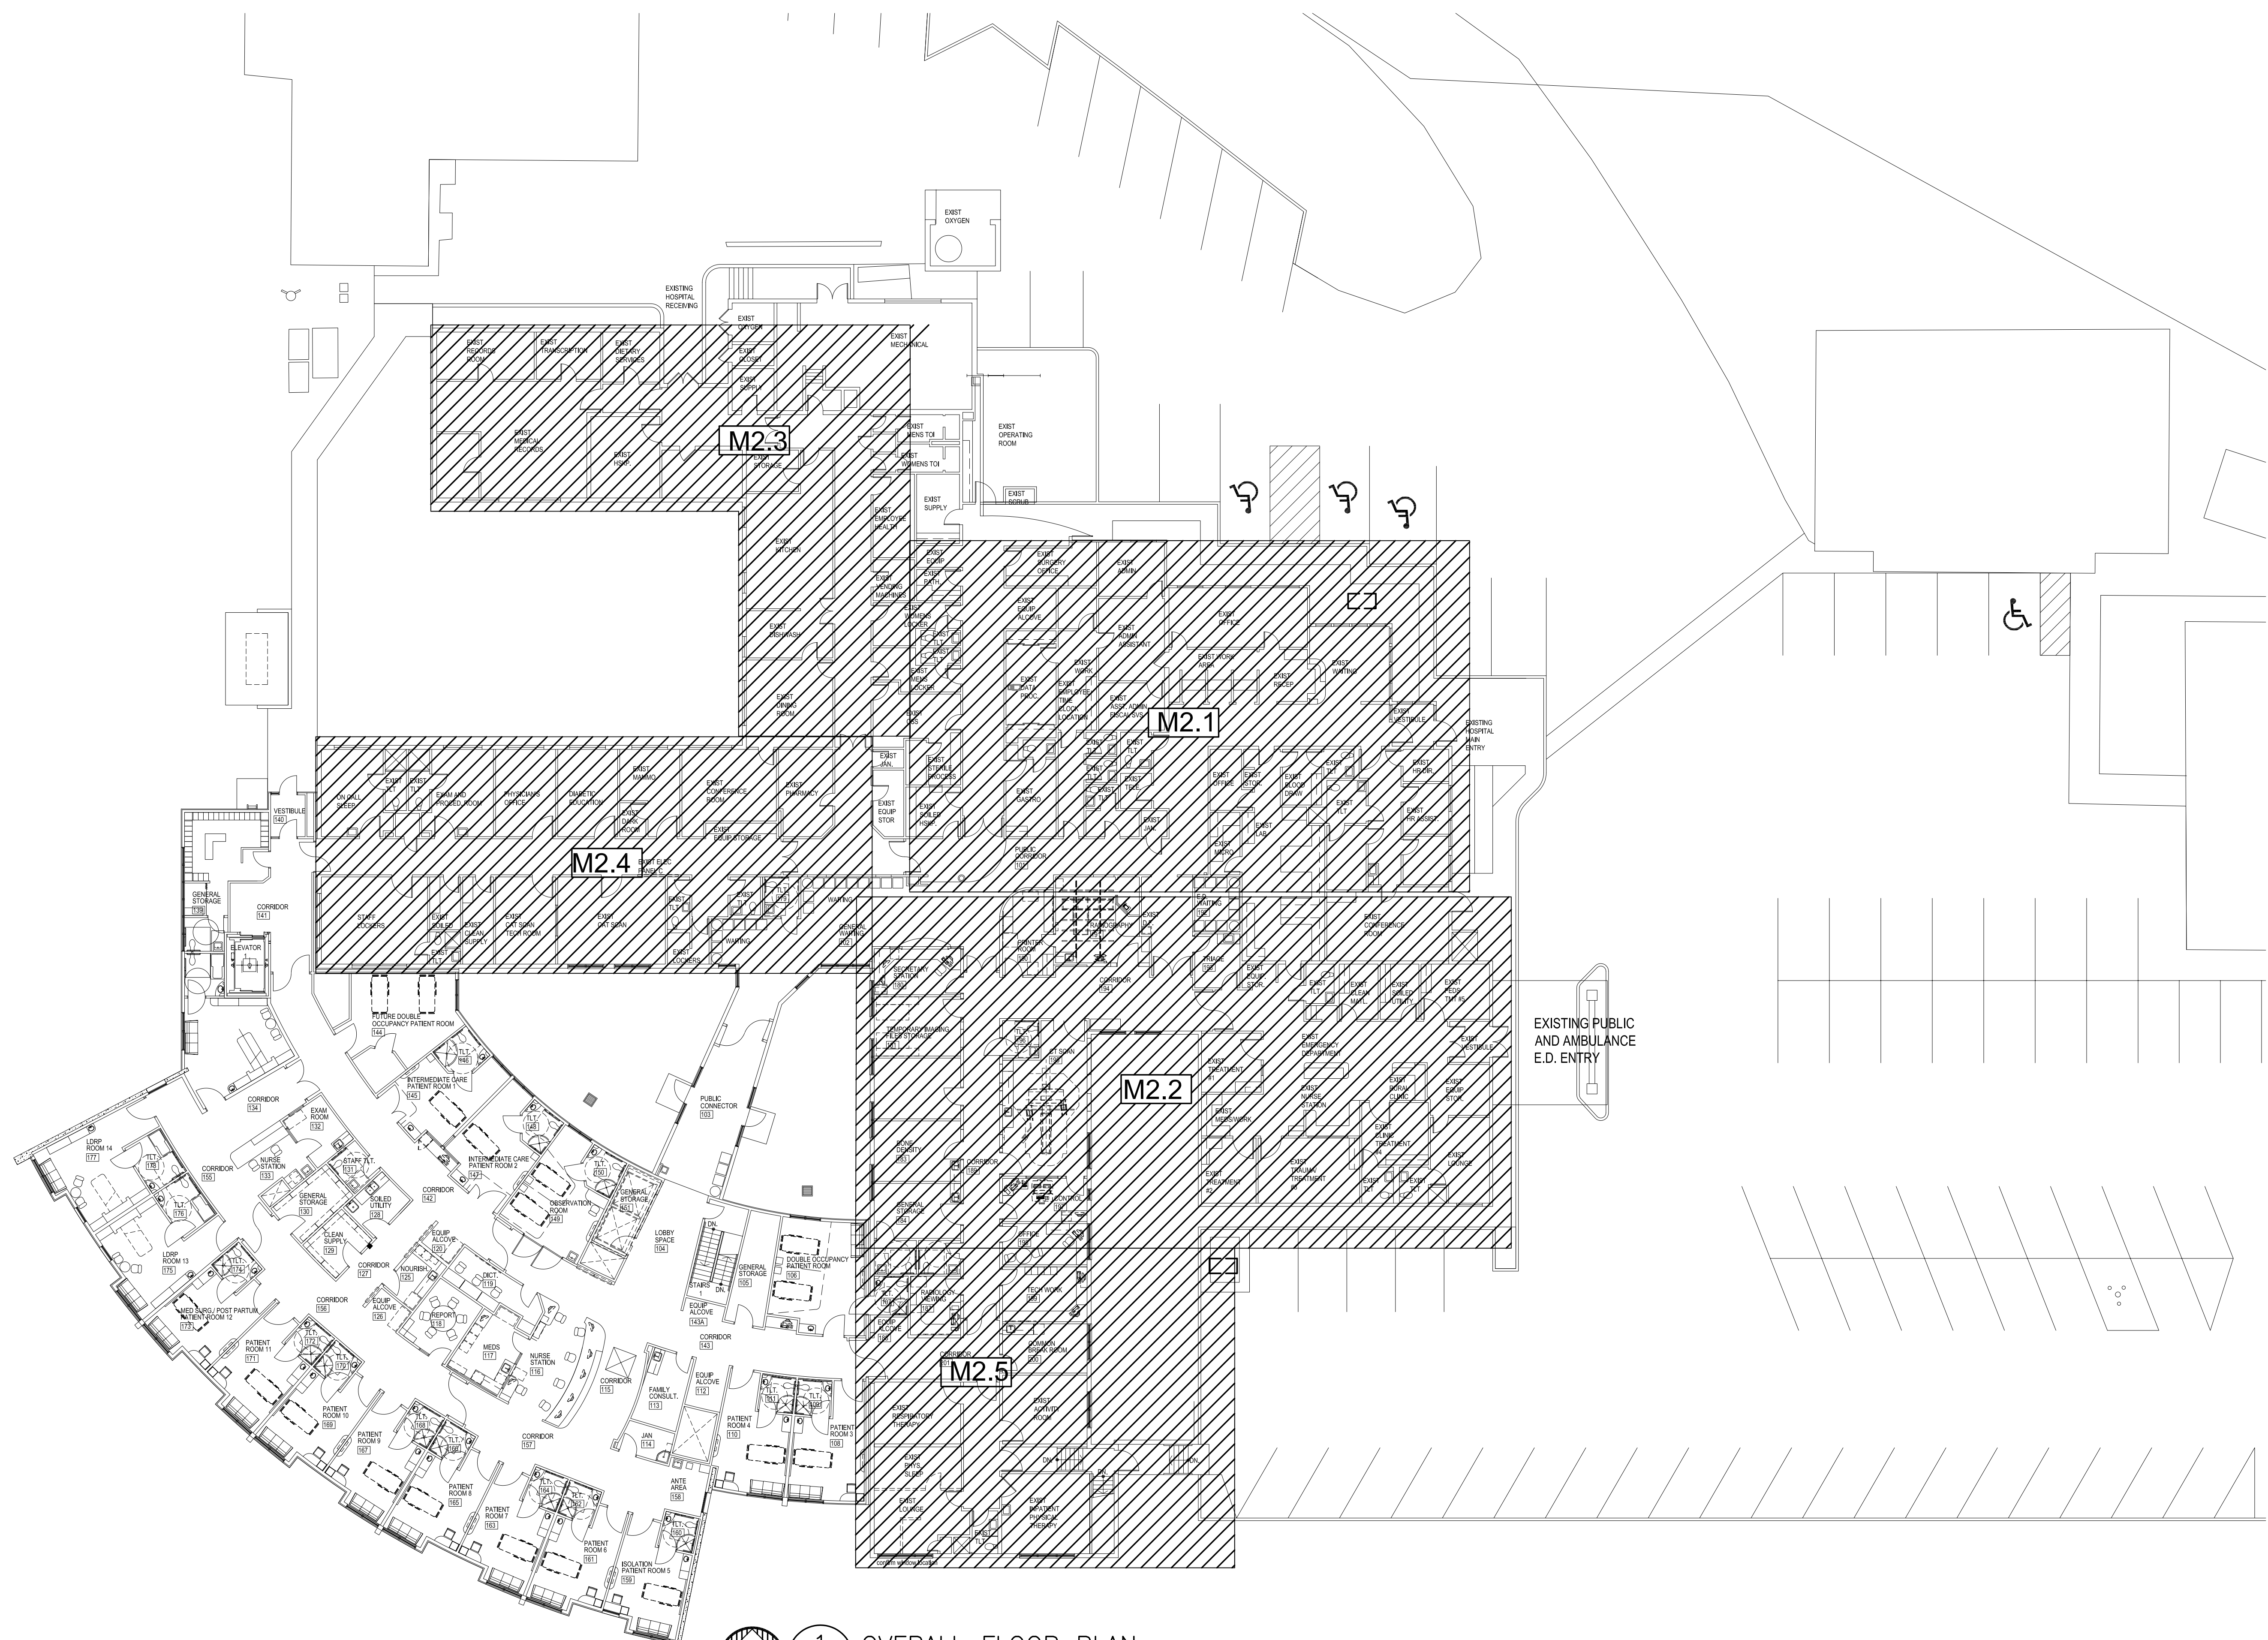

1 OVERALL FLOOR PLAN
M2.0 SCALE: 1/16" = 1'-0"



Date:	09/19/2016
Proj No:	9140
Drawn By:	TB
Chkd By:	TB
DSGN By:	TB
Acad File:	

HVAC UPGRADES - PHASE 1
Skyline Hospital
211 Skyline Drive

MECHANICAL DEMO PLAN

White Salmon WA



Consulting Engineers
2007 S.E. Ash St.
Portland, OR 97214
PHN: (503) 234-0548
FAX: (503) 234-0677
WWW.MFA-ENG.COM