


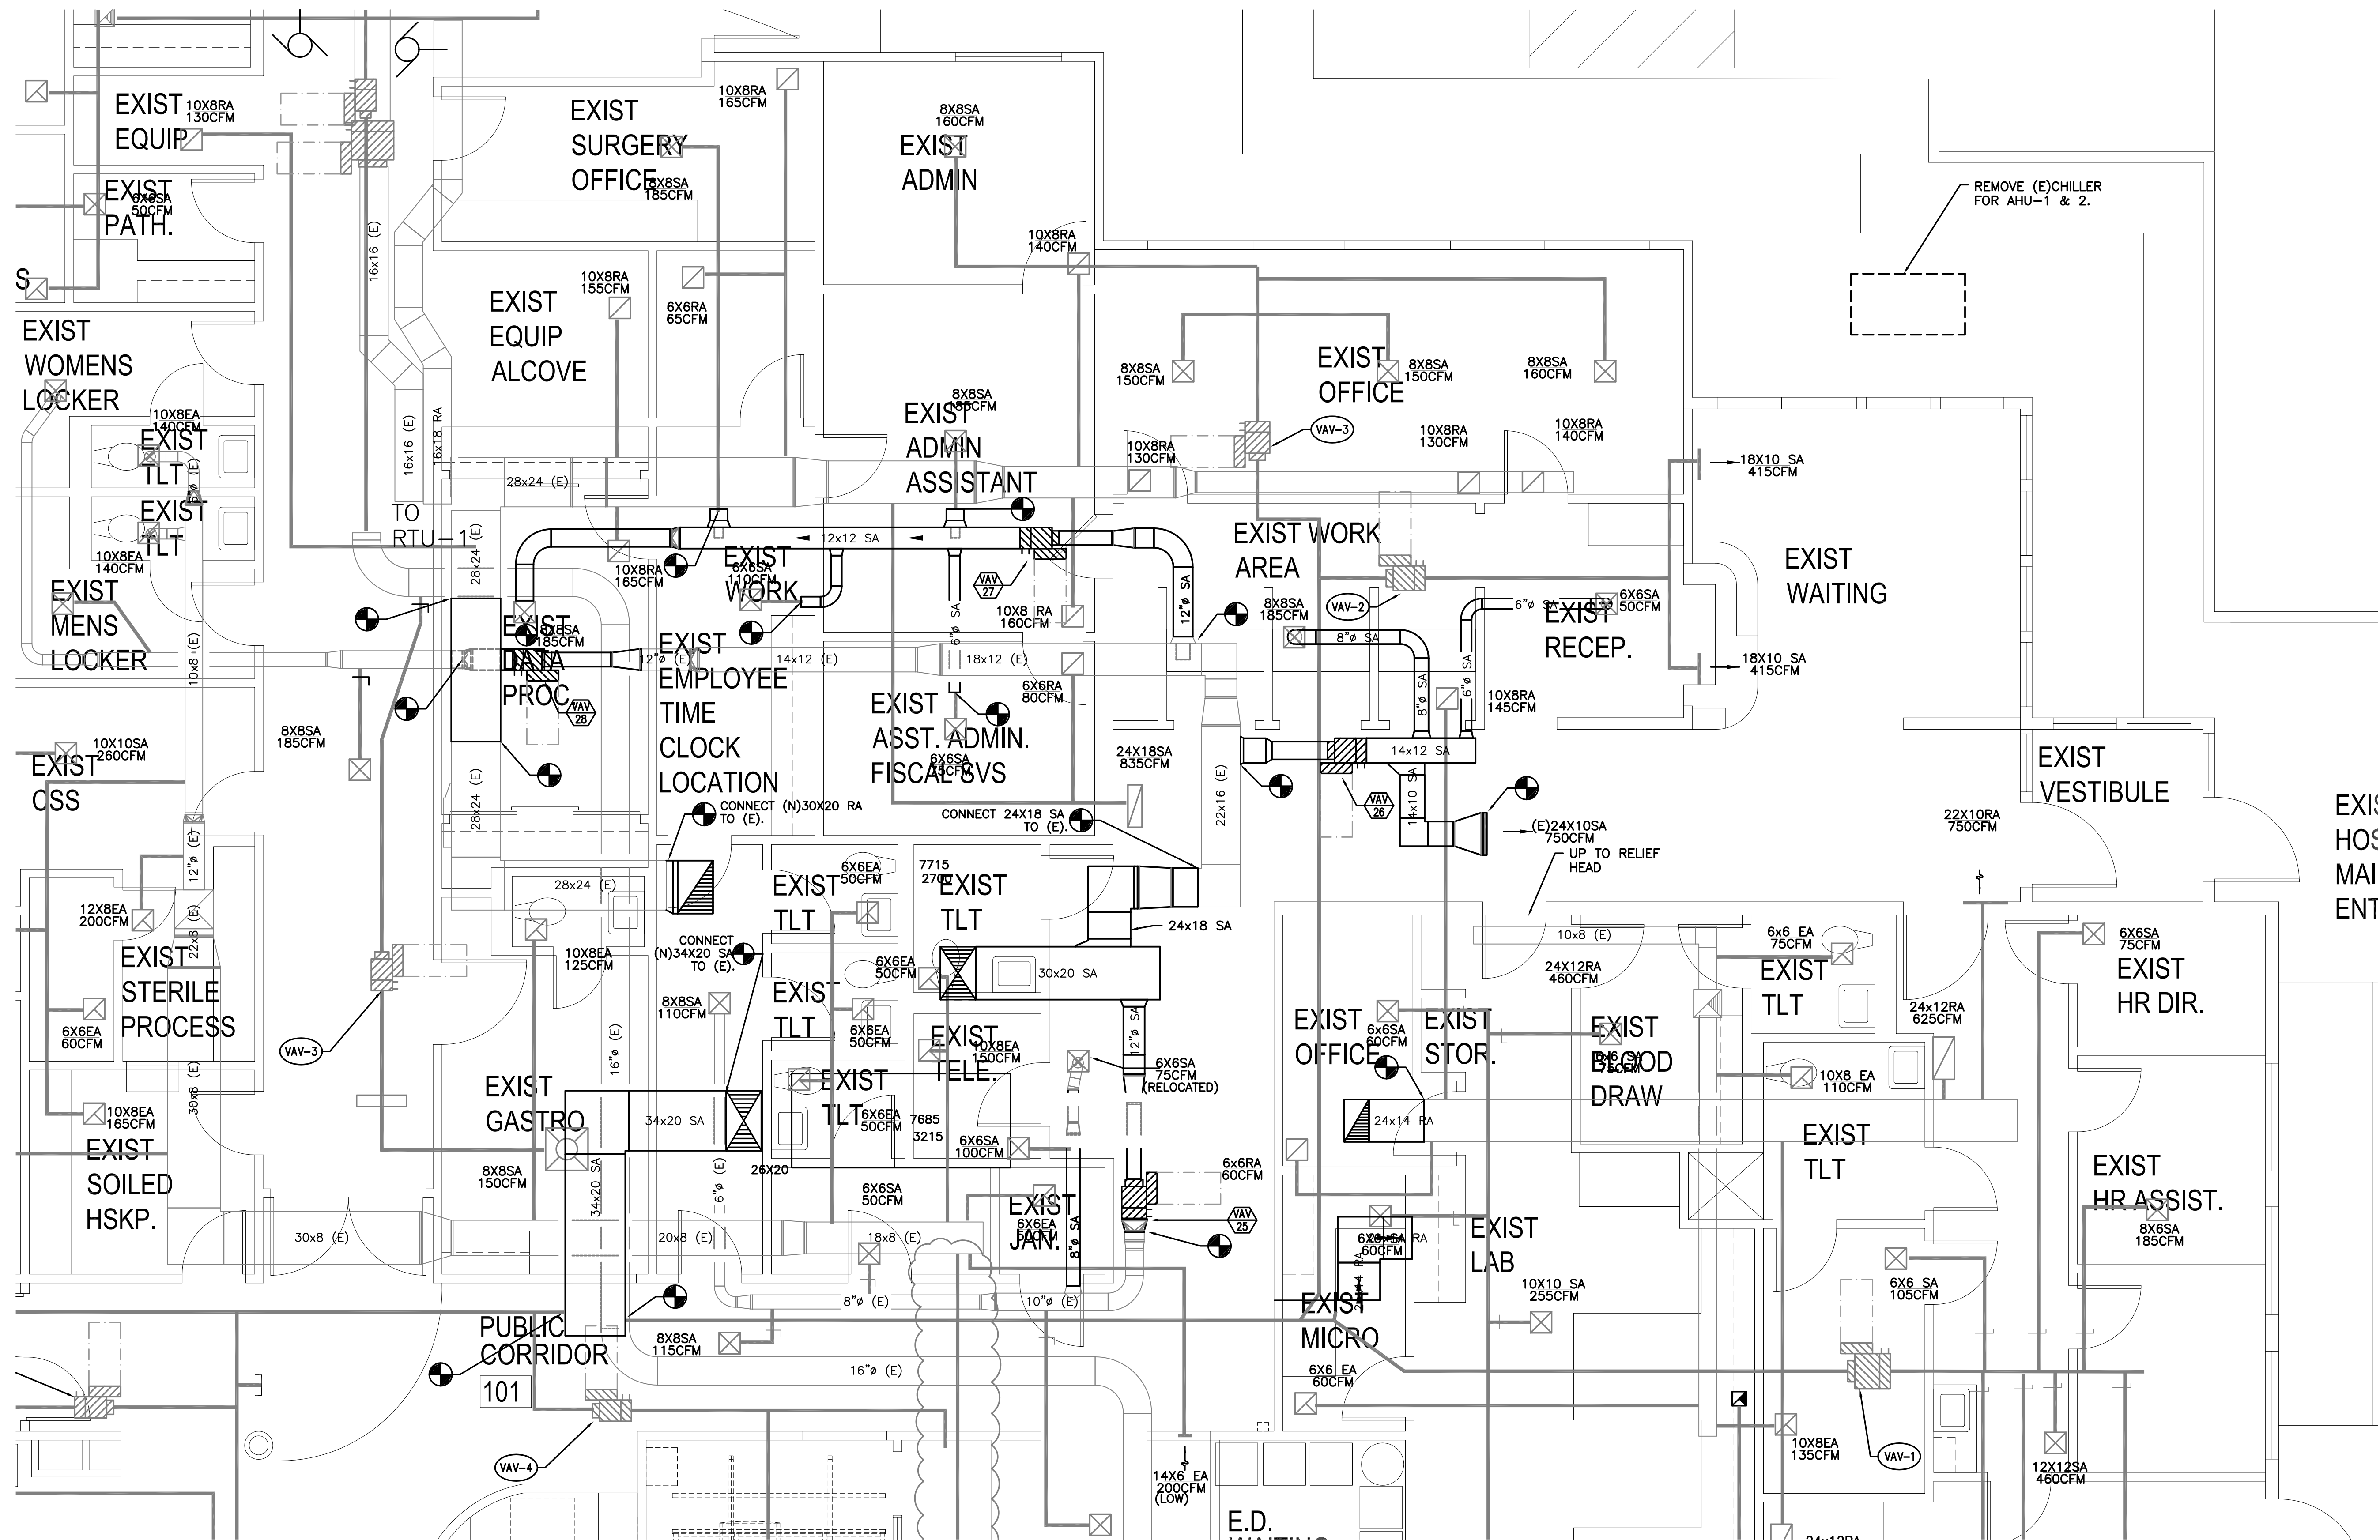

1 PARTIAL FLOOR PLAN
M2.1 SCALE: 1/4" = 1'-0"

SHEET NOTES:
1. TO MAINTAIN AHU OPERATIONS OF EXISTING FACILITIES AND TO MINIMIZE DOWNTIME, INSTALL NEW DUCTWORK PRIOR TO DEMO OF (E)AHU'S, RETURN FANS AND DUCTWORK AS MUCH AS POSSIBLE. CONTRACTOR TO DETERMINE BEST LOCATION FOR STUB-OUT FOR CONNECTION TO EXISTING.

KEYED NOTES:
1. REMOVE (E) RETURN FAN AND CONTROLS.



Date: 09/19/2016
Proj No: 9140
Drawn By: TB
Chkd By: TB
DSN By: TB
Acad File:

WA
HVAC UPGRADES - PHASE 1
Skyline Hospital
211 Skyline Drive
MECHANICAL DEMO PLAN

White Salmon



Consulting Engineers
2007 S.E. Ash St.
Portland, OR 97214
PHN: (503) 234-0548
FAX: (503) 234-0677
WWW.MFA-ENG.COM

SHEET

M2.1

OF