



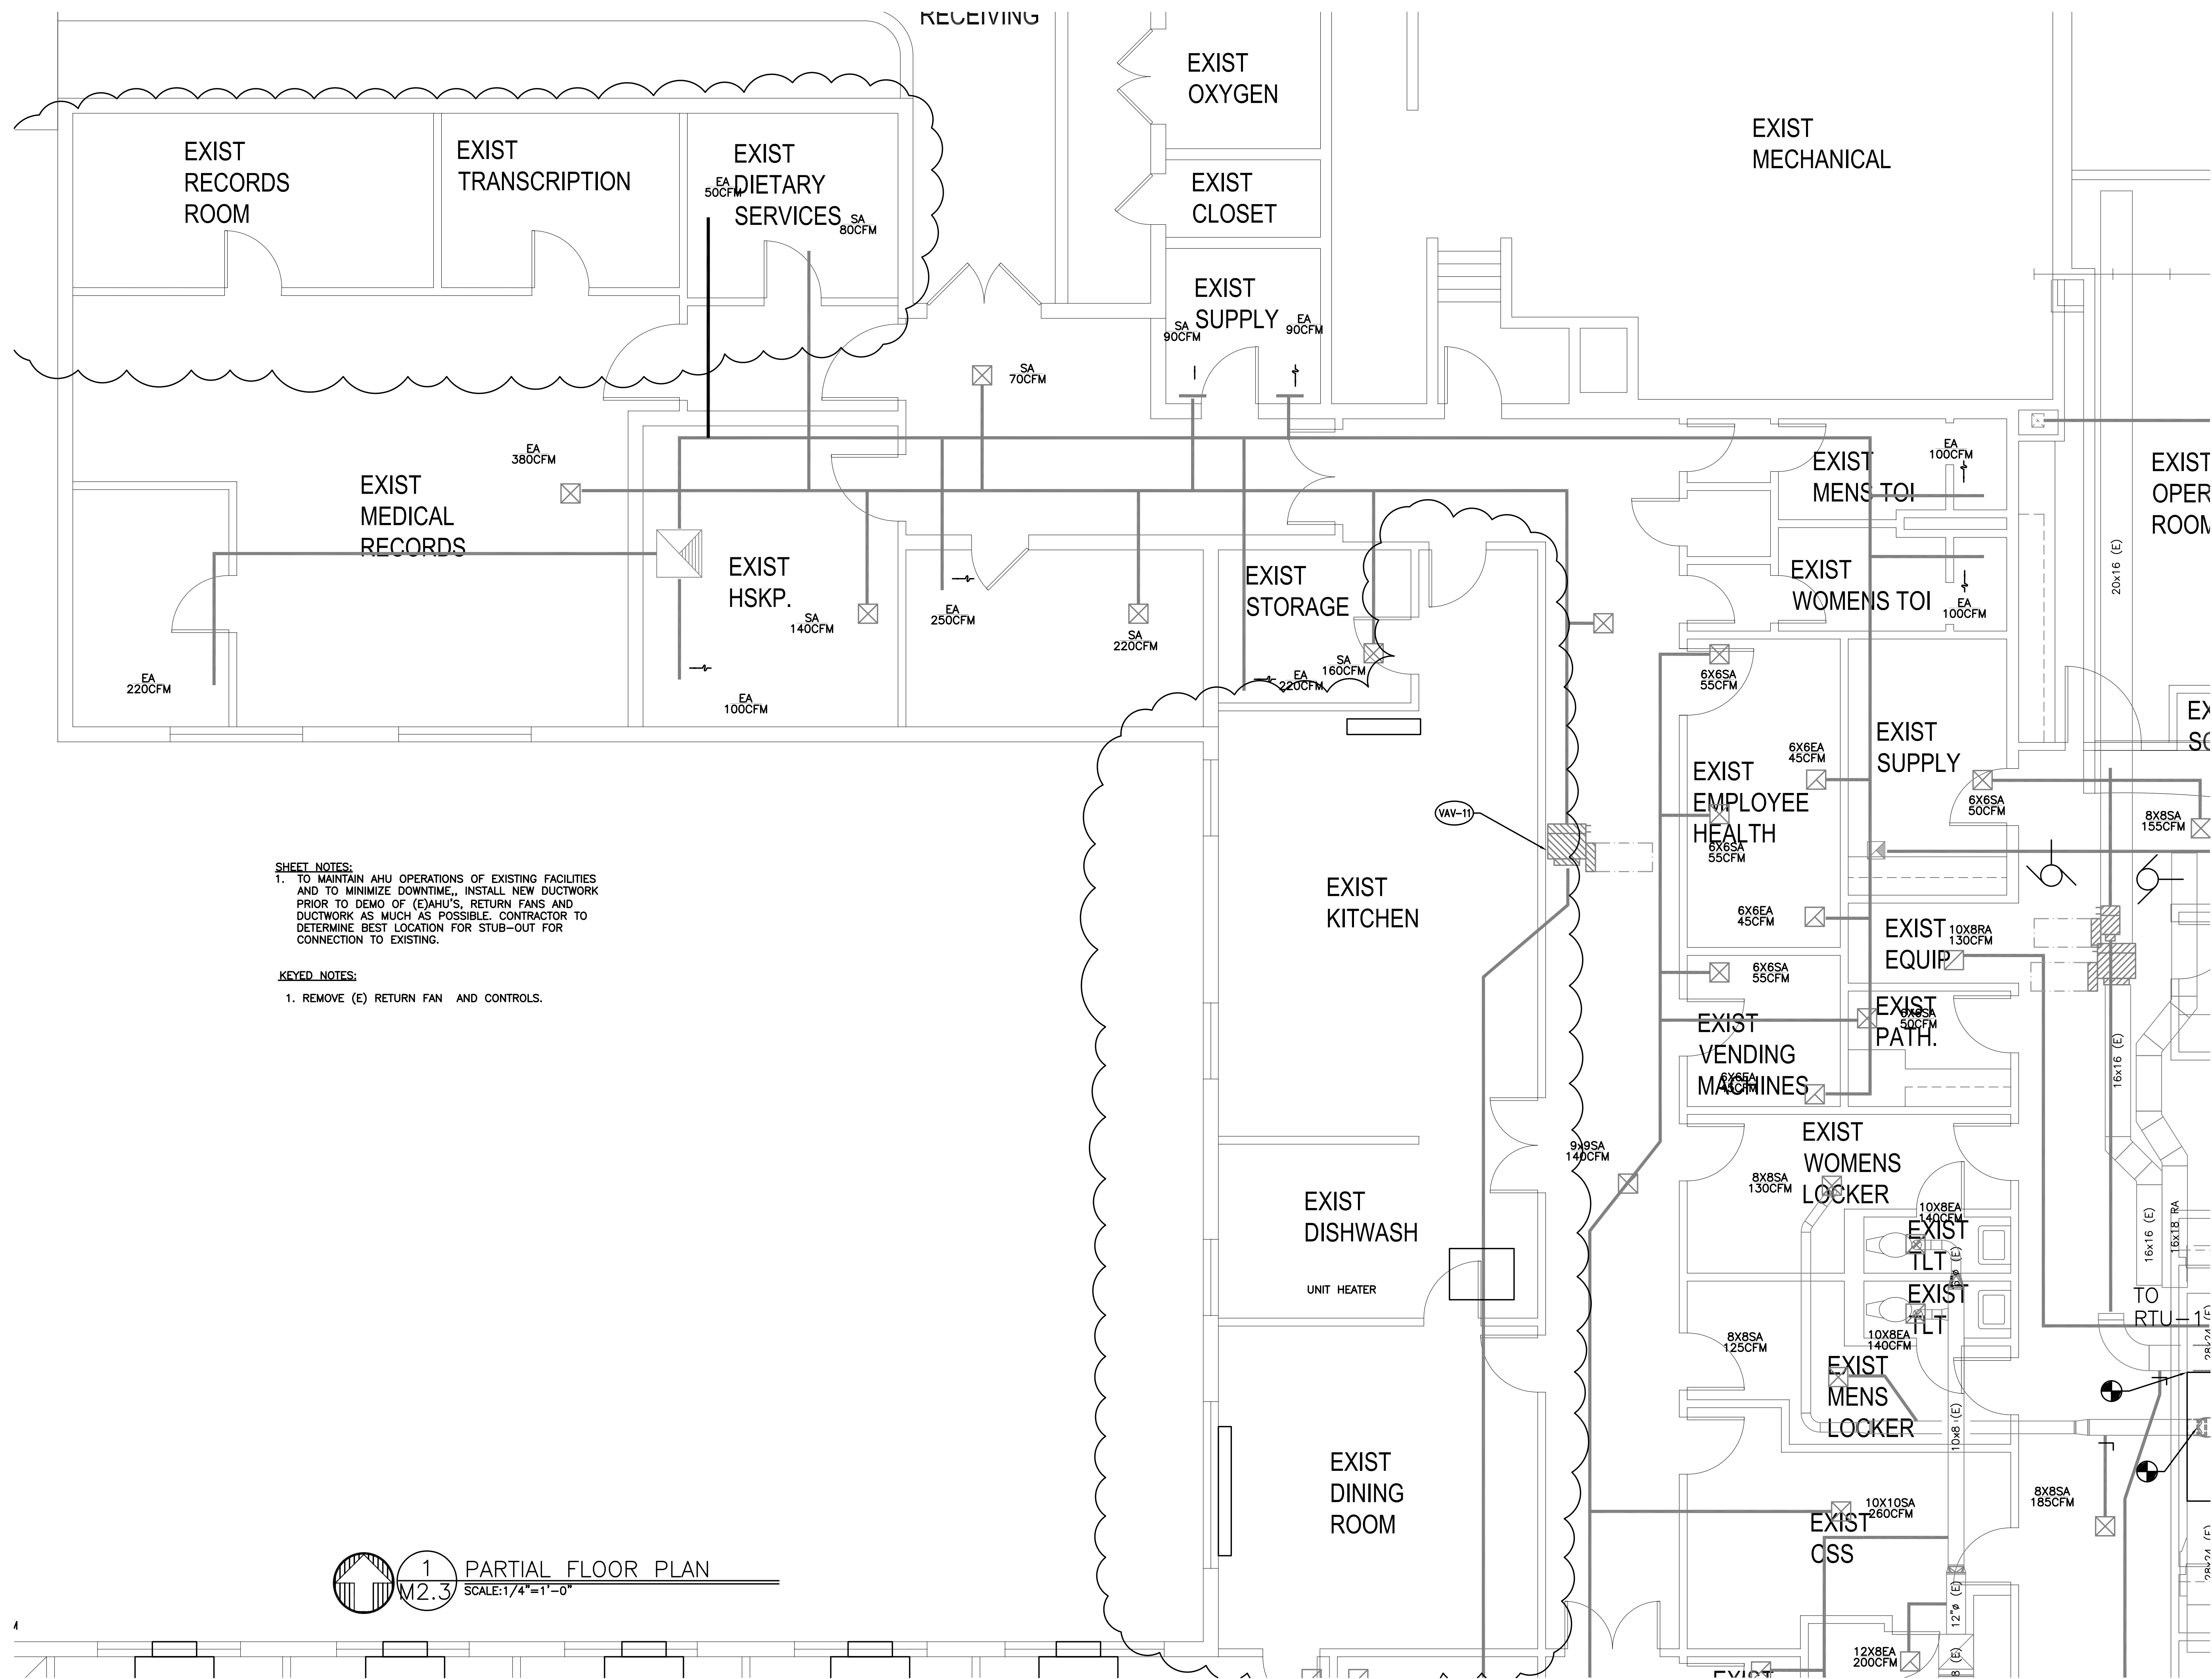

SHEET NOTES:
1. TO MAINTAIN AHU OPERATIONS OF EXISTING FACILITIES AND TO MINIMIZE DOWNTIME,, INSTALL NEW DUCTWORK PRIOR TO DEMO OF (E)AHU'S. RETURN FANS AND DUCTWORK AS MUCH AS POSSIBLE. CONTRACTOR TO DETERMINE BEST LOCATION FOR STUB-OUT FOR CONNECTION TO EXISTING.

KEYED NOTES:
1. REMOVE (E) RETURN FAN AND CONTROLS.

1 PARTIAL FLOOR PLAN
M2.3 SCALE:1/4"=1'-0"

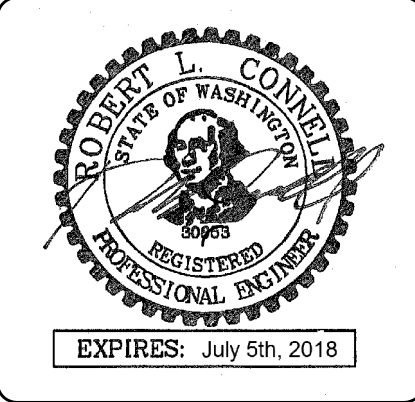

Date:	09/19/2016
Proj No:	9140
Drawn By:	TB
Chkd By:	TB
DSN By:	TB
Acad File:	

HVAC UPGRADES - PHASE 1
Skyline Hospital
211 Skyline Drive

White Salmon

WA

MECHANICAL DEMO PLAN



Consulting Engineers
2007 S.E. Ash St.
Portland, OR 97214
PHN: (503) 234-0548
FAX: (503) 234-0677
WWW.MFA-ENG.COM

SHEET
M2.3
OF