


2 PRV STATION PIPING DETAIL
M1.0 NO SCALE

1 CHILLER ROOM - BASEMENT PIPING PLAN
SCALE: 1/4" = 1'-0"

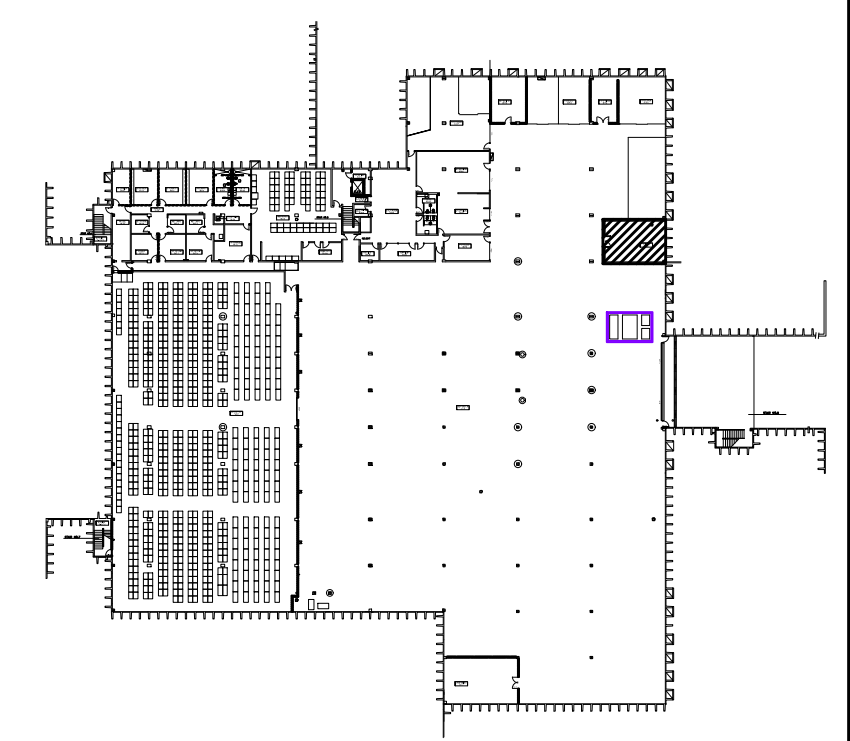

REPLACE COOLING TOWER

JOHN B. YEON FACILITY
1620 SE 190TH ST
GRESHAM, OREGON, 97233

Mark	Date	Description of Revision	By

Consultant Project No: 16050-16
 CAD DWG FILE: Drawn By: M1.0
 Checked By: Approved By:
 M.C. Bldg # - Proj # B425 - CP08.18.24
 Sheet Title: CHILLER ROOM - BASEMENT PIPING PLAN
 Date: 09.12.2018
M1.0
 M Sheet of TNS

PRICING ISSUE 12 SEPTEMBER 2018