


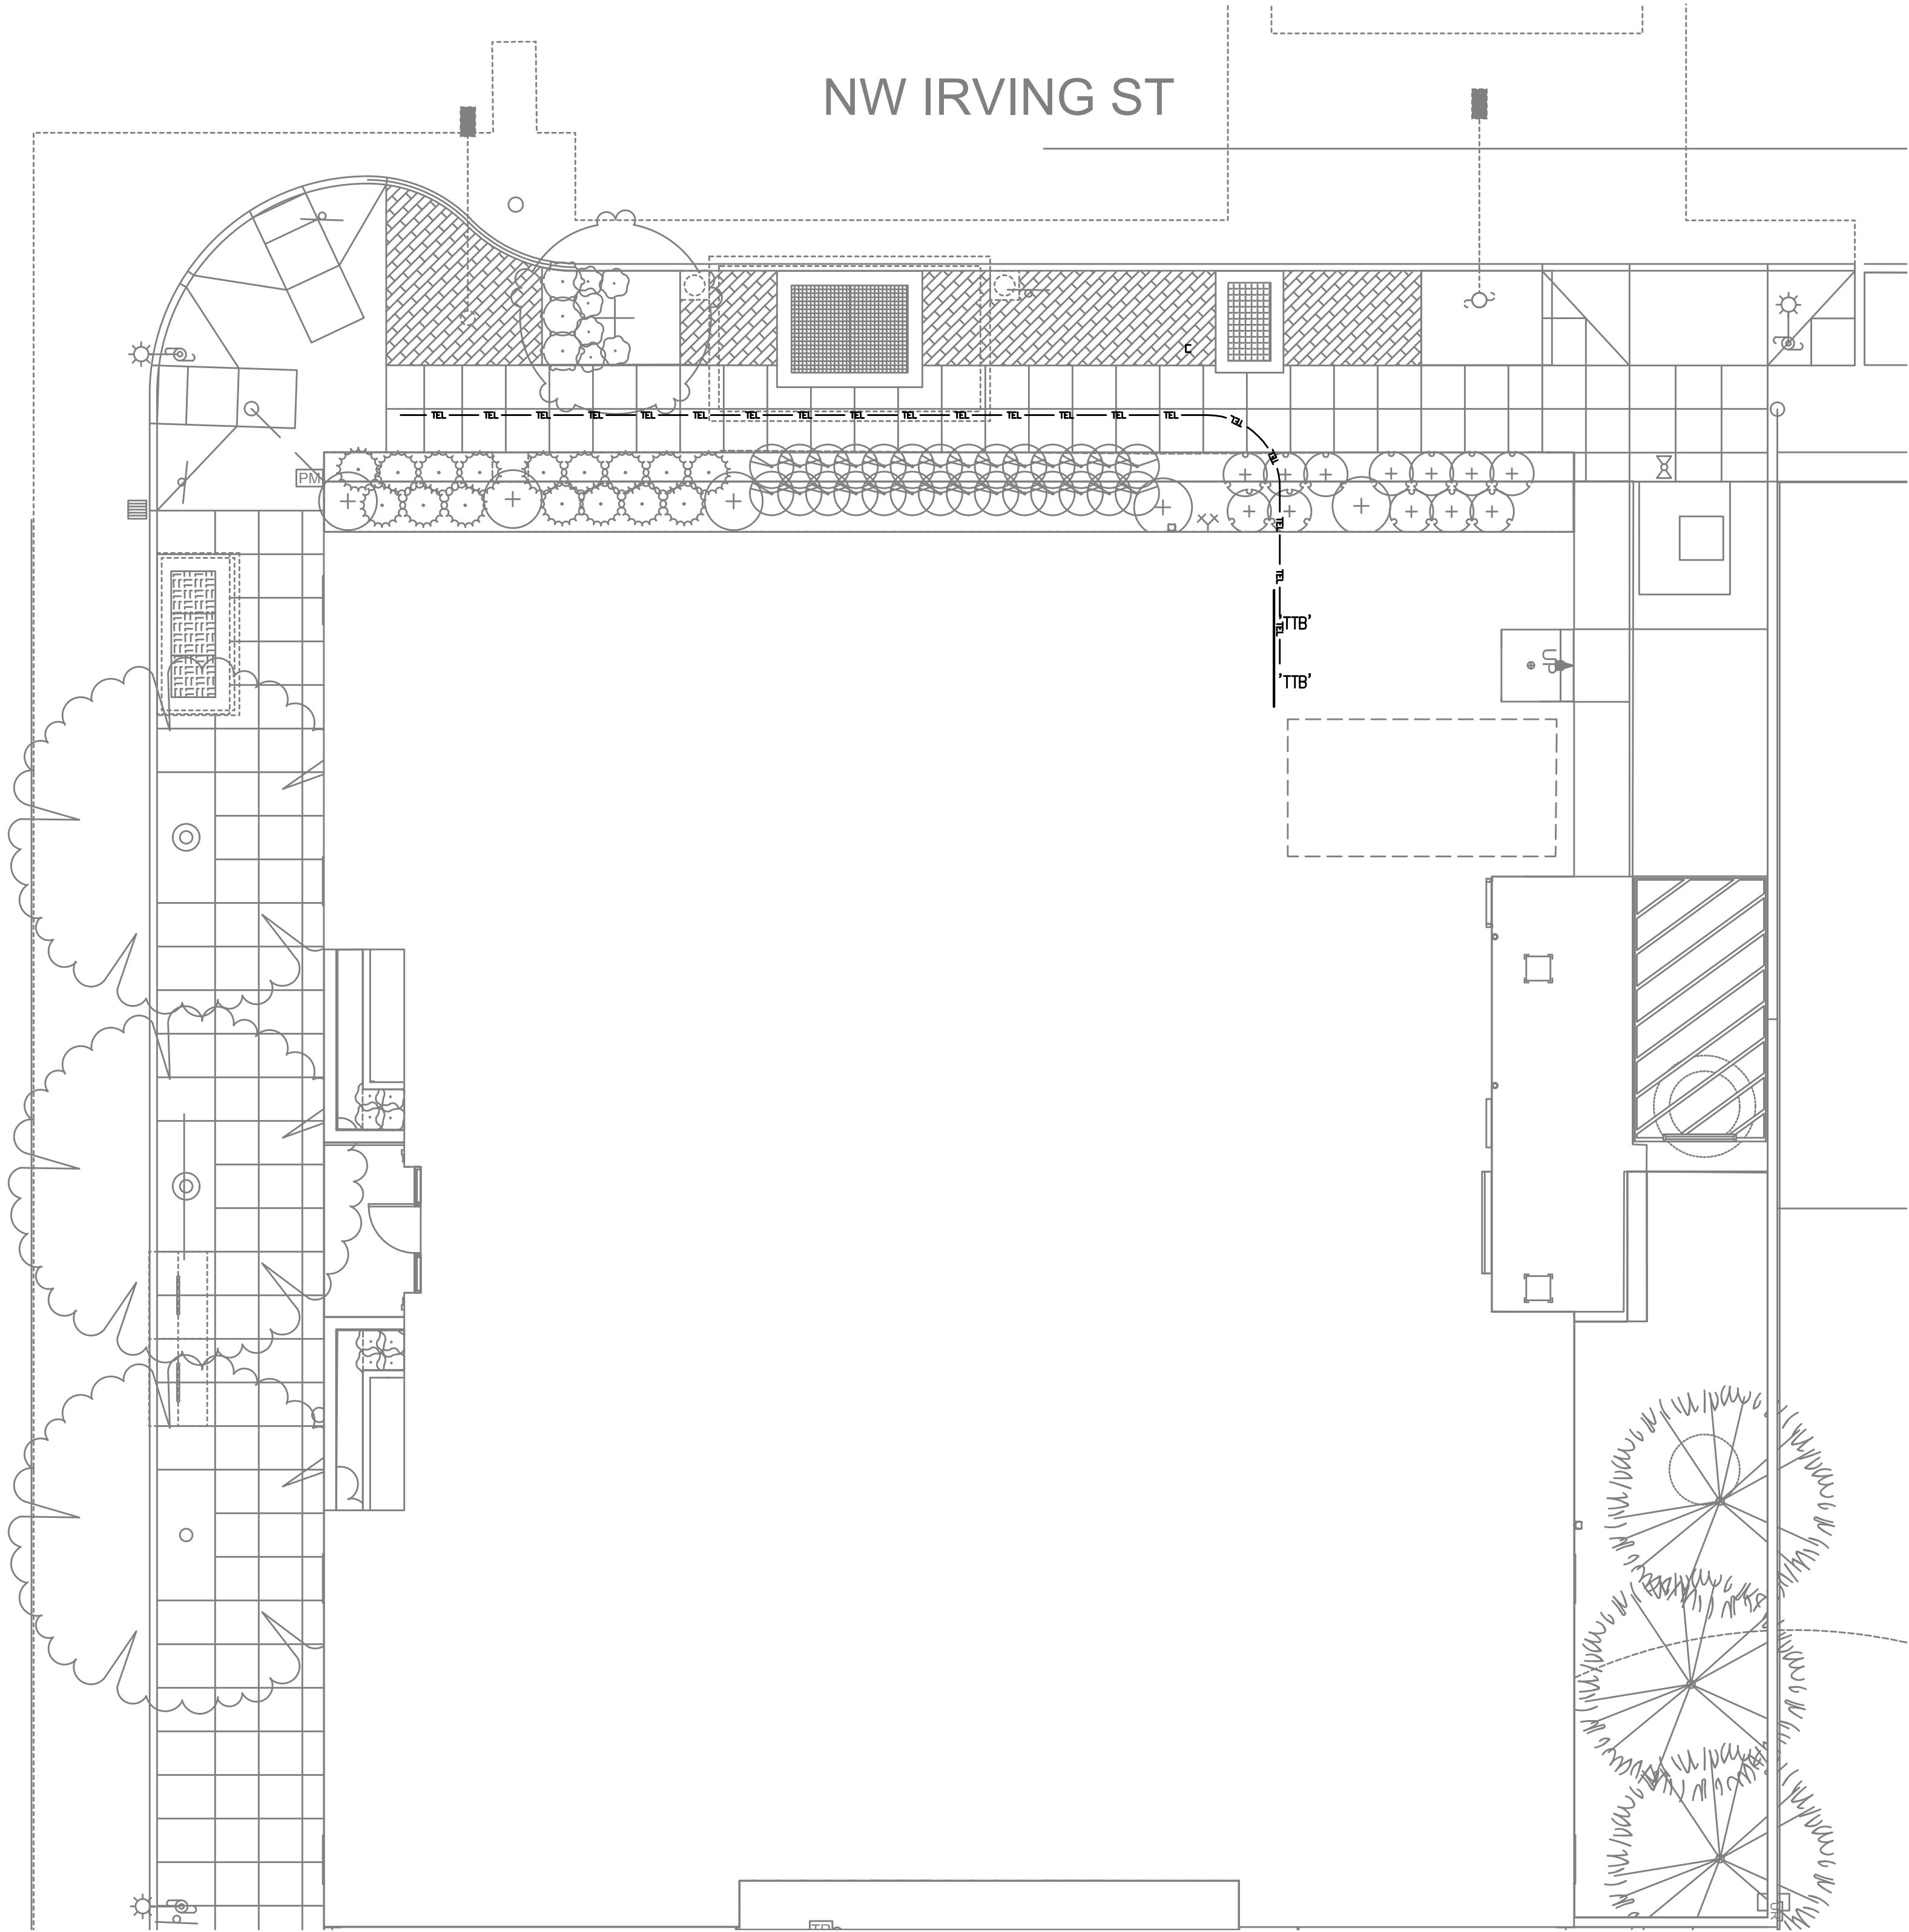

GENERAL NOTES:

- A. ALL PLANS ARE CONSIDERED DIAGRAMMATICAL. THEREFORE ALL EQUIPMENT SIZES AND DEVICE LOCATIONS ARE APPROXIMATE AND SUBJECT TO FIELD CONDITIONS AND PRODUCT APPROVAL.
- B. UTILITY SERVICE ENTRANCE CONDUIT SIZE AND ROUTING TO BE CONFIRMED WITH OWNER SELECTED UTILITIES.
- C. COORDINATE WITH LOCAL UTILITY PROVIDER FOR DEPTH AND CONDUIT BEND REQUIREMENTS.
- D. CONTRACTOR TO LOCATE ALL UNDERGROUND UTILITIES BEFORE TRENCHING. COORDINATE WITH CIVIL.

1 SITE PLAN — NORTH BUILDING
T1.01 SCALE: 3/32" = 1'-0"

NOTE: DRAWINGS ARE AT HALF SCALE WHEN PRINTED AT 11X17
COPYRIGHT: CARLETON HART ARCHITECTURE DO NOT REPRODUCE WITHOUT PERMISSION

TECHNOLOGY SITE PLAN
PROJECT NO. 17004
10/02/2020
REVISIONS: 

SUSAN EMMONS - NORTH BLDG
624 NW 18TH AVENUE
PORTLAND, OR
NORTHWEST HOUSING ALTERNATIVES
PERMIT SET


CARLETON HART ARCHITECTURE P.C.
830 SW 10th Avenue #200 Portland, OR 97205
503 243 2252 | www.carletonhart.com

M Consulting Engineers
2007 S.E. Ash St
Portland, OR 97214
PHN: (503) 234-0548
FAX: (503) 234-0677
INC. WWW.MFIA-ENG.COM
CONTACT: GARY ADONIK

