


d:\dowa\architects\6470_parkrose_middle_school\mechanical\record drawings\complete - cad\ans\pdf\6470m201.dwg 8/14/2016 2:07 PM

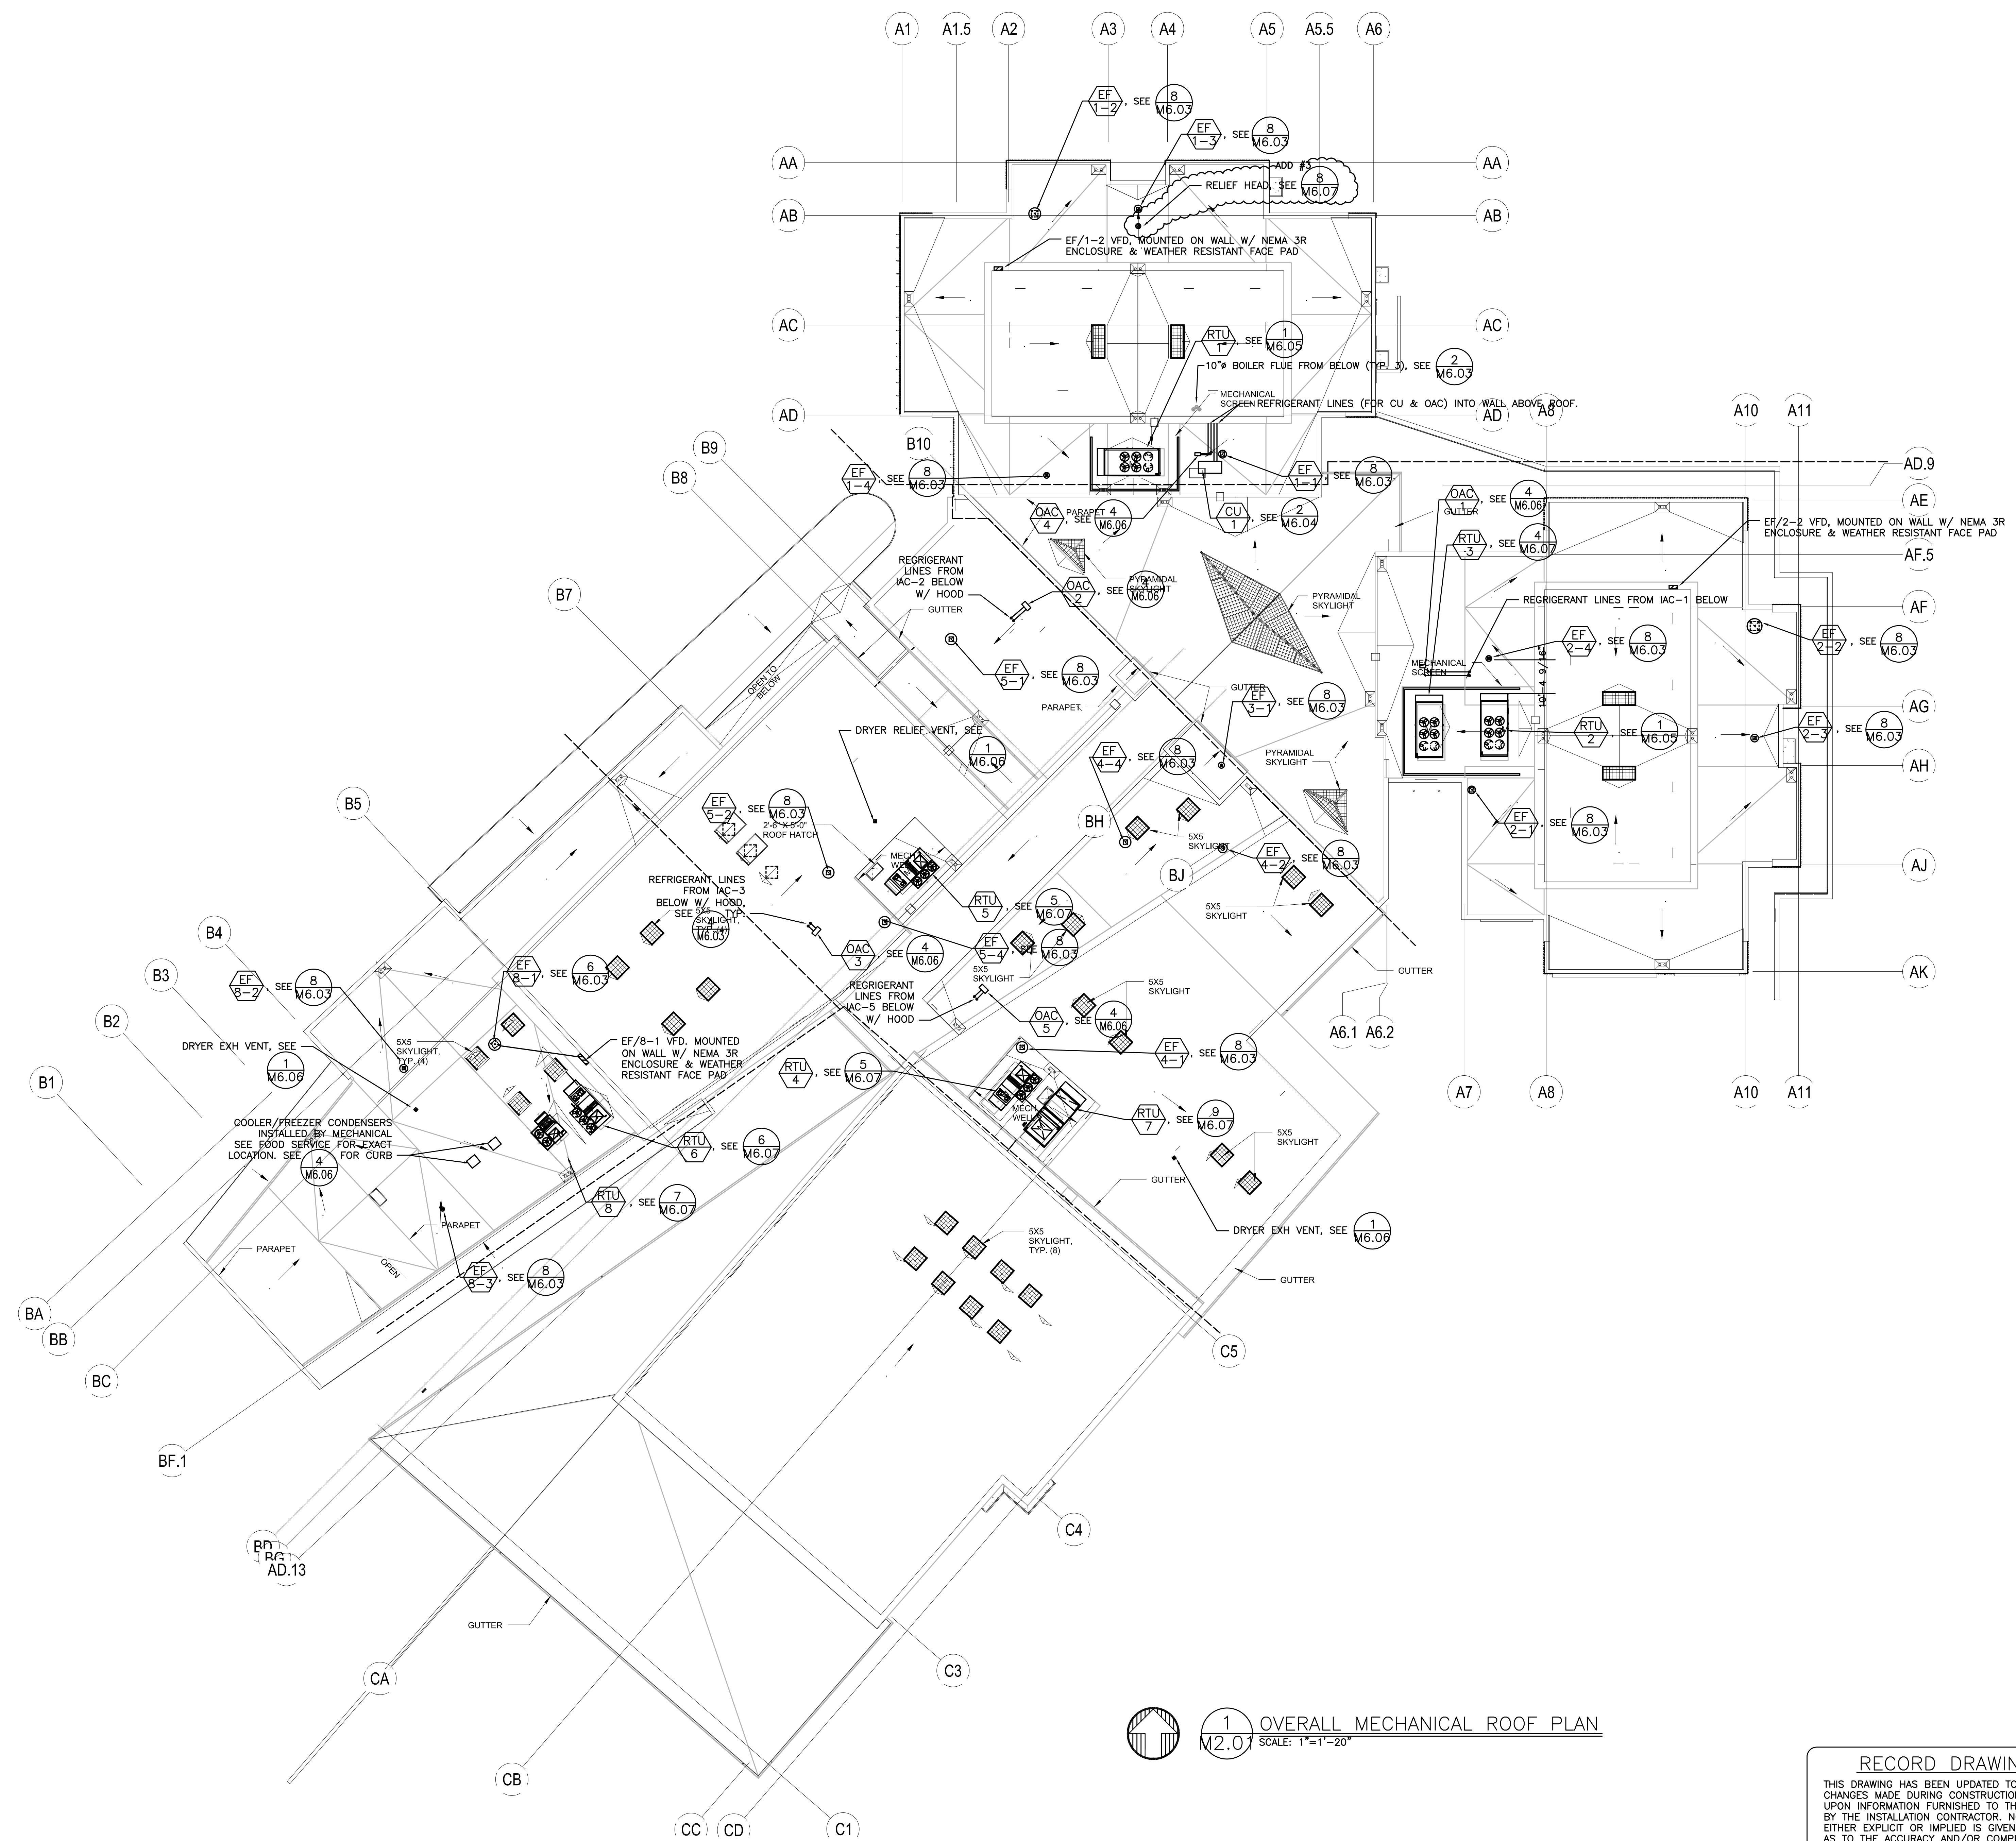

1 OVERALL MECHANICAL ROOF PLAN
 12.01 SCALE: 1"=1'-20"

RECORD DRAWING:
 THIS DRAWING HAS BEEN UPDATED TO REFLECT CHANGES MADE DURING CONSTRUCTION BASED UPON INFORMATION FURNISHED TO THE ENGINEER BY THE INSTALLATION CONTRACTOR. NO WARRANTY, EITHER EXPLICIT OR IMPLIED IS GIVEN BY MFA, INC. AS TO THE ACCURACY AND/OR COMPLETENESS OF THIS INFORMATION.

phase	RECORD DRAWING
date	11/09/2015
revisions	
project #	11082