



phase	RECORD DRAWING
date	11/09/2015
revisions	
project #	11082

LEVEL 1 SECTOR 'E'  
 MECHANICAL PIPING PLAN

**M3.15**

- GENERAL NOTES:**
- SEE 3/M6.06 FOR SUPPORT OF FLEX PIPE.
  - SEE 9/M6.06 FOR SEISMIC PIPE SUPPORT. NOTE: SEISMIC SUPPORTS SHOWN ARE BASED ON ANTICIPATED REQUIREMENTS. DESIGN OF SEISMIC AS REQUIRED BY SPECIFICATIONS IS BY OTHERS.
  - SEE 13/M6.03 FOR NON-SEISMIC PIPE SUPPORT.
  - FIRE SEALING OF PIPES MAY NOT BE SHOWN IN ALL LOCATIONS REQUIRED. SEE ARCHITECTURAL DRAWING FOR FIRE RATED WALL.
  - SEE ARCHITECTURAL DRAWINGS FOR ACOUSTICALLY IMPORTANT WALLS (WALL TYPES). SEAL PENETRATIONS IN THOSE WALLS PER DETAIL 10/M6.04

- M3.15 SHEET NOTES:**
- (A) - SEISMIC PIPE SUPPORT. SEE SPECS, TYP.
  - (B) -

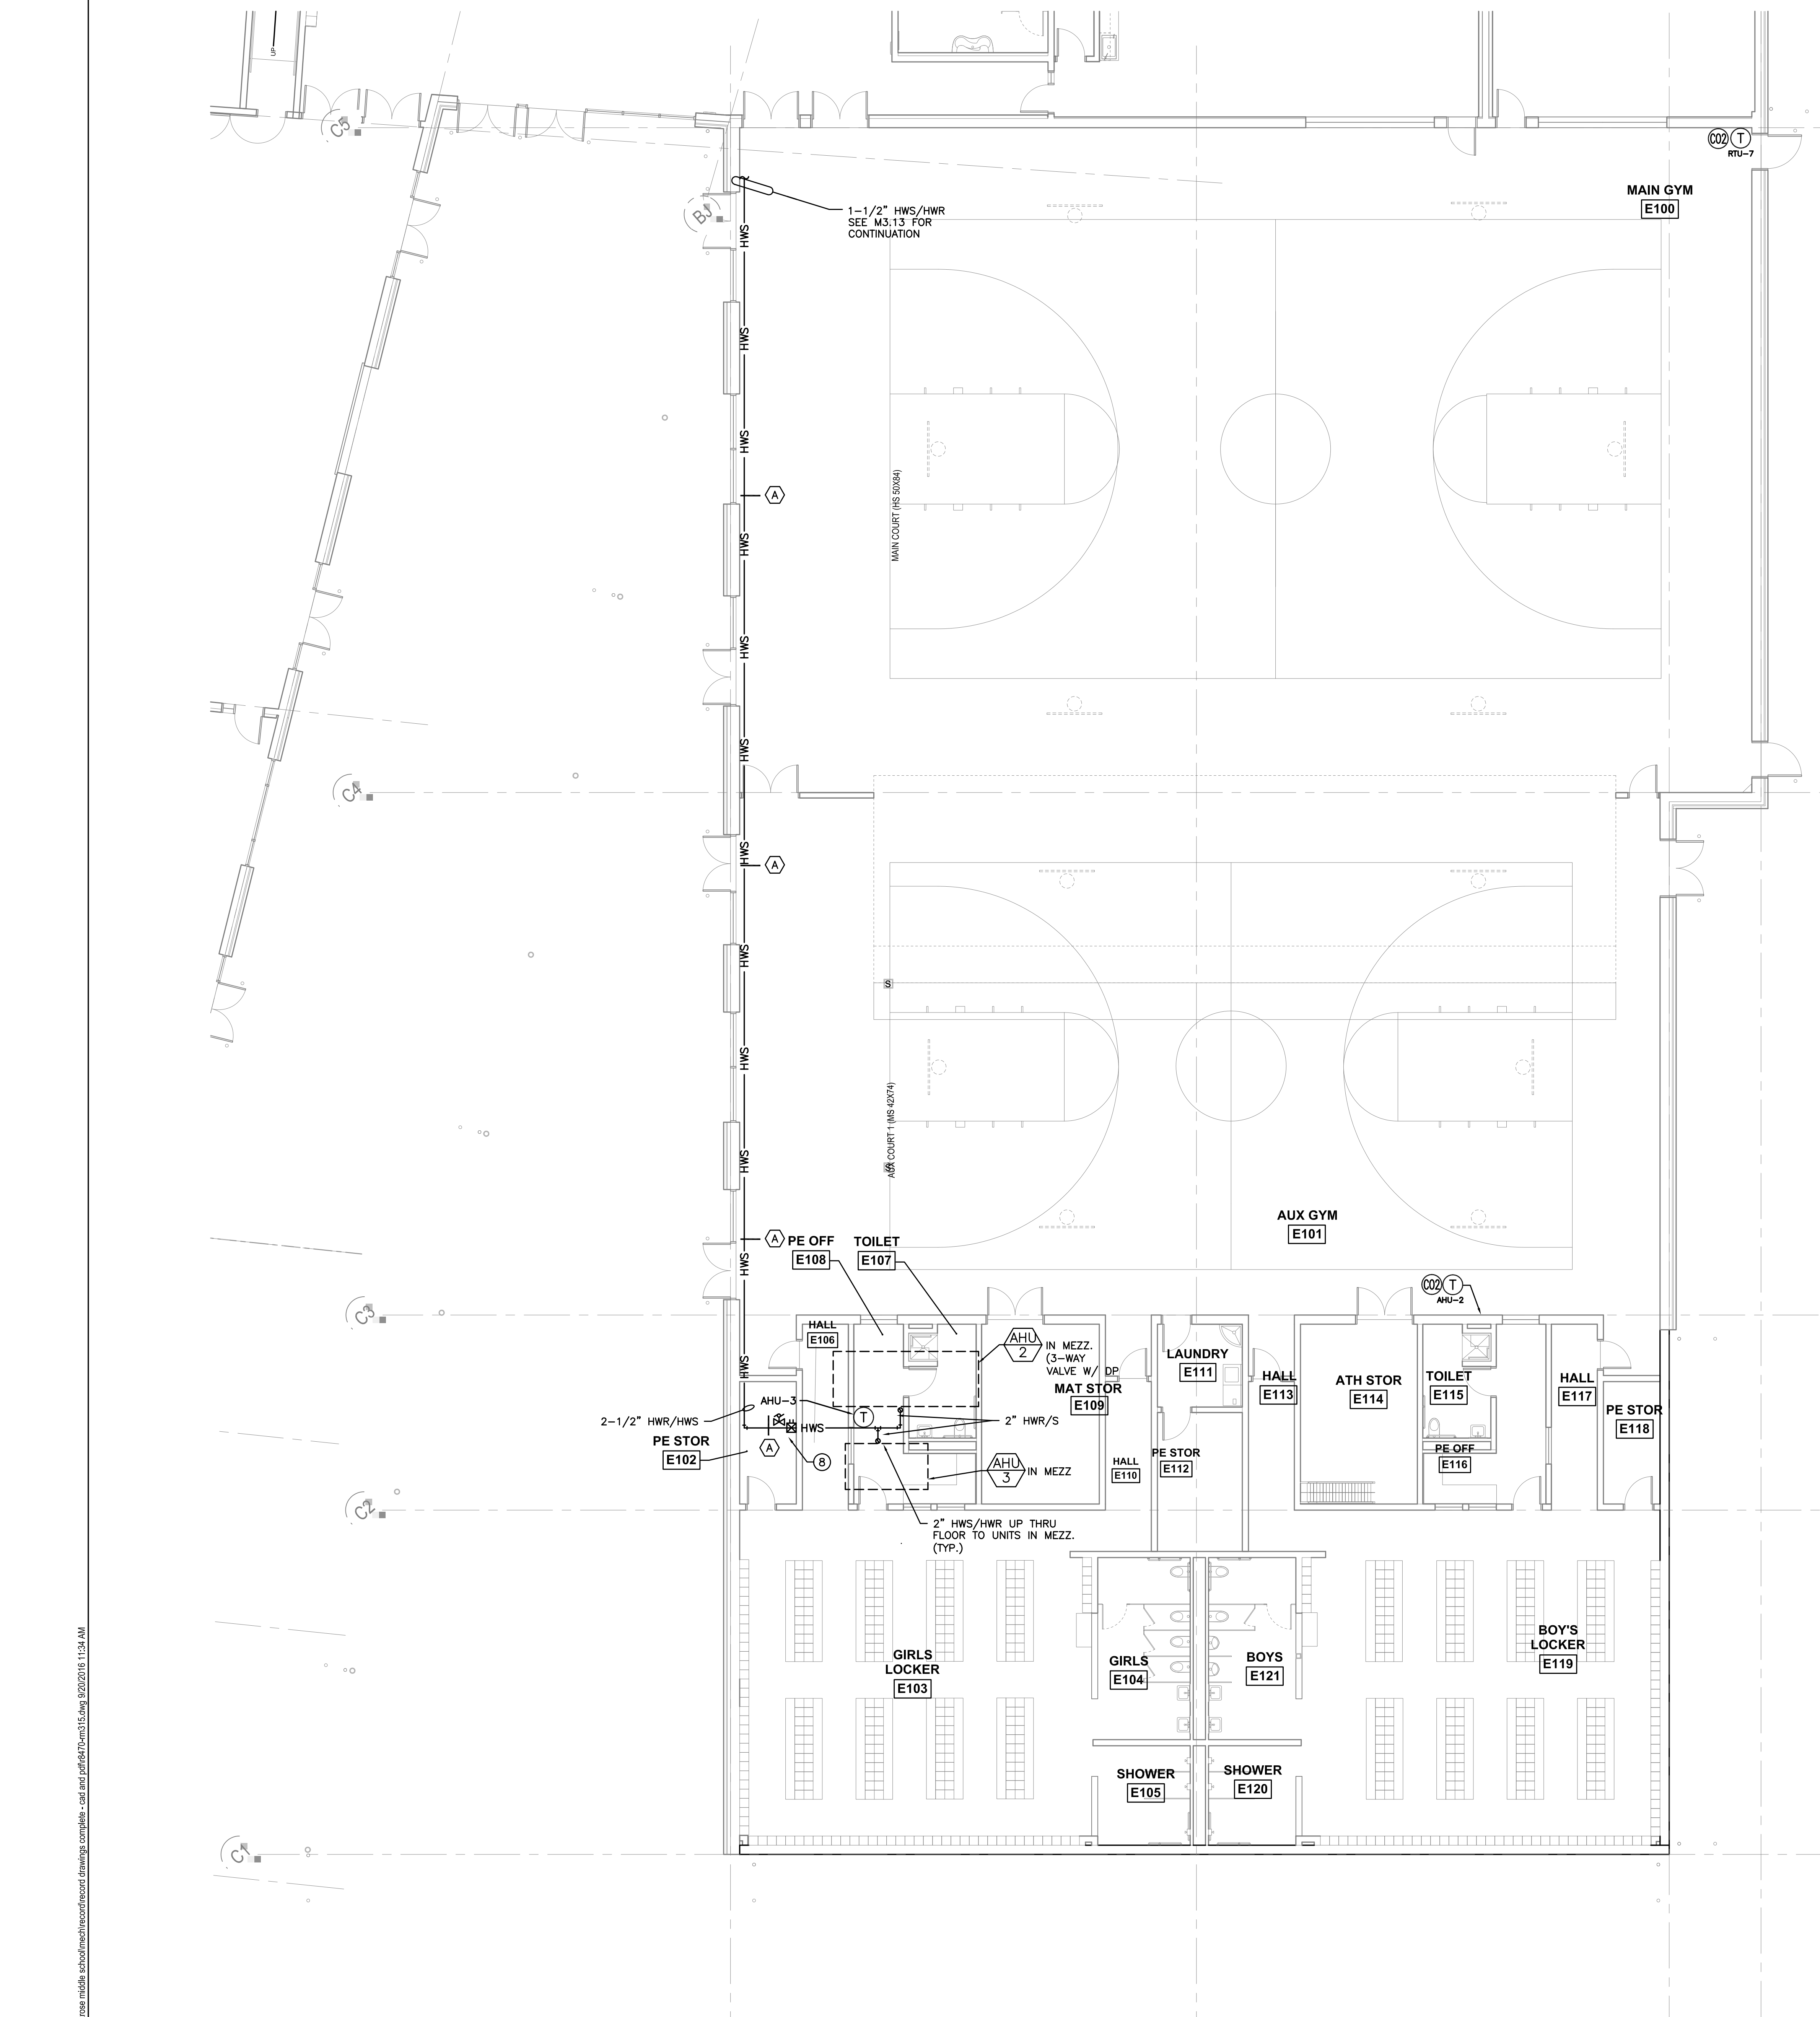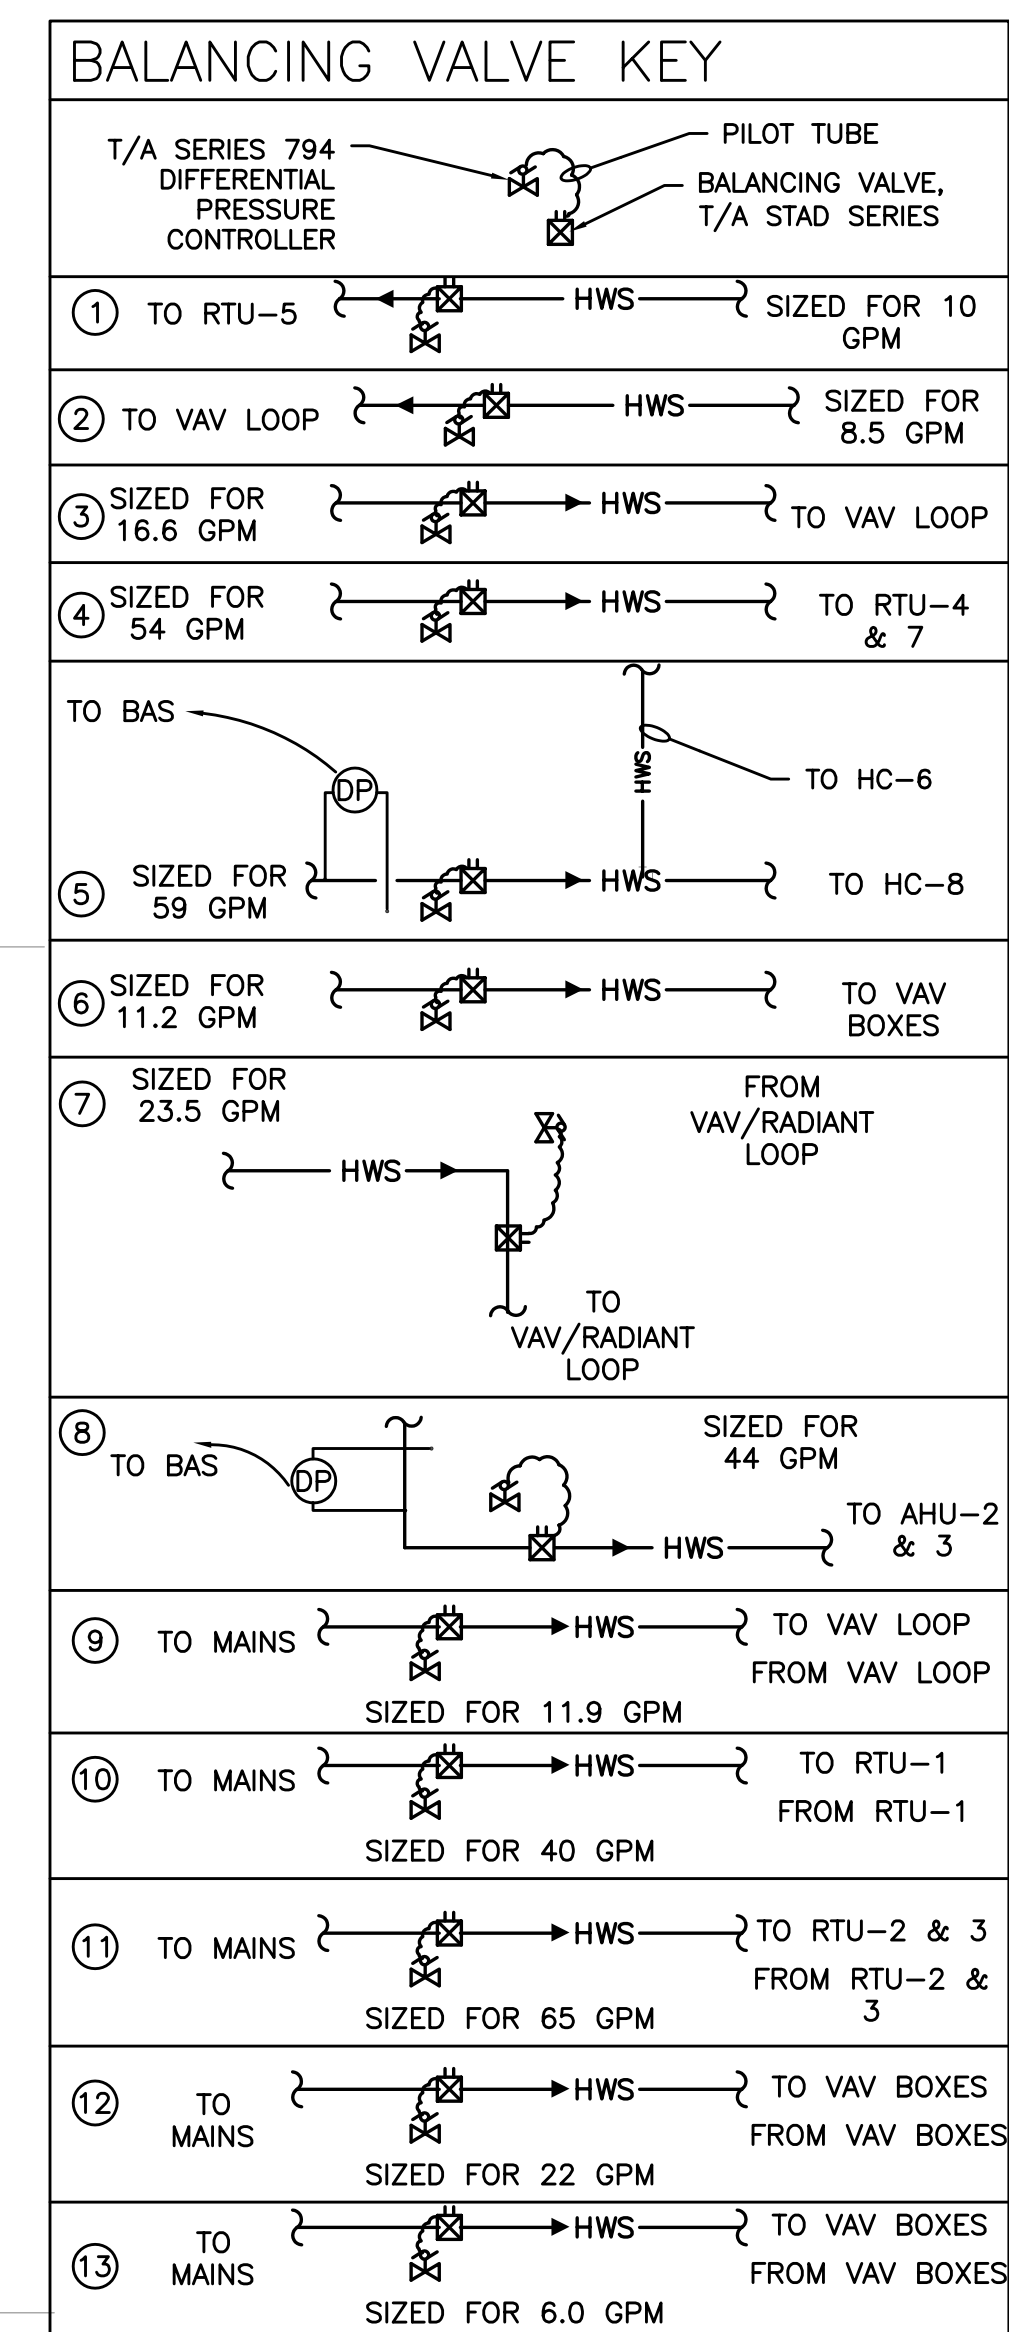

**M3.15** LEVEL 1 SECTOR 'D' MECHANICAL PIPING PLAN  
 SCALE: 1/8"=1'-0"

**RECORD DRAWING:**  
 THIS DRAWING HAS BEEN UPDATED TO REFLECT CHANGES MADE DURING CONSTRUCTION BASED UPON INFORMATION FURNISHED TO THE ENGINEER BY THE INSTALLATION CONTRACTOR. NO WARRANTY, EITHER EXPLICIT OR IMPLIED IS GIVEN BY MFA, INC. AS TO THE ACCURACY AND/OR COMPLETENESS OF THIS INFORMATION.

g:\dowa\architects\6470\_parkrose middle school\mech\record drawings\complete - cad\mep\6470\m3.15.dwg 9/20/2015 11:34 AM