

phase	RECORD DRAWING
date	11/09/2015
revisions	
project #	11082
LEEL 2 SECTOR 'A' MECHANICAL PIPING PLAN	

M3.21, M3.22 SHEET NOTES:



- (A) - FIRE SEAL PENETRATION.
- (B) - HWRR TO FP-1 FROM BELOW.
- (C) - HWRR TO FP-2 FROM BELOW.
- (D) - HWRR TO RU-2 FROM BELOW.
- (E) - HWRR TO RU-3 FROM BELOW.
- (F) - HWRR TO RU-4 FROM BELOW.
- (G) - 1/2" HWS FROM BELOW TO SERVE RADIATOR.

GENERAL NOTES:

- SEE (3) (M6.06) FOR SUPPORT OF FLEX PIPE.
- SEE (9) (M6.06) FOR SEISMIC PIPE SUPPORT. NOTE: SEISMIC SUPPORTS SHOWN ARE BASED ON ANTICIPATED REQUIREMENTS. DESIGN OF SEISMIC AS REQUIRED BY SPECIFICATIONS IS BY OTHERS.
- SEE (13) (M6.03) FOR NON-SEISMIC PIPE SUPPORT.
- FIRE SEALING OF PIPES MAY NOT BE SHOWN IN ALL LOCATIONS REQUIRED. SEE ARCHITECTURAL DRAWING FOR FIRE RATED WALL.
- SEE ARCHITECTURAL DRAWINGS FOR ACOUSTICALLY IMPORTANT WALLS (WALL TYPES). SEAL PENETRATIONS IN THOSE WALLS PER DETAIL 10/M6.04

VAV KEY - LEVEL 2 SECTOR A & B

① - VAV 1.9	② - VAV 1.10	③ - VAV 1.11	④ - VAV 1.12	⑤ - VAV 1.13
⑥ - VAV 1.14	⑦ - VAV 1.15	⑧ - VAV 1.16	⑨ - VAV 1.17	⑩ - VAV 2.9
⑪ - VAV 2.10	⑫ - VAV 2.11	⑬ - VAV 2.12	⑭ - VAV 2.13	⑮ - VAV 2.14
⑯ - VAV 2.15	⑰ - VAV 2.16	⑱ - VAV 2.19	⑲ - VAV 3.1	⑳ - VAV 3.4
㉑ - VAV 3.6				

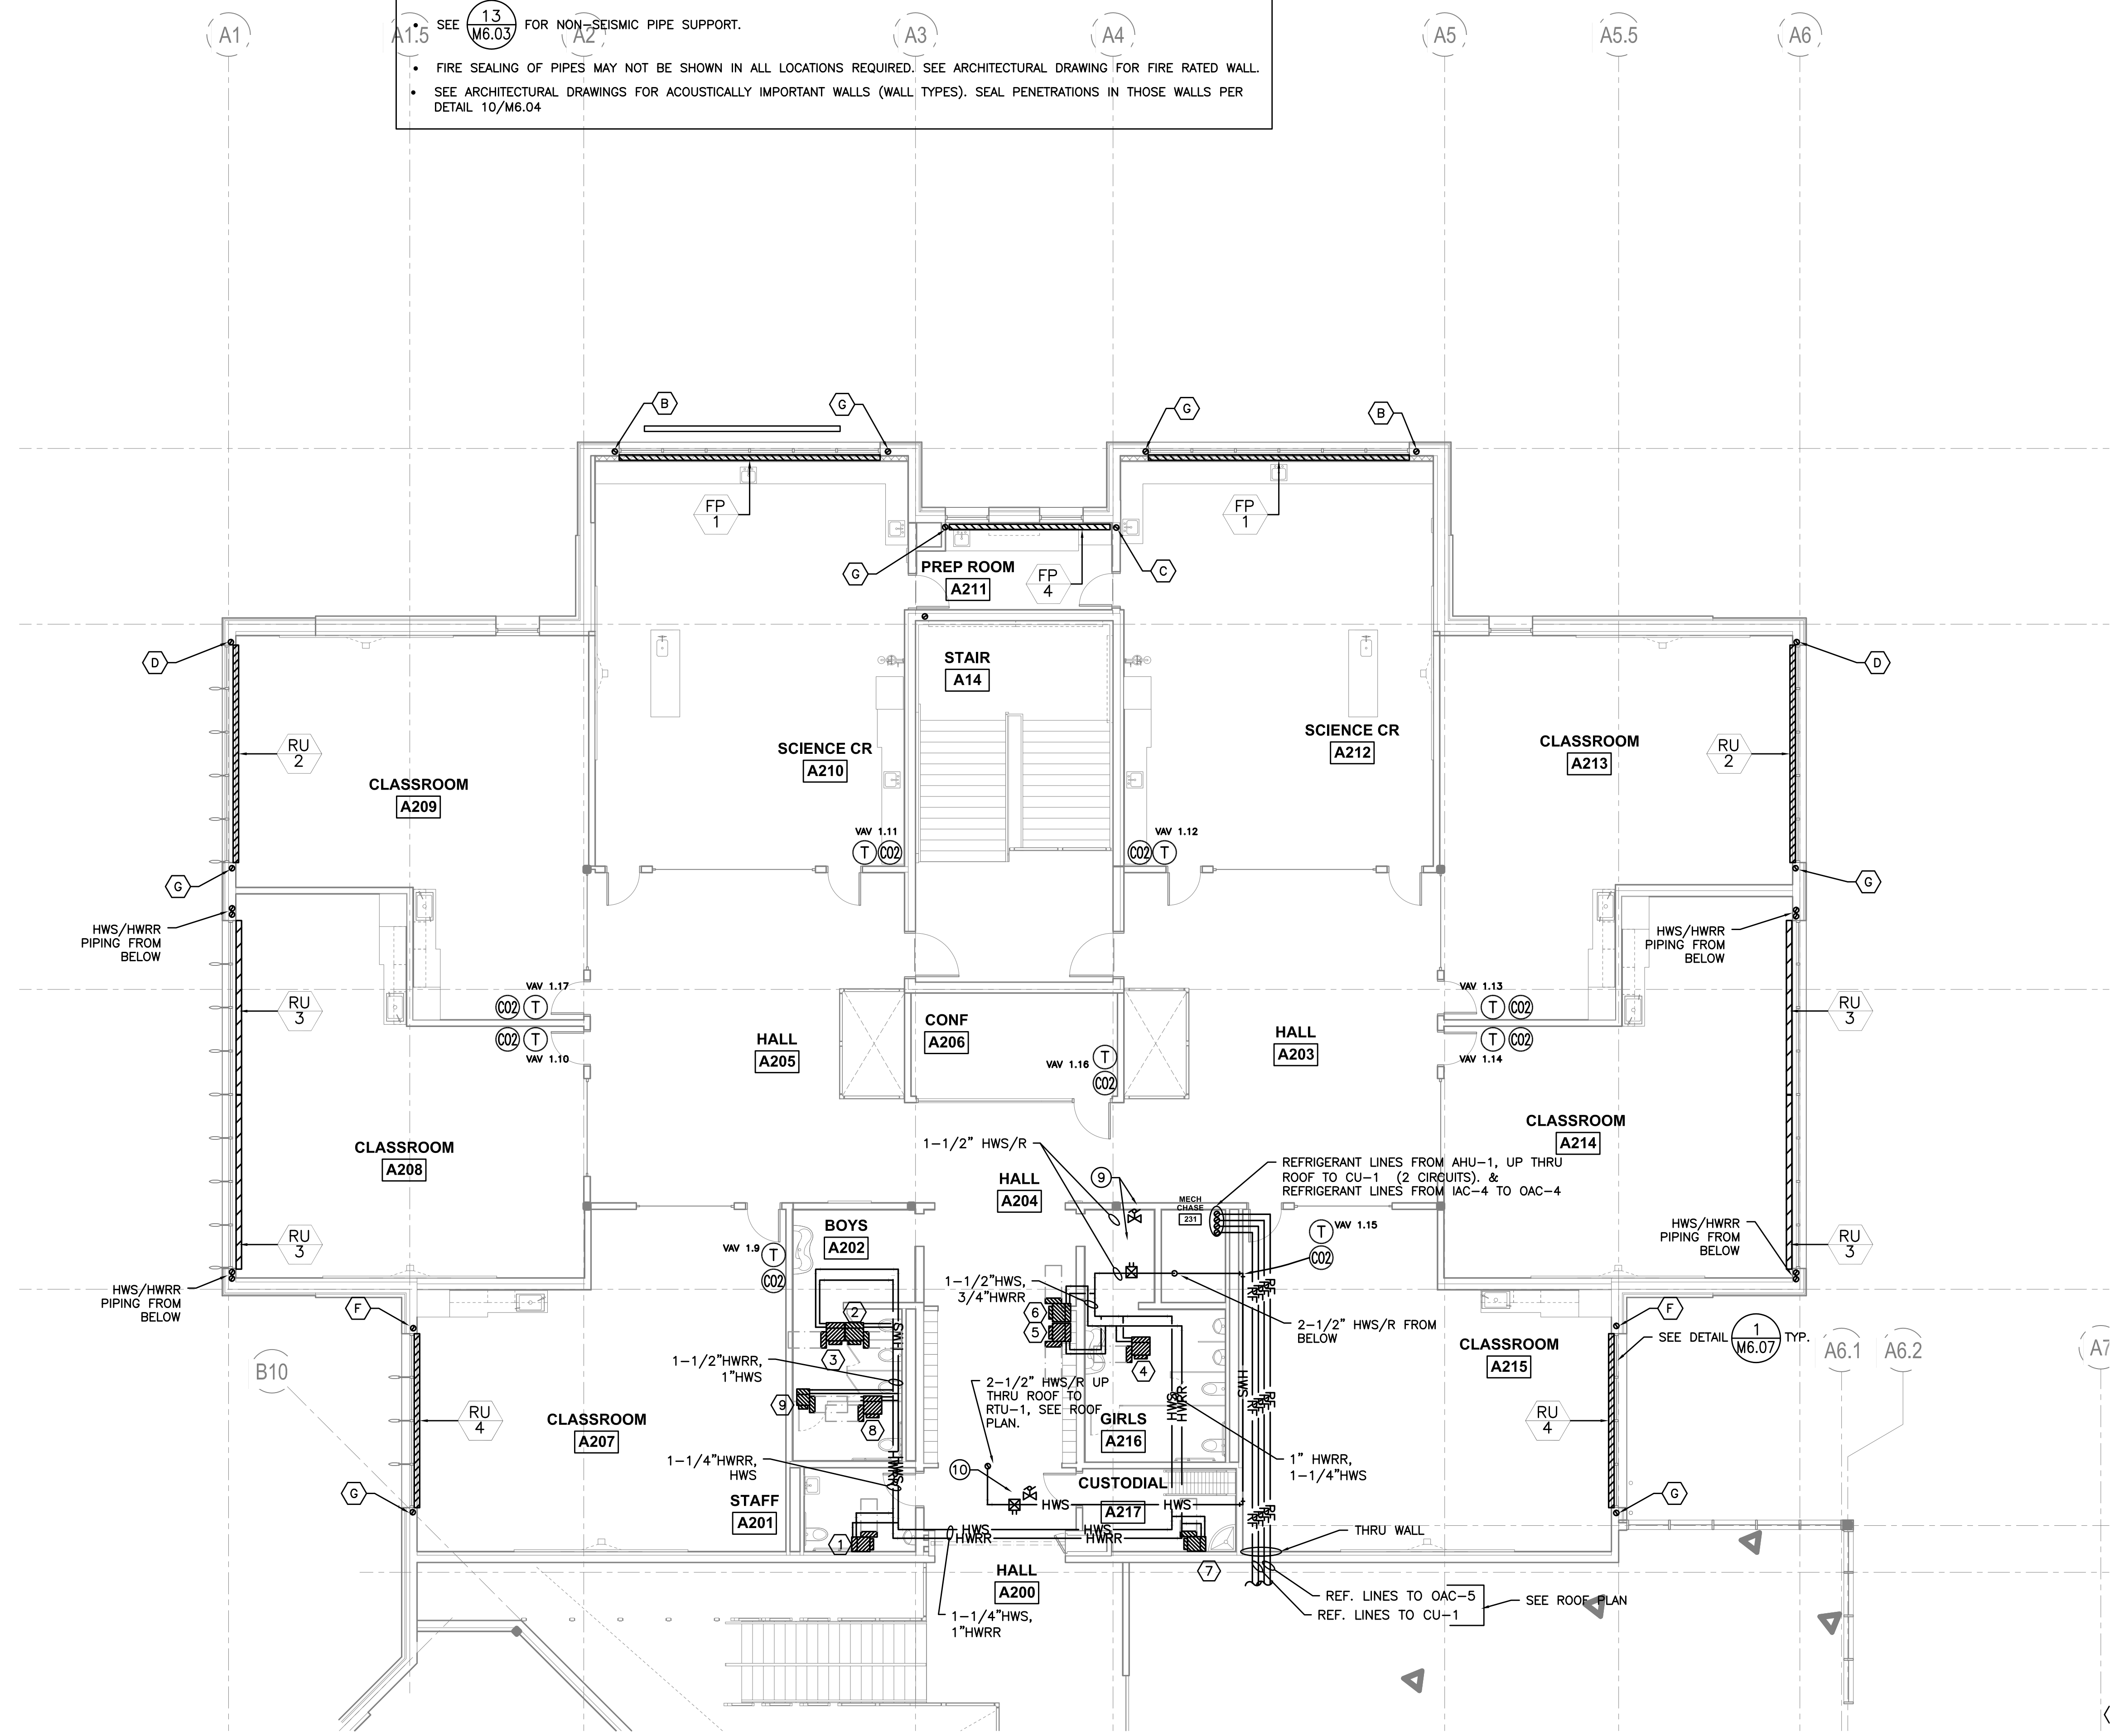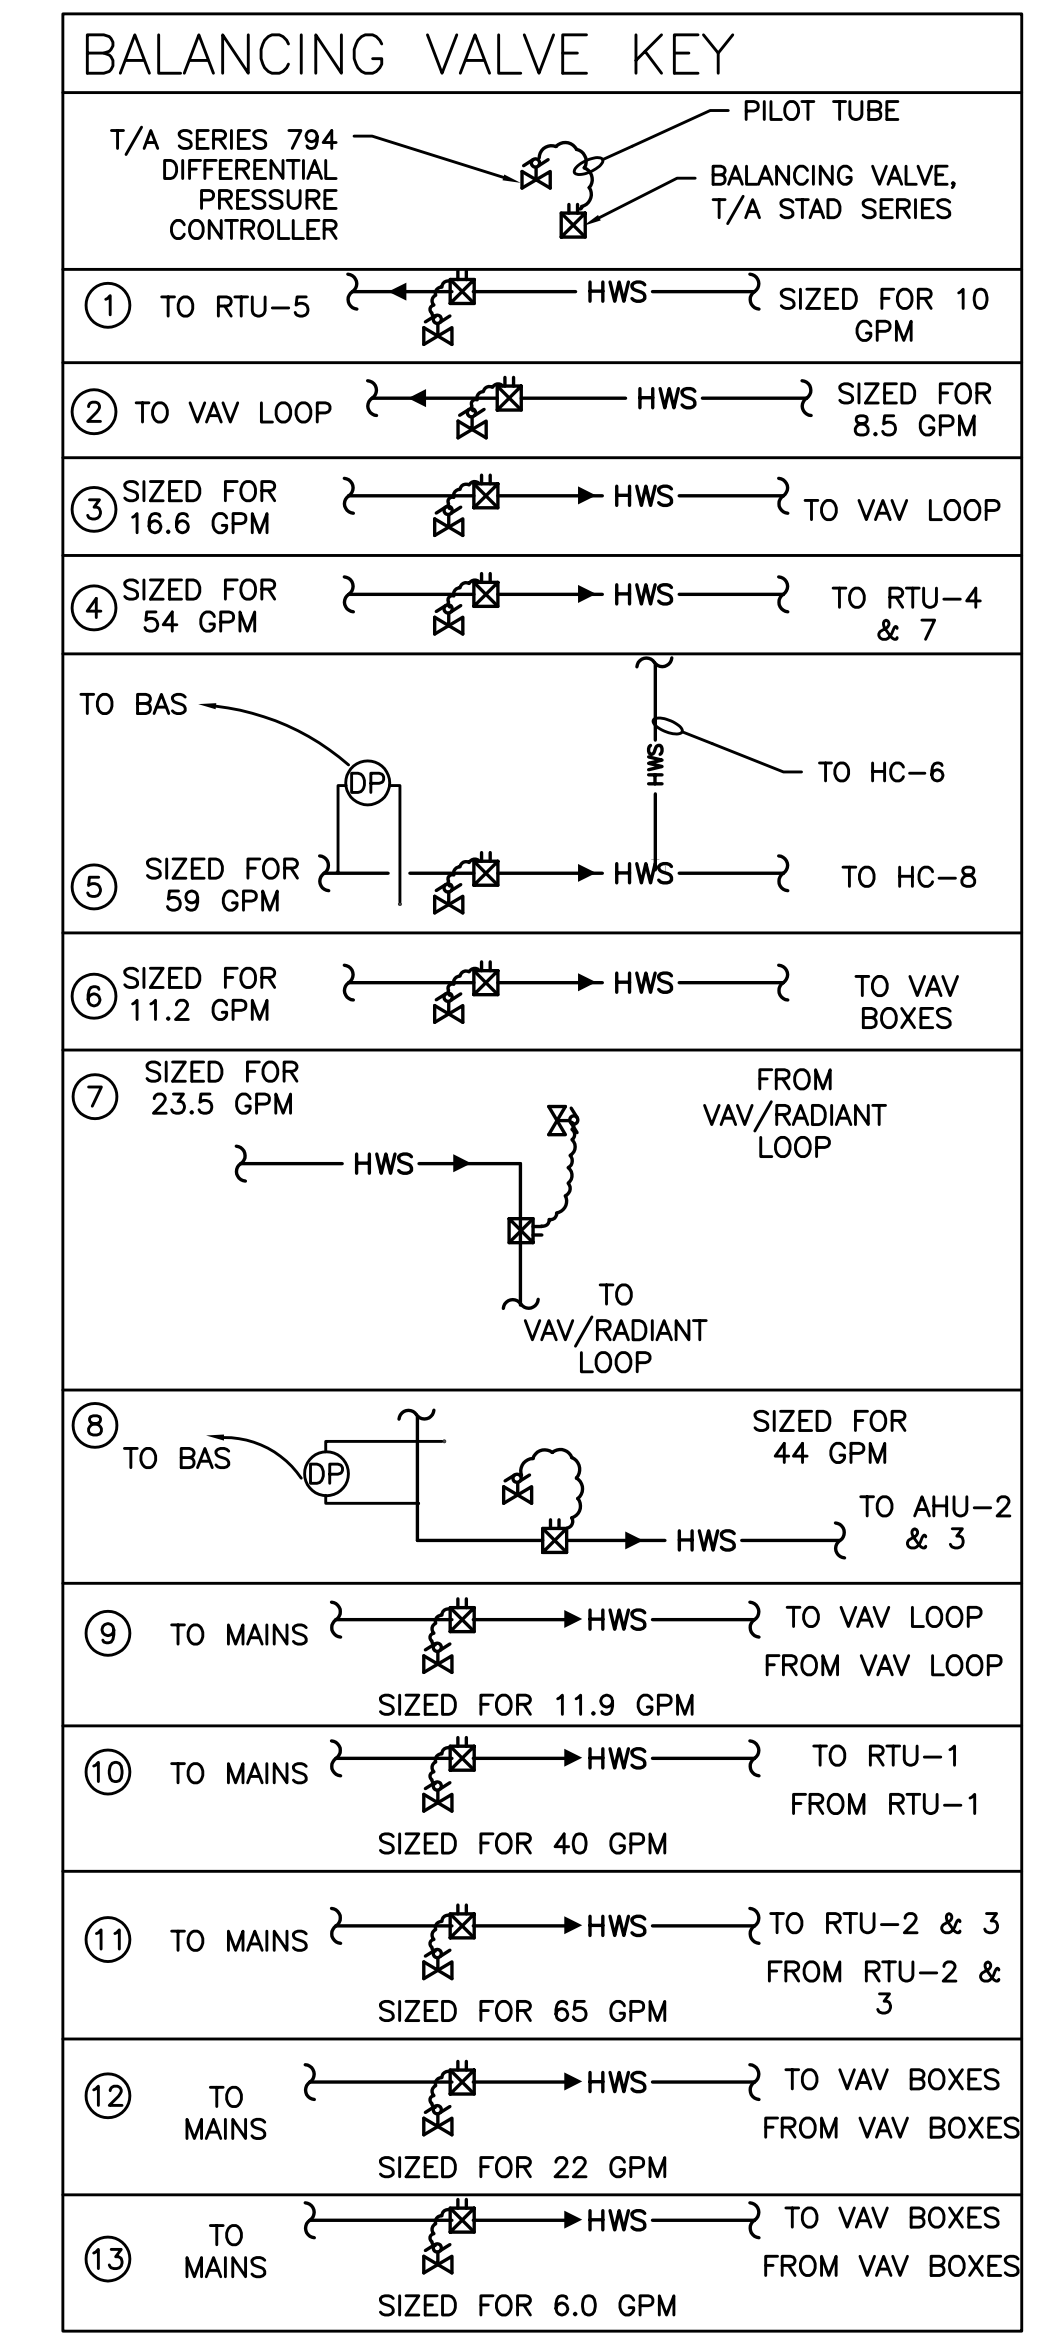

1 LEVEL 2 SECTOR 'A' MECHANICAL PIPING PLAN
 M3.21 SCALE: 1/8"=1'-0"

RECORD DRAWING:
 THIS DRAWING HAS BEEN UPDATED TO REFLECT CHANGES MADE DURING CONSTRUCTION BASED UPON INFORMATION FURNISHED TO THE ENGINEER BY THE INSTALLATION CONTRACTOR. NO WARRANTY, EITHER EXPLICIT OR IMPLIED IS GIVEN BY MFA, INC. AS TO THE ACCURACY AND/OR COMPLETENESS OF THIS INFORMATION.

g:\dowa\architects\6470_parkrose middle school\mech\record drawings\complete - call area.pdf(6470-m321_m322.dwg 3/20/2016 11:42 AM)