



GENERAL NOTES

1. (E) BUILDING PAD IS CONCRETE TREATED. PROVIDE MATERIALS & LABOR AS REQ'D TO REMOVE CONCRETE TREATED PAD FOR UNDERFLOOR WORK

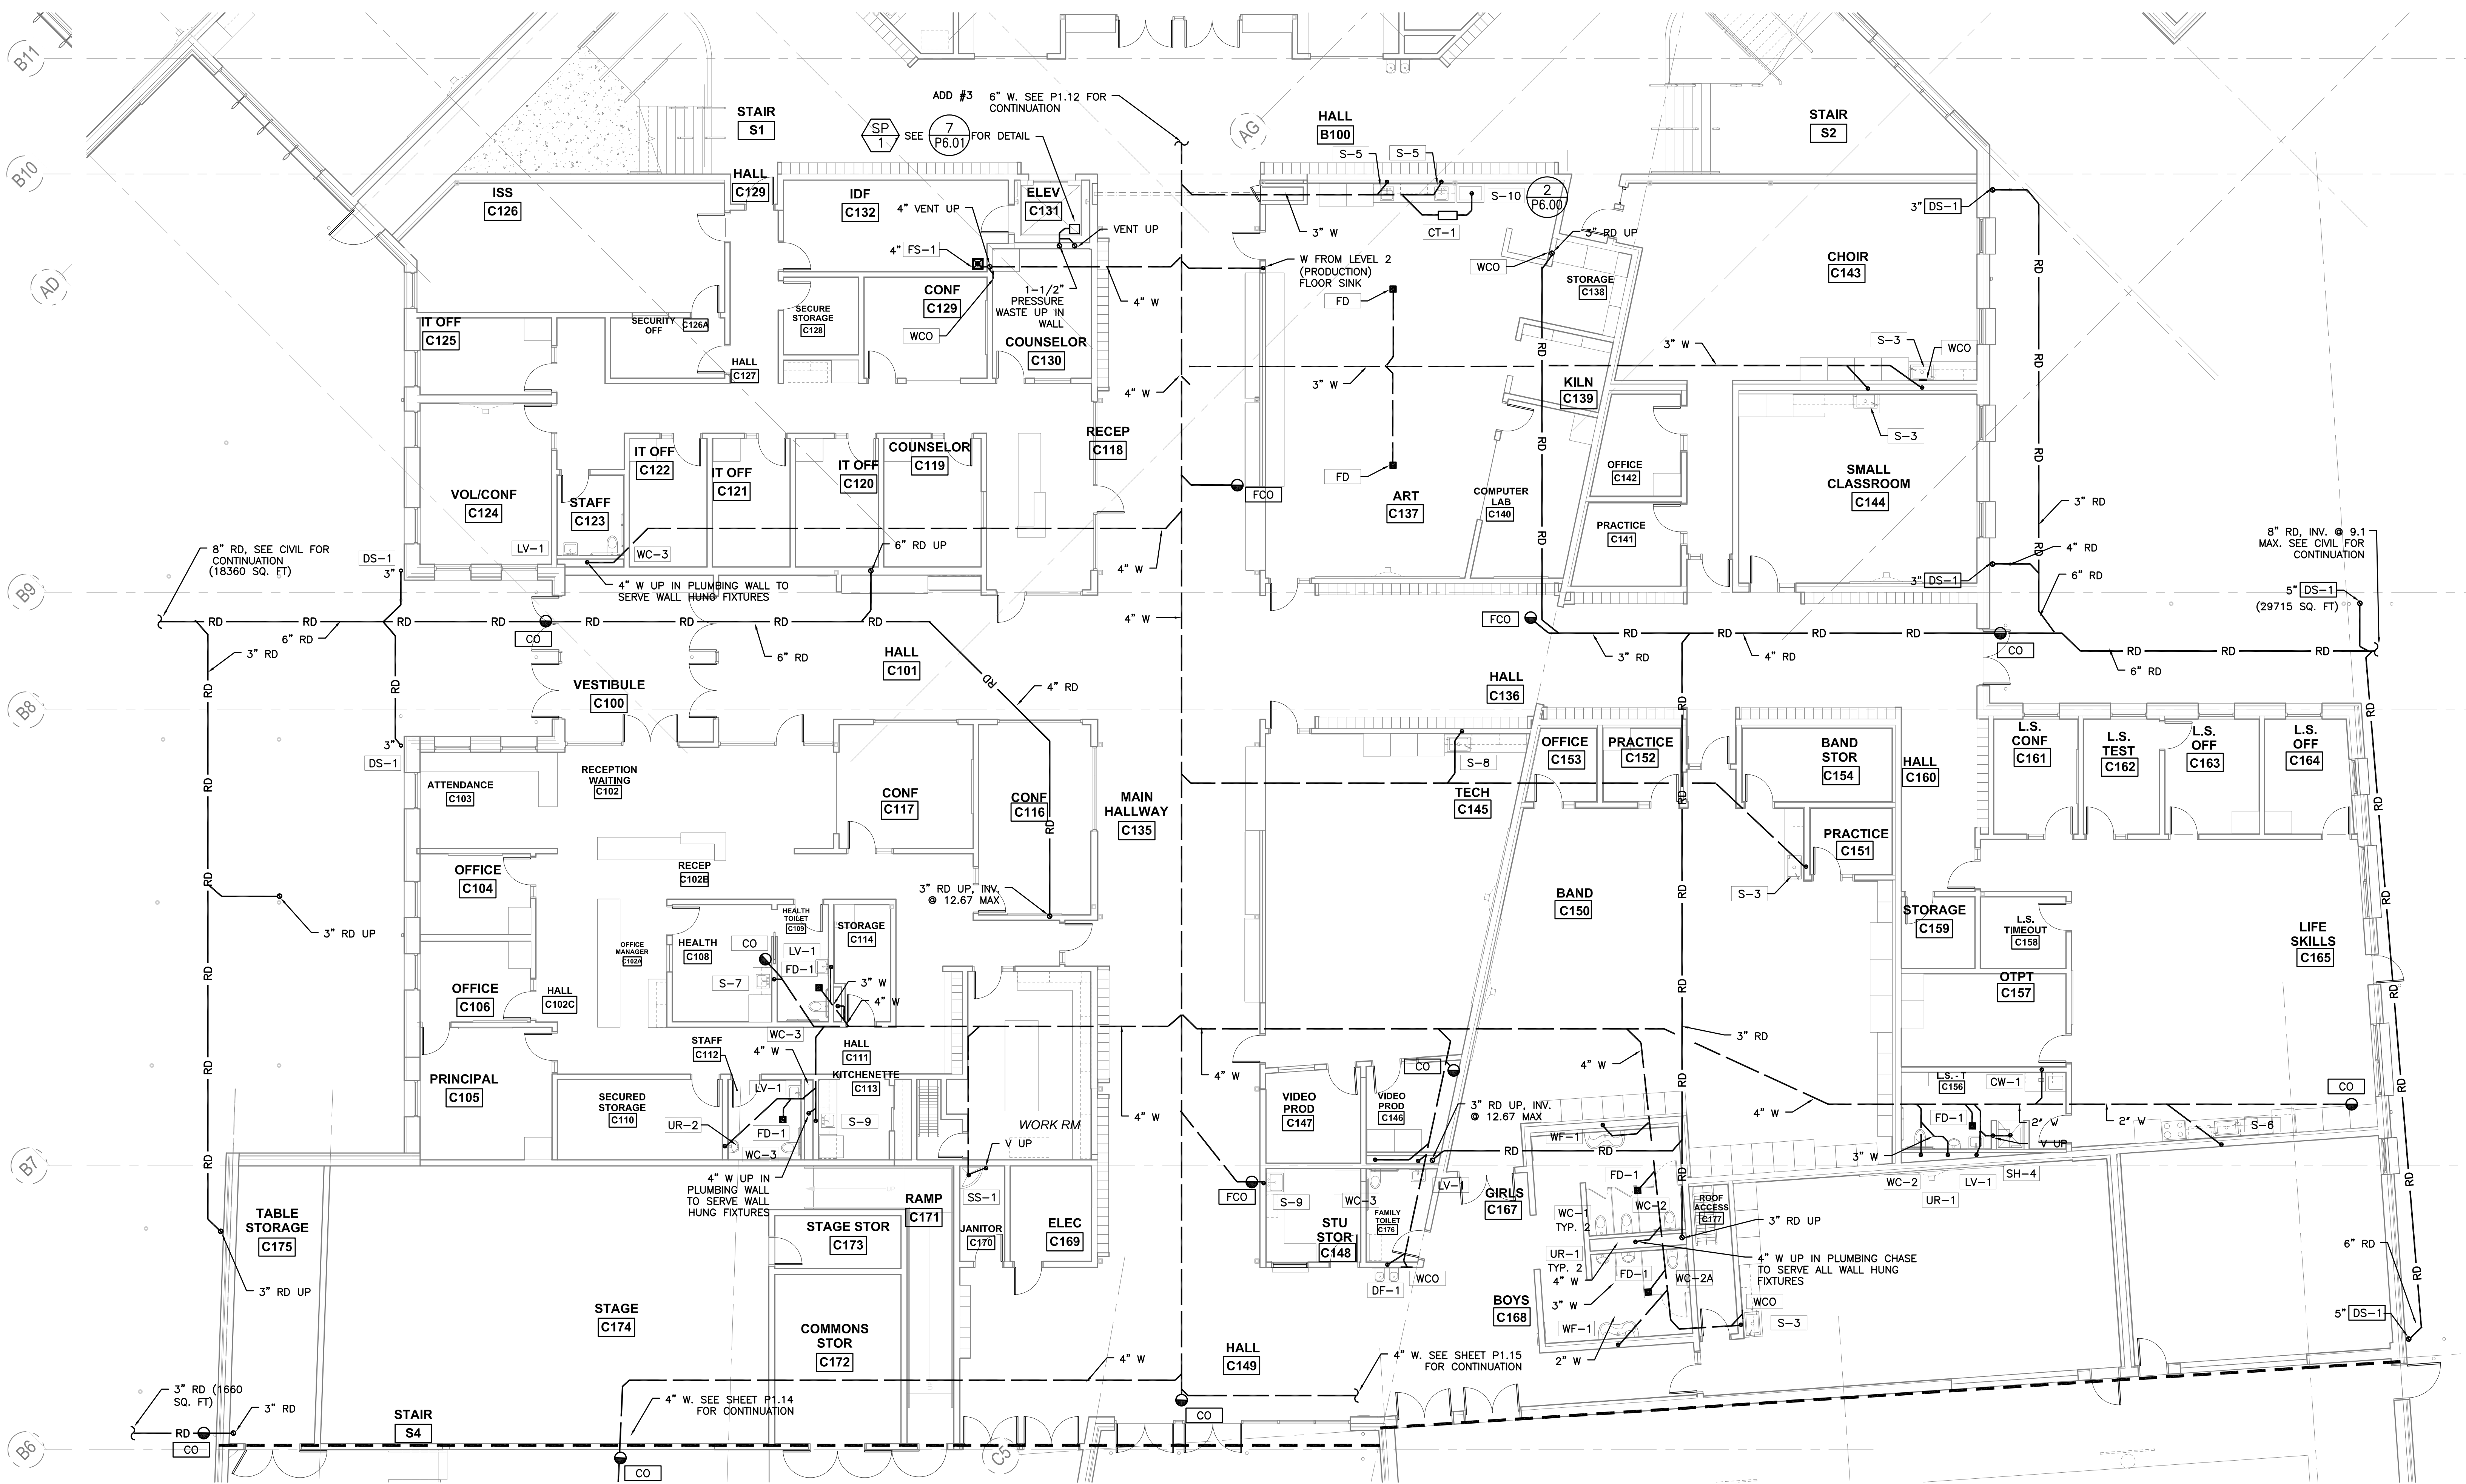

1 LEVEL 1 SECTOR 'C' UNDERSLAB PLUMBING PLAN
 SCALE: 1/8"=1'-0"

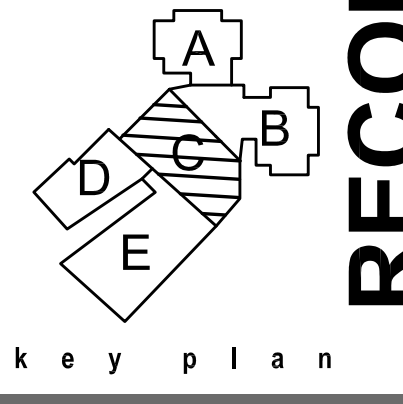

| | |
|---|----------------|
| phase | RECORD DRAWING |
| date | 11/09/2015 |
| revisions | |
| project # | 11082 |
| LEVEL 1 SECTOR 'C' UNDERSLAB PLUMB PLAN | |

RECORD DRAWING:
 THIS DRAWING HAS BEEN UPDATED TO REFLECT CHANGES MADE DURING CONSTRUCTION BASED UPON INFORMATION FURNISHED TO THE ENGINEER BY THE INSTALLATION CONTRACTOR. NO WARRANTY, EITHER EXPLICIT OR IMPLIED IS GIVEN BY MFA, INC. AS TO THE ACCURACY AND/OR COMPLETENESS OF THIS INFORMATION.

P1.13

g:\dowa\architects\6470_parkrose_midschool\mefirecord\record\drawings\complete_cad\ans\pdr6470sp113_rpt14.dwg, 10/20/16, 2:27 PM