


1 LEVEL 1 SECTOR 'E' PLUMBING PLAN
 P2.15 SCALE: 1/8"=1'-0"

P2.15 SHEET NOTES


(A) 2" CW DN IN HEADER SPACE TO SERVE: 6 WATER CLOSETS, 2 URINALS, 2 HB, & 4 LAVS
 (B) 1-1/4" CW/HW DN IN HEADER SPACE TO SERVE 6 SHOWERS & HB
 (C) 4" W FROM BELOW. ROUTE IN HEADER TO FIXTURES
 (D) VENT FROM BELOW

GENERAL NOTES

- SEE DETAIL 11/P6.01 FOR ACOUSTIC PENETRATION DETAIL. SEAL ALL PENETRATIONS OF ACOUSTICALLY IMPORTANT WALLS
 - SEE DETAIL 3/P6.00 FOR NON-SEISMIC DUCT SUPPORT
 - SEE DETAIL 3/P6.01 FOR SEISMIC DUCT SUPPORT (SEE SPECS FOR DESIGN REQUIREMENT)

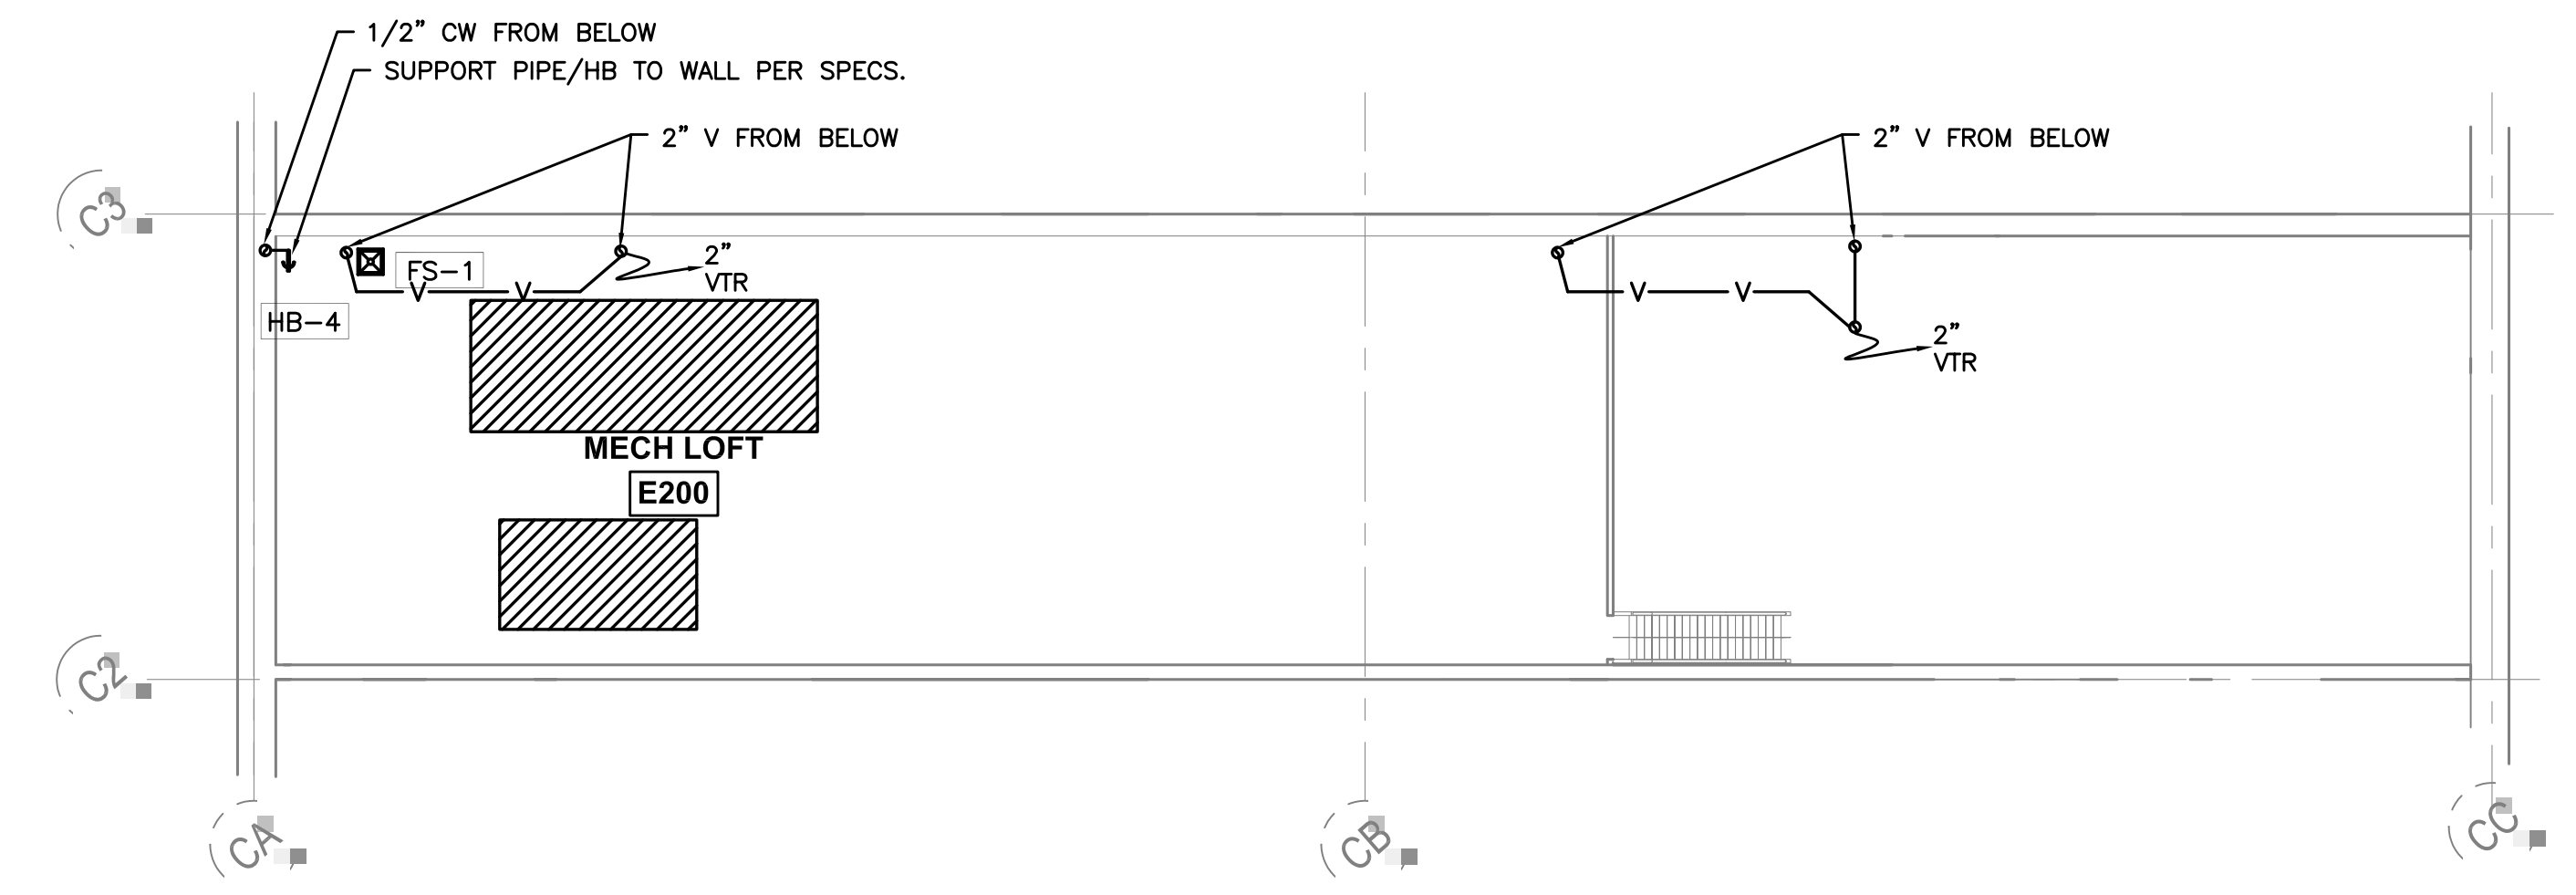

2 LEVEL 1 SECTOR 'E' MECH. LOFT PLUMBING PLAN
 P2.15 SCALE: 1/8"=1'-0"

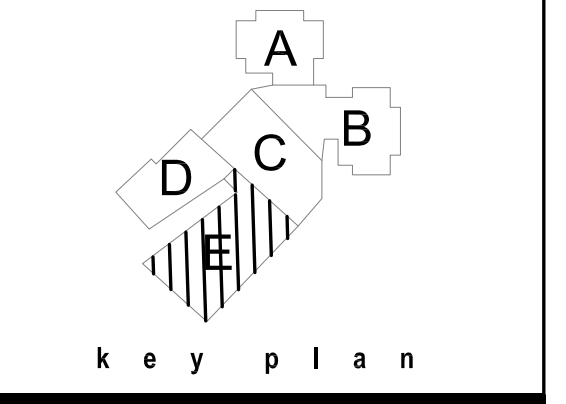

phase	RECORD DRAWING
date	11/09/2015
revisions	
project #	11082

LEVEL 1 SECTOR 'E'
 MECH. LOFT PLUMB. PLAN

P2.15

RECORD DRAWING:
 THIS DRAWING HAS BEEN UPDATED TO REFLECT CHANGES MADE DURING CONSTRUCTION BASED UPON INFORMATION FURNISHED TO THE ENGINEER BY THE INSTALLATION CONTRACTOR. NO WARRANTY, EITHER EXPLICIT OR IMPLIED IS GIVEN BY MFA, INC. AS TO THE ACCURACY AND/OR COMPLETENESS OF THIS INFORMATION.

g:\dowa_architects\6470_parkrose_middle_school\mech\record\drawings\complete_cad\area\pdr\6470\p215.dwg 10/4/2015 8:29 AM