


phase	RECORD DRAWING
date	11/09/2015
revisions	
project #	11082

LEVEL 0 & 1
 FIRE PROTECTION PLANS

P4.10

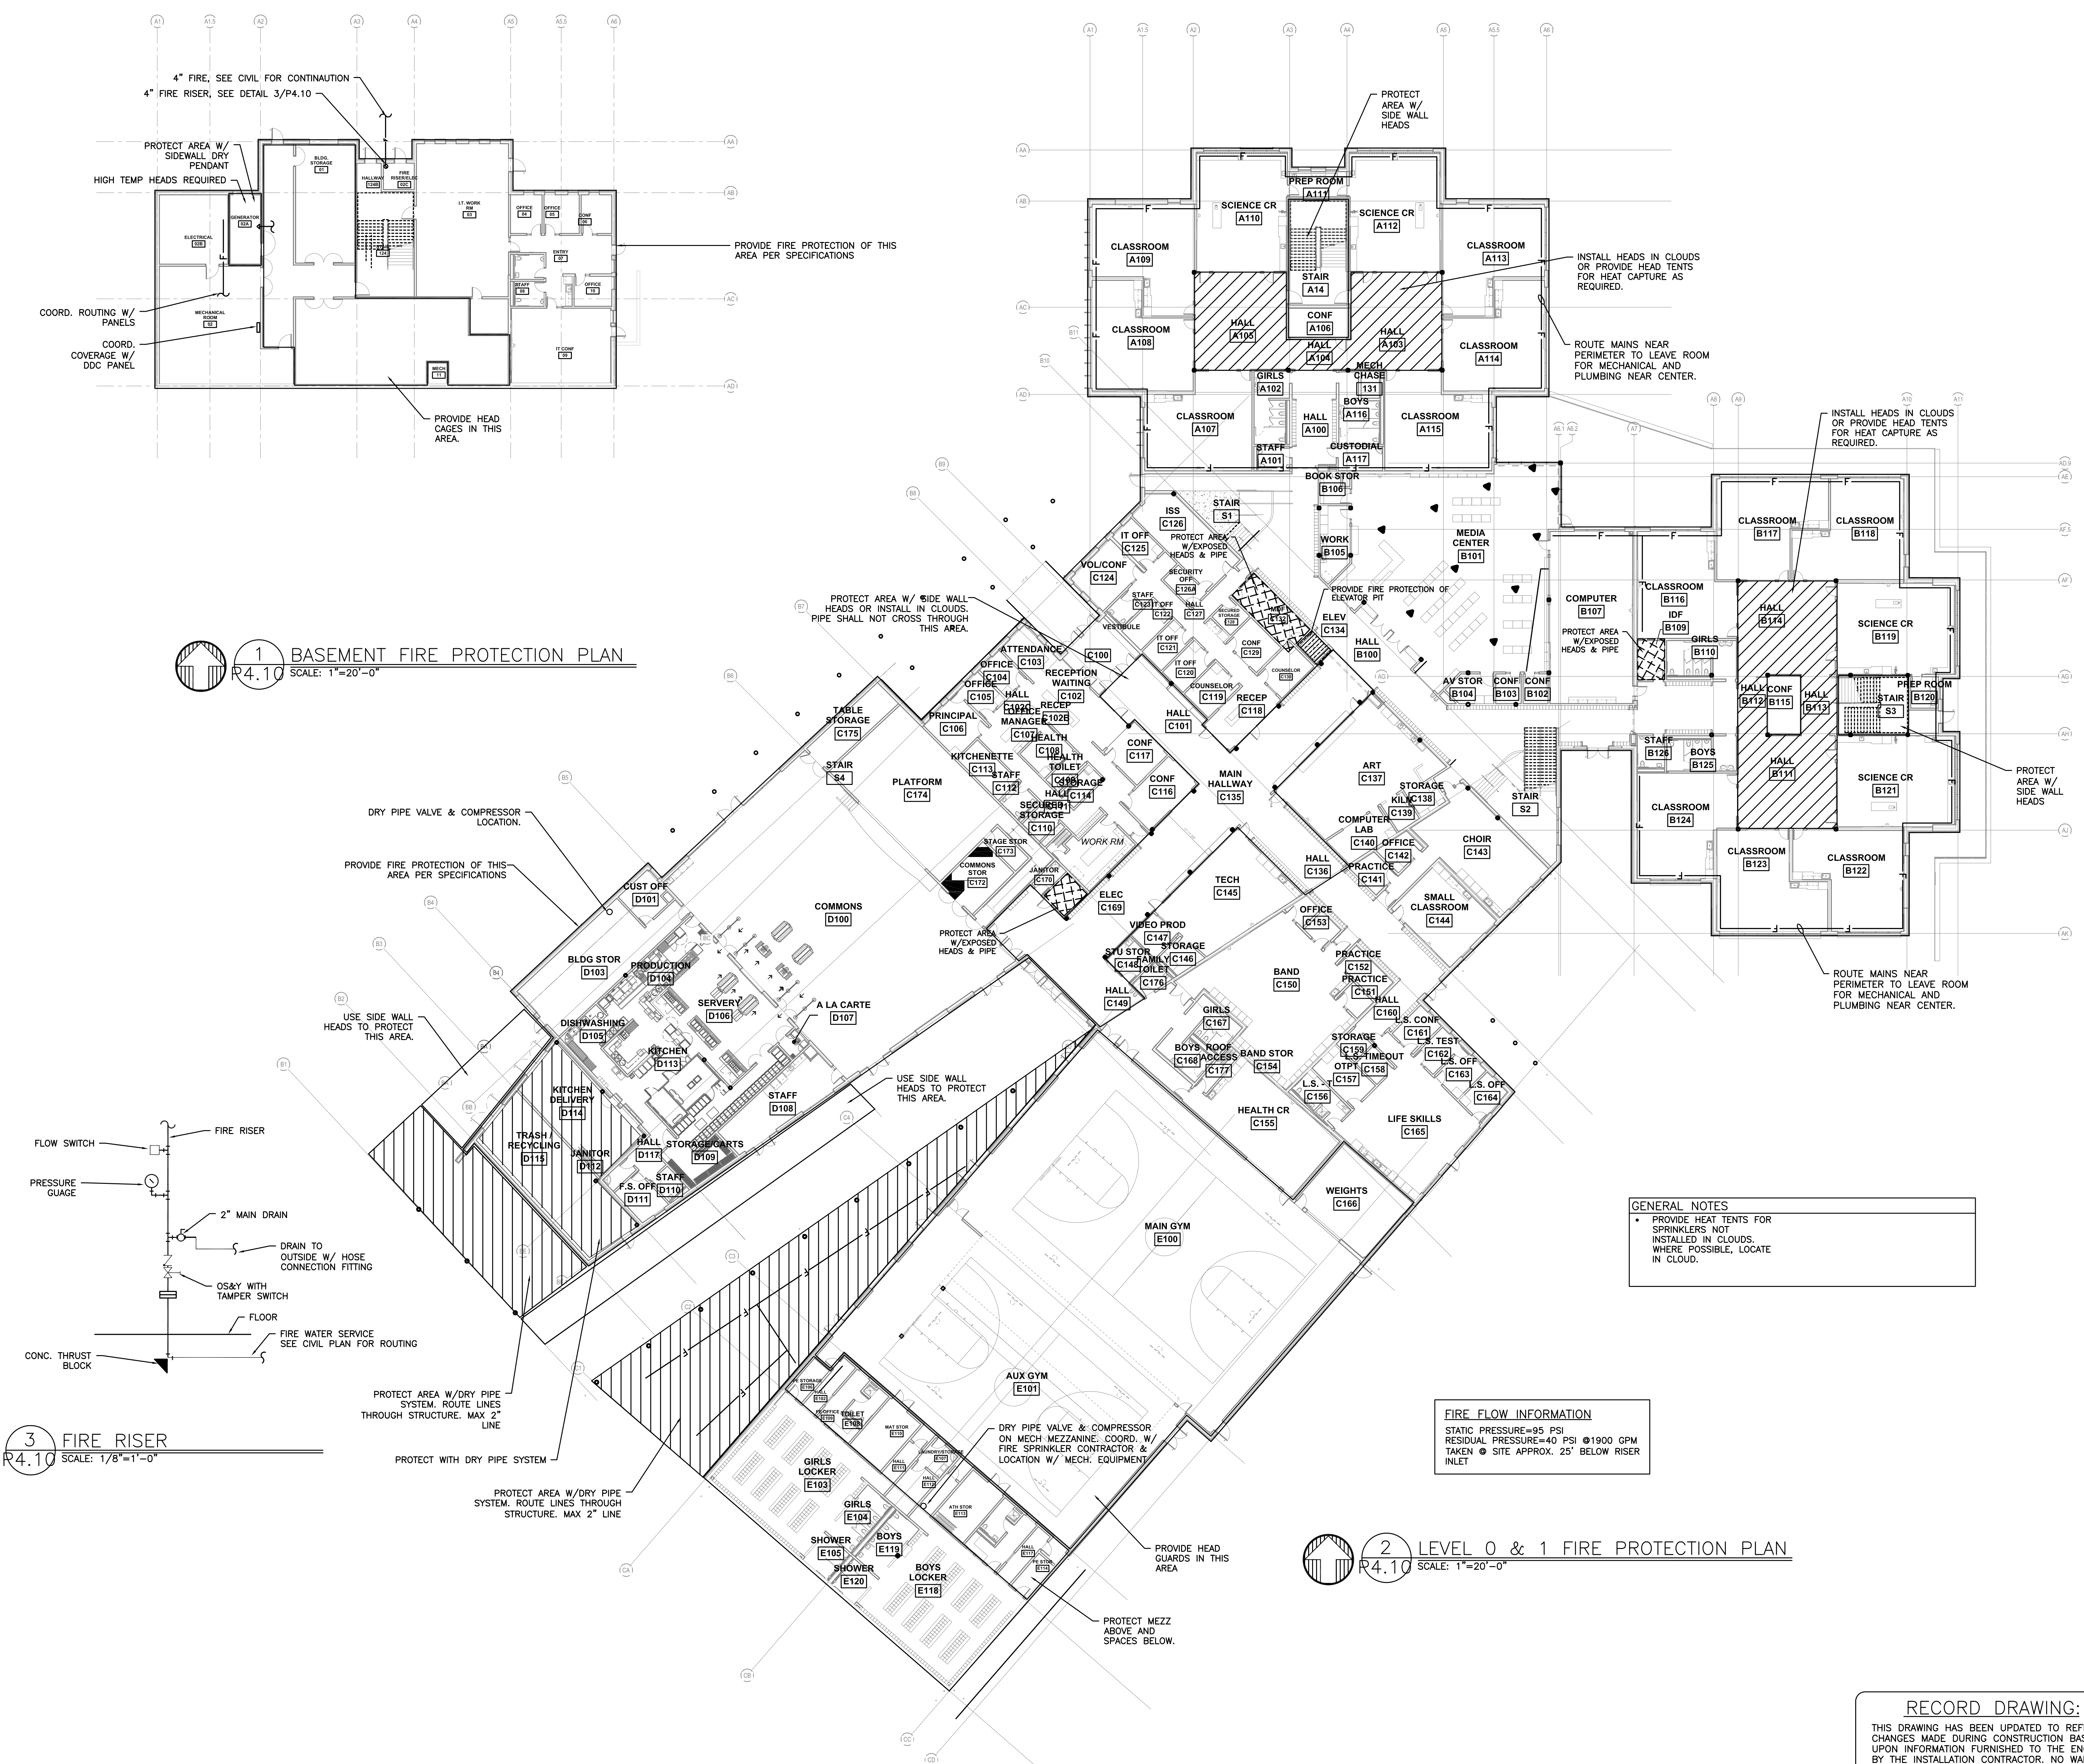

1 BASEMENT FIRE PROTECTION PLAN
 SCALE: 1"=20'-0"

2 LEVEL 0 & 1 FIRE PROTECTION PLAN
 SCALE: 1"=20'-0"

3 FIRE RISER
 SCALE: 1/8"=1'-0"

GENERAL NOTES

- PROVIDE HEAT TENTS FOR SPRINKLERS NOT INSTALLED IN CLOUDS. WHERE POSSIBLE, LOCATE IN CLOUD.

FIRE FLOW INFORMATION
 STATIC PRESSURE=95 PSI
 RESIDUAL PRESSURE=40 PSI @ 1900 GPM
 TAKEN @ SITE APPROX. 25' BELOW RISER INLET

RECORD DRAWING:
 THIS DRAWING HAS BEEN UPDATED TO REFLECT CHANGES MADE DURING CONSTRUCTION BASED UPON INFORMATION FURNISHED TO THE ENGINEER BY THE INSTALLATION CONTRACTOR. NO WARRANTY, EITHER EXPLICIT OR IMPLIED IS GIVEN BY MFA, INC. AS TO THE ACCURACY AND/OR COMPLETENESS OF THIS INFORMATION.

G:\dowa\architects\6470_parkrose middle school\mefire\record drawings\complete - call area.pdf\6470-p4.10_p4.11.dwg, 10/4/2016 9:37 AM