

1
M6.2
BOILER ROOM I
1/4"=1'-0"

1/4"=1'-0"

BY: ARJ	CHK'D: SWM	DATE: 3.03.05
NO	REVISION	DATE
3-3	REVISION	3.03.05
△		
△		
△		



ROSEBURG H.S.

NEW MAIN BUILDING
BOILER ROOM MECHANICAL PLAN

MFIA INC.

2007 S.E. ASH ST.
PORTLAND OR. 97214 ph. 503-234-0548

JOB NO.
SHEET NO.
REV-REF: M6.2α

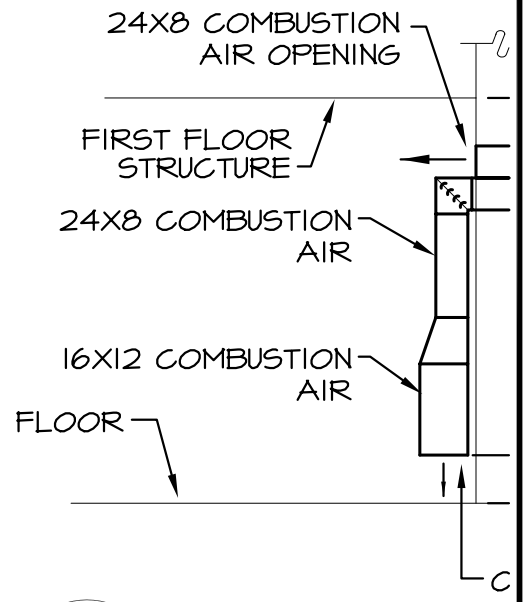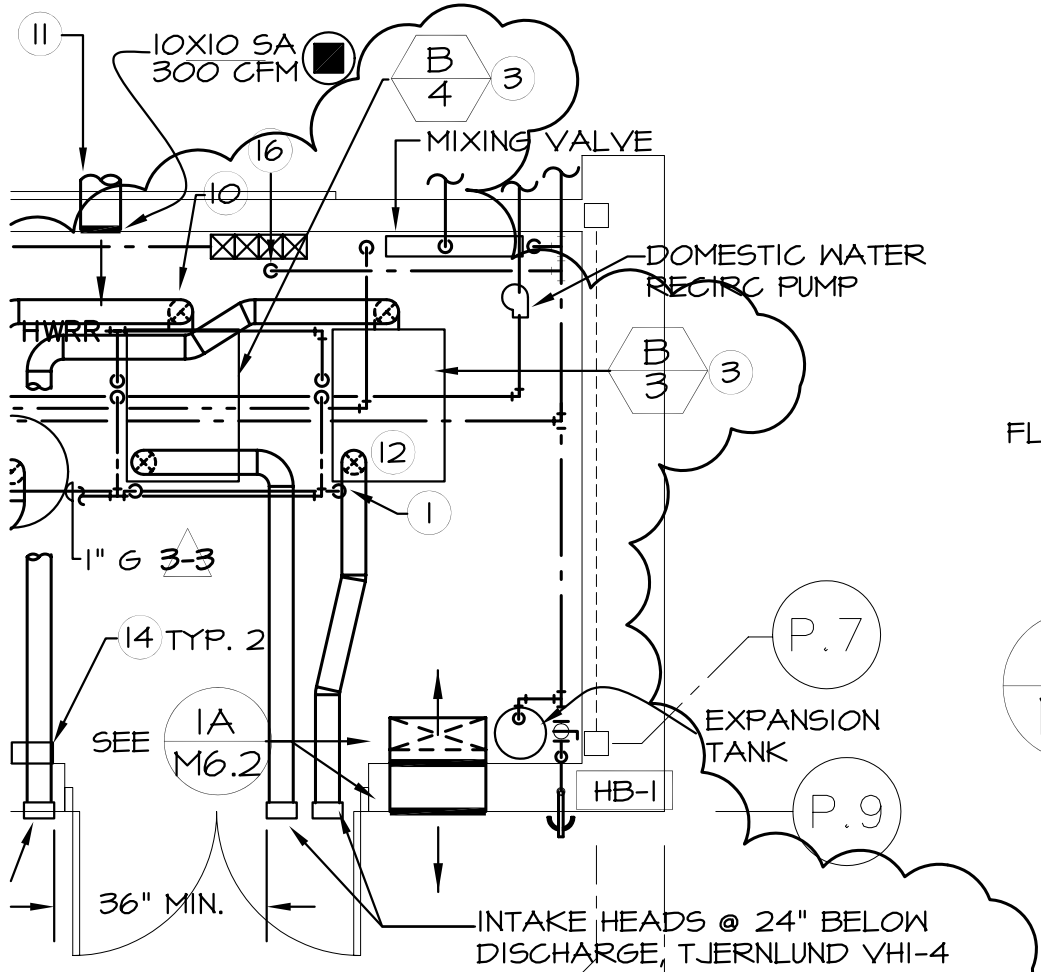

IA COMBUSTIC
M6.2 DETAIL

DISCHARGE JUST BELOW CEILING LINE. DISCHARGE VIA TJERNLUND 4" SIDEWALL HEAD (MODEL VHI-4)

SLE STAGE COOLING
LY STAT; ACTIVATE
↓ WHEN ROOM
ACHES 80°F OR ABOVE
RELIEF GRILLE W/
KDRAFT DAMPER

D108

1/4"=1'-0"

BY: ARJ	CHK'D: SWM	DATE: 3.03.05
NO	REVISION	DATE
3-3	REVISION	3.03.05
△		
△		
△		

ROSEBURG H.S.
NEW MAIN BUILDING
BOILER ROOM MECHANICAL PLAN

MFIA INC.
2007 S.E. ASH ST.
PORTLAND OR. 97214 ph. 503-234-0548

JOB NO.
SHEET NO.
REV-REF:M6.2b