
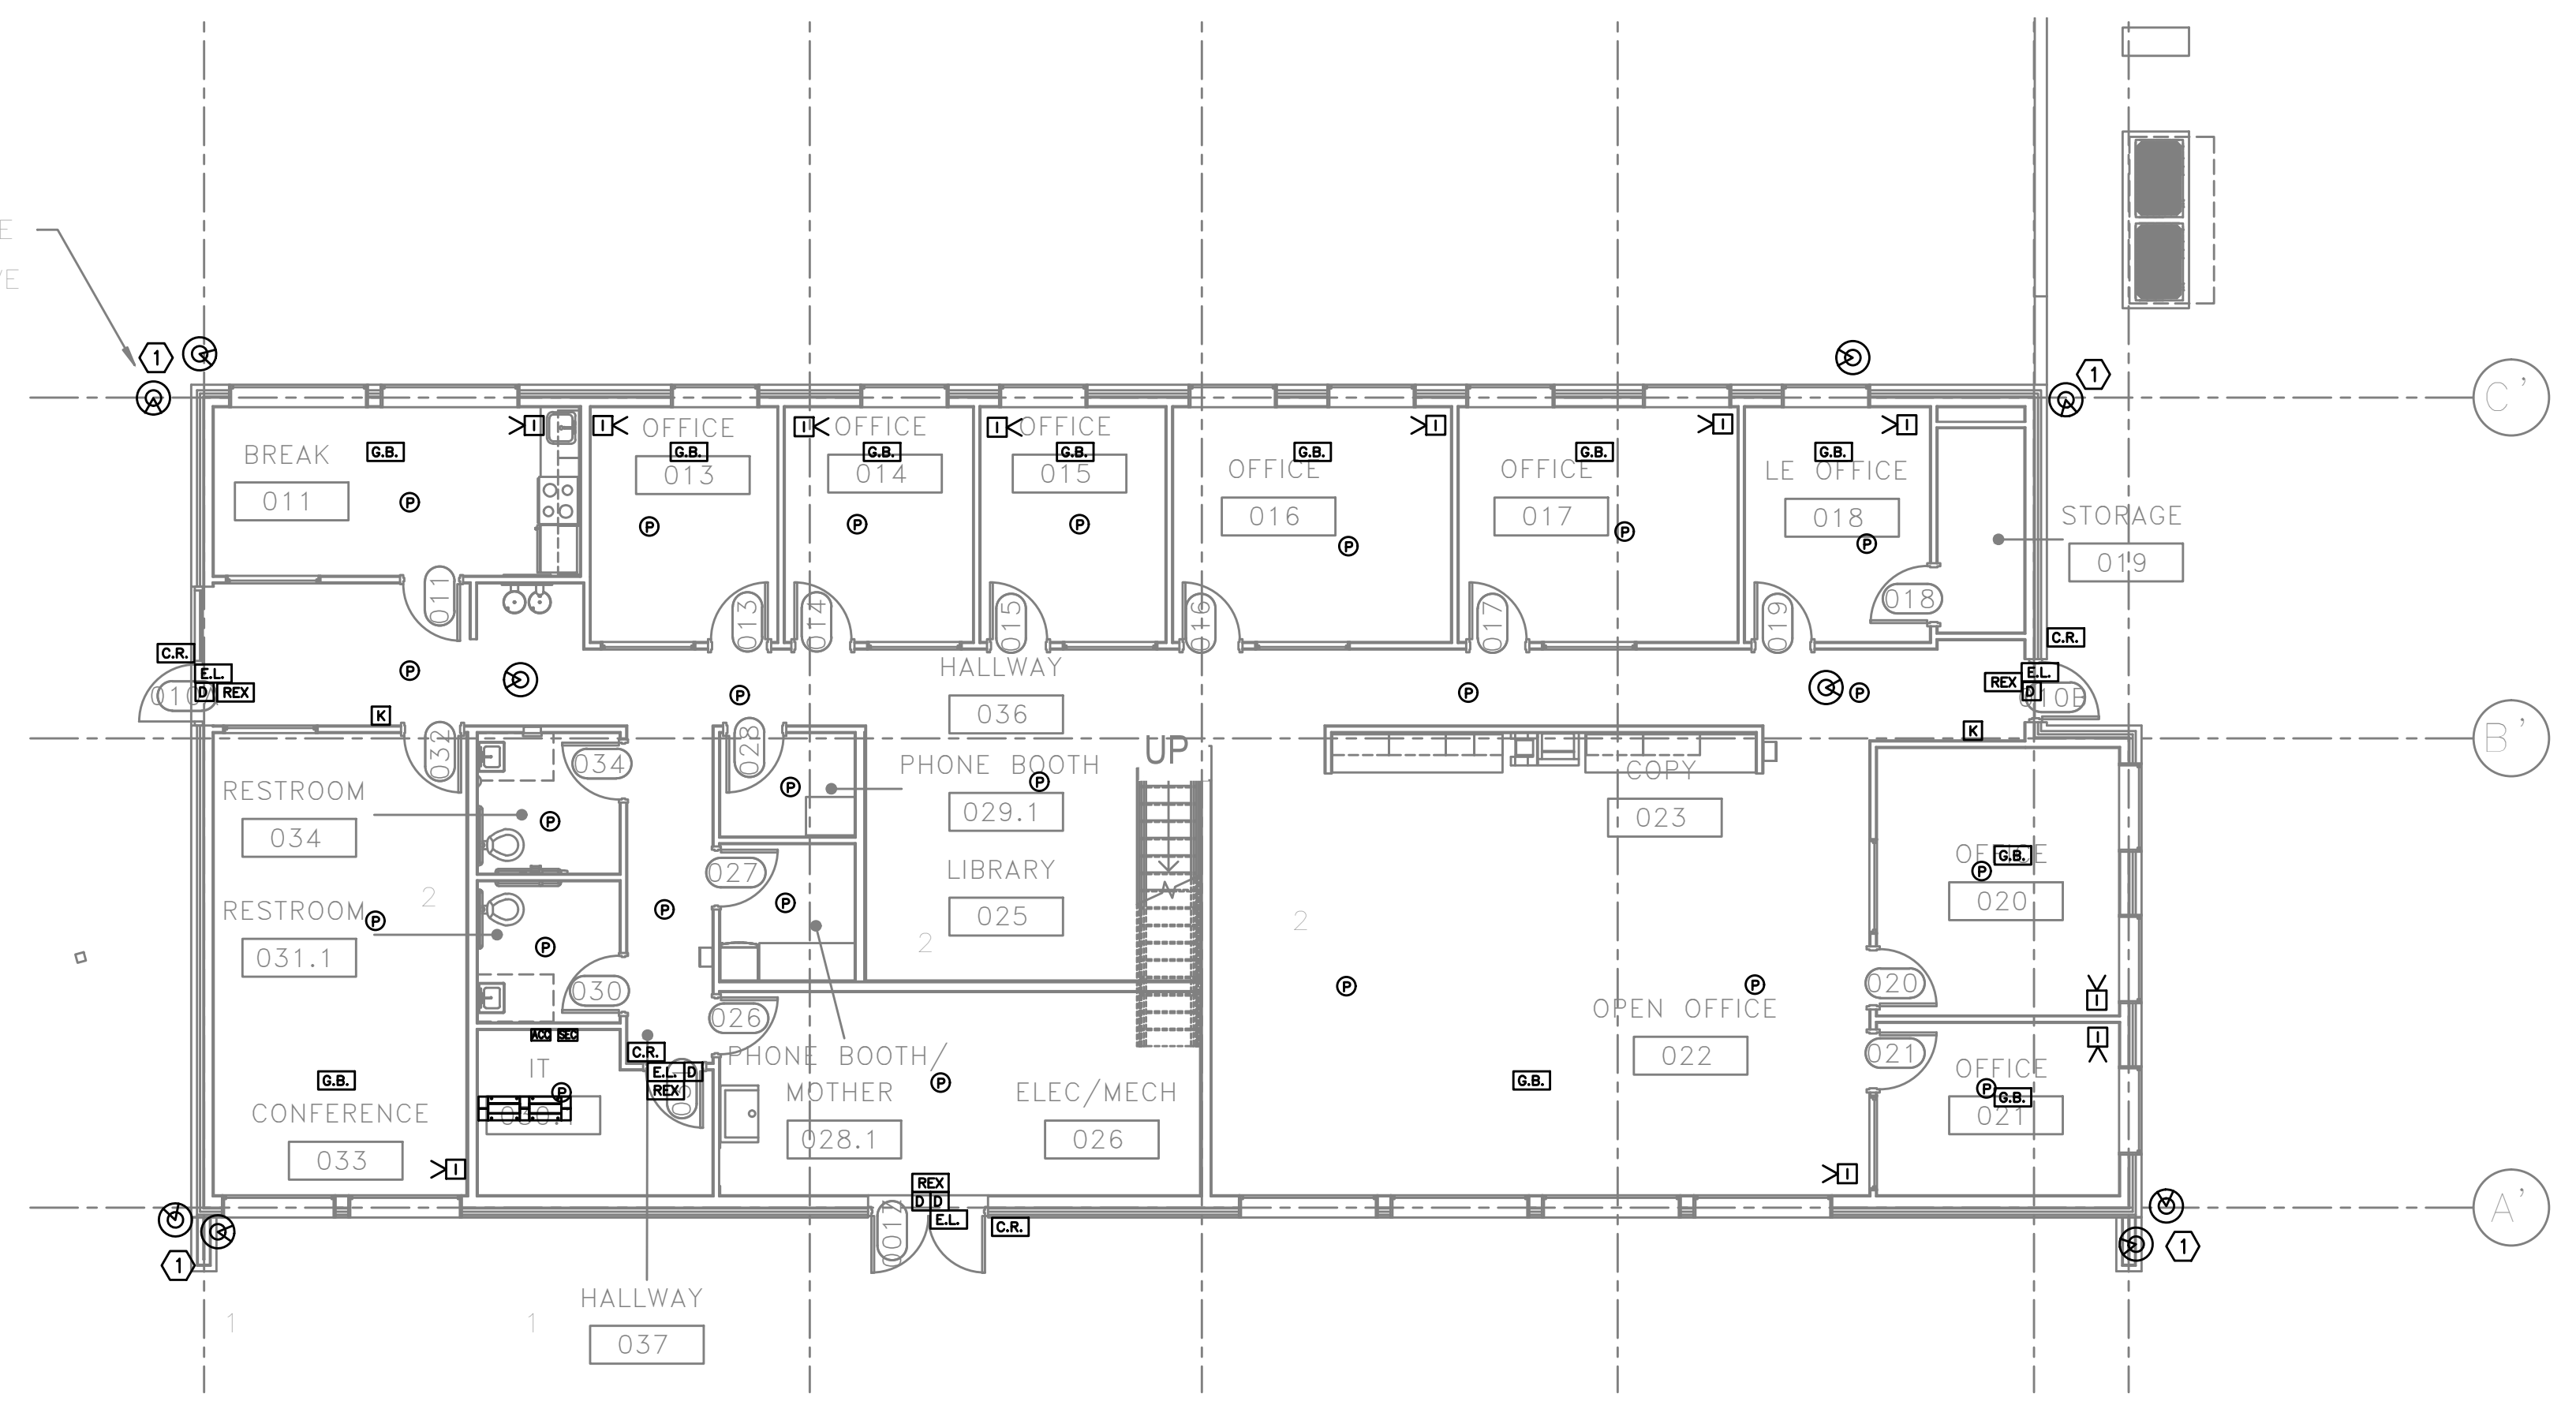


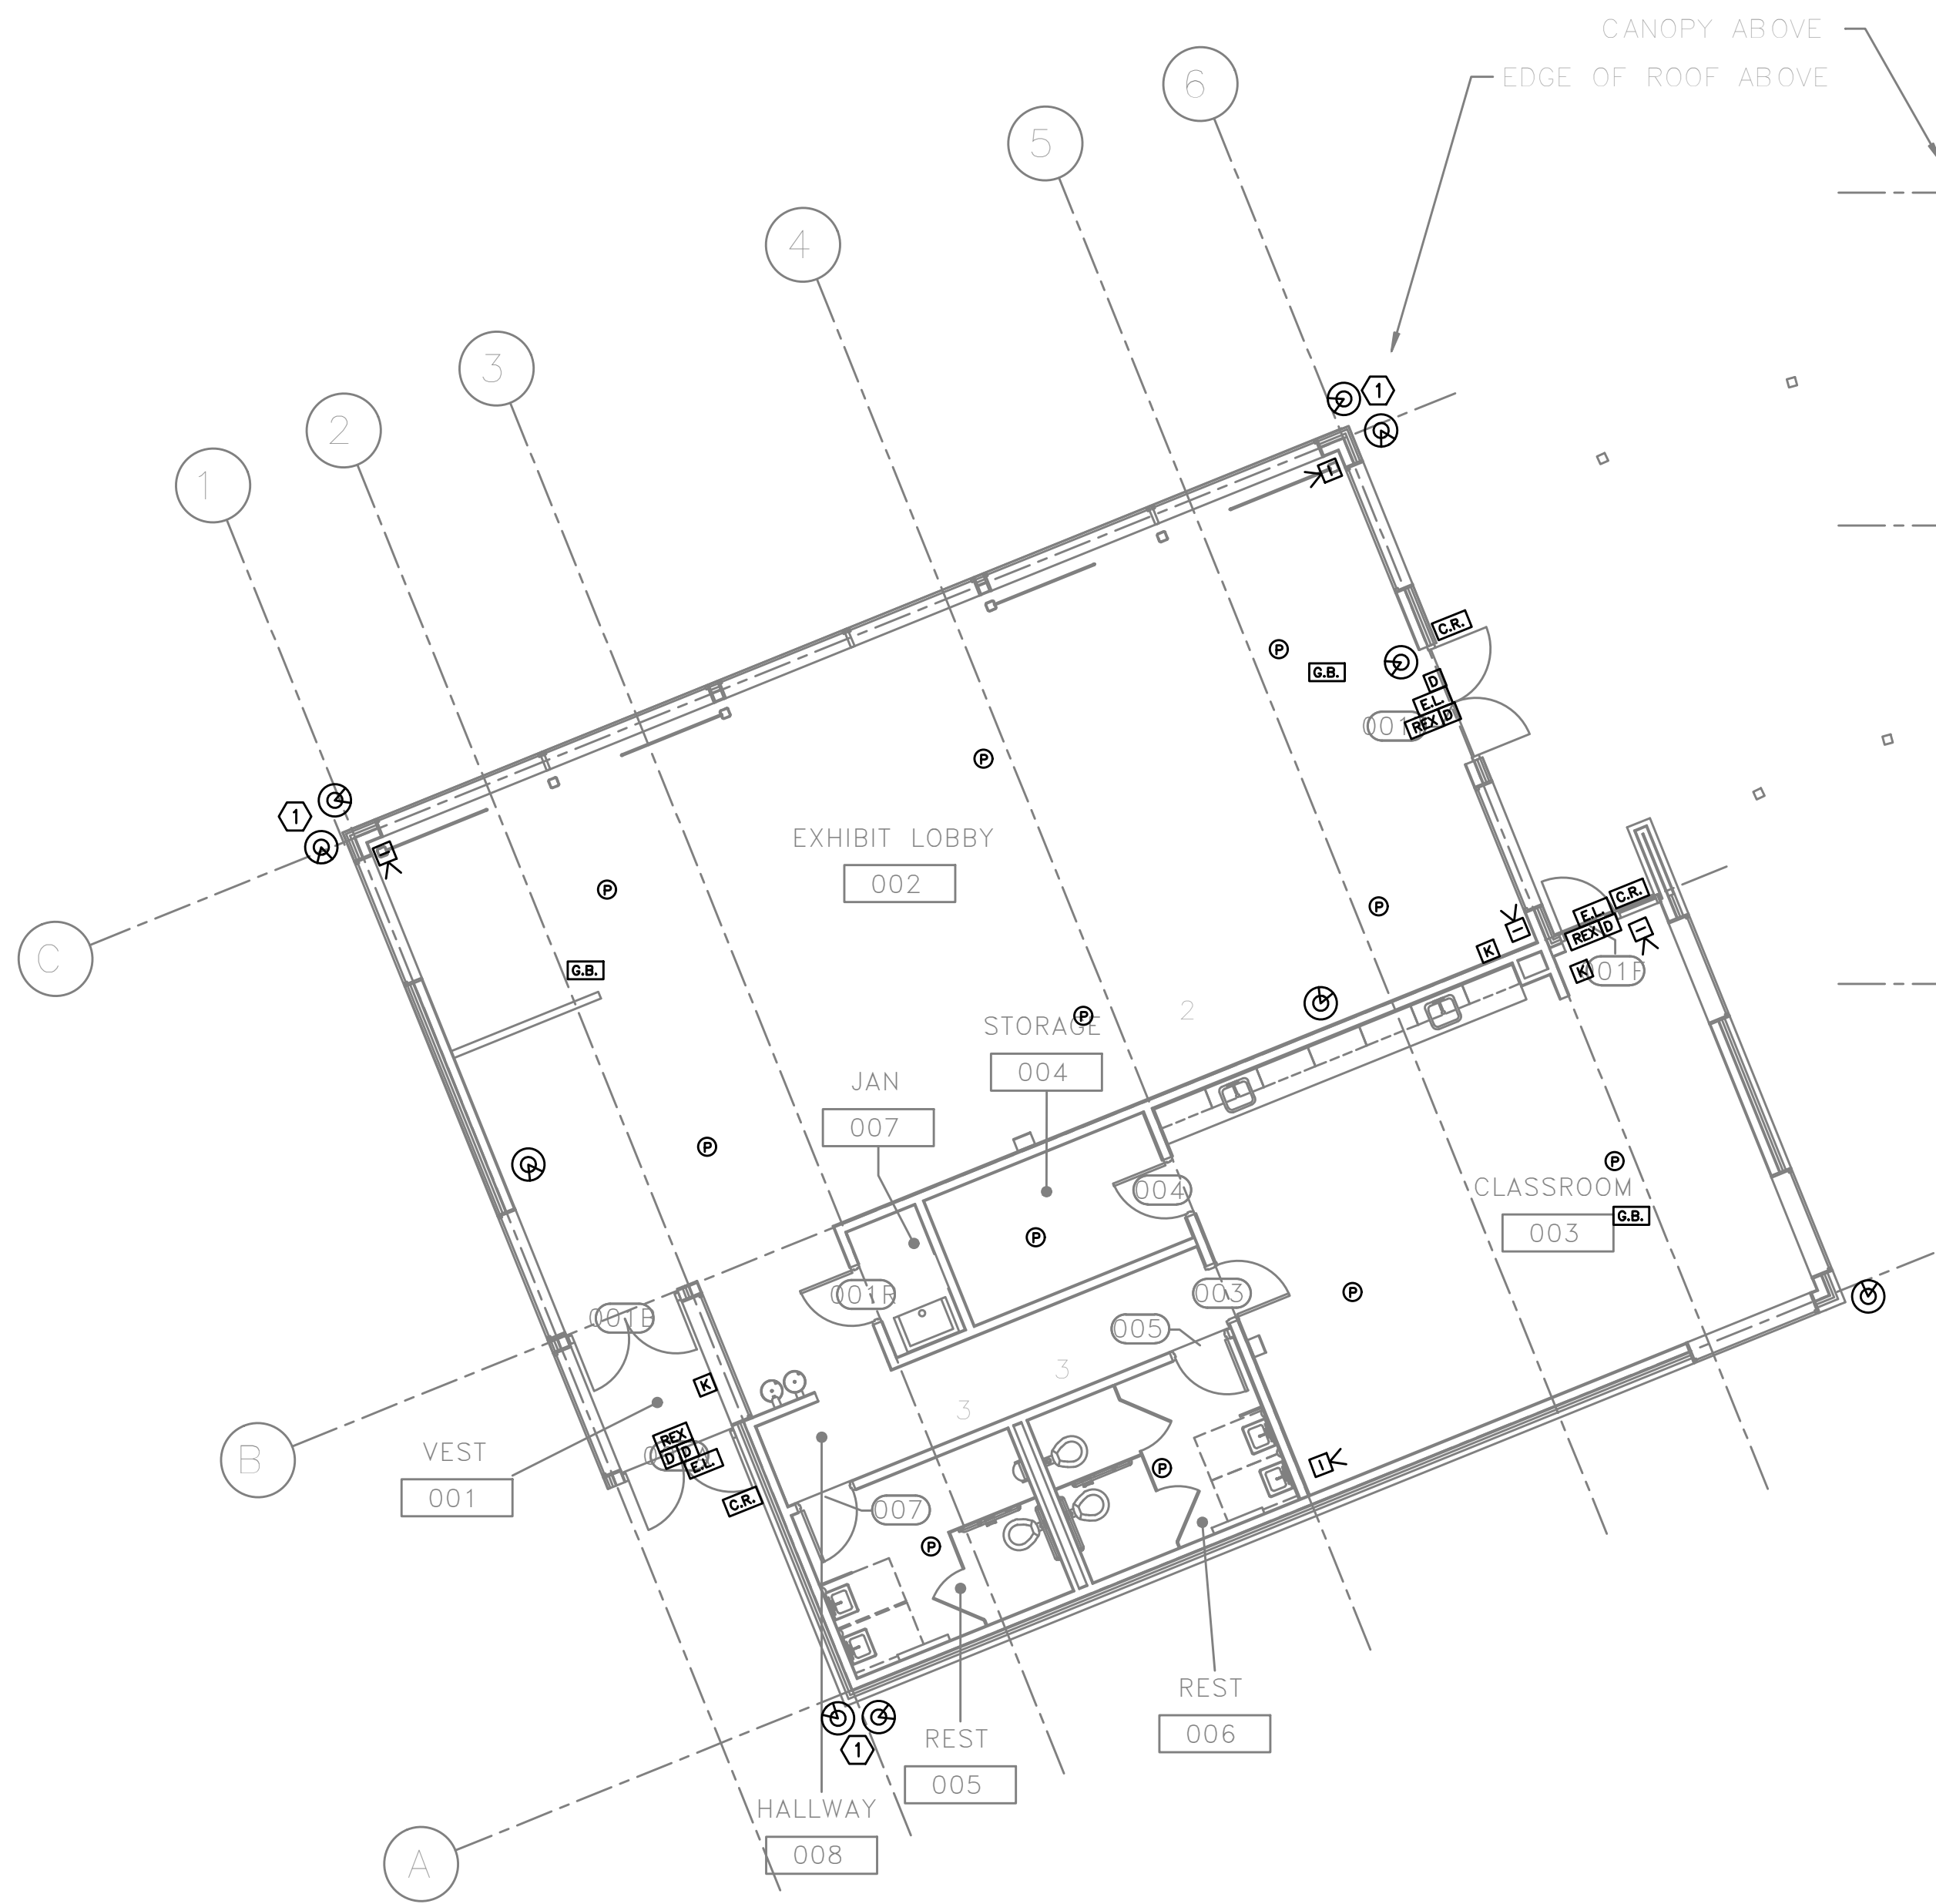

1 FIRST FLOOR PLAN – ACCESS CONTROL AND SECURITY
T302 SCALE: 1/8" = 1'-0"

NOTES:

1. DUAL LENS CAMERA IN A SINGLE ENCLOSURE.

GENERAL NOTES:

- A. TECHNOLOGY DRAWINGS ARE DIAGRAMMATICAL AND MAY NOT ACCURATELY REFLECT ACTUAL CONSTRUCTION CONDITIONS. THE TECHNOLOGY CONTRACTOR SHALL BE RESPONSIBLE FOR COORDINATING THE INSTALLATION OF ALL TECHNOLOGY EQUIPMENT, WITH ALL TRADES PRIOR TO AND DURING CONSTRUCTION.
- B. THE TECHNOLOGY CONTRACTOR SHALL REFER TO THE ARCHITECTURAL DRAWINGS FOR ALL MOUNTING HEIGHTS AND FINISHES OF DEVICES AND FIXTURES.
- C. COORDINATE WITH MECHANICAL PLANS FOR LOCATIONS OF SMOKE, FIRE/SMOKE DAMPERS, AND ROOF TOP UNITS REQUIRING CONNECTION TO FIRE ALARM SYSTEM.
- D. FOR VOICE/DATA OUTLETS PROVIDE A SINGLE GANG MUD-RING WITH A 1" CONDUIT FROM THE TOP OF THE MUD-RING TO ACCESSIBLE CEILING SPACE. TERMINATE CONDUIT WITH END CONNECTORS AND THREAD ON PLASTIC BUSHING FOR CABLE PROTECTION. OUTLET SHALL BE AT THE SAME HEIGHT AS ADJACENT POWER OUTLET AND LESS THAN 18" SEPARATION. COORDINATE WITH ELECTRICAL.
- E. COORDINATE ALL DEVICE LOCATIONS WITH LATEST ARCHITECTURAL INTERIOR ELEVATIONS TO VERIFY DEVICES WILL NOT BE OBSTRUCTED.

VERIFY SCALE
THIS BAR IS
ONE INCH ON
ORIGINAL DRAWING
0" 1"
ADJUST SCALES
ACCORDINGLY, IF
NOT ONE INCH
ON THIS SHEET

REV.	DATE	DESCRIPTION	BY	
TULELAKE NWR				
NEW HEADQUARTERS FACILITY				
FIRST FLOOR PLAN – ACCESS CONTROL AND SECURITY				
DESIGNED GMA	DRAWN GMA	CHECKED RLC	DATE 02/11/2022	ASSET NO. 10072616

65% DESIGN DEVELOPMENT