


ASIAN HEALTH & SERVICE CENTER

SE 91ST AVE & SE FOSTER RD,
PORTLAND OR 97266

JOB NO. 15043.00

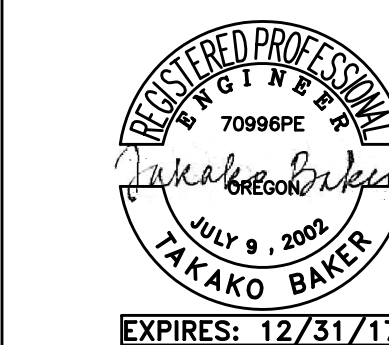

M Consulting Engineers
2007 S.E. Ash St.
Portland, OR 97214
PHN: (503) 234-0548
FAX: (503) 234-0677
INC. WWW.MPIA-ENG.COM
CONTACT: TAKAKO BAKER

PERMIT SET

Issue:	date:
100% SD	10.15.15
50% DD	12.09.15
100% DD	02.05.16
50% CD	03.30.16
75% CD	04.27.16
PERMIT SET	07.22.16

revision:	date:
1 PERMIT REV (ADD 1)	01.24.17
2 PERMIT REV 2	02.09.17
3 PERMIT REV 3	03.08.17
4 CONST SET REV 4	03.31.17

title:


FIRST FLOOR REFRIGERANT PIPING PLAN

sheet:

M3.01

SHEET NOTES:

- REFRIGERANT PIPING SHOWN HERE ARE FOR REFERENCE ONLY. VRV MANUFACTURER TO PROVIDE REFRIGERANT PIPING DIAGRAM SHOWING EXACT ROUTING AND SIZING TO EACH INDOOR UNIT AND TO BRANCH CONTROLLER WITH THEIR SHOP DRAWING.
- CONTRACTOR SHALL COORDINATE LOCATION OF FAN COILS, ETC. WITH LIGHT FIXTURES AND OTHER TRADES TO ENSURE PROPER CLEARANCE FOR MAINTENANCE.
- SEE P3.01, 3.02 AND 3.03 FOR CONDENSATE PIPING PLAN.
- (R) DENOTES A REFRIGERANT SENSOR WITH AUDIO AND VISUAL ALARM. BACHARACH IAM-100, OR APPROVED EQUAL. PROVIDE A SIGNAGE IN THE ROOM WHICH READS "EVACUATE ROOM UPON SOUNDING OF ALARM".

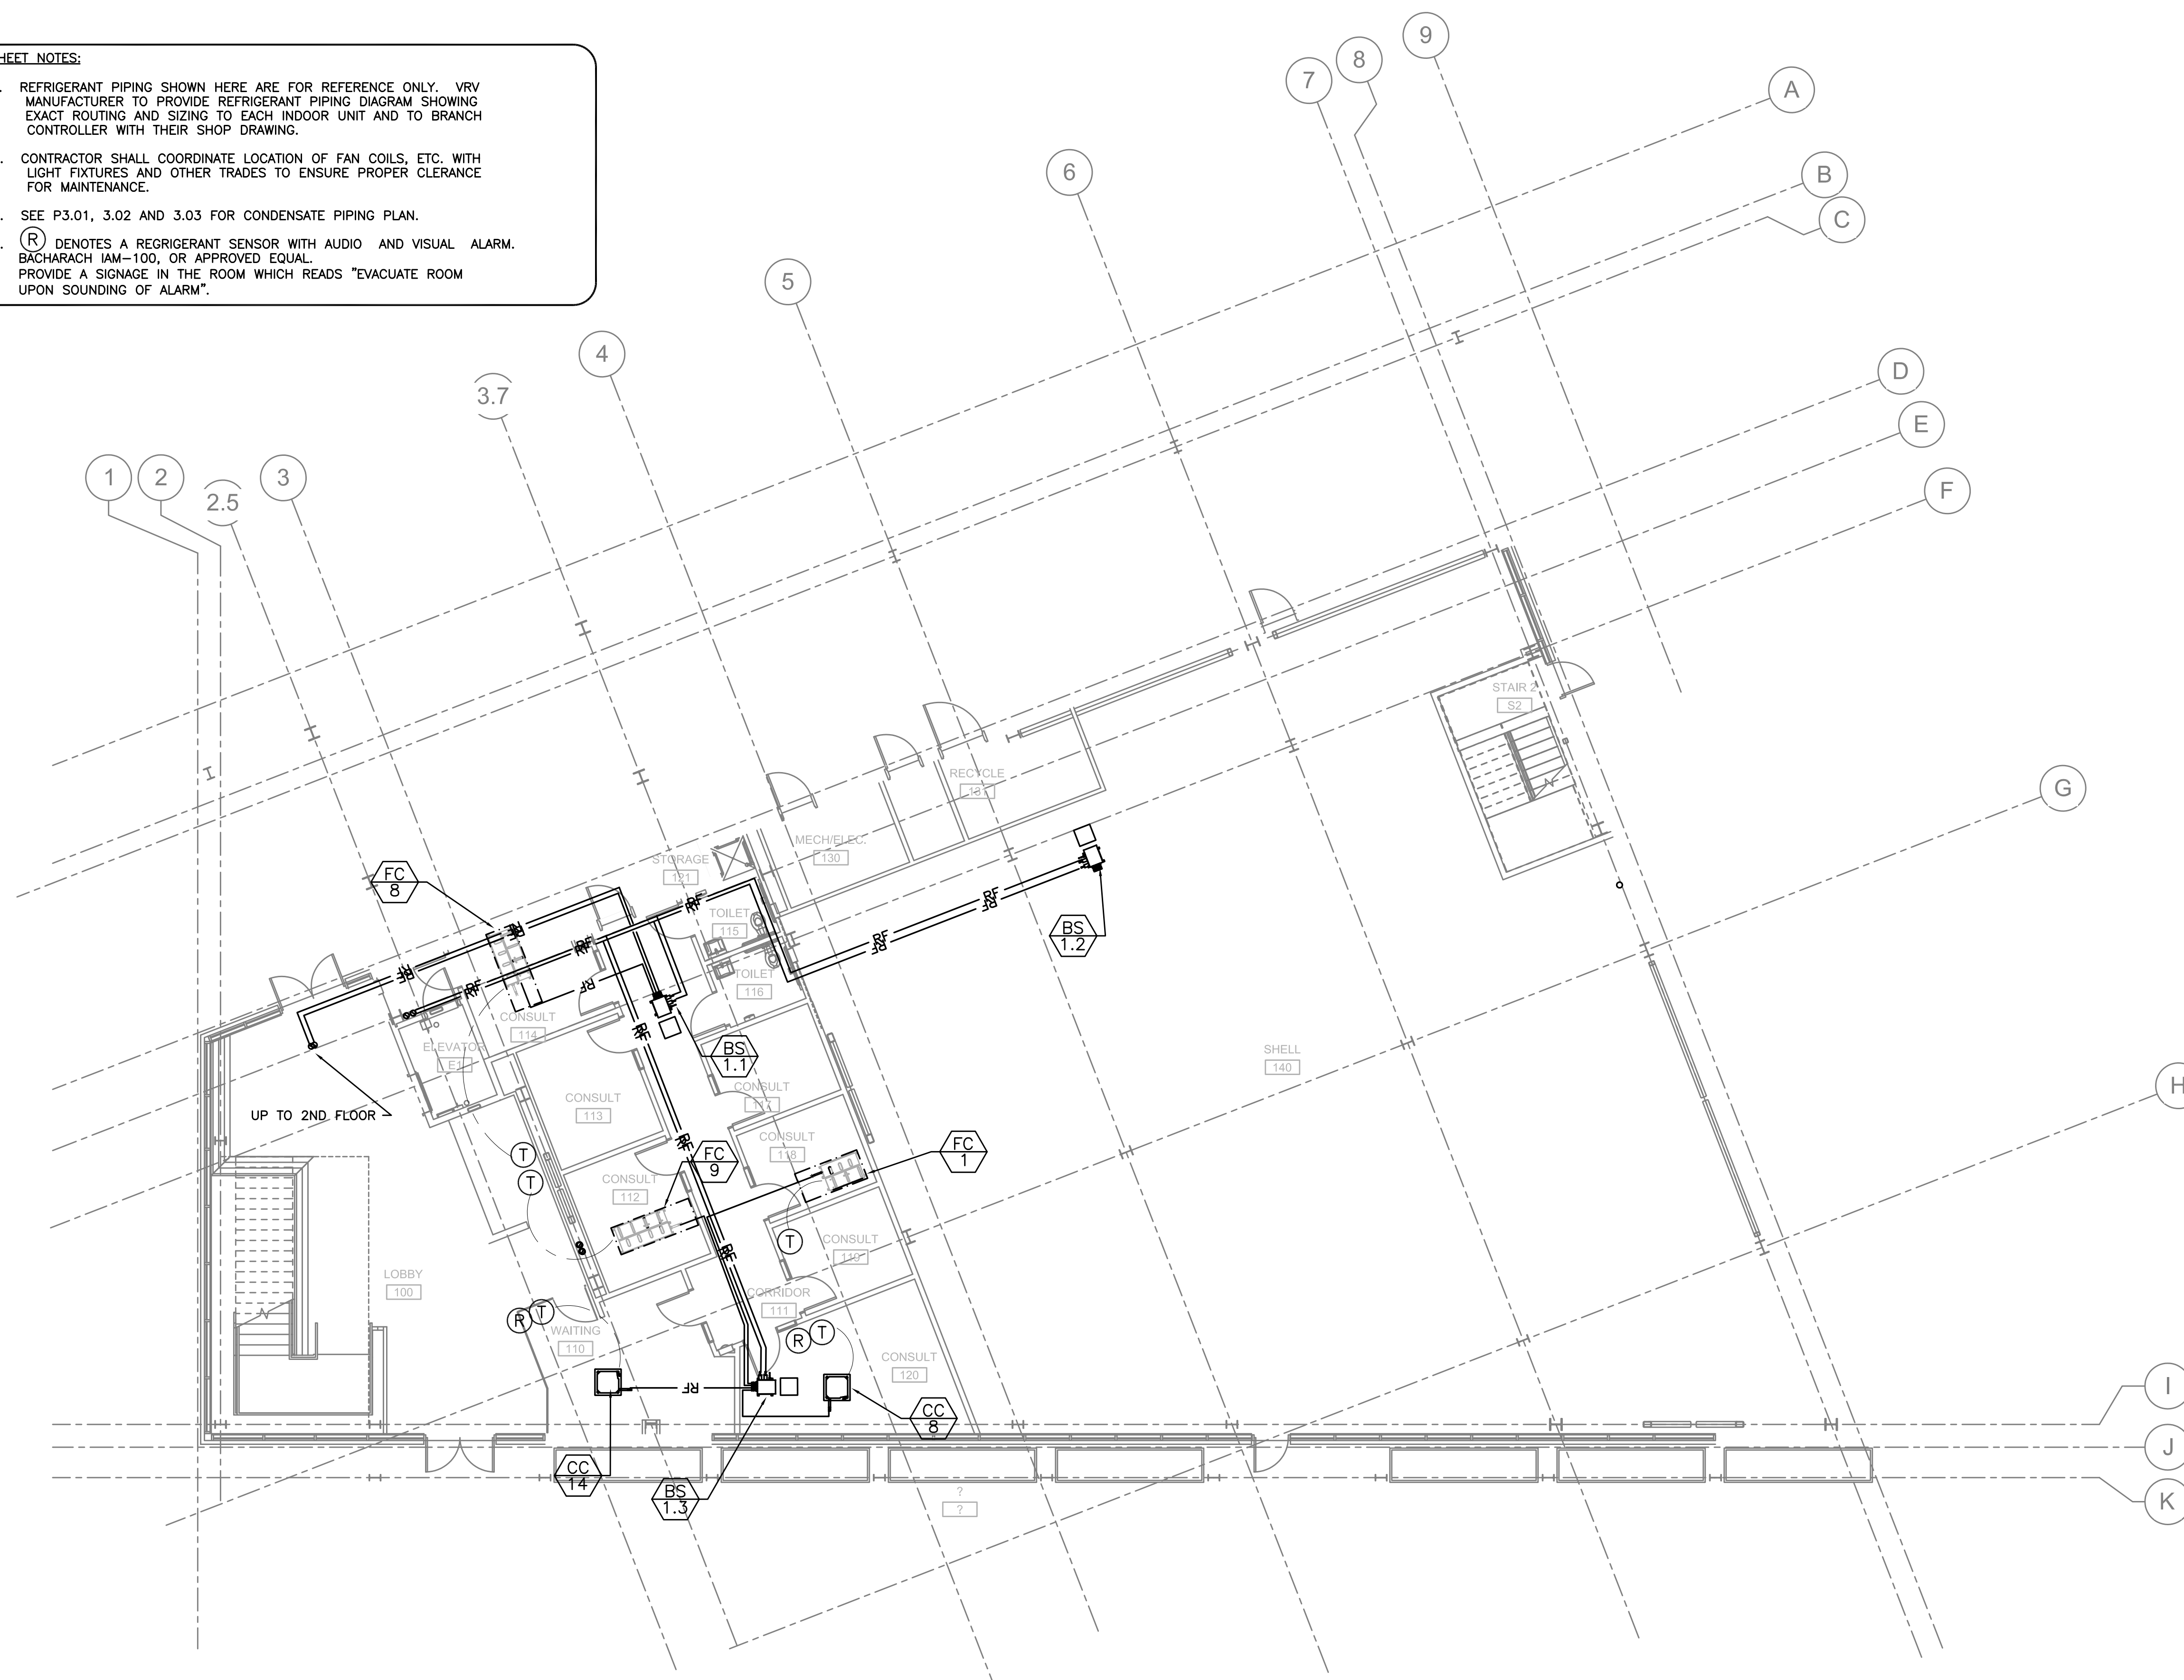

1 FIRST FLOOR REFRIGERANT PIPING PLAN
SCALE: 1/8" = 1'-0"