


**YAKIMA VALLEY
CLINIC TENANT
IMPROVEMENT**

9035 SE FOSTER RD
PORTLAND, OR 97266

JOB NO. 17001

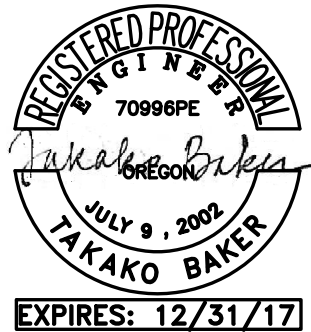

PERMIT SET

05.30.2017

issue: date:

revision: date:

title:

**MECHANICAL
FLOOR
PLAN**

sheet:


M2.0

© 2016 HOLST ARCHITECTURE pc

M2.0 Consulting Engineers
2007 S.E. Ash St.
Portland, OR 97214
PHN: (503) 234-0548
FAX: (503) 234-0677
INC. WWW.M2.0-ENG.COM
CONTACT: TAKAKO BAKER

KEYED NOTES:

1. CONNECT 8" SA TO FC-A1 RA PLENUM. BALANCE TO 200 CFM.
2. CONNECT 6" SA TO FC-A2 RA PLENUM. BALANCE TO 80 CFM.
3. CONNECT 10X8 SA TO FC-A3 RA PLENUM. BALANCE TO 210 CFM.
4. CONNECT 8" SA TO FC-A4. BALANCE TO 175 CFM.

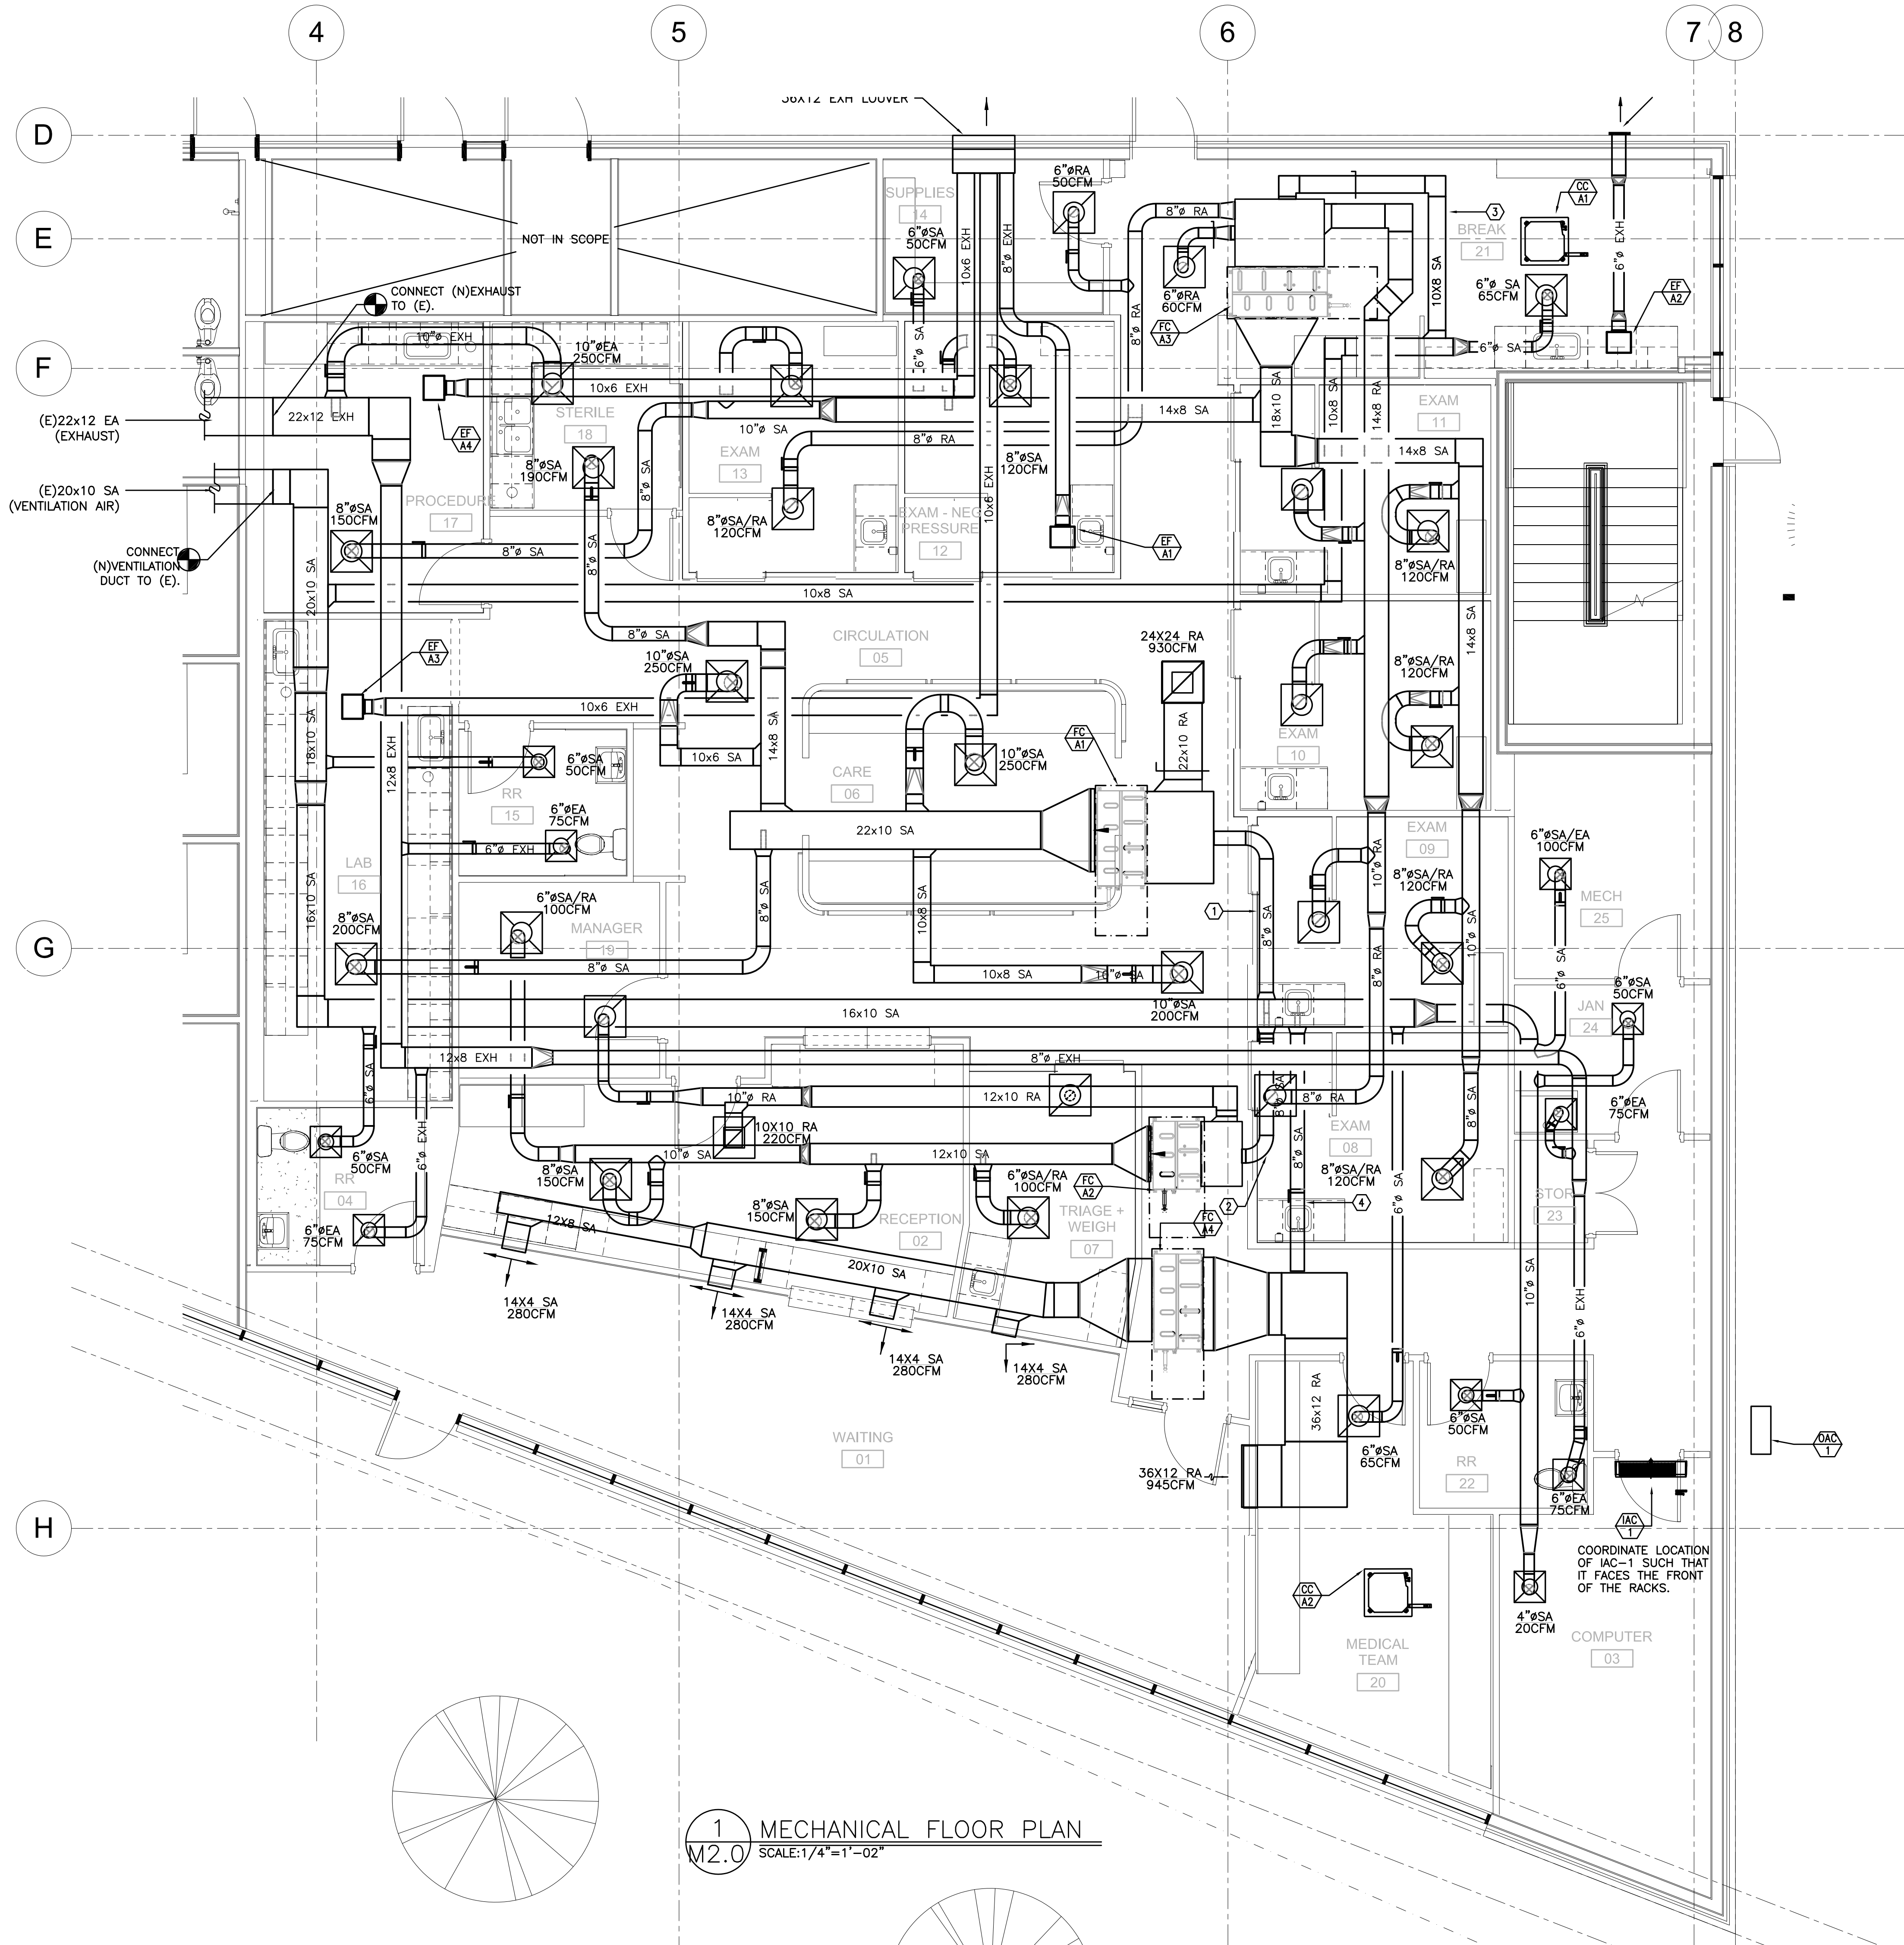

1 MECHANICAL FLOOR PLAN
SCALE: 1/4" = 1' - 02"