


YAKIMA VALLEY
CLINIC TENANT
IMPROVEMENT

9035 SE FOSTER RD
PORTLAND, OR 97266

JOB NO. 17001

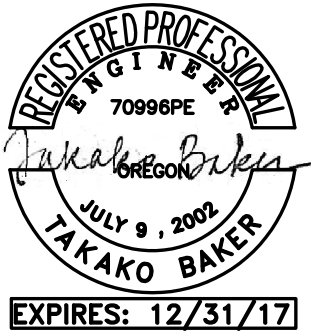

SHEET NOTES:

1. REFRIGERANT PIPING SHOWN HERE ARE FOR REFERENCE ONLY. VRV MANUFACTURER TO PROVIDE REFRIGERANT PIPING DIAGRAM SHOWING EXACT ROUTING AND SIZING TO EACH INDOOR UNIT AND TO BRANCH CONTROLLER WITH THEIR SHOP DRAWING.
2. CONTRACTOR SHALL COORDINATE LOCATION OF FAN COILS, ETC. WITH LIGHT FIXTURES AND OTHER TRADES TO ENSURE PROPER CLERANCE FOR MAINTENANCE.
3. SEE P3.01, 3.02 AND 3.03 FOR CONDENSATE PIPING PLAN.
4. (R) DENOTES A REGRIGERANT SENSOR WITH AUDIO AND VISUAL ALARM. BACHARACH IAM-100, OR APPROVED EQUAL. PROVIDE A SIGNAGE IN THE ROOM WHICH READS "EVACUATE ROOM UPON SOUNDING OF ALARM".

PERMIT SET

05.30.2017

issue: date:

revision: date:

title:


REFRIGERANT
PIPING &
CONDENSATE
DRAIN PLAN

sheet:

M3.0

© 2016 HOLST ARCHITECTURE pc

M
F
I
A
INC.
Consulting Engineers
2007 S.E. Ash St.
Portland, OR 97214
PHN: (503) 234-0548
FAX: (503) 234-0677
CONTACT: TAKAKO BAKER

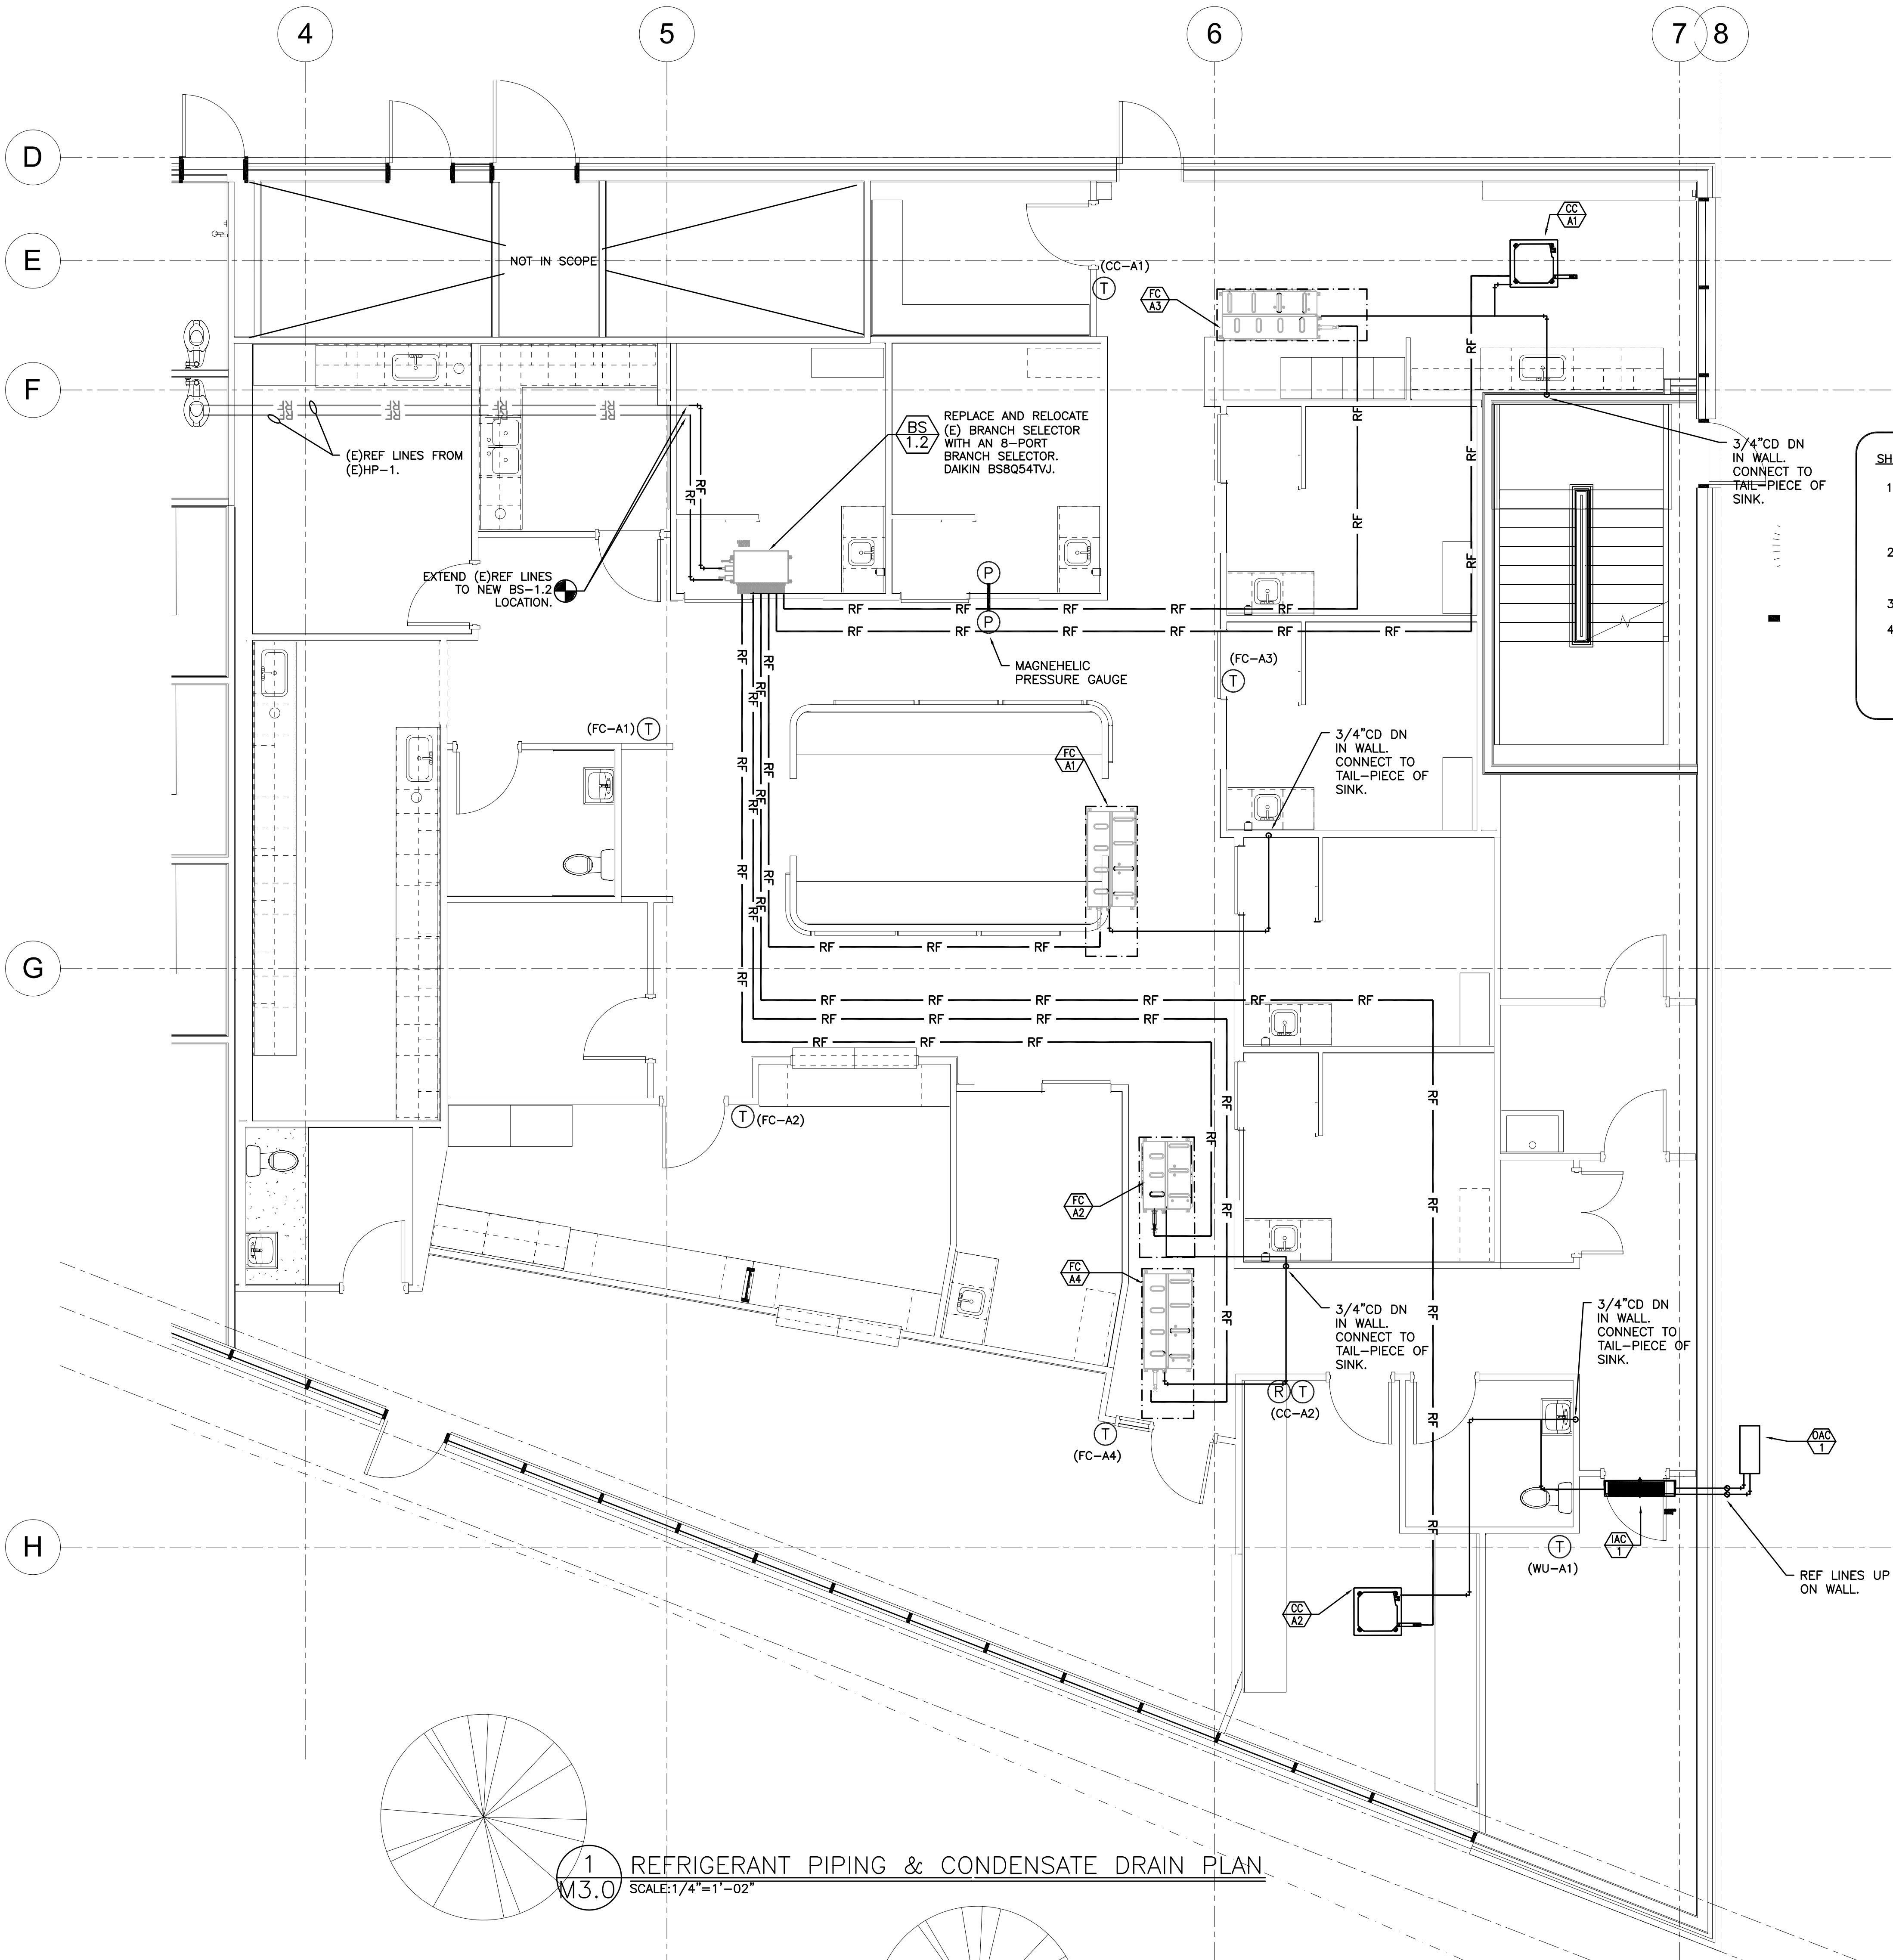

1 REFRIGERANT PIPING & CONDENSATE DRAIN PLAN
M3.0 SCALE: 1/4"=1'-02"