


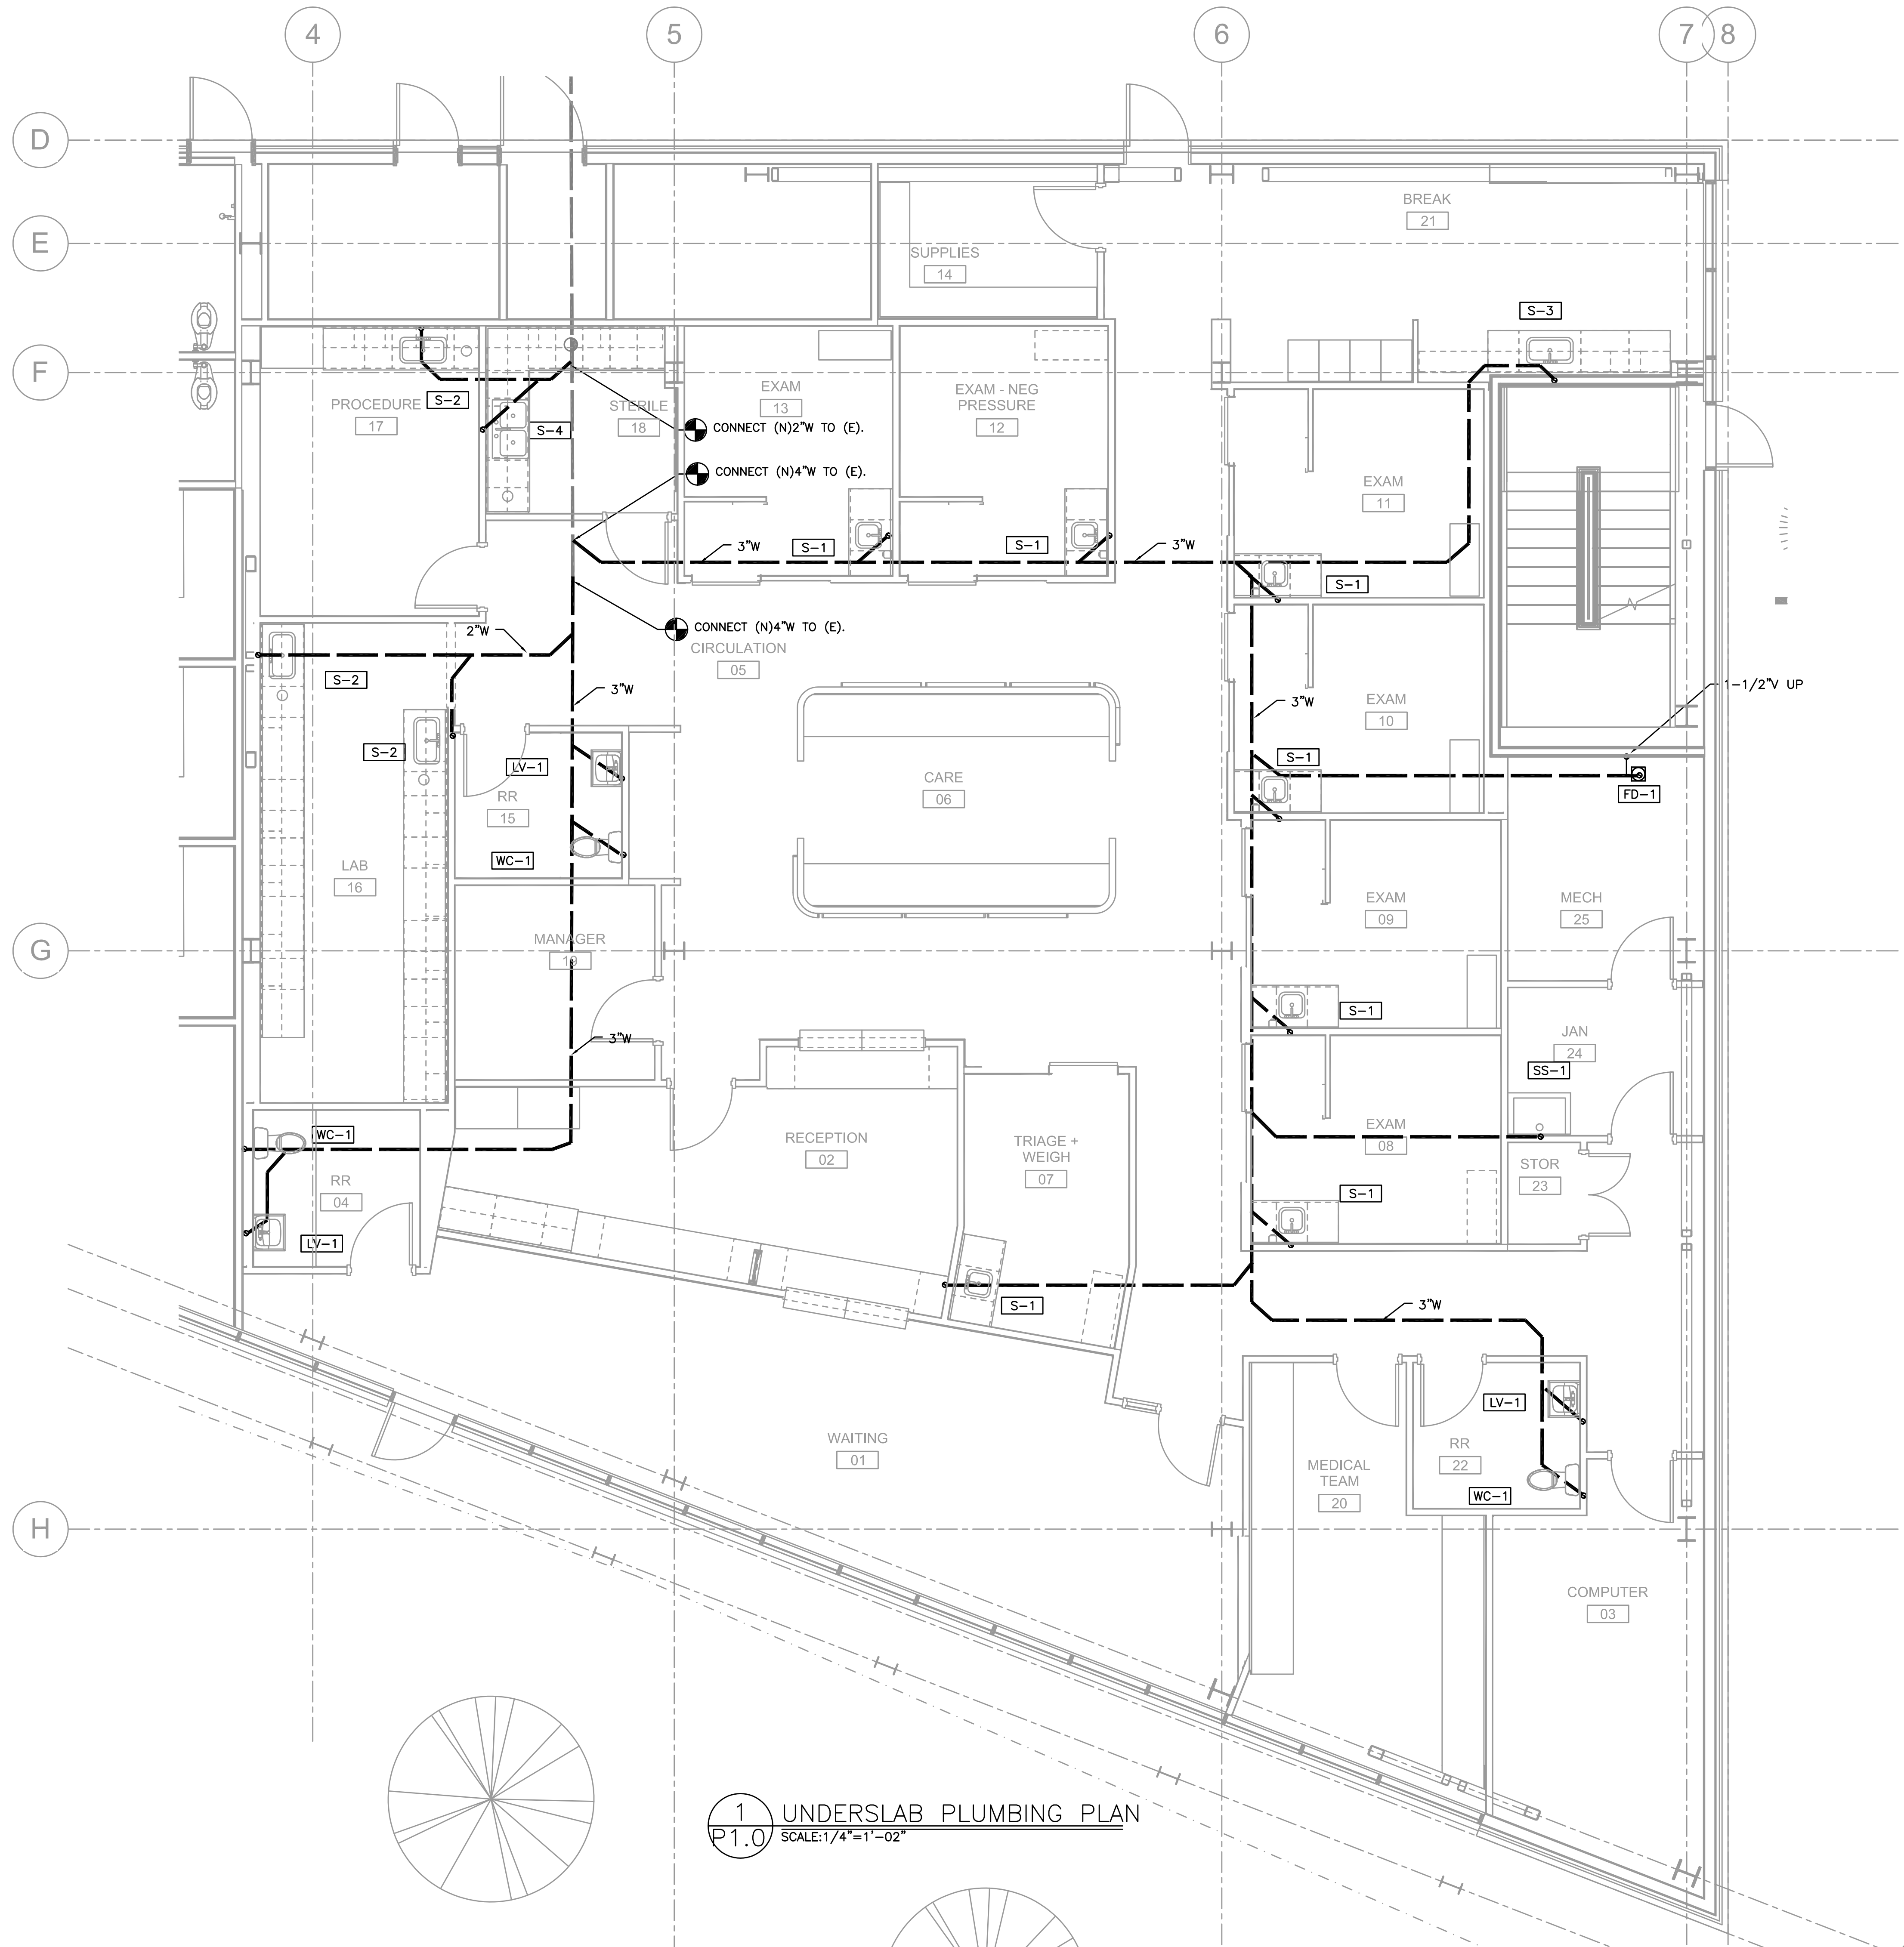

1 UNDERSLAB PLUMBING PLAN
P1.0 SCALE: 1/4" = 1'-02"

HOLST


110 SE 8TH AVE.
PORTLAND, OR
97214

HOLSTARC.COM

YAKIMA VALLEY
CLINIC TENANT
IMPROVEMENT

9035 SE FOSTER RD
PORTLAND, OR 97266

JOB NO. 17001

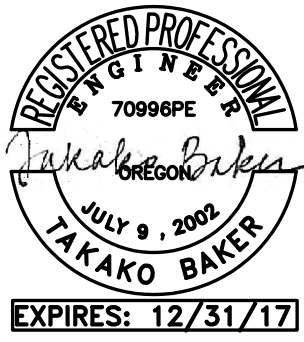

PERMIT SET

05.30.2017

issue: date:

revision: date:

title:

UNDERSLAB
PLUMBING
PLAN

sheet:

P1.0

© 2016 HOLST ARCHITECTURE pc

M
E
I
A
INC. Consulting Engineers
2007 S.E. Ash St.
Portland, OR 97214
PHN: (503) 234-0548
FAX: (503) 234-0677
WWW.MEIA-ENG.COM
CONTACT: TAKAKO BAKER