


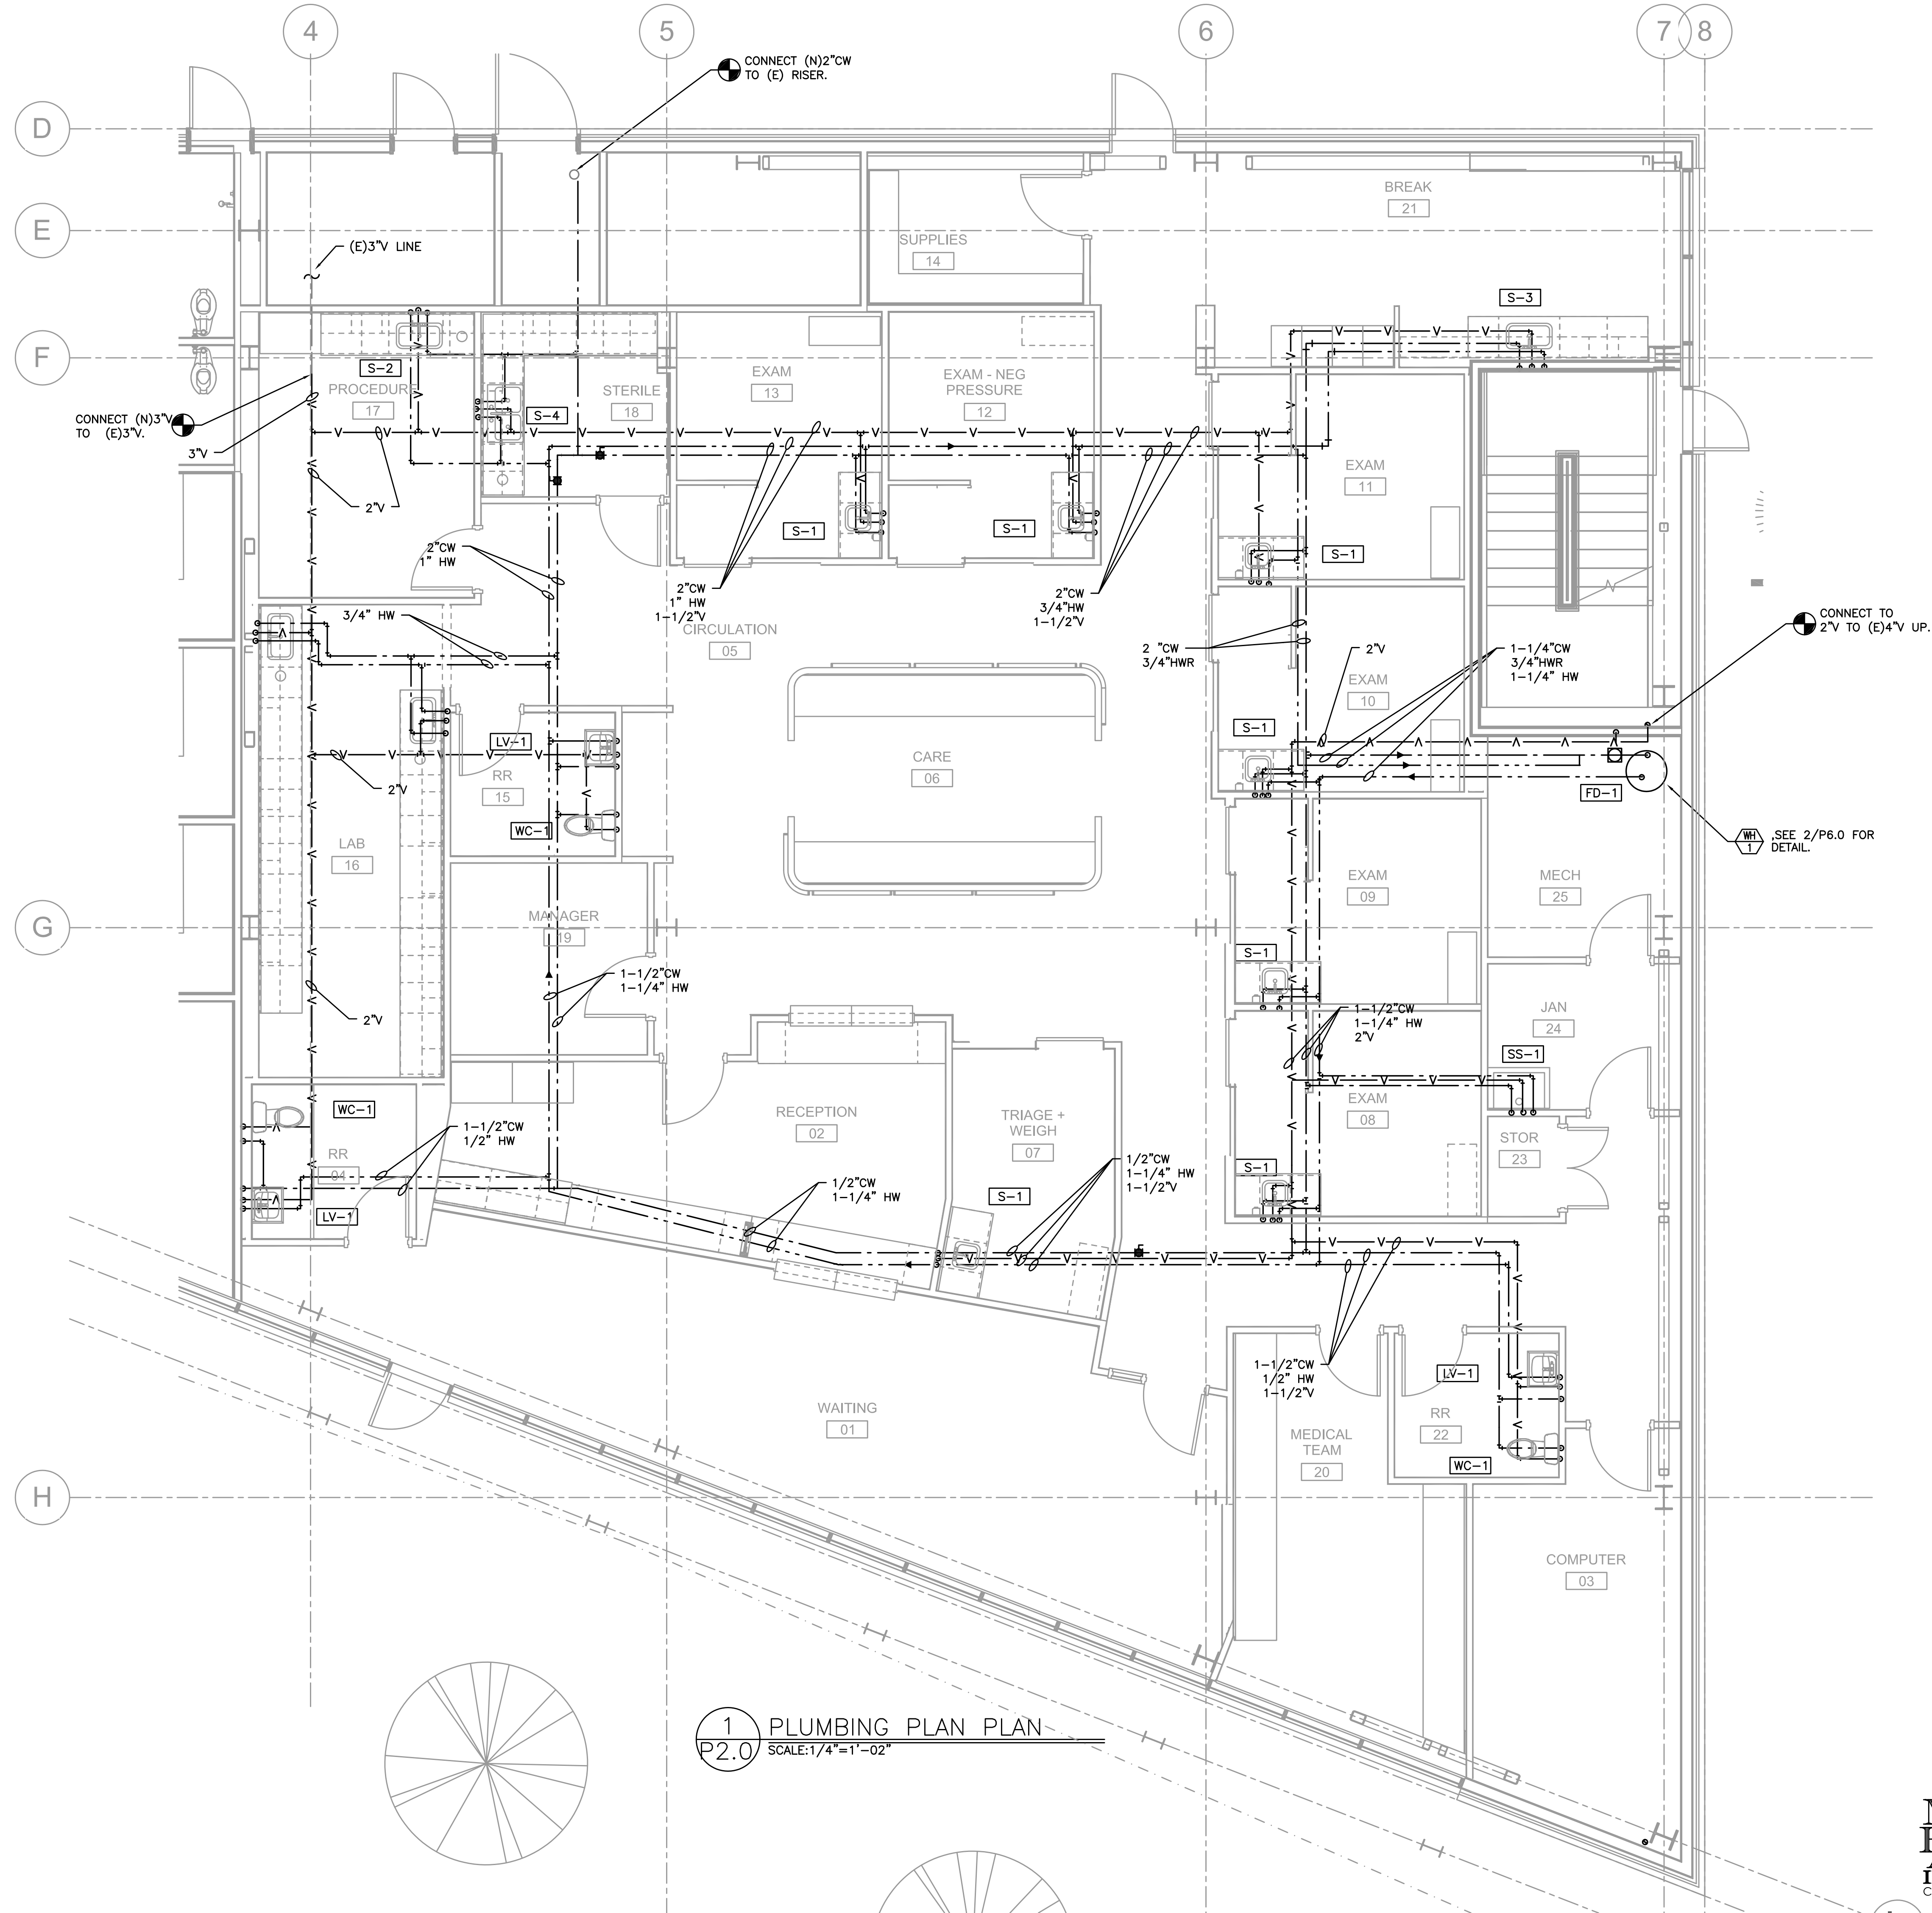

1 PLUMBING PLAN PLAN
P2.0 SCALE: 1/4" = 1'-02"

HOLST


110 SE 8TH AVE.
PORTLAND, OR
97214

HOLSTARC.COM

YAKIMA VALLEY
CLINIC TENANT
IMPROVEMENT

9035 SE FOSTER RD
PORTLAND, OR 97266

JOB NO. 17001

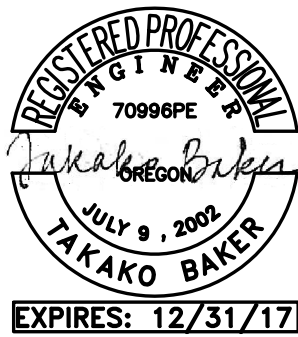

PERMIT SET

05.30.2017

issue: date:

revision: date:

title:

PLUMBING
PLAN

sheet:

P2.0

© 2016 HOLST ARCHITECTURE pc

M
F
A
INC
Consulting Engineers
2007 S.E. Ash St.
Portland, OR 97214
PHN: (503) 234-0548
FAX: (503) 234-0877
WWW.MFIA-ENG.COM
CONTACT: TAKAKO BAKER